 













COPYRIGHT
This drawing is copyright and may not be altered, reproduced or used other than for the Contract Works for which it is issued without written permission.
© : Johns Slater and Haward Ltd.

Notes:

- This drawing should be read in conjunction with JSH electrical services specification ref: EB/CR/5557/E.
- The School has advised that there is asbestos products in the working areas. The Contractor shall communicate with the Main Contractor and the School prior to any works being undertaken.

Legend:

	Surface mounted linear fluorescent
	Recessed downlighter
	Internally illuminated emergency bulk head
	Surface mounted round luminaire
	Lighting switch one way (n=no of gangs)
	Lighting switch two way (n=no of gangs)
	Pull cord switch
	Typical circuit line
	Typical switch line
	Typical switch link
	Denotes emergency

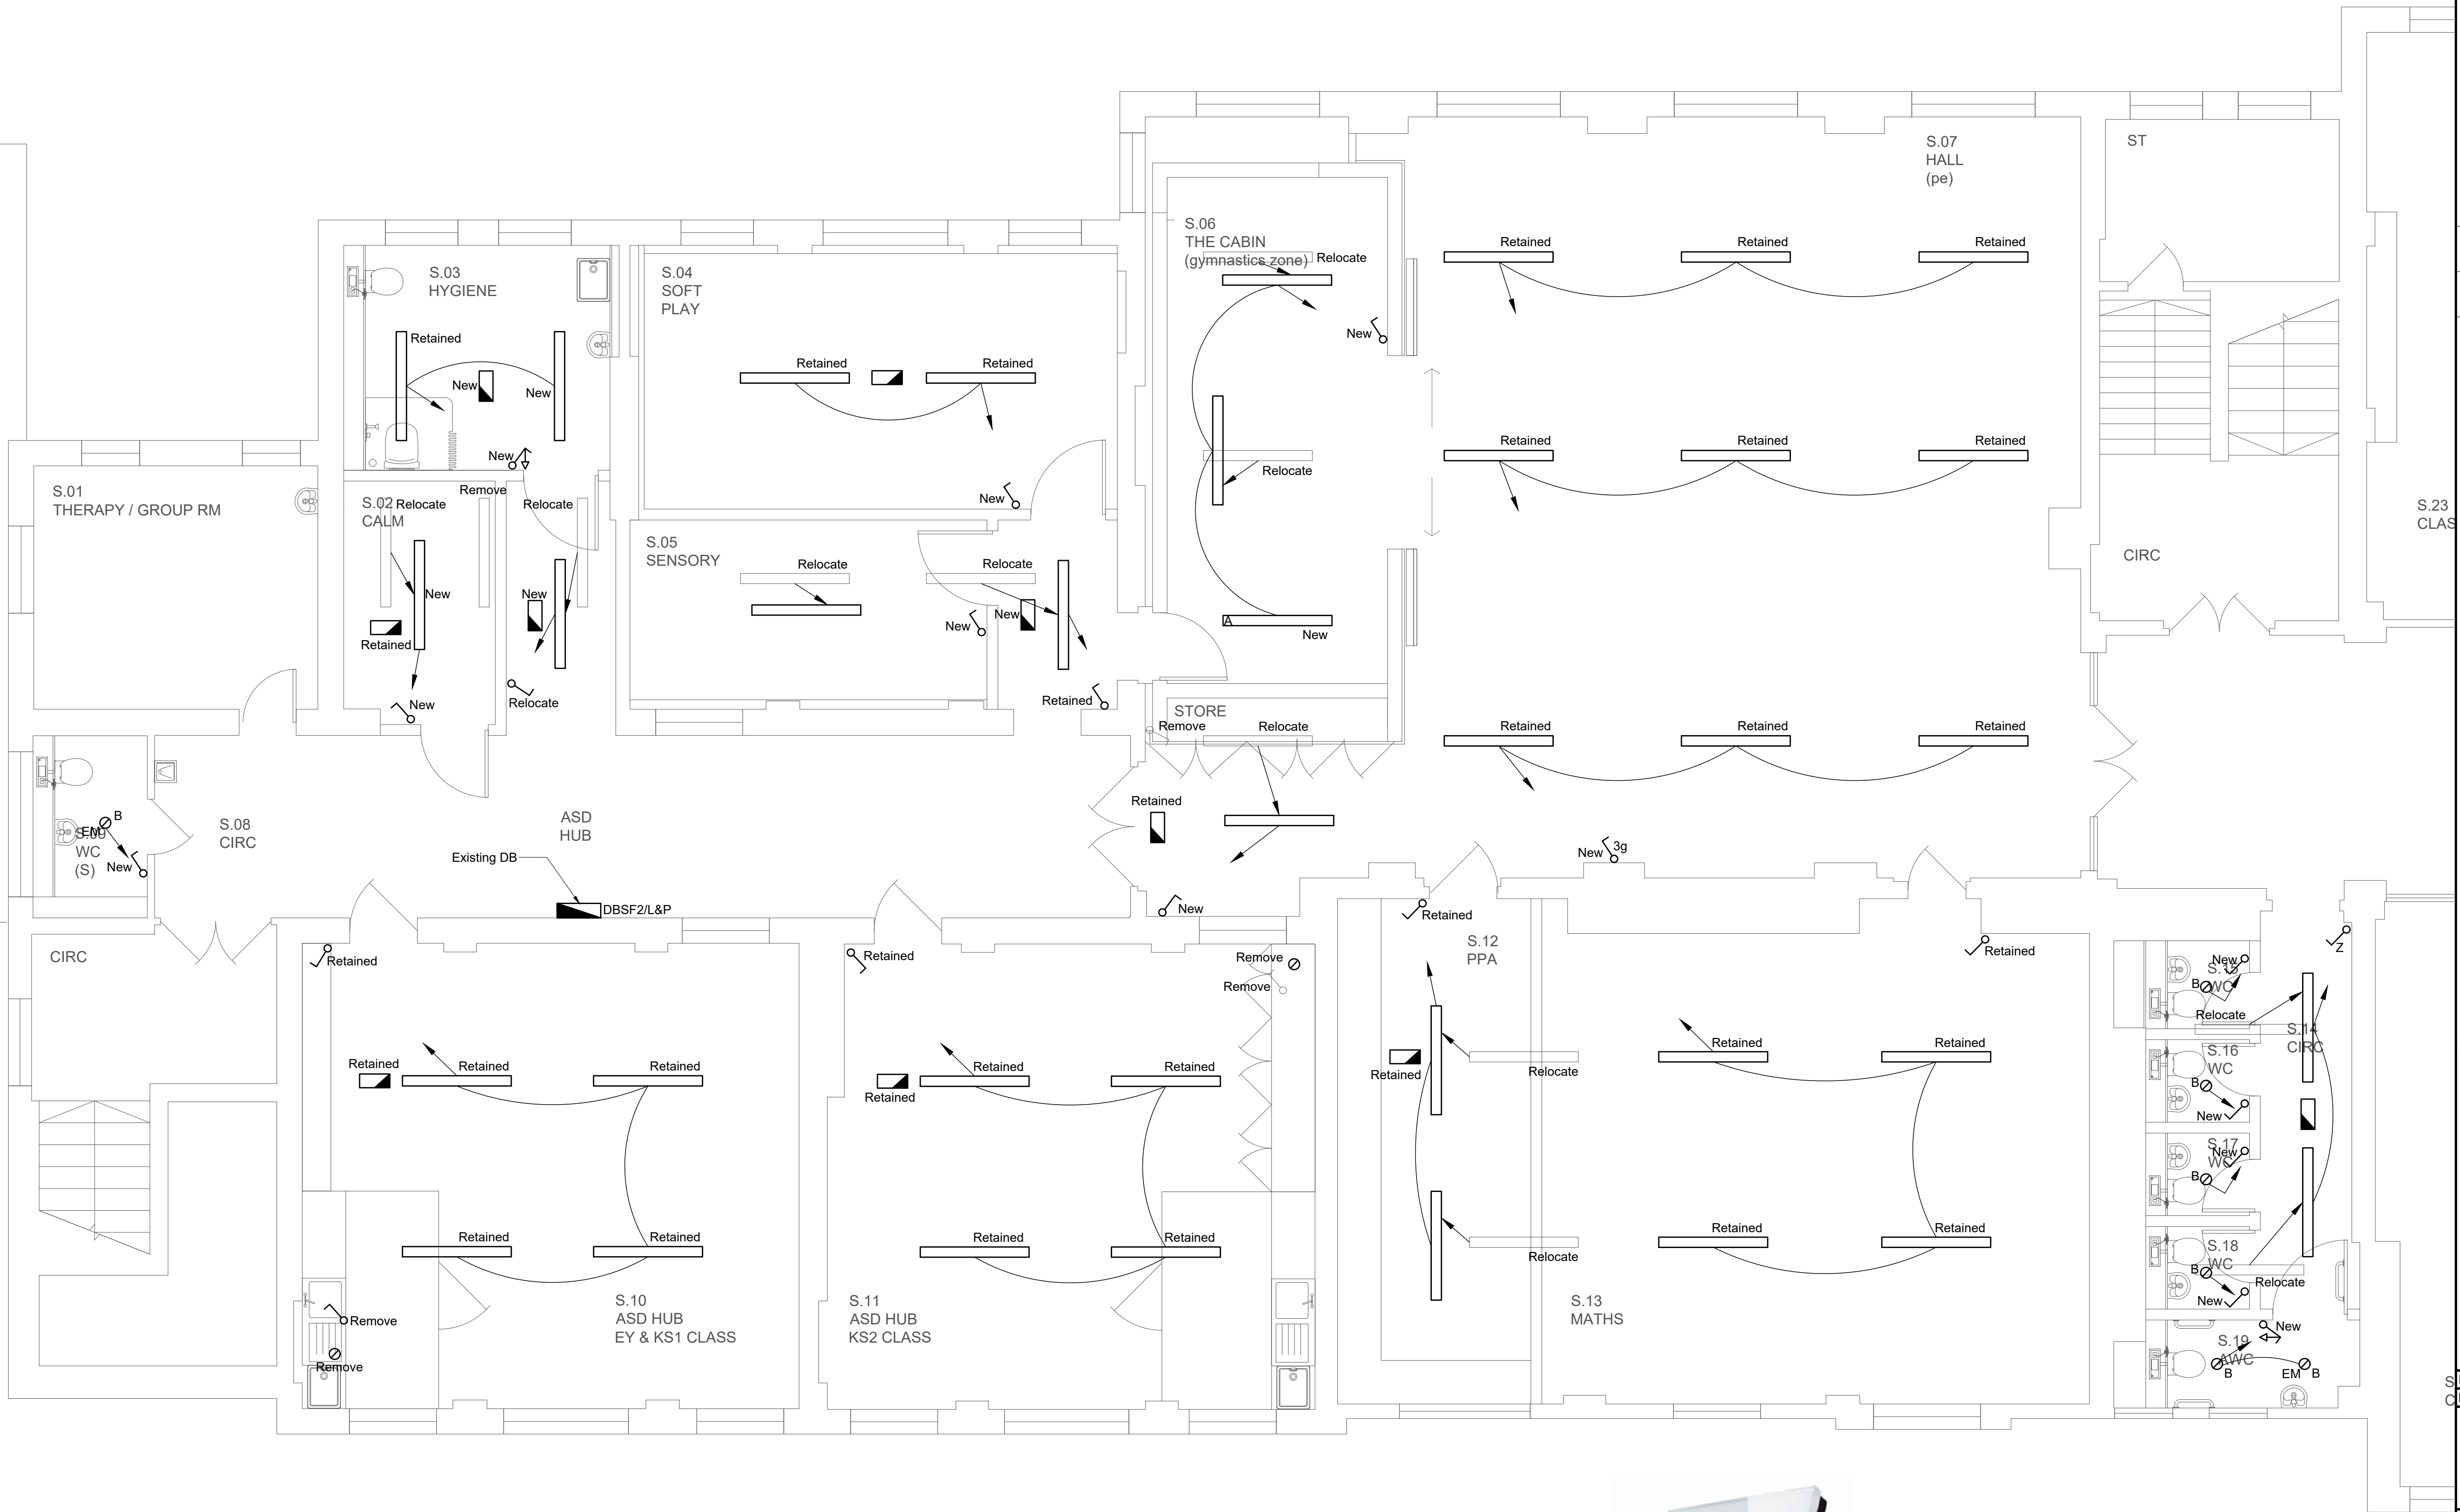

SP01	Tender Issue	JH	EB	05/19
REV	DESCRIPTION	DR'WN	CHK'D	DATE

Johns Slater and Haward
Chartered Building Services Consultants
Ardennais House, 6 Sorrel Horse Mews, Grimwade St, Ipswich IP4 1LN
01473 255965, engineers@jshipswich.co.uk, www.jshipswich.co.uk

JSH

CLIENT:



PROJECT:

Primrose Hill Primary School ARP

DRG TITLE:

Second Floor
Proposed Lighting Layout

SCALE: 1:50 @ A1	STATUS: D2 - Tender	PROJECT: 5557.00	ORIGINATOR: JSH
ZONE: XX	LEVEL: 02	TYPE: DR	DRG No. REV E-0204 P01



Ref:"A" - College LED4200-840 HF L1500



Ref:"B" - Cetus LED 2000 HF 830



Ref:"C" - Voyager Solid L MS E3D-S WH



Ref:"Z" - I LumoS Luxury White Glass
Panel LED Dimmer