

DO NOT SCALE


THE CONTRACTOR IS TO CHECK AND VERIFY ALL BUILDING AND SITE DIMENSIONS, LEVELS AND SEWER INVERT LEVELS AT CONNECTION POINTS BEFORE WORK STARTS.

THIS DRAWING IS TO BE READ AND CHECKED IN CONJUNCTION WITH ENGINEERS AND OTHER SPECIALIST DRAWINGS.

THE DRAWING AND THE WORKS DEPICTED ARE THE COPYRIGHT OF HAWORTH TOMPKINS LTD AND MAY NOT BE REPRODUCED EXCEPT BY WRITTEN PERMISSION.

NOTES

TO BE READ IN CONJUNCTION WITH GA PLANS, SECTIONS AND ELEVATIONS.

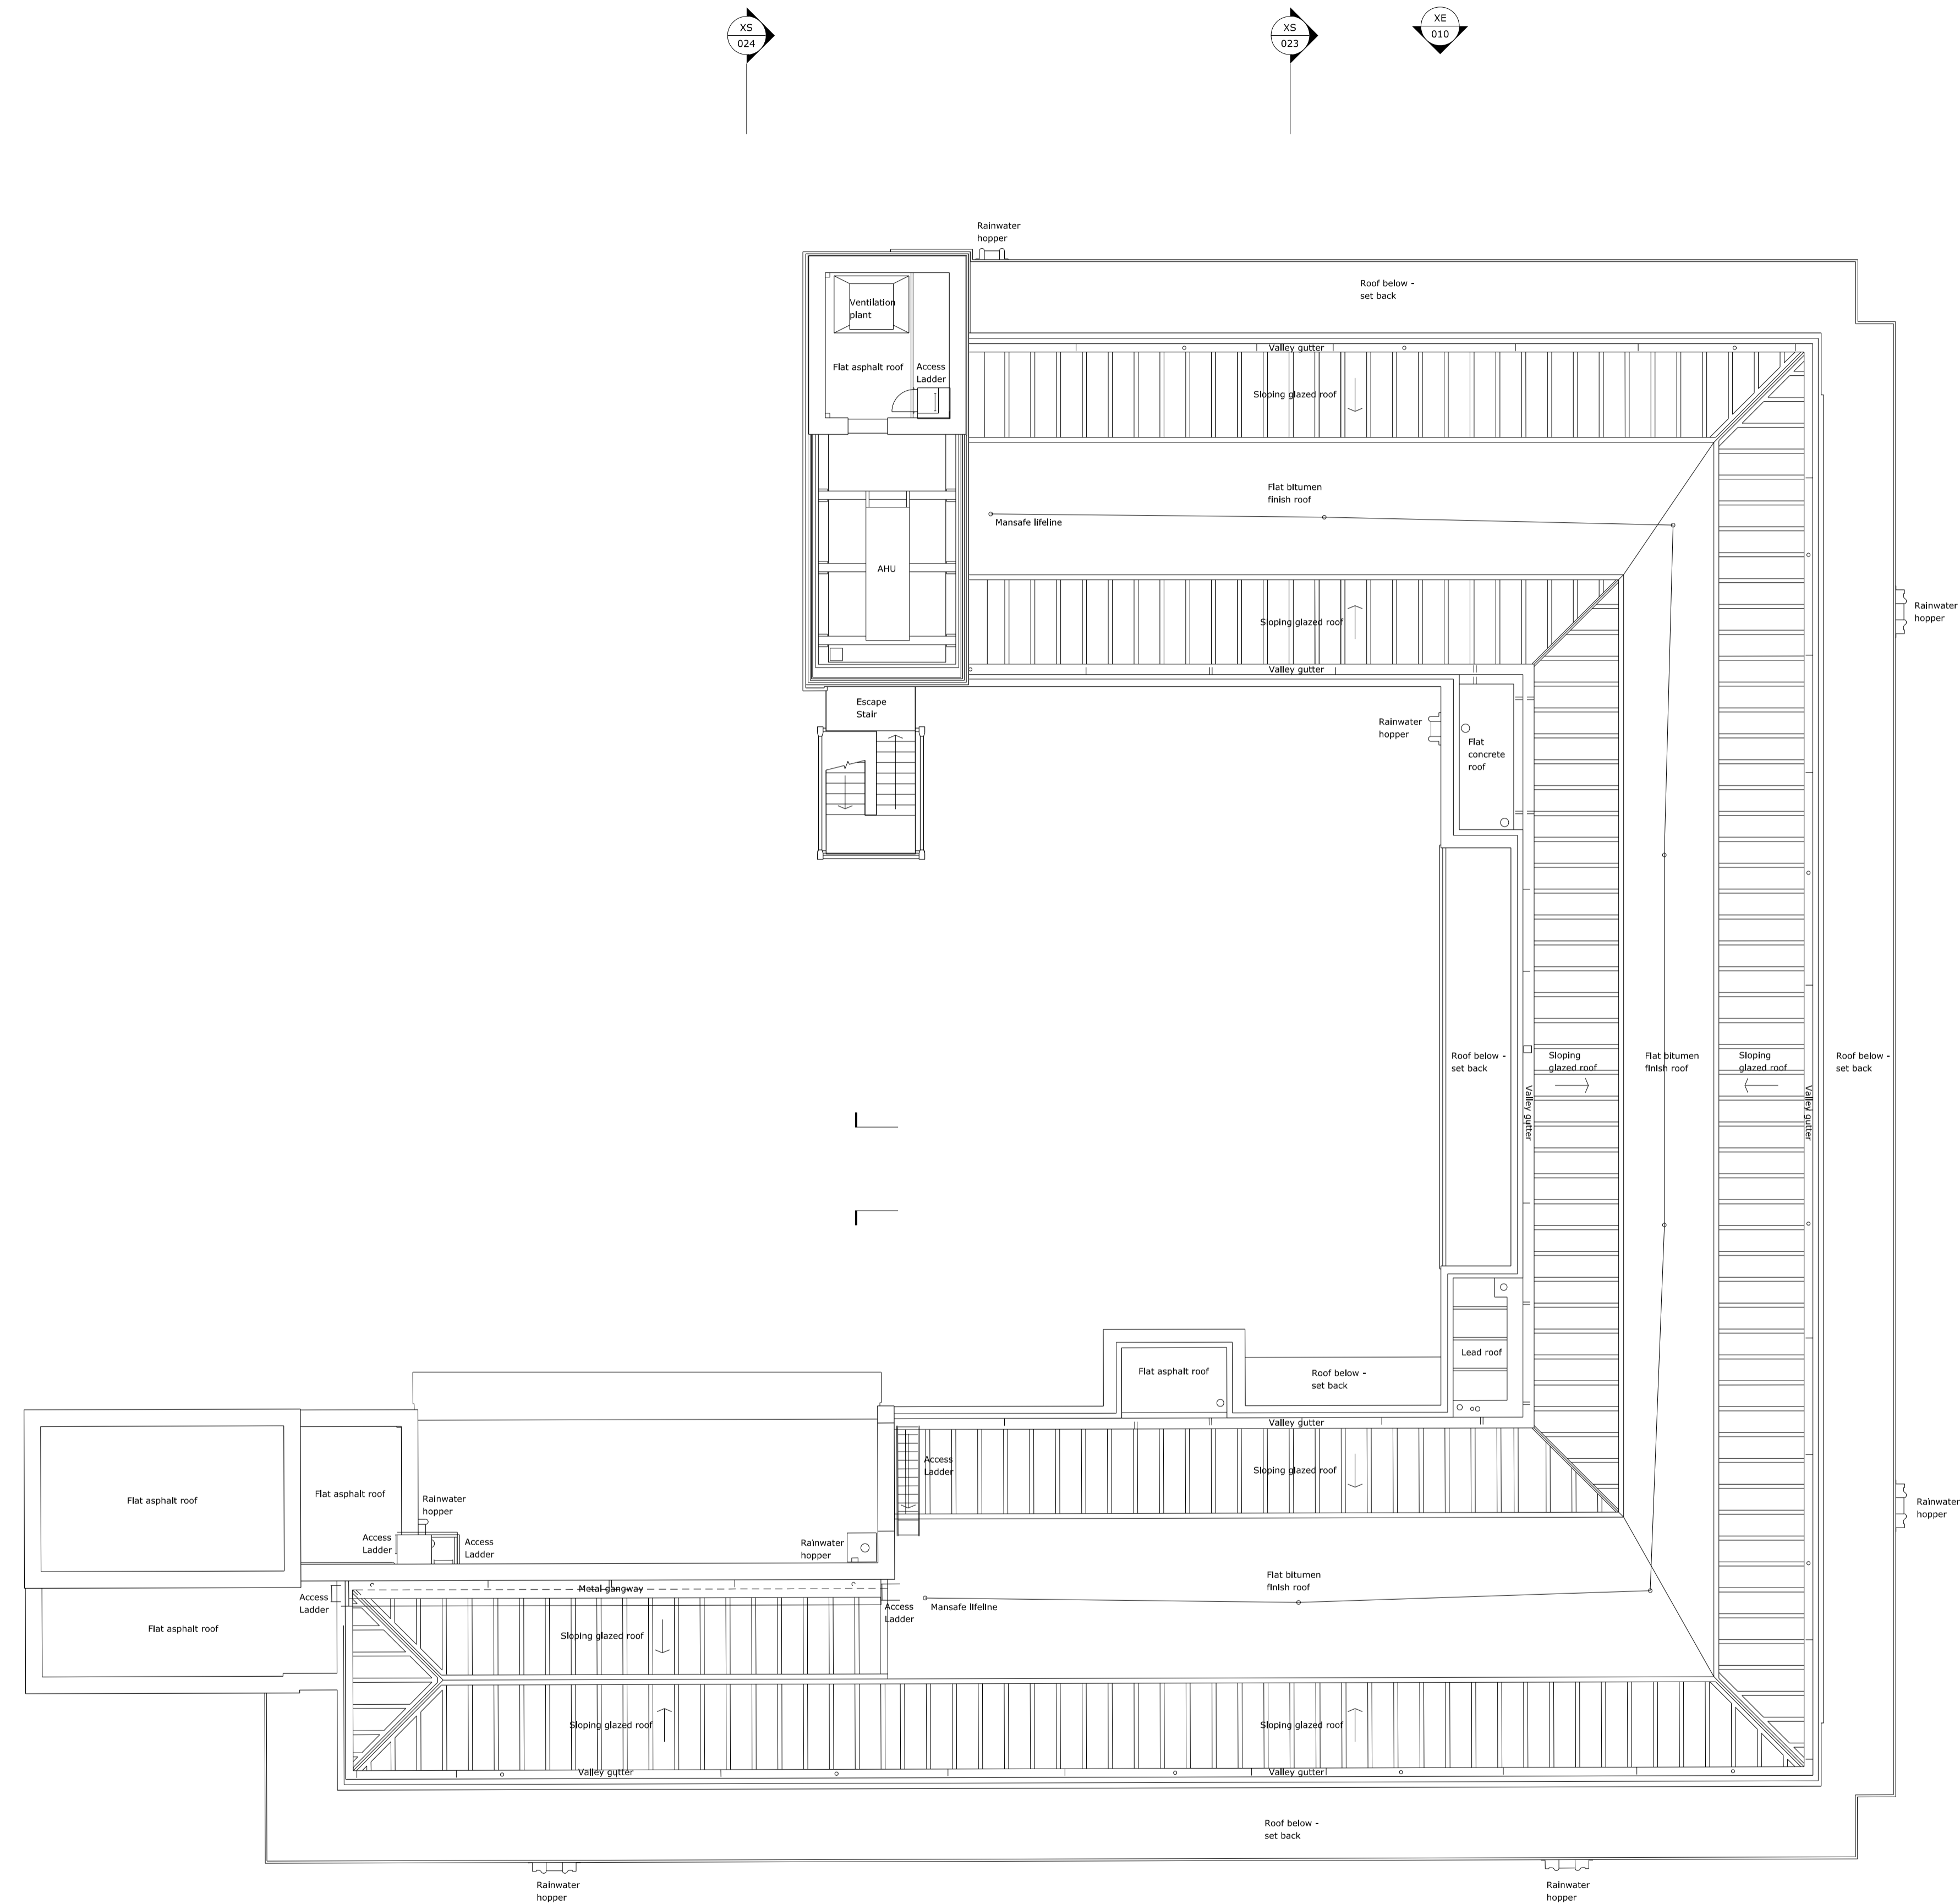

| | | |
|---|----------------|-----------------|
| REV | DATE | DESCRIPTION |
| - | 24/05/19 | Planning |
| <p>HaworthTompkins 33 Greenwood Place, London NW5 1LB +44 (0)20 7250 3225, www.haworthtompkins.com</p> | | |
| <p>JOB 1811: WARBURG INSTITUTE</p> | | |
| <p>DRG Roof Plan Existing</p> | | |
| DRG No | 1811-HT-XP-020 | REV - |
| SCALE | 1:100 at A1 | DATE 11.04.19 |
| DRAWN BY | HM | INSPECTED BY EF |
| DRAWING STATUS | PLANNING | |