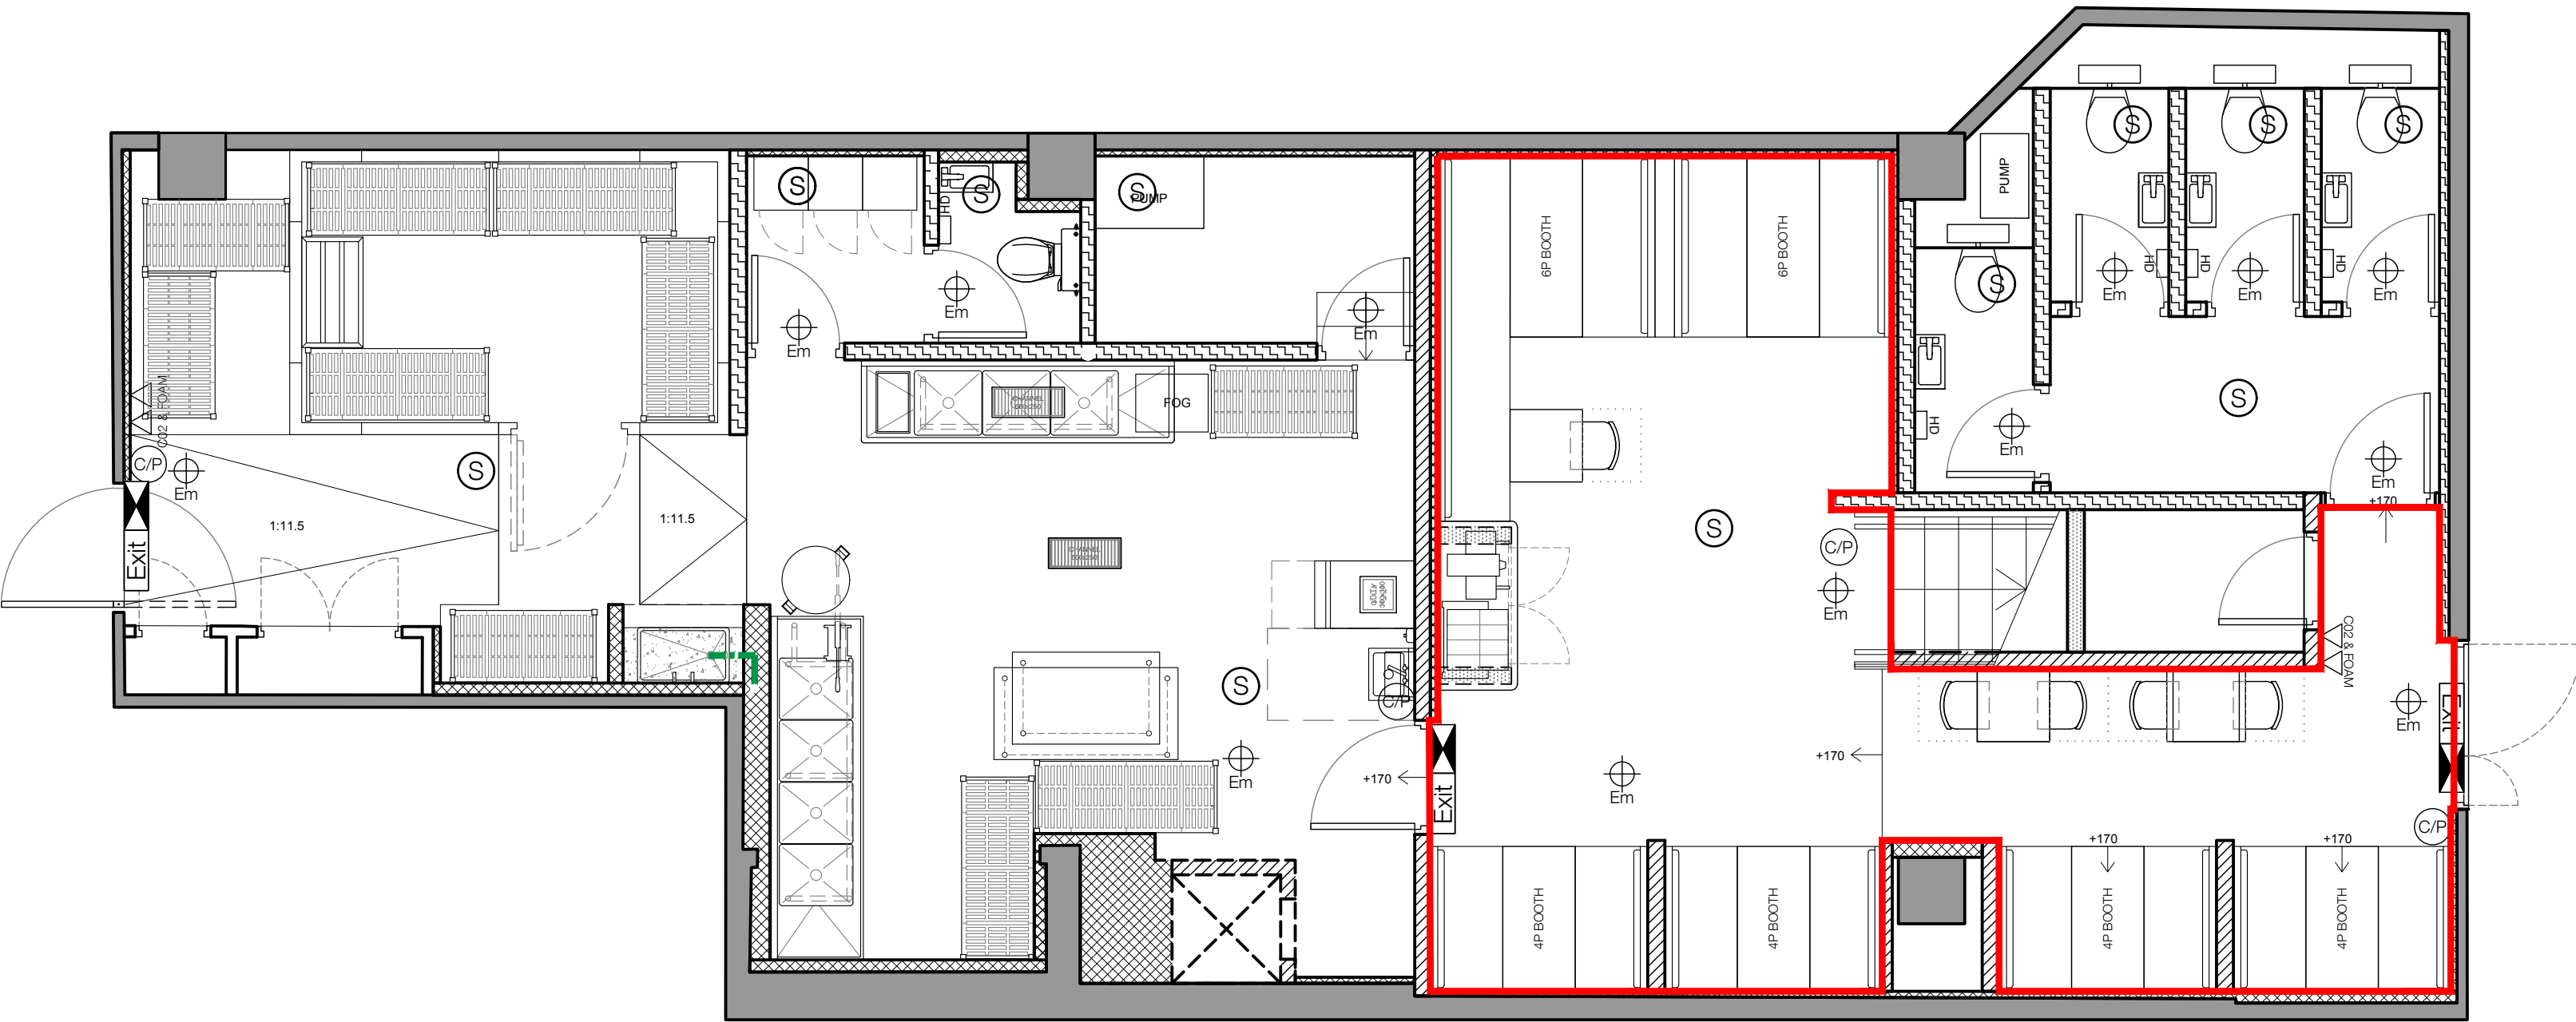


 
 


02 BASEMENT PLAN
SCALE 1:50 @ A1

FLOOR PLAN GENERAL NOTES

- ## FIRE ALARM & EMERGENCY LIGHTING LAYOUT

-  FIRE SUPPRESSION SYSTEM
-  ZONE TO BE SPRINKLERED
-  FIRE BOUNDARY INDICATING PARTITION TO HAVE 60MINS FIRE RATING IN ADDITION TO WALL CONSTRUCTION REFERENCE, ANY DOORS WITHIN INDICATED PARTITION TO HAVE 30 MINUTES FIRE RATING BUILDING CONTROL TO CONFIRM

- | | |
|---|---|
|  | FIRE EXTINGUISHER - CO2, FOAM OR WET CHEM |
|  | WET CHEM & FIRE BLANKET |
|  | CO2 REPEATER BEACON |
|  | ANSUL TANK POSITION |
|  | FIRE ALARM PANEL POSITION |

NOTES
VOID DETECTION TO BE INSTALLED TO ALL CEILING VOIDS OF 800
OR GREATER DEPTH. FINAL POSITIONS TO BE AGREED FOLLOWING
SITE STRIP OUT.

LICENSED PREMISES

THE LOCATION AND TYPE OF FIRE SAFETY AND ALL OTHER FIRE SAFETY EQUIPMENT IS SHOWN AS ATTACHED TO THIS POLICY. FROM TIME TO TIME, PRESENT, THIS MAY BE VARIED FROM TIME TO TIME WITH THE AGREEMENT OF THE FIRE OFFICER OR AFTER A FIRE RISK ASSESSMENT.

 AREAS TO WHICH CHILDREN AND YOUNG PERSONS WILL HAVE ACCESS

PLANNING



Date	Drawn	Checked
29/07/16	AV	BT
11/08/16	AV	BT
12/08/16	AV	BT
08/09/16	AV	BT
24/11/16	AV	BT
06/01/17	CN	BT
03/03/17	SC	SC
05/04/17	AV	BT
28/05/19	KD	BT

Location Plan (NTS):

135 Curtain Road, London EC2A 3BX
+44 (0)20 7713 7413 - blacksheep.uk.com

LICENSING PLAN

Project
TOTTENHAM COURT ROAD
LONDON, UK

Drawing No.	Date	Scale	Revision	Drawn By	Checked By
FIV144-A221	29/07/2016	1:50 @ A1	I	AV	BT