


2000_PROPOSED

LBMV architects

Luigi Montefusco Ltd
27 Elizabeth Mews
NW3 4UH London
T+44 (0) 207 483 3880
info@lbmvarchitects.com
www.lbmvarchitects.com

DRAWINGS STATUS		DRAWN		CHECKED		GENERAL NOTE		LEGEND			
PLANNING PERMISSION		A3	MF, UG	LM	<div>- This drawing should be removed from currency immediately when a revised version is issued.</div> <div>- All dimensions to be checked on site by the contractor. Discrepancies to be reported before proceeding with the works.</div> <div>- This drawing is copyrighted.</div> <div>- All dimensions in mm's.</div>						
PROJECT TITLE PLANNING APPLICATION / LISTED BUILDING CONSENT 06 Lyndhurst Gardens NW3 5NR			DATE							SCALE	
			05.04.2019								
			DRAWING TITLE								
			JOB NO		DRAWING NO						
			0071		A2000						

	</		

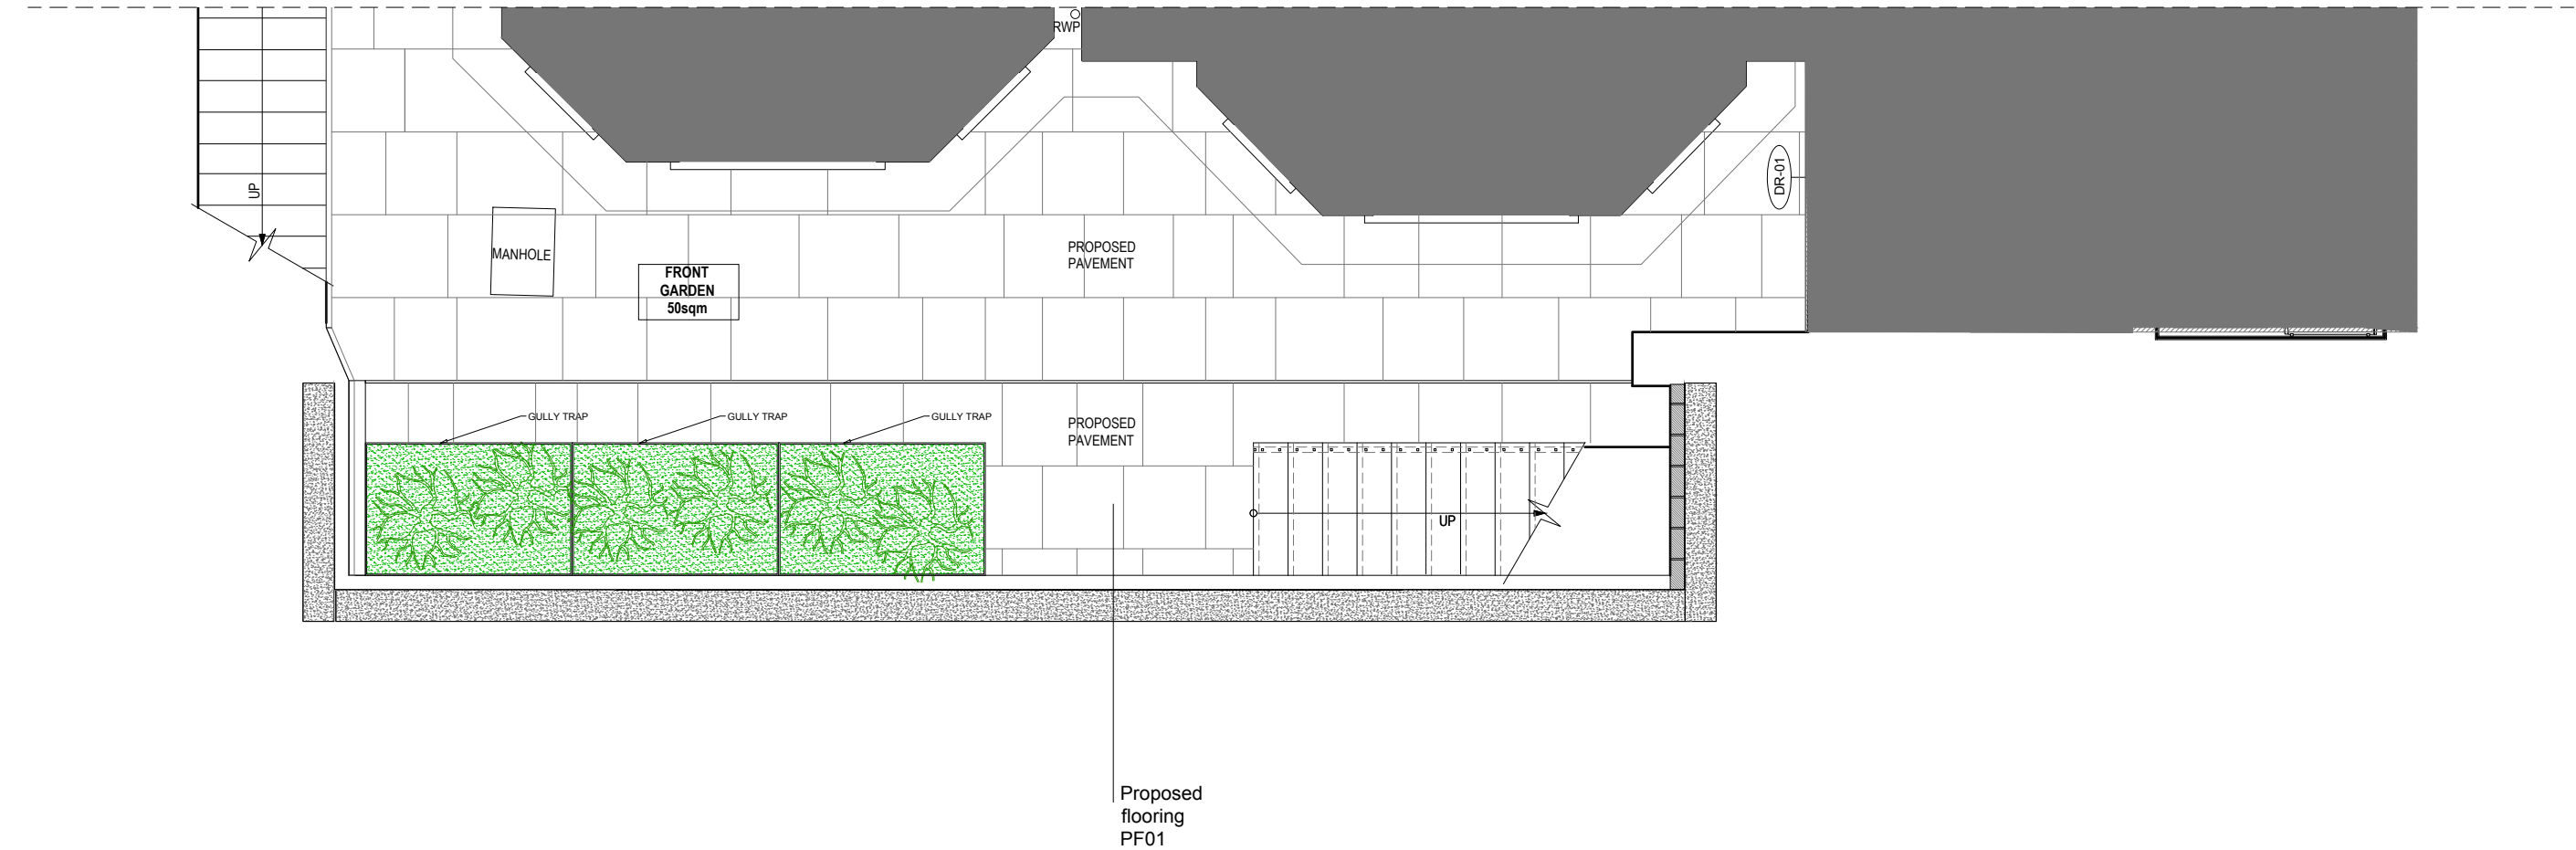


LBMV architects

Luigi Montefusco Ltd
27 Elizabeth Mews
NW3 4UH London
T+44 (0) 207 483 3880
info@lbmvarchitects.com
www.lbmvarchitects.com

DRAWINGS STATUS
PLANNING PERMISSION
A3
PROJECT TITLE
PLANNING APPLICATION /
LISTED BUILDING CONSENT
06 Lyndhurst Gardens
NW3 5NR

DRAWN
MF, UG
CHECKED
LM
DATE
05.04.2019
SCALE
1:50@A3
DRAWING TITLE
PROPOSED LOWER
GROUND PLAN
JOB NO
0071
DRAWING NO
A2001

GENERAL NOTE
- This drawing should be removed from currency
immediately when a revised version is issued.
- All dimensions to be checked on site by the contractor.
Discrepancies to be reported before proceeding with the
works.
- This drawing is copyrighted.
- All dimensions in mm's.

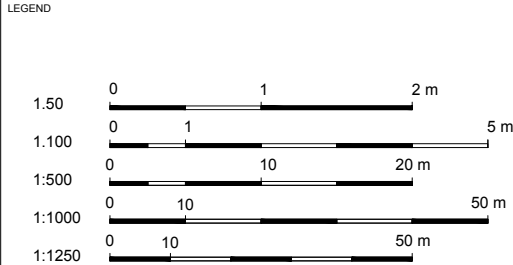


ELECTRICAL SYMBOLS	WALK OVER
	LIGHTING SPIKE
SERVICE SYMBOLS	SWITCH
	WATER SUPPLY
ELECTRICAL SYMBOLS	WATER-GARDEN

REV	DESCRIPTION	DATE	NAME
00		08-04-2019	

PROPOSED UPPER GROUND FLOOR PLAN-FRONT GARDEN

SCALE 1:50

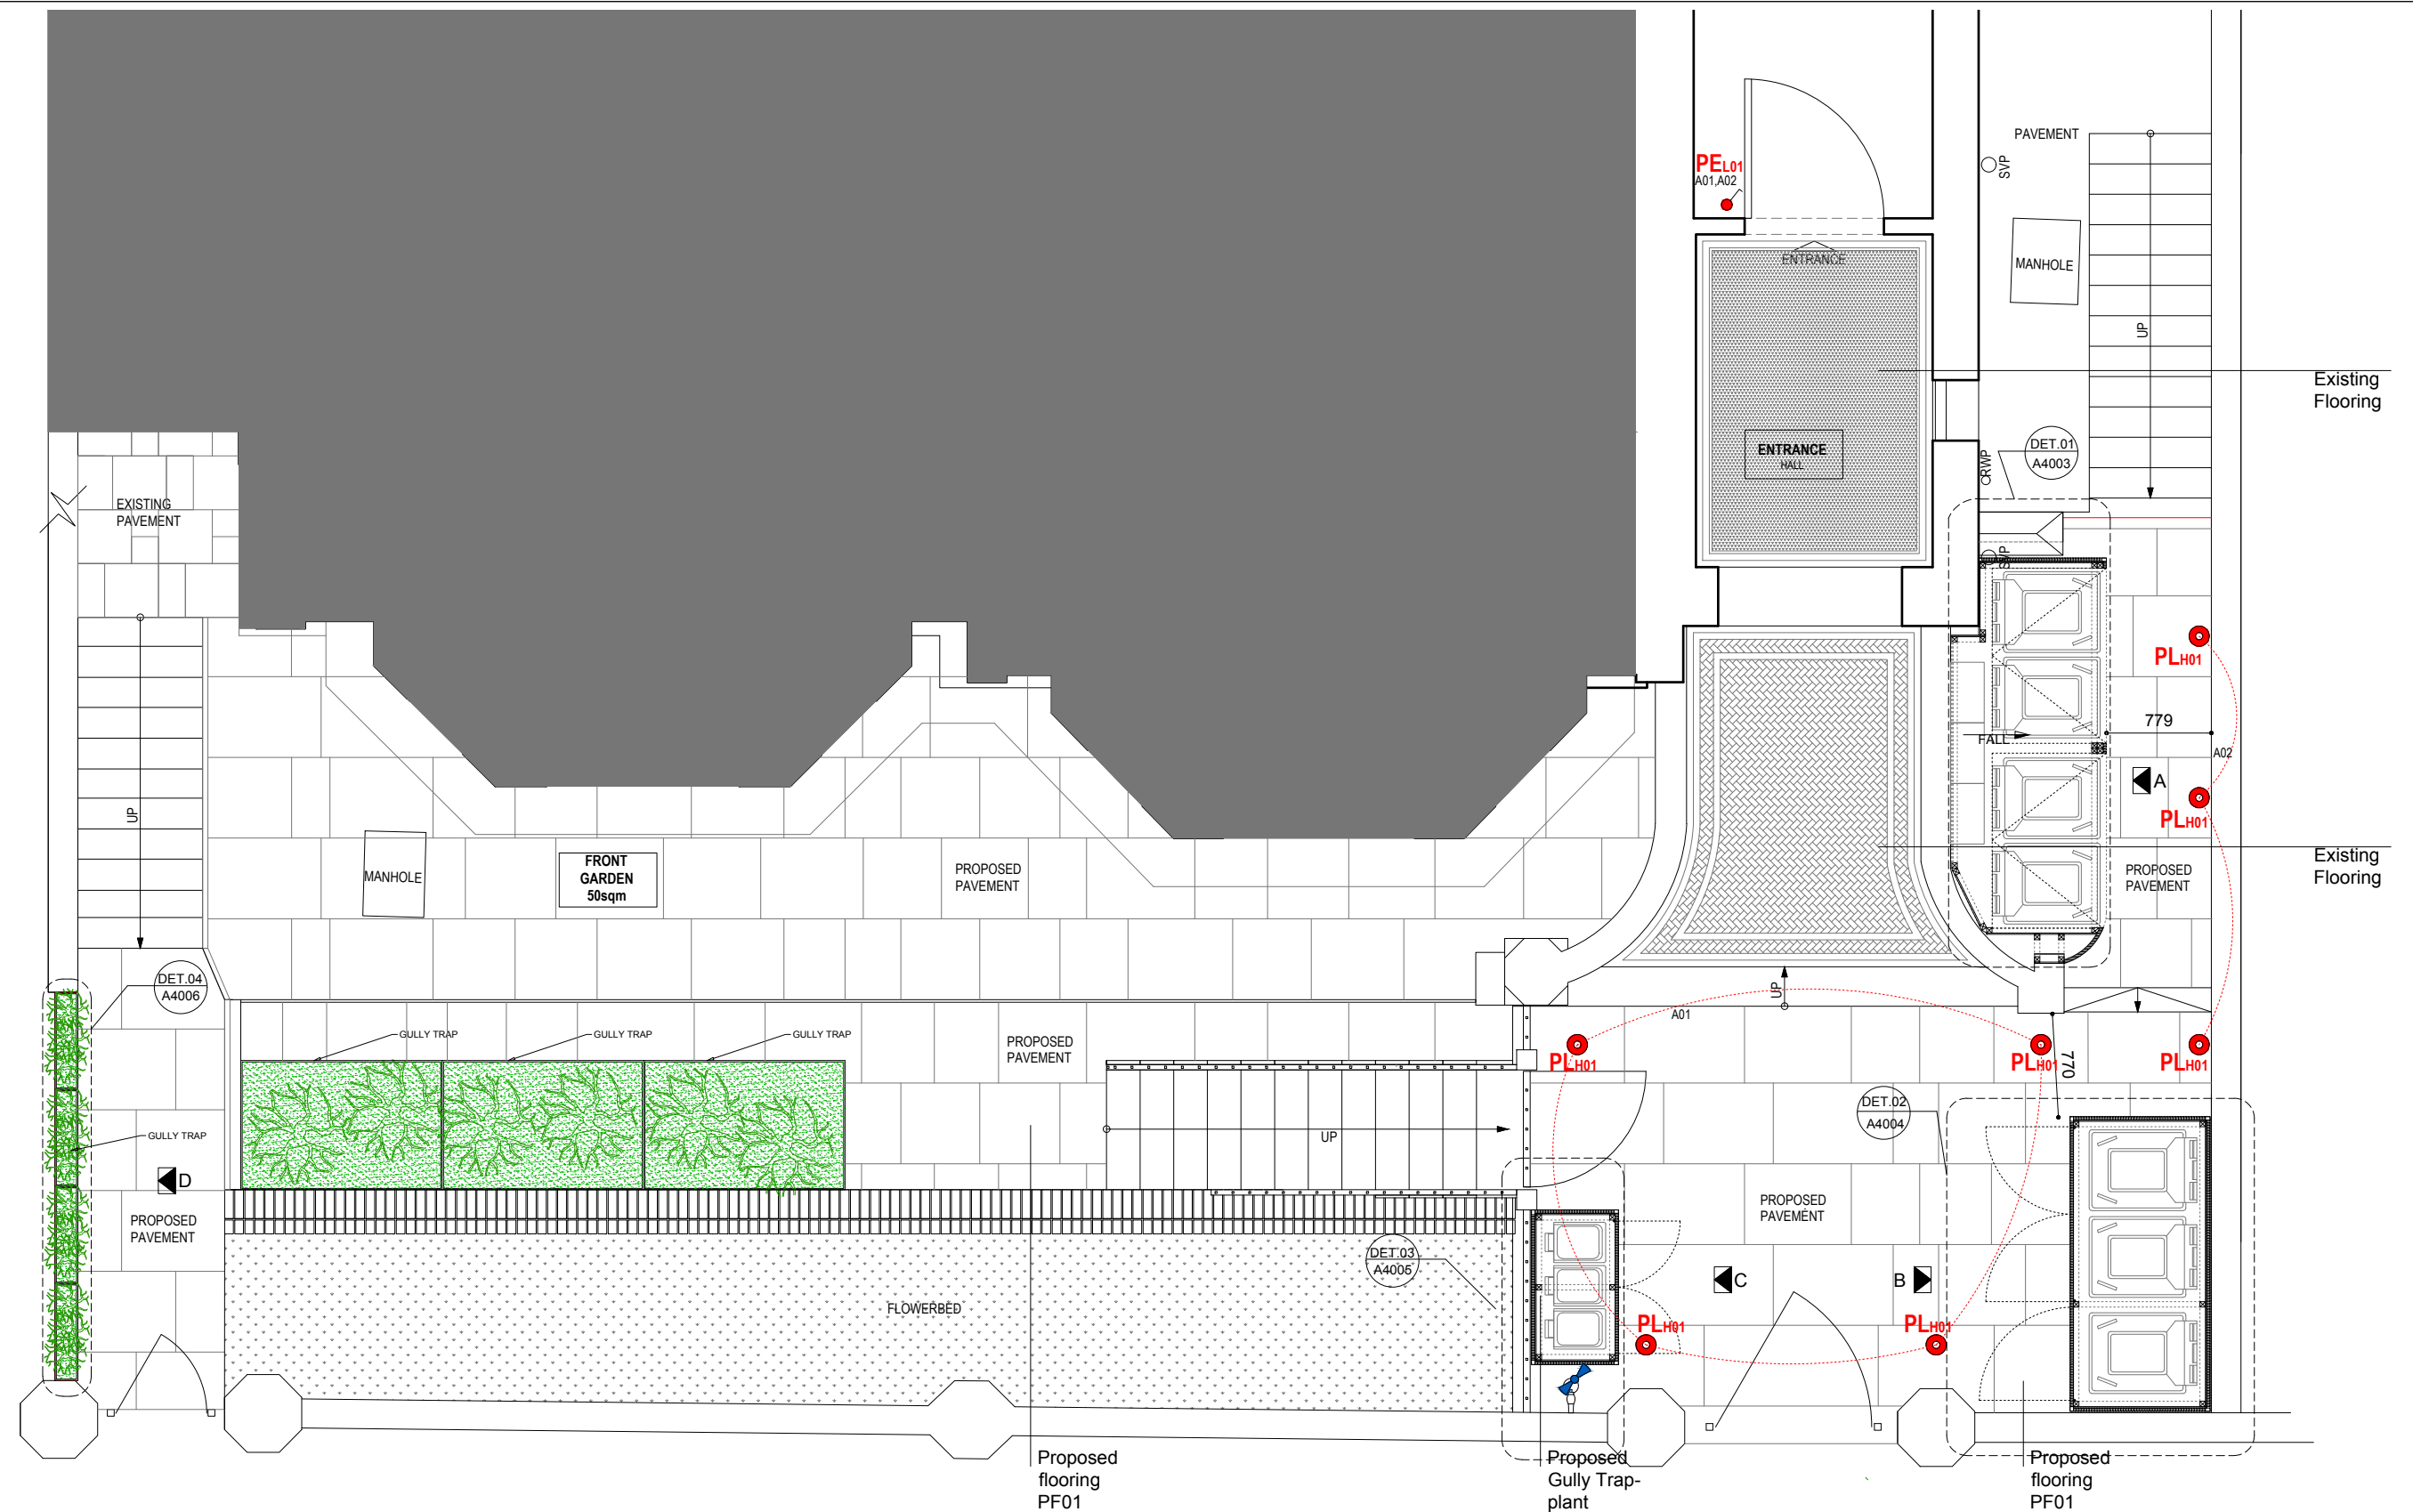


LBMV architects




Luigi Montefusco Ltd
27 Elizabeth Mews
NW3 4UH London
T+44 (0) 207 483 3880
info@lbmvarchitects.com
www.lbmvarchitects.com

DRAWINGS STATUS		DRAWN	CHECKED
PLANNING PERMISSION		A3	MF, UG
			LM
PROJECT TITLE		DATE	SCALE
		05.04.2019	1:50@A3
PLANNING APPLICATION / LISTED BUILDING CONSENT 06 Lyndhurst Gardens NW3 5NR		DRAWING TITLE	
		PROPOSED UPPER GROUND FLOOR PLAN	
		JOB NO	DRAWING NO
		0071	A2002

GENERAL NOTE	<ul style="list-style-type: none"> - This drawing should be removed from currency immediately when a revised version is issued. - All dimensions to be checked on site by the contractor. Discrepancies to be reported before proceeding with the works. - This drawing is copyrighted. - All dimensions in mm's.
--------------	---

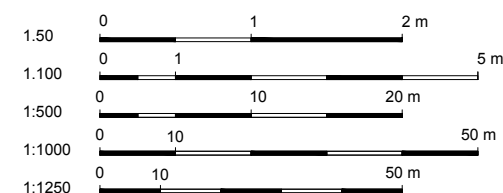LEGEND



ELECTRICAL SYMBOLS	
	WALK OVER
	LIGHTING SPIKE
	SWITCH
SERVICE SYMBOLS	
	WATER SUPPLY
	WATER-GARDE

00		08-04-2019	
REV	DESCRIPTION	DATE	NAME