
 
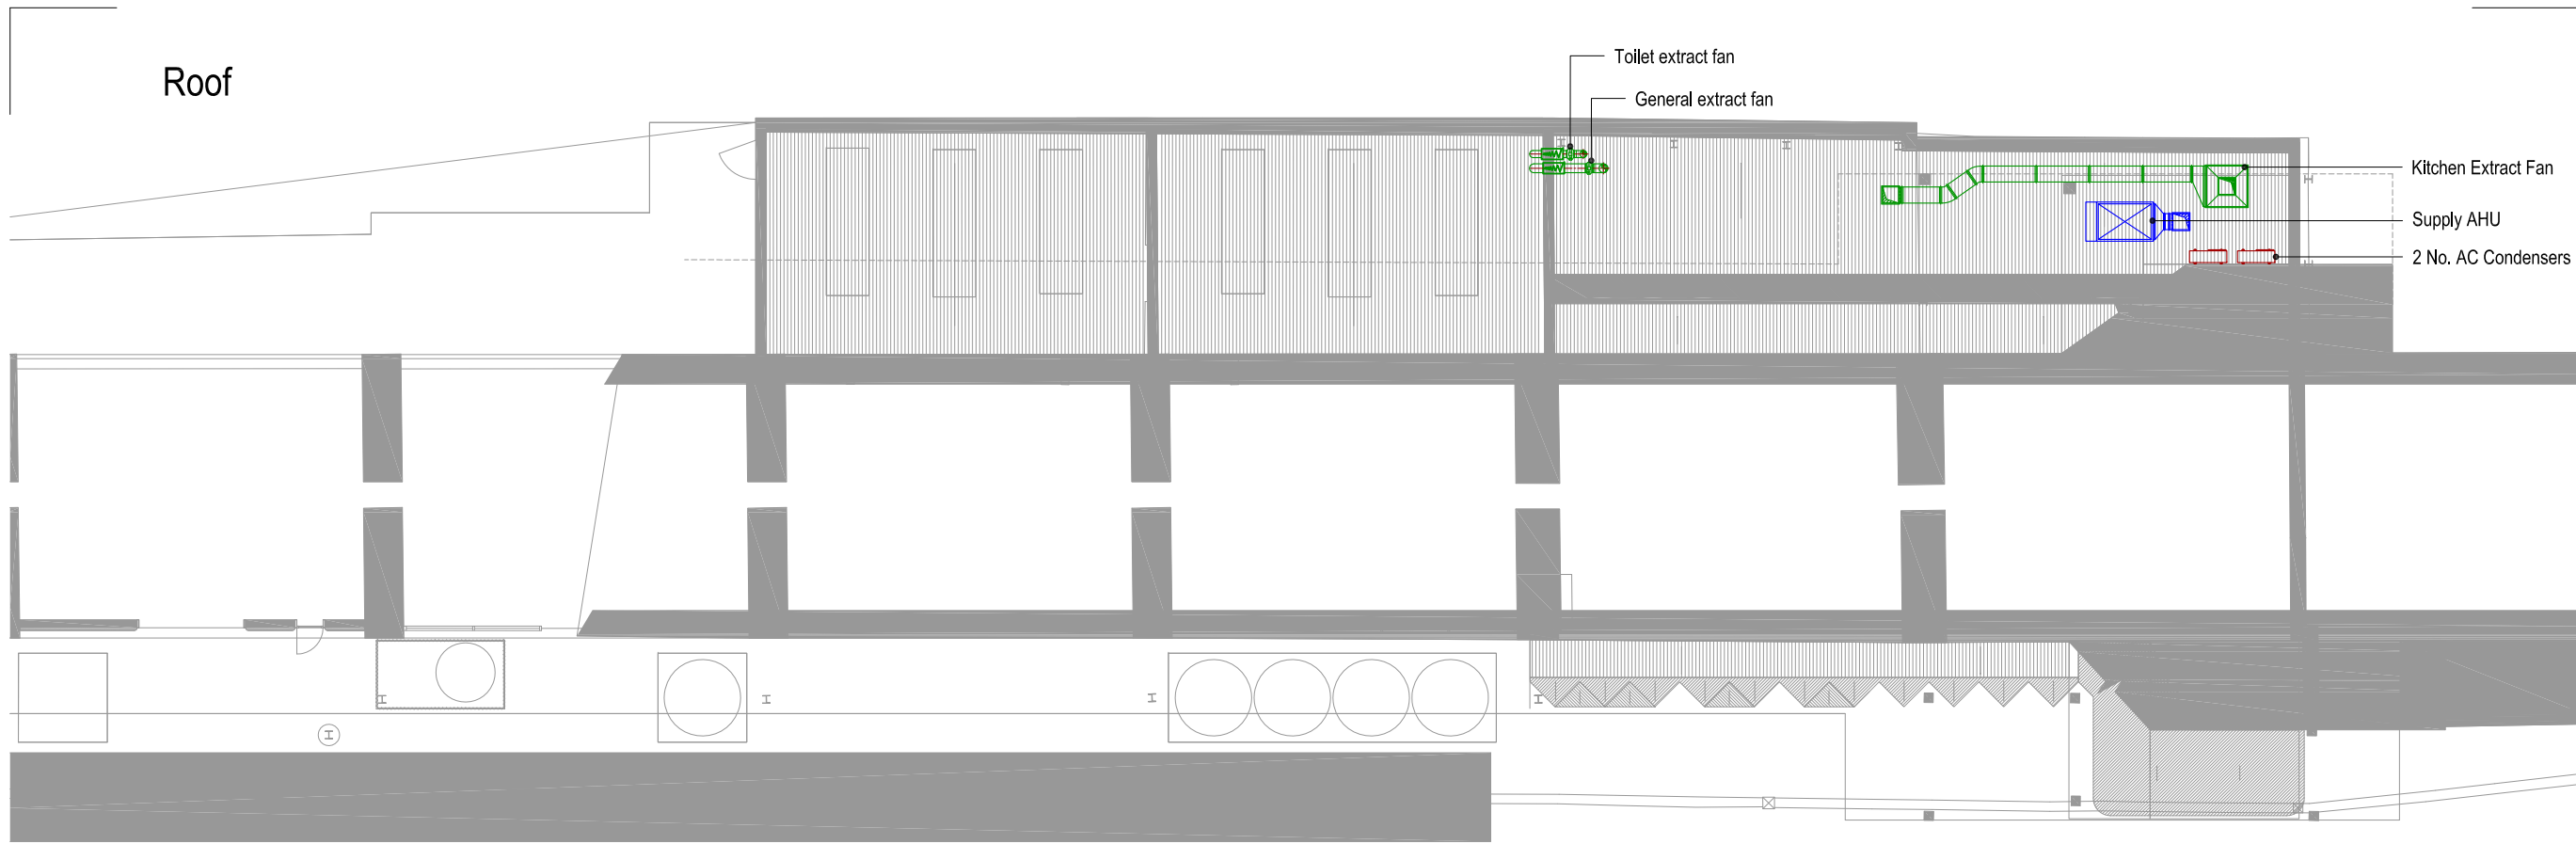


Roof



Ground Floor

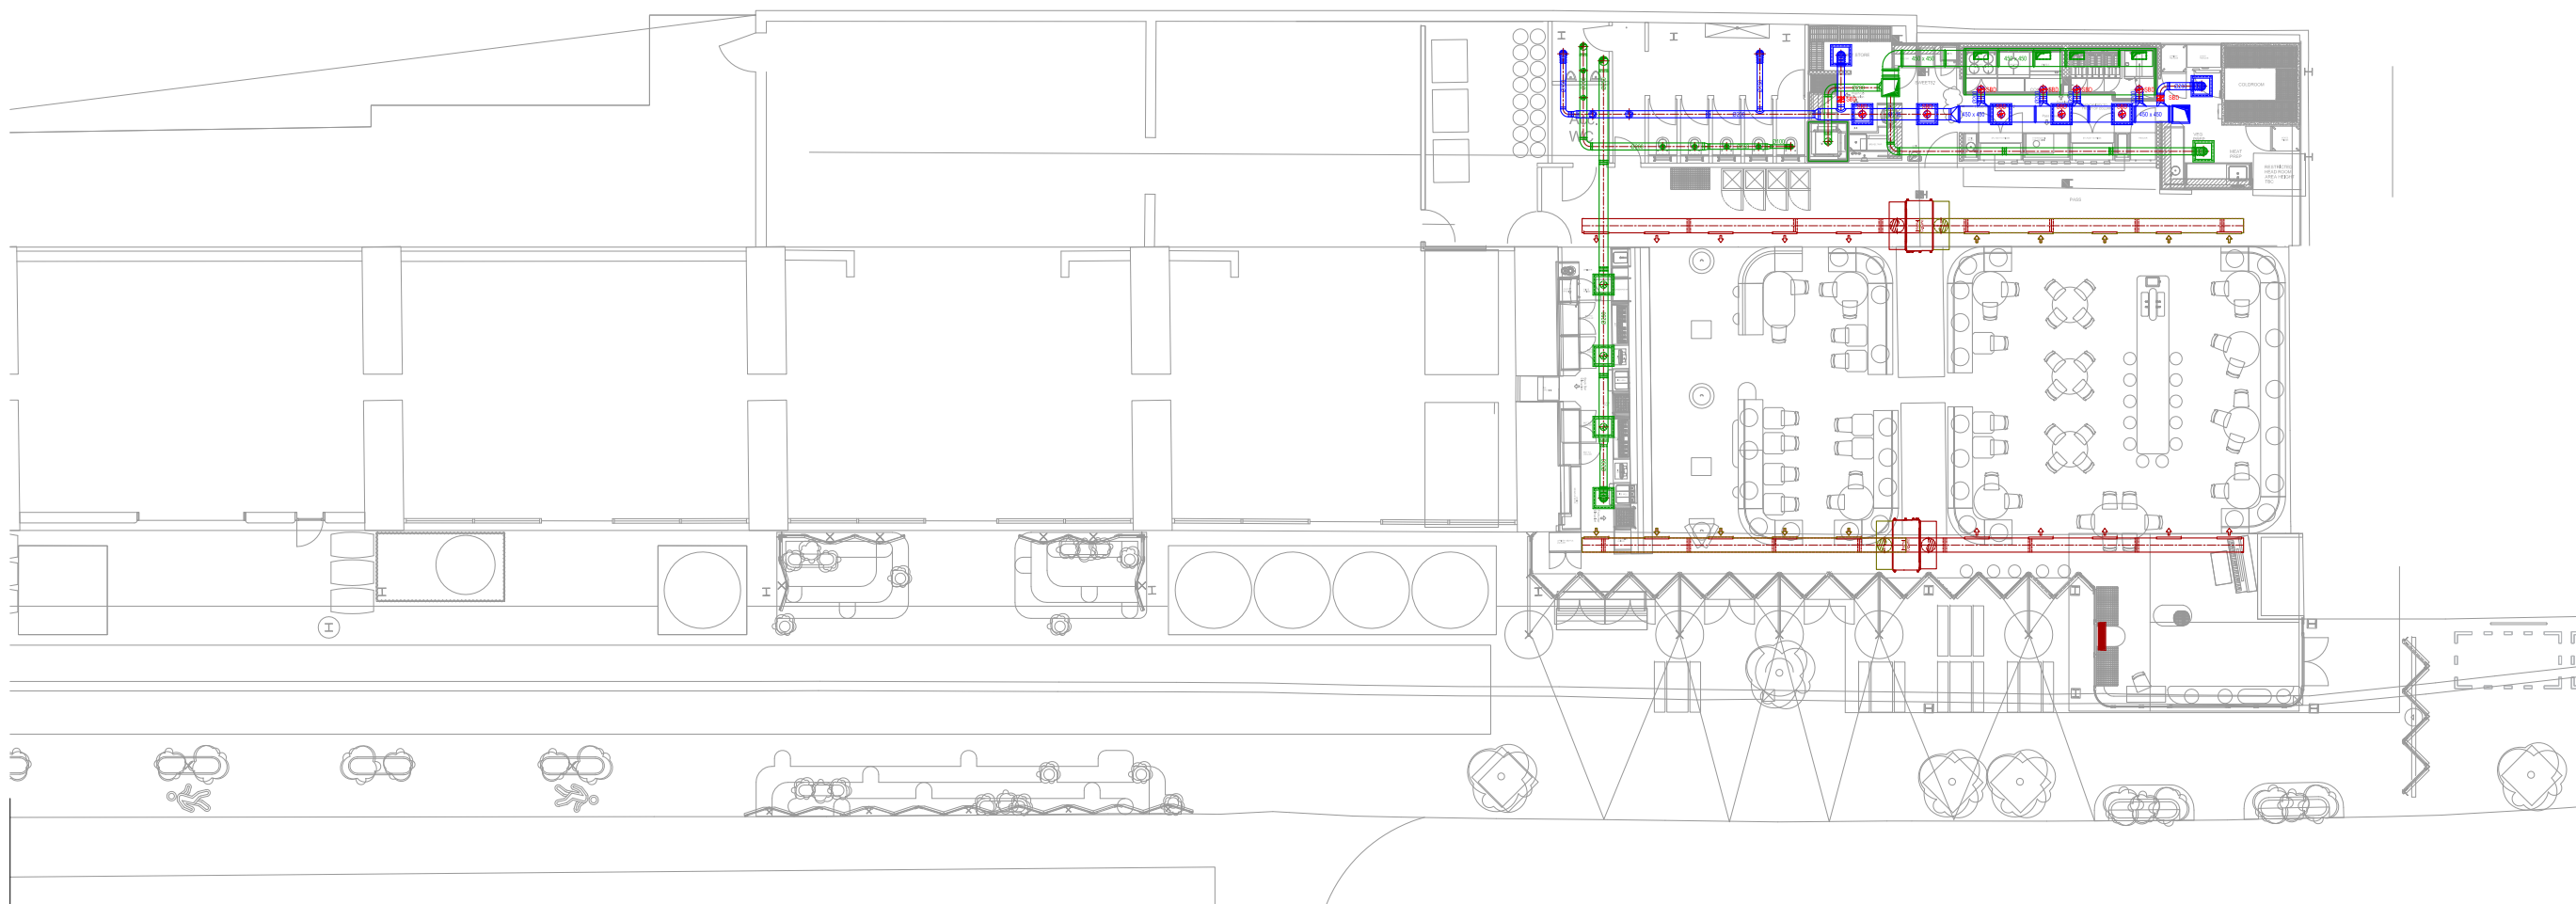

B	20-06-19	PR	Scale bar and north arrow added.
A	14-06-19	JK	Amendments to equipment location on roof. General & WC extract moved to roof.
No.	Date	Rev. By	Revision Description

Client:
Camden Town Brewery

Project:
**Camden Town Brewery
Camden**

Drawing Title:
**Ventilation Layout
Ground Floor & Roof**

Drawing No:	Rev:
001-646-01	B
Scale: 1:100 @ A1 1:200 @ A3	
Drawn By: JK	Date: 06-06-19

chapman ventilation
 15-20 Woodfield Road, Welwyn Garden City
 Hertfordshire AL7 1JQ
 Tel: 01707 372658 Fax: 01707 325001
 E-mail: info@chapmanventilation.co.uk
 Web: www.chapmanventilation.co.uk

Copyright of this drawing resides with Chapman Ventilation Limited ©