




 

GENERAL NOTES  
 DO NOT SCALE OFF THIS DRAWING.  
 ALL DIMENSIONS MUST BE CHECKED ON SITE INFORM THE ARCHITECT OF ANY DISCREPANCIES PRIOR TO CONSTRUCTION.  
 THIS DRAWING IS COPYRIGHT & MAY NOT BE OTHERWISE USED OR COPIED.  
 READ IN CONJUNCTION WITH M.E.P. S.E. AND CIVIL ENGINEER'S DRAWINGS.  
 CDM REGULATIONS 2015  
 ALL CURRENT DRAWINGS AND SPECIFICATIONS FOR THE PROJECT MUST BE READ IN CONJUNCTION WITH THE DESIGNER'S HAZARD AND ENVIRONMENTAL ASSESSMENT RECORD

**Key**

-  Existing
-  Proposed

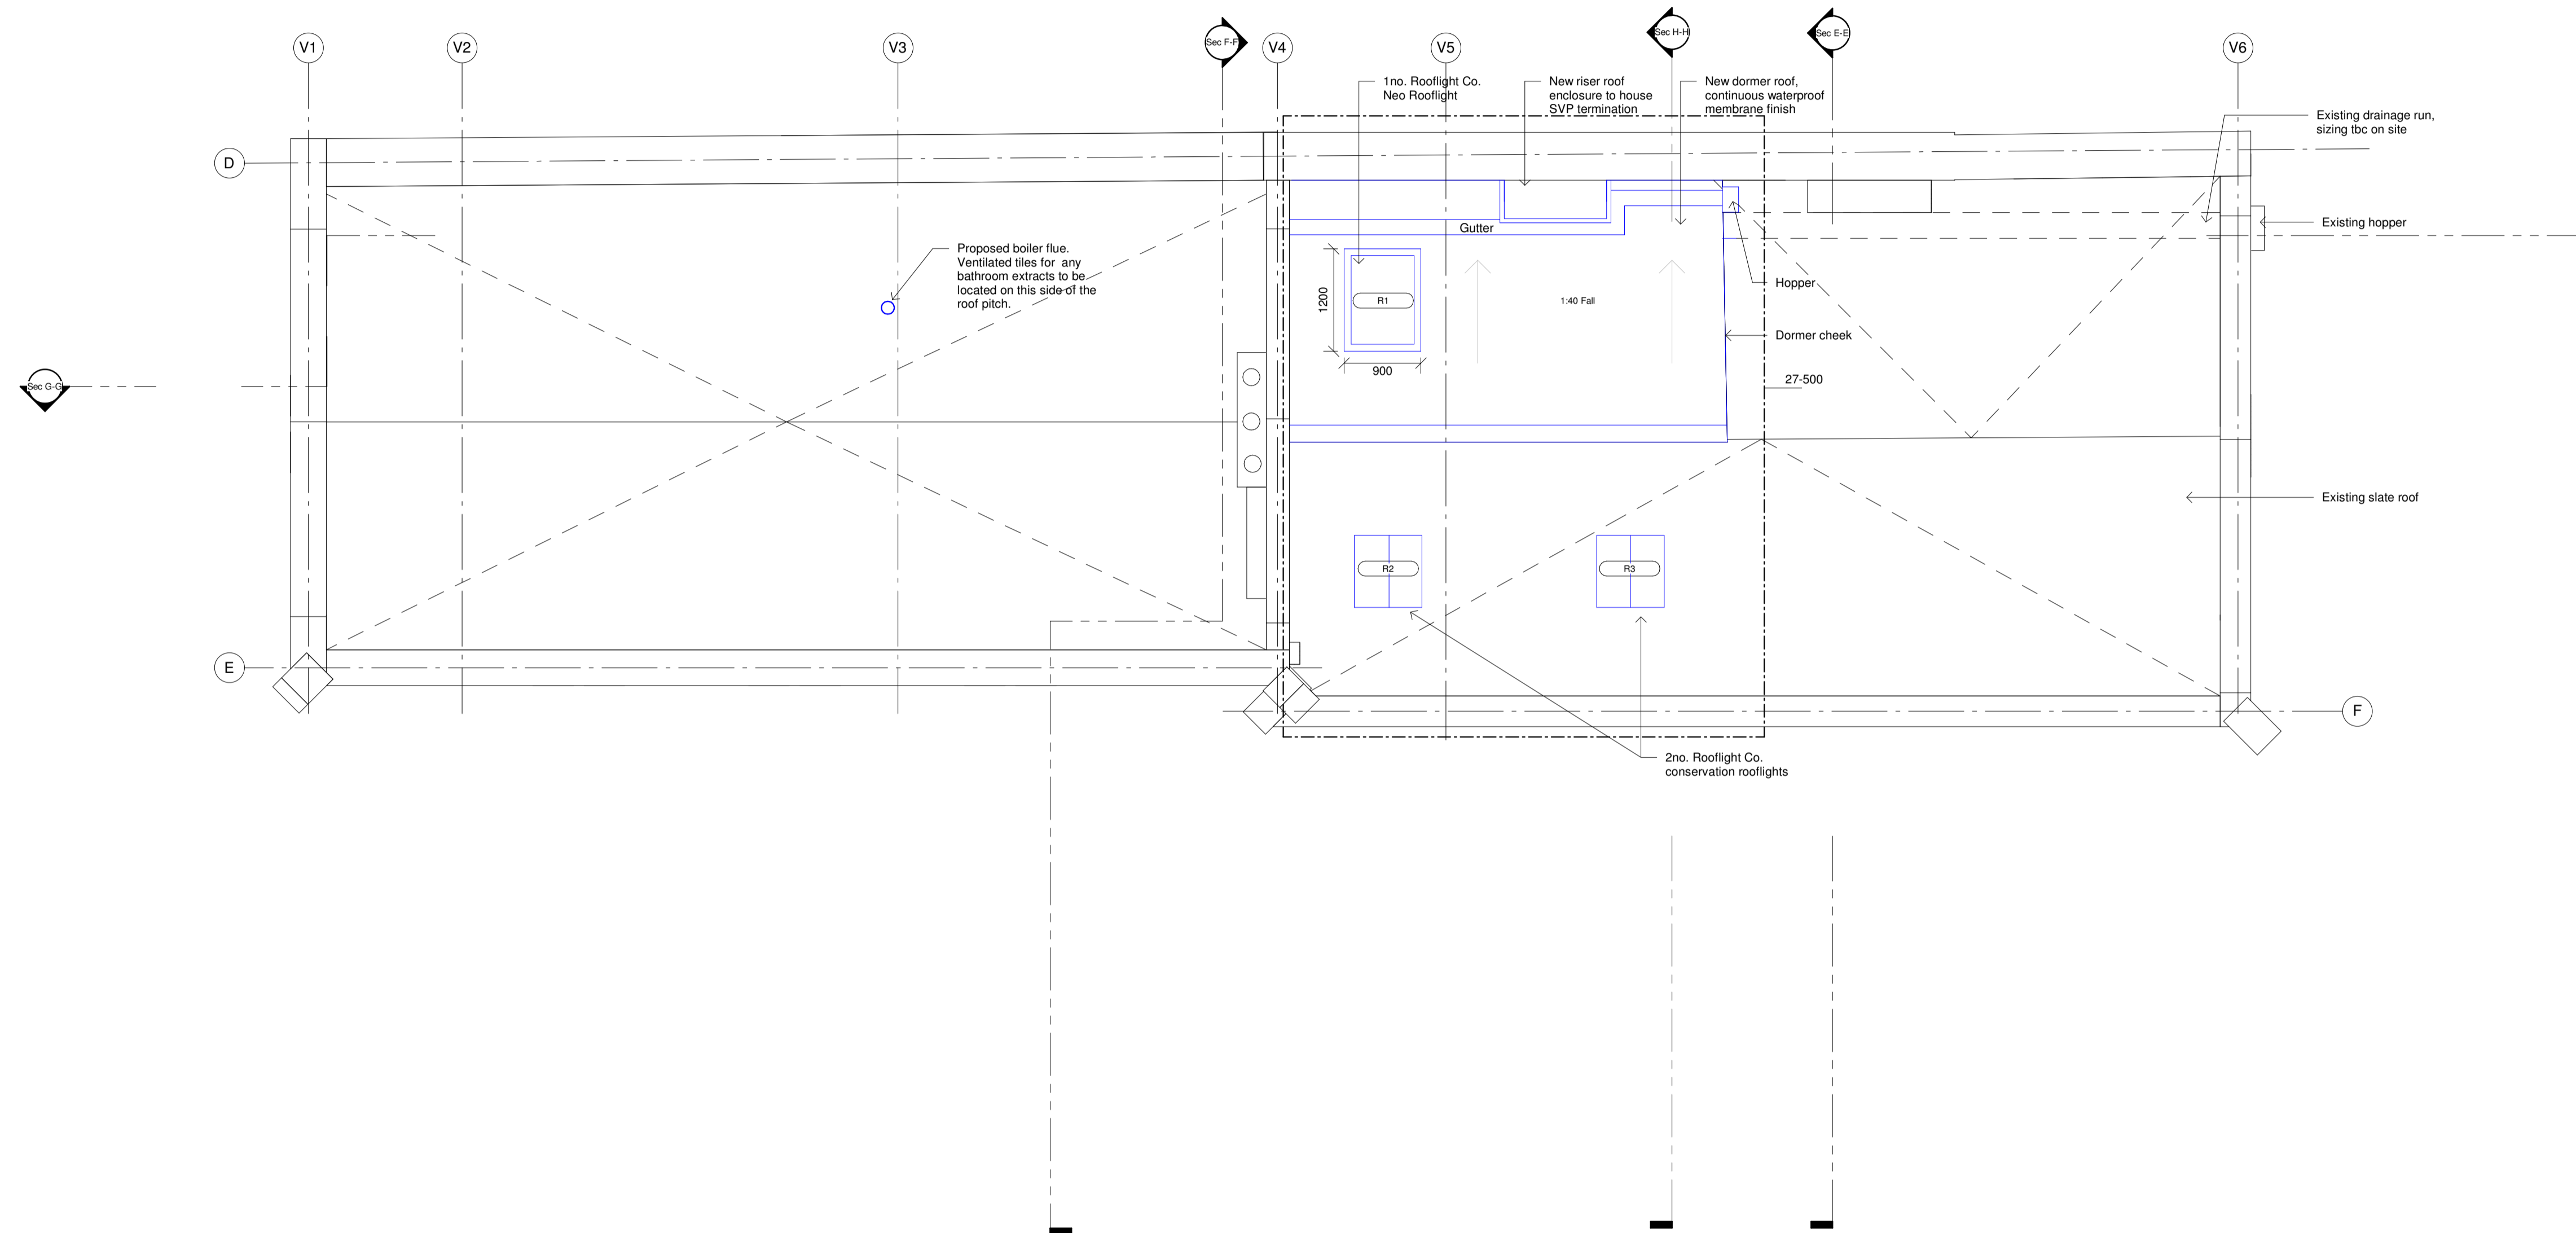

**Building Key**

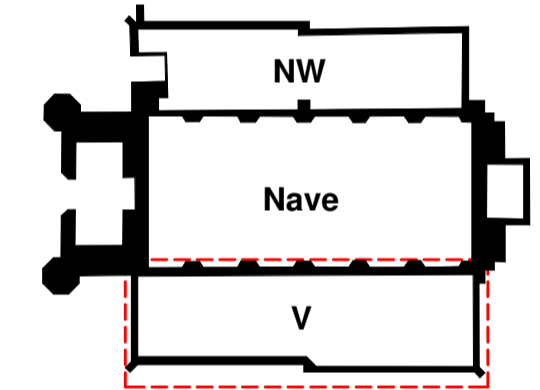

The Danish Church  
 4 St Katharine's Precinct  
 London NW1 4HH

**C.F. Møller**

Telephone House, 69-77 Paul Street  
 London, EC2A 4NW  
 United Kingdom  
 Tel.: +44 020 7427 1530  
 london@cfmoller.com

Europlads 2, 11  
 8000 Aarhus C  
 Denmark  
 Tel.: +45 8730 5300  
 www.cfmoller.com

Rev	Description	By	Chk	Date
B	Planning Condition Discharge	HBA	RN	05.07.19
A	Tender Issue	HBA	RN	08.02.19

**The Danish Church**

Title  
**The Vicarage - Proposed - Roof Plan**

Project No.  
**85331**

Status  
**Stage 4 - TENDER**

Scale @ A1	Date	Revision
1 : 50	08/02/19	B

Drawing Number  
**85331-CFM-20-123**