


OUT OF SCOPE FOR WORKS ON VENTILATION

- 2NO. REFRIGERANT PIPES DROP TO LL TO SERVE CCU (TYPICAL)
- 500mm x 50mm REFRIGERANT PIPEWORK TRAY RUNS AT HL UNDERNEATH THE VENTILATION SERVICES
- CONDENSERS ARE LOCATED AT GROUND FLOOR. REFER TO GROUND FLOOR GA FOR CLARITY
- 500mm x 50mm REFRIGERANT PIPEWORK TRAY RUNS IN THE CEILING VOID
- 500mm x 50mm TRAY AGAINST THE WALL TO ACCOMMODATE REFRIGERANT PIPEWORK AND PROCESSED CHW
- EXTERNAL CONDENSER SERVING CCU TYPICAL SIZE 1050mm (L) x 300mm (W) x 1338mm (H) MOUNTED TYPICALLY ON UNISTRUT FRAME TO EXISTING WALL

NO WORKS TO BE PERFORMED IN THE HATCHED AREA, THE EXISTING SYSTEM REQUIRES TO BE MAINTAINED AND TO BE KEPT ACTIVE THROUGHOUT THE ENTIRE LENGTH OF THE CONTRACT.

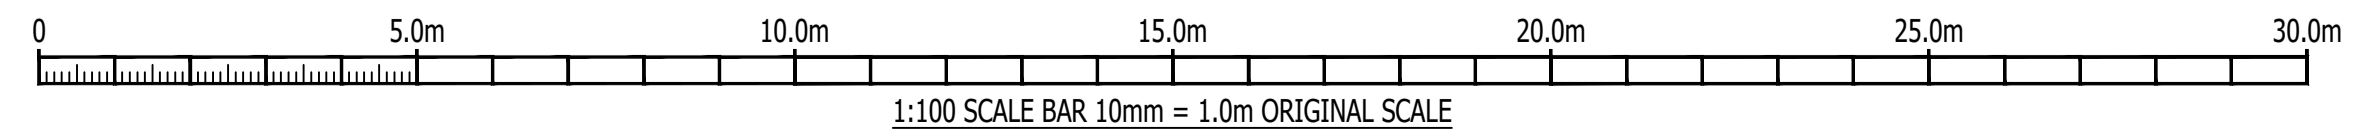

- NOTES**
1. DO NOT SCALE FROM THIS DRAWING.
 2. THE CONTRACTOR MUST VERIFY ALL DIMENSIONS TOLERANCES AND REFERENCES BEFORE PROCEEDING WITH WORKS.
 3. ANY DISCREPANCY FOUND BETWEEN THIS DRAWING AND ANY OTHER DOCUMENTS MUST BE REPORTED IMMEDIATELY TO THE CONTRACT ADMINISTRATOR.
 4. REMOVE THIS DRAWING FROM CURRENCY WHEN REVISED DRAWING IS ISSUED.
 5. COPYRIGHT OF DESIGNS SHOWN ON THIS DRAWING REMAINS WITH ELEMENTA CONSULTING LTD.
 6. THIS DRAWING IS TO BE READ IN CONJUNCTION WITH THE SPECIFICATION AND ALL OTHER CONTRACT PROJECT DOCUMENTS.
 7. THE CONTRACTOR SHALL REFER TO ARCHITECTS OR INTERIOR DESIGN DRAWINGS INCLUDING REFLECTED CEILING PLANS AND OTHER SPECIALIST DRAWINGS FOR SETTING OUT ALL VISIBLE AND CEILING MOUNTED EQUIPMENT.

A1 ORIGINAL SIZE DRAWING			
T01	TENDER ISSUE	RT	01.07.19
P01	STAGE 3 COSTING ISSUE	RT	21.06.19
P01	PRELIMINARY	RT	03.06.19
No.	REVISION	CHK	DATE

Elementa Consulting Ltd
 80 Cheapside
 London
 EC2V 6EE
elementa
 Member of Integral Group
 t: +44(0)203 6979300
 f: +44(0)203 6979301
 www.elementaconsulting.com

CLIENT
UNIVERSITY COLLEGE LONDON

PROJECT
UCL BEAMS

TITLE
LOWER GROUND FLOOR SPACE COOLING LAYOUT

DATE	MAY '19	SCALE	1:100 @ A1
DESIGNED	MP	CHECKED	RT
		APPROVED	SE

SUITABILITY CODE: D2
SUITABILITY DESCRIPTION: ISSUED FOR TENDER

DRAWING STATUS	TENDER	
DRAWING No.	510120-ELE-XX-LG-DR-MX-55001	REVISION
		T01