

- NOTES**
- DO NOT SCALE FROM THIS DRAWING.
 - THE CONTRACTOR MUST VERIFY ALL DIMENSIONS TOLERANCES AND REFERENCES BEFORE PROCEEDING WITH WORKS.
 - ANY DISCREPANCY FOUND BETWEEN THIS DRAWING AND ANY OTHER DOCUMENTS MUST BE REPORTED IMMEDIATELY TO THE CONTRACT ADMINISTRATOR.
 - REMOVE THIS DRAWING FROM CURRENCY WHEN REVISED DRAWING IS ISSUED.
 - COPYRIGHT OF DESIGNS SHOWN ON THIS DRAWING REMAINS WITH ELEMENTA CONSULTING LTD.
 - THIS DRAWING IS TO BE READ IN CONJUNCTION WITH THE SPECIFICATION AND ALL OTHER CONTRACT PROJECT DOCUMENTS.
 - THE CONTRACTOR SHALL REFER TO ARCHITECTS OR INTERIOR DESIGN DRAWINGS INCLUDING REFLECTED CEILING PLANS AND OTHER SPECIALIST DRAWINGS FOR SETTING OUT ALL VISIBLE AND CEILING MOUNTED EQUIPMENT.


CONDENSER SERVING AHU DX COIL
TYPICAL SIZE 1050mm (L) x 300mm (W) x 1338mm (H)

REFRIGERANT PIPEWORK RUNS AT LOW LEVEL

FLOOR MOUNTED AHU WITH HEPA FILTER
4280mm (L) x 930mm (W) x 1750mm (H) (INCLUDING STEEL BASE AND 150mm ANTI-VIBRATION MOUNTS)
CONTRACTOR TO SEPARATE AIR STREAMS

700x350 SUPPLY & EXTRACT DUCTS FROM LOW LEVEL TO HIGH LEVEL BELOW.
FOR CONTINUATION OF SERVICES REFER TO DRAWING NUMBER 510120-ELE-XX-LG-DR-MX-57001

FOR MECHANICAL SERVICES REFER TO DRAWING NUMBER 510120-ELE-XX-GF-DR-ME-51001

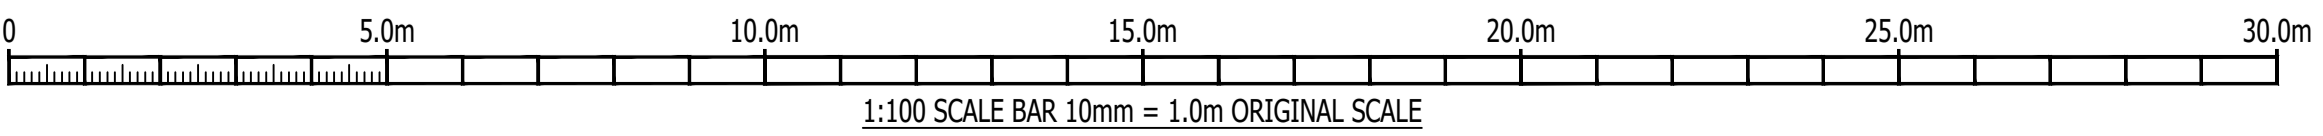

A1 ORIGINAL SIZE DRAWING

T01	TENDER ISSUE	RT	01.07.19
P03	STAGE 3 COSTING ISSUE	RT	21.06.19
P02	PRELIMINARY ISSUE	RT	05.06.19
P01	PRELIMINARY ISSUE	RT	03.06.19

No.	REVISION	CHK	DATE
<p>Elementa Consulting Ltd 80 Cheapside London EC2V 6EE</p> <p>elementa Member of Integral Group</p> <p>t: +44(0)203 6979300 f: +44(0)203 6979301 www.elementaconsulting.com</p>			

CLIENT
UNIVERSITY COLLEGE LONDON

PROJECT
UCL BEAMS

TITLE
GROUND FLOOR VENTILATION LAYOUT

DATE: MAY '19 SCALE: 1:100 @ A1

DESIGNED: MP CHECKED: RT APPROVED: SE

SUITABILITY CODE: D2 SUITABILITY DESCRIPTION: ISSUED FOR TENDER

DRAWING STATUS: TENDER

DRAWING No: 510120-ELE-XX-GF-DR-MX-57001 REVISION: T01