

DO NOT SCALE - IF IN DOUBT ASK




CLEARWATER COURT  
VASTERN ROAD  
READING  
RG1 8DB

**NOTES**  
1. ALL DIMENSIONS IN MILLIMETRES AND ALL LEVELS IN METRES UNLESS SHOWN OTHERWISE.

**REFERENCES**  
H582\_01-A1-AB-00604 DETAILS OF PIPELINE AT CROSSING POINT WITH GLOUCESTER GATE RAILINGS  
H582\_01-A1-AB-23022 PIPELINE PLAN AND PROFILE SHEET 2 OF 11

**LEGEND**  
— NEW PIPELINE ROUTE  
[Red Box] APPLICATION SITE

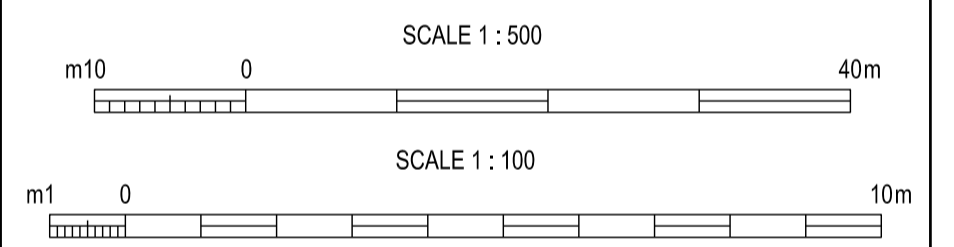

**CURRENT VERSION INFORMATION**

Iss	Description	Dsgnr	Chkd	Appd	Date
A	FOR INFORMATION	SSJ	PJ	KM	31.10.18



**Thames Water Utilities**  
Clearwater Court  
Vastern Road, Reading RG1 8DB

Location Code: N/A	OS Reference: TQ2883	Security Reference: UBR	Drawn By: SDB
Project Group: EIGHT20	Sub Process: N/A		
Location / Town: EUSTON, LONDON			
Site Name: GLOUCESTER GATE			
Project Name: EUSTON 42 INCH TRUNK MAIN DIVERSION (PHASE 1)			
Contract Name: EIGHT20			
Drawing Title: PLAN AND ELEVATIONS AT CROSSING POINT WITH EXISTING GLOUCESTER GATE RAILINGS			
Drawing No.: H582_01-A1-AB-00605	Scale: AS SHOWN	Sheet Size: A1	Rev: A