


LEGEND

AV	AIR VENT	MK(E)	ELECTRIC SERVICE MARKER
B	BOLLARD	MK(G)	GAS SERVICE MARKER
BB	BELISHA BEACON	MK(W)	WATER SERVICE MARKER
BH	BORE HOLE	CHW	OVERHEAD WIRE
BL	BASE/BED LEVEL	OSBM	ORDNANCE SURVEY BENCH MARK
BP	BRICK PILLAR	P	POST
BS	BUS STOP	PT	POST OFFICE TELEGRAPH
C	SEWER (COMBINED)	PB	POST BOX
CAJB	CABLE JUNCTION BOX	RP	ROOFTOP POINT
CATV	CABLE INSPECTION COVER	RNP	ROAD NAME PLATE
CIP	CABLE INSPECTION POINT	RS	ROAD SIGN
CD	CABLE DUCT	RW	RETAINING WALL
CL	COVER LEVEL	RWP	RAIN WATER PIPE
CP	CHARGING POINT - ELEC CAR	S	SEWER (STORM)
D	DRAIN	SAP	SAPLING
DPC	DAMP PROOF COURSE	SC	STOP COCK
DK	DROP KERB	SC(G)	STOP COCK (GAS)
EB	ELECTRICITY BOX	SC(W)	STOP COCK (WATER)
EIC	ELECTRICITY INSPECTION COVER	SP	SIGN POST
EP	ELECTRICITY POLE	SEG	SIDE ENTRY GULLY
ER	EARTHING ROD	STM	SURVEY STATION
F	FLOWER BED	STP	SUPPORT FOR TELEPHONE POLE
FH	FIRE HYDRANT	SV	STOP VALVE
FL	FLOOR LEVEL	SVP	SOIL VENT PIPE
G	GULLY	TBM	TEMPORARY BENCH MARK
GIC	GAS INSPECTION COVER	TCS	TELEPHONE CALL BOX
GJB	GAS JUNCTION BOX	TH	TRIAL HOLE
GV	GAS VENT	THL	THRESHOLD LEVEL
IC	INSPECTION COVER	TIC	TELECOM INSPECTION COVER
IL	INVERT LEVEL	TP	TELEGRAPH POLE
JB	JUNCTION BOX	TOB	TOP OF BUILDING
LB	LITTER BIN	TOP	TOP OF FENCE
LP	LAMP POST	TOW	TOP OF WALL
MH	MANHOLE	TS	TREE STUMP
MK	SERVICE MARKER	UTL	UNABLE TO LIFT
		VP	VENT PIPE
		WL	WATER LEVEL
		WM	WATER METER
		WO	WASH OUT

TYPE
TRUNK GIRTH / SPREAD DIAMETER
HEIGHT

TREE

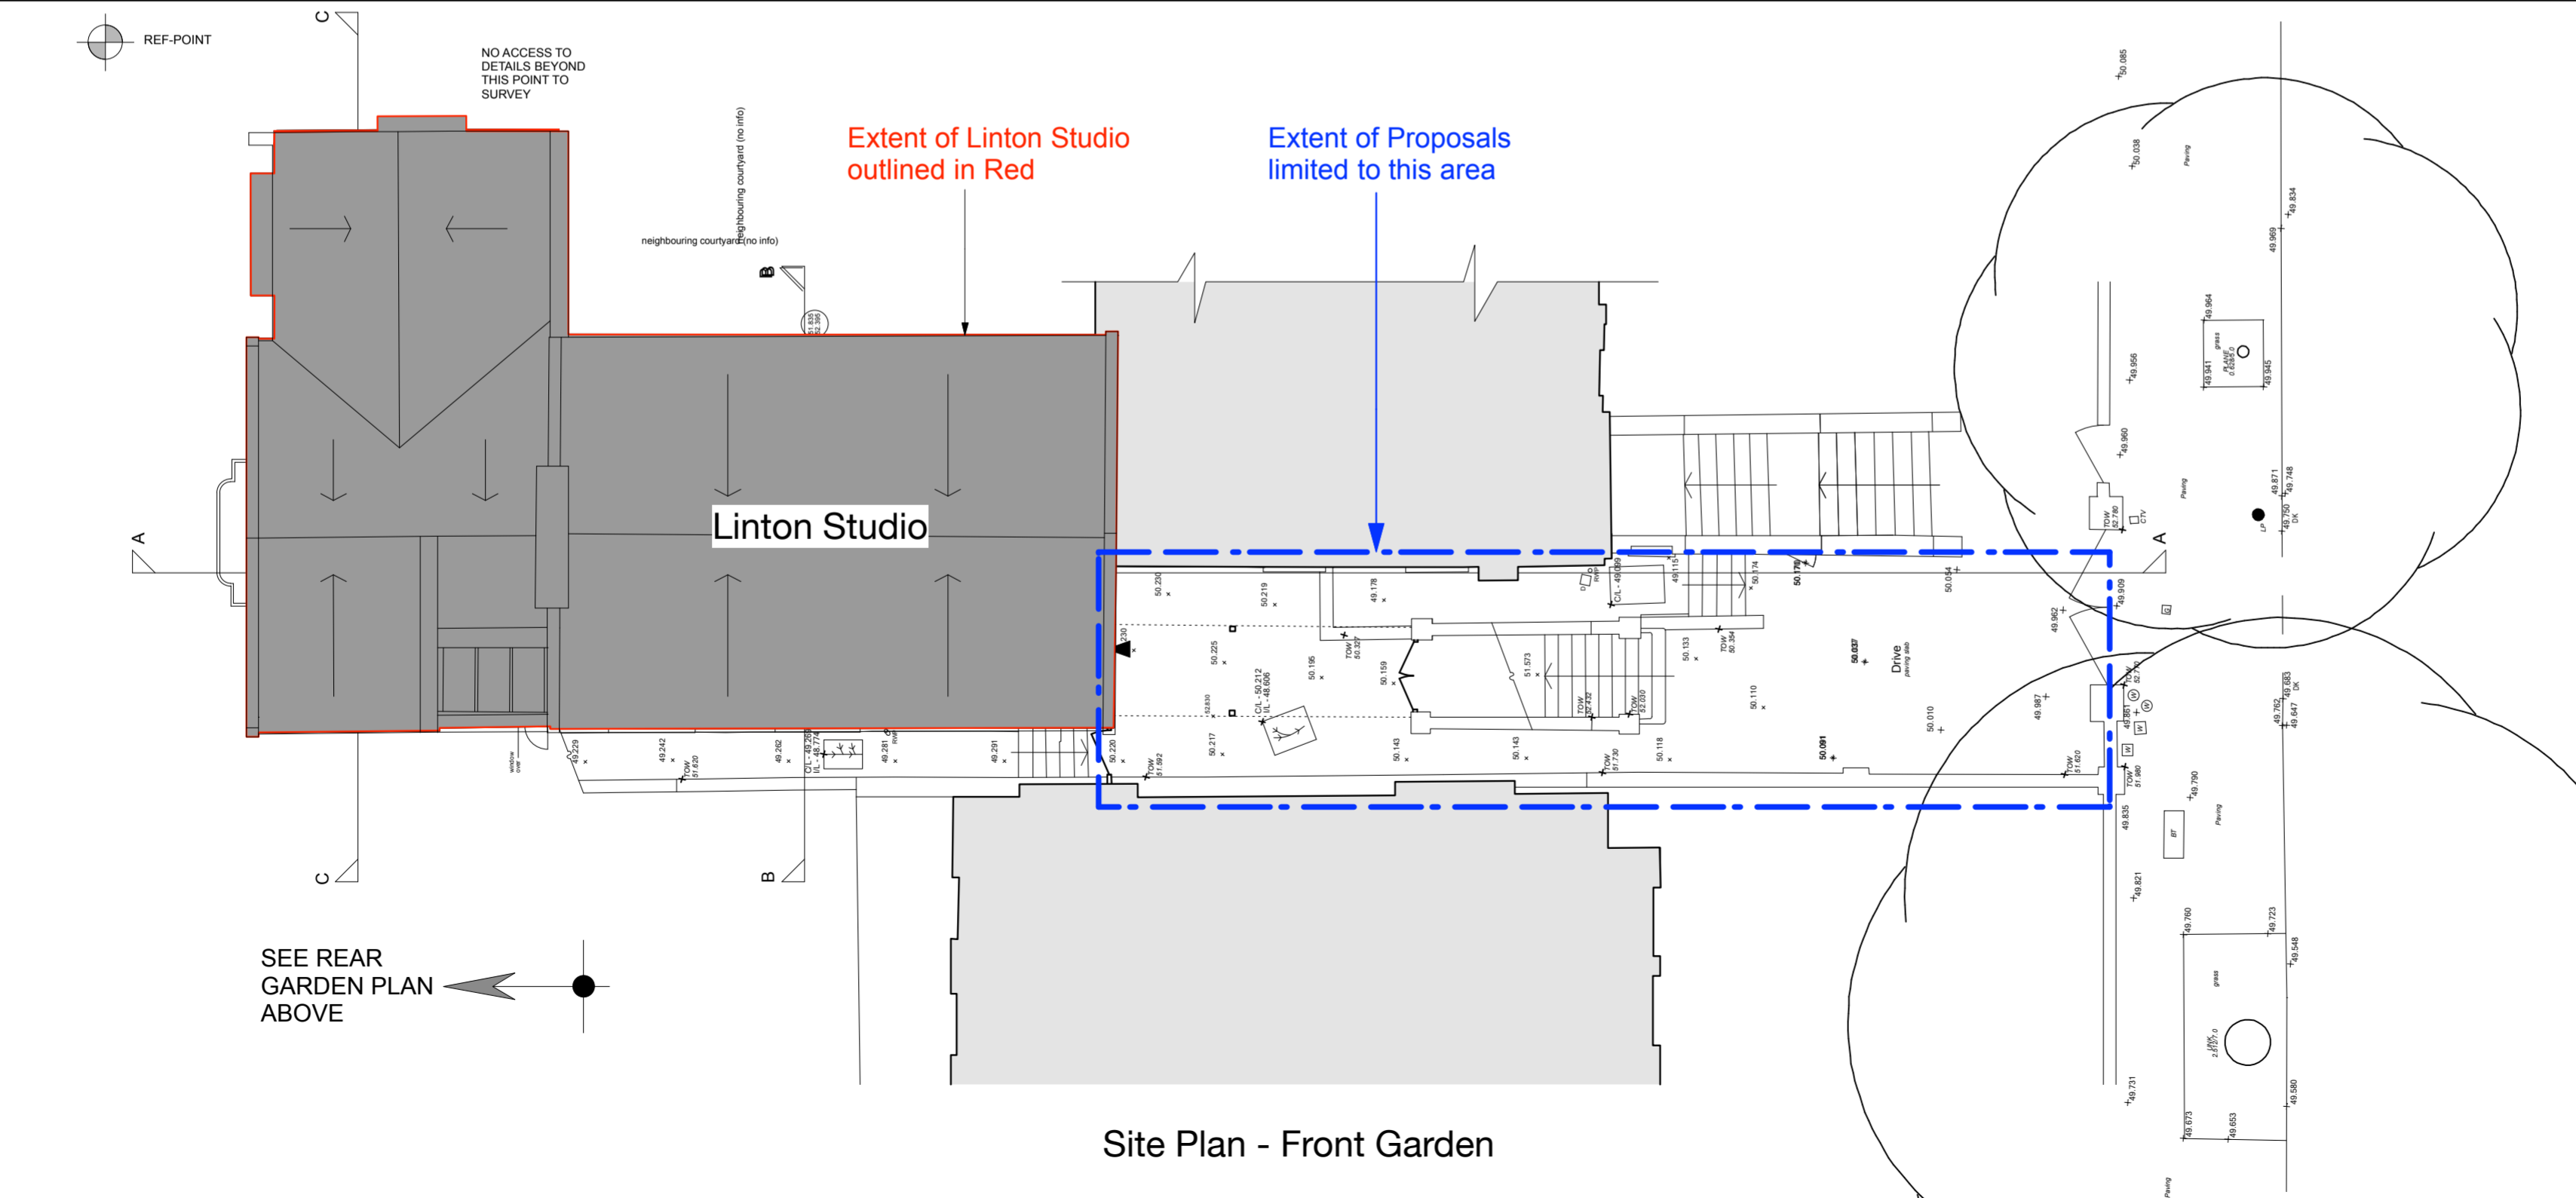

cad surveys

www.cadsurveys.co.uk

Project :
Linton Studio, 35 Steele's Road
London NW3 4RG

Drawing title:
Existing Site Plans

Drawing Ref:
1076-S2-01

Scale: 1:100 @ A2

Date : 25/08/2017

Drawn by : CW

CAD Surveys Ltd.
Suite 2 KPC House
Canterbury Road
Willesborough
Ashford
TN24 0BP
01233 635089