

©COPYRIGHT 2016 WARNER WONG PTE LTD | WOW ARCHITECTS PTE LTD. DRAWINGS AND SAMPLES PROPERTY OF WARNERWONG PTE LTD | WOW ARCHITECTS PTE LTD. NOT FOR CONSTRUCTION. ALL INFORMATION CONTAINED HEREIN IS FOR DESIGN PURPOSES ONLY. ALL DIMENSIONS TO BE CONFIRMED ON SITE PRIOR TO COMMENCEMENT OF WORK. ALL DISCREPANCIES TO BE REFERRED TO THE CONSULTANT FOR CLARIFICATION PRIOR TO EXECUTION. NO STRUCTURAL CHANGES TO BE CARRIED OUT WITHOUT PRIOR CONSENT FROM STRUCTURAL CONSULTANT AND STATUTORY

**DRAWN**  
RYM  
**DATE**  
20-Jun-19  
06-Aug-19

**CHECKED**  
AP  
**PURPOSE OF SUBMISSION**  
FOR COORDINATION  
REVISION 1

**LEGEND**

**HCL LONDON RESIDENCE**  
LONDON, UNITED KINGDOM





**CONSTRUCTION DRAWINGS**  
SCALE 1:50

FOR CONSTRUCTION  
**WARNER WONG**  
DESIGN  
OCTOBER 2018  
Date of Issue

**WOW**

WARNER WONG DESIGN

HLR-CD-I-EI-REV1

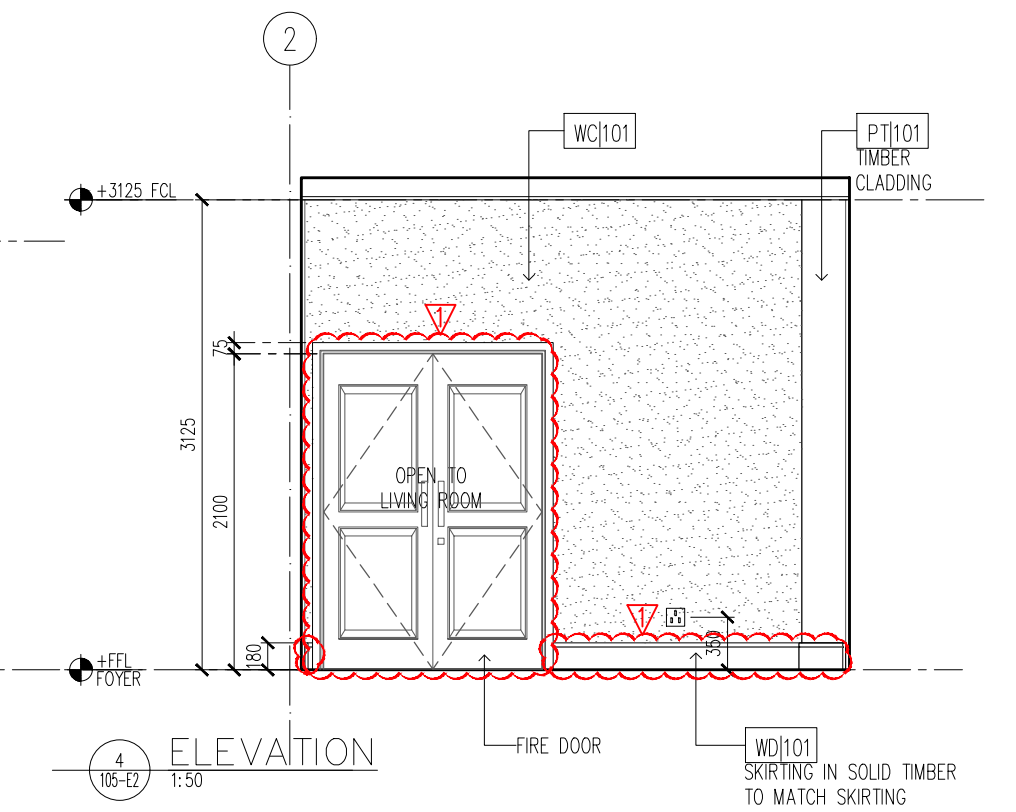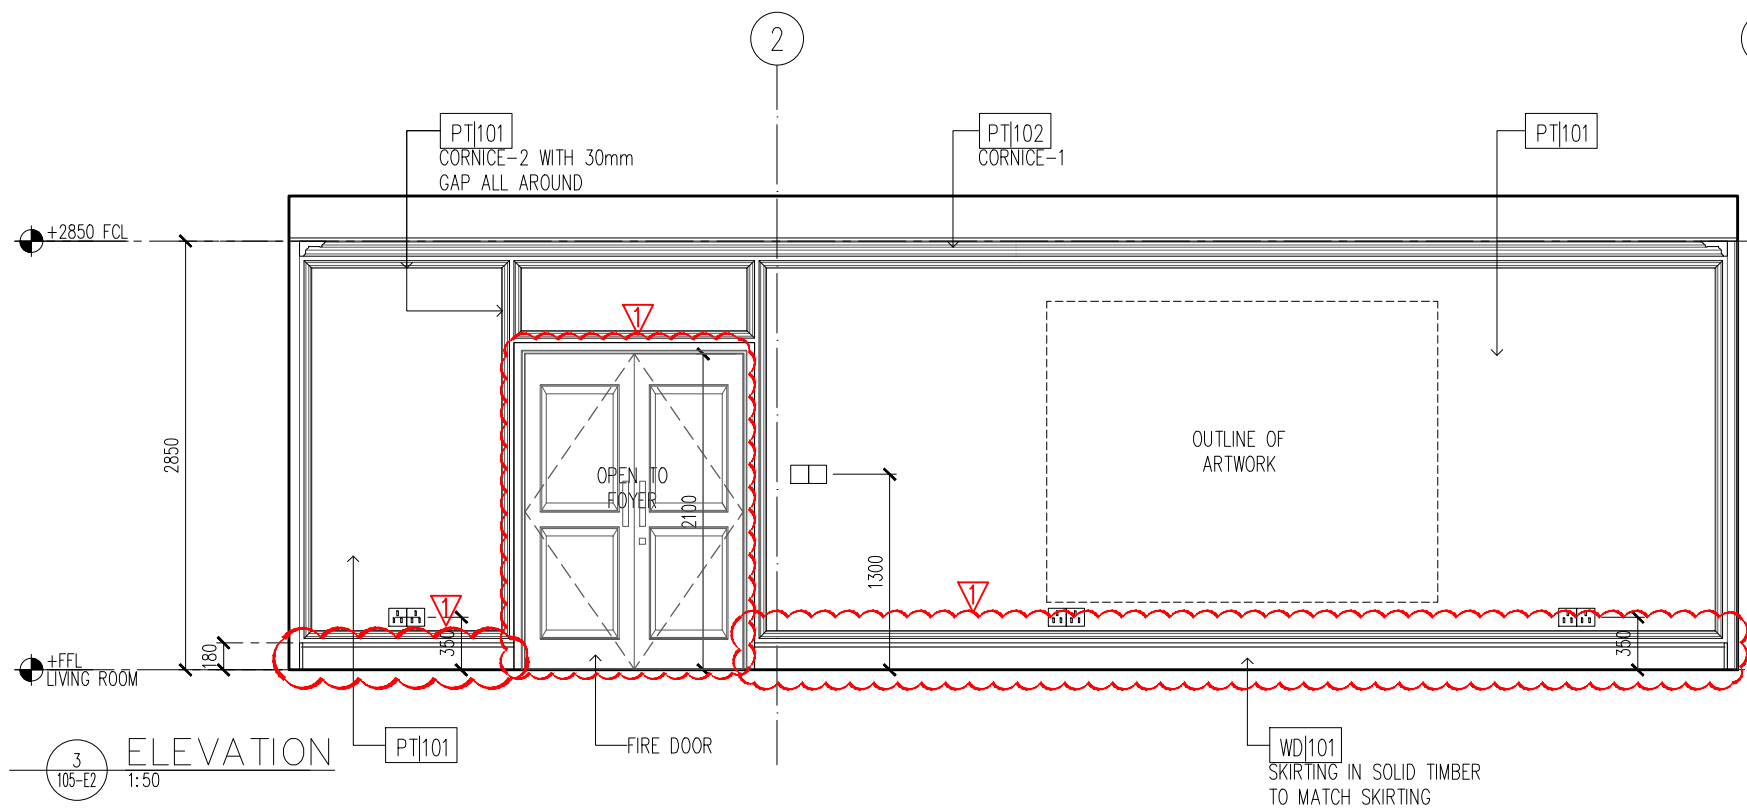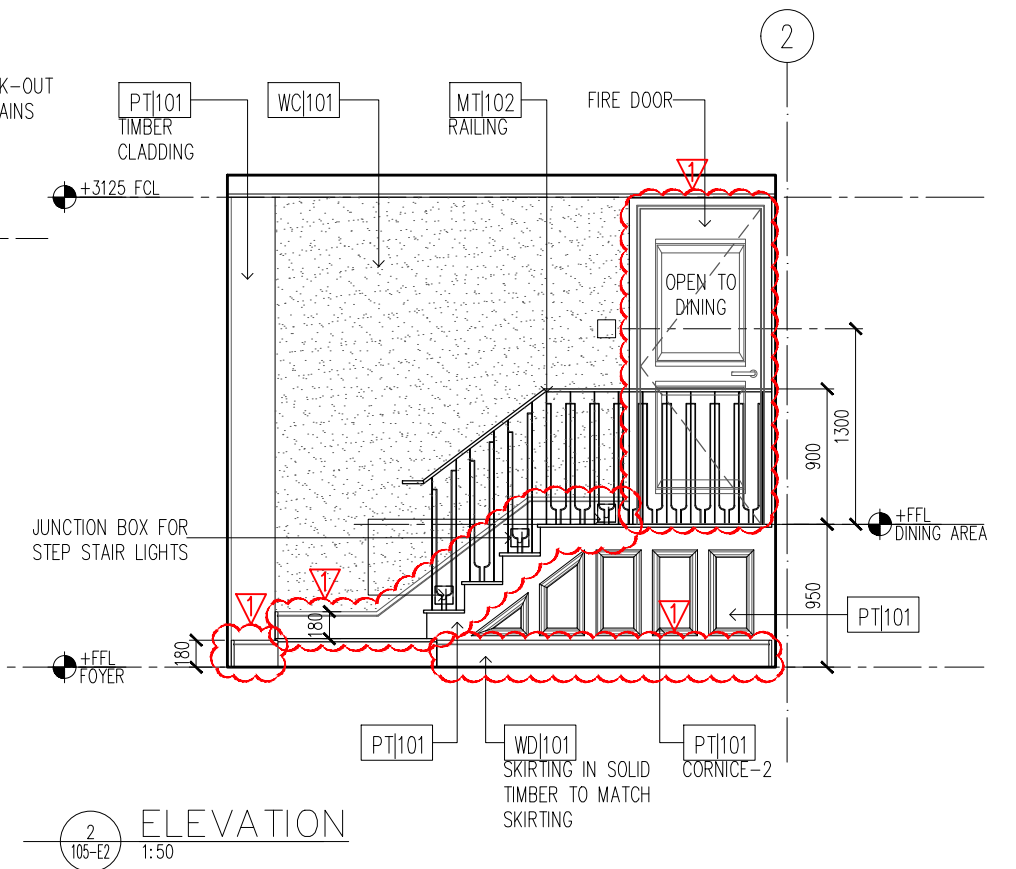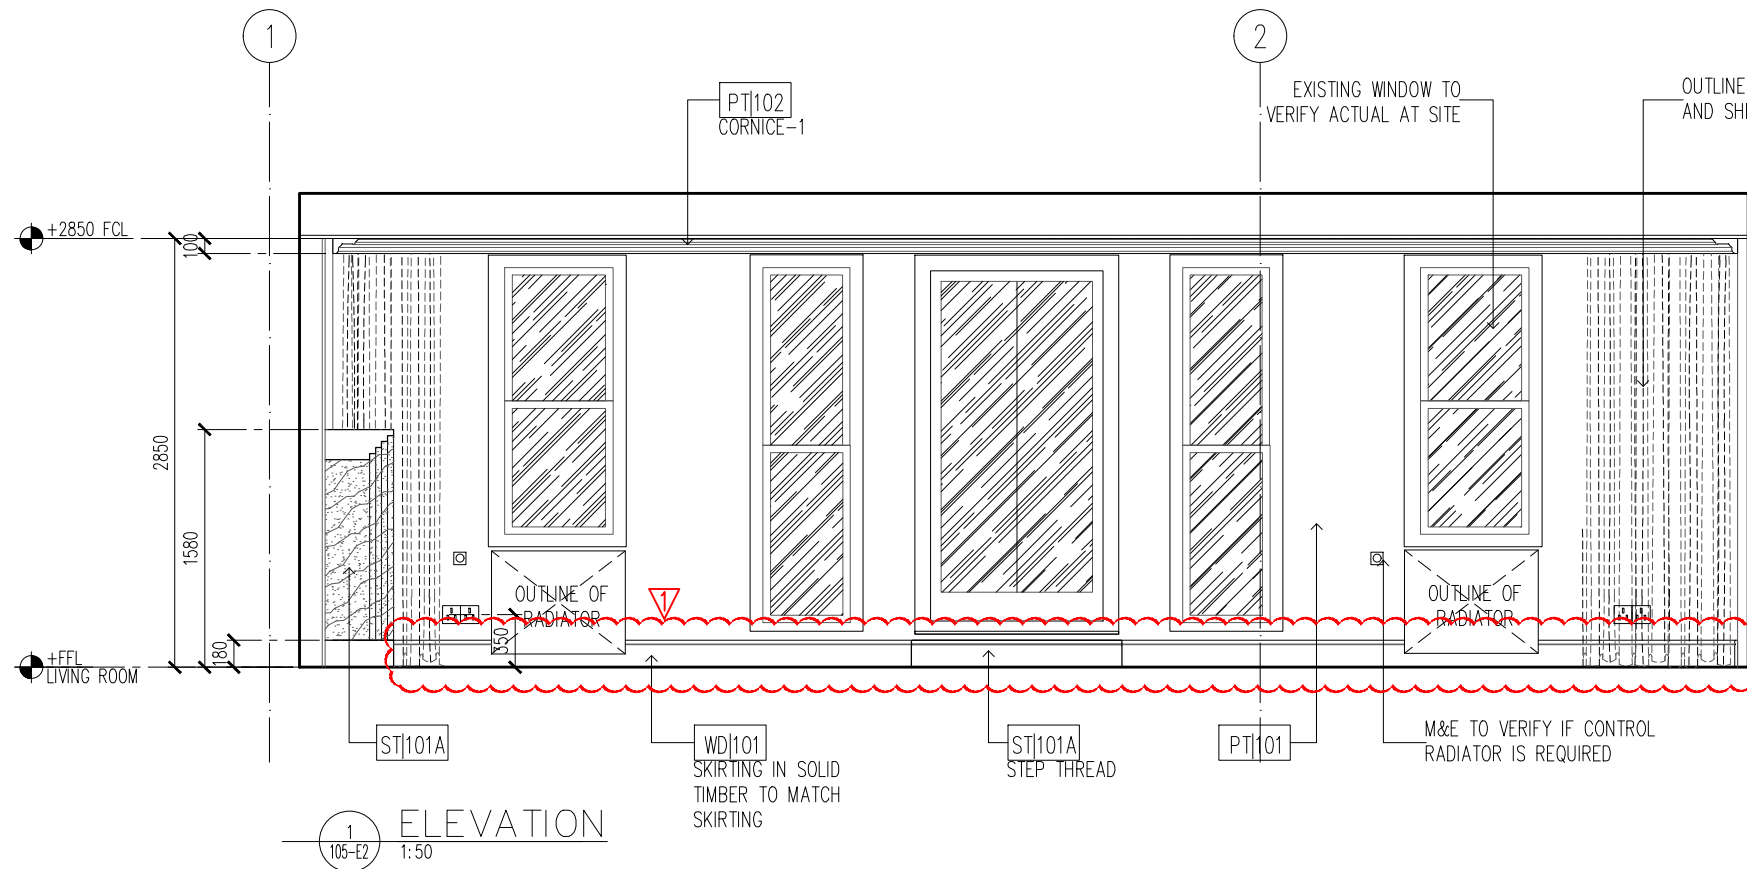

© COPYRIGHT 2014 WARNER WONG PTE LTD | WOW ARCHITECTS PTE LTD. DRAWINGS AND SAMPLES PROPERTY OF WARNER WONG PTE LTD | WOW ARCHITECTS PTE LTD. NOT FOR CONSTRUCTION. ALL INFORMATION CONTAINED HEREIN IS FOR DESIGN PURPOSES ONLY. ALL DIMENSIONS TO BE CONFIRMED ON SITE PRIOR TO COMMENCEMENT OF WORK. ALL DISCREPANCIES TO BE REFERRED TO THE CONSULTANT FOR CLARIFICATION PRIOR TO EXECUTION. NO STRUCTURAL CHANGES TO BE CARRIED OUT WITHOUT PRIOR CONSENT FROM STRUCTURAL CONSULTANT AND STATUTORY

**DRAWN**  
RYM  
**DATE**  
20-Jun-19  
06-Aug-19

**CHECKED**  
AP  
**PURPOSE OF SUBMISSION**  
FOR COORDINATION  
REVISION 1

**LEGEND**

**HCL LONDON RESIDENCE**  
LONDON, UNITED KINGDOM



**CONSTRUCTION DRAWINGS**  
SCALE 1:50

FOR CONSTRUCTION  
WARNER WONG  
DESIGN  
OCTOBER 2018  
Date of Issue

HLR-CD-I-E2-REV1

**WOW**

WARNER WONG ARCHITECTS

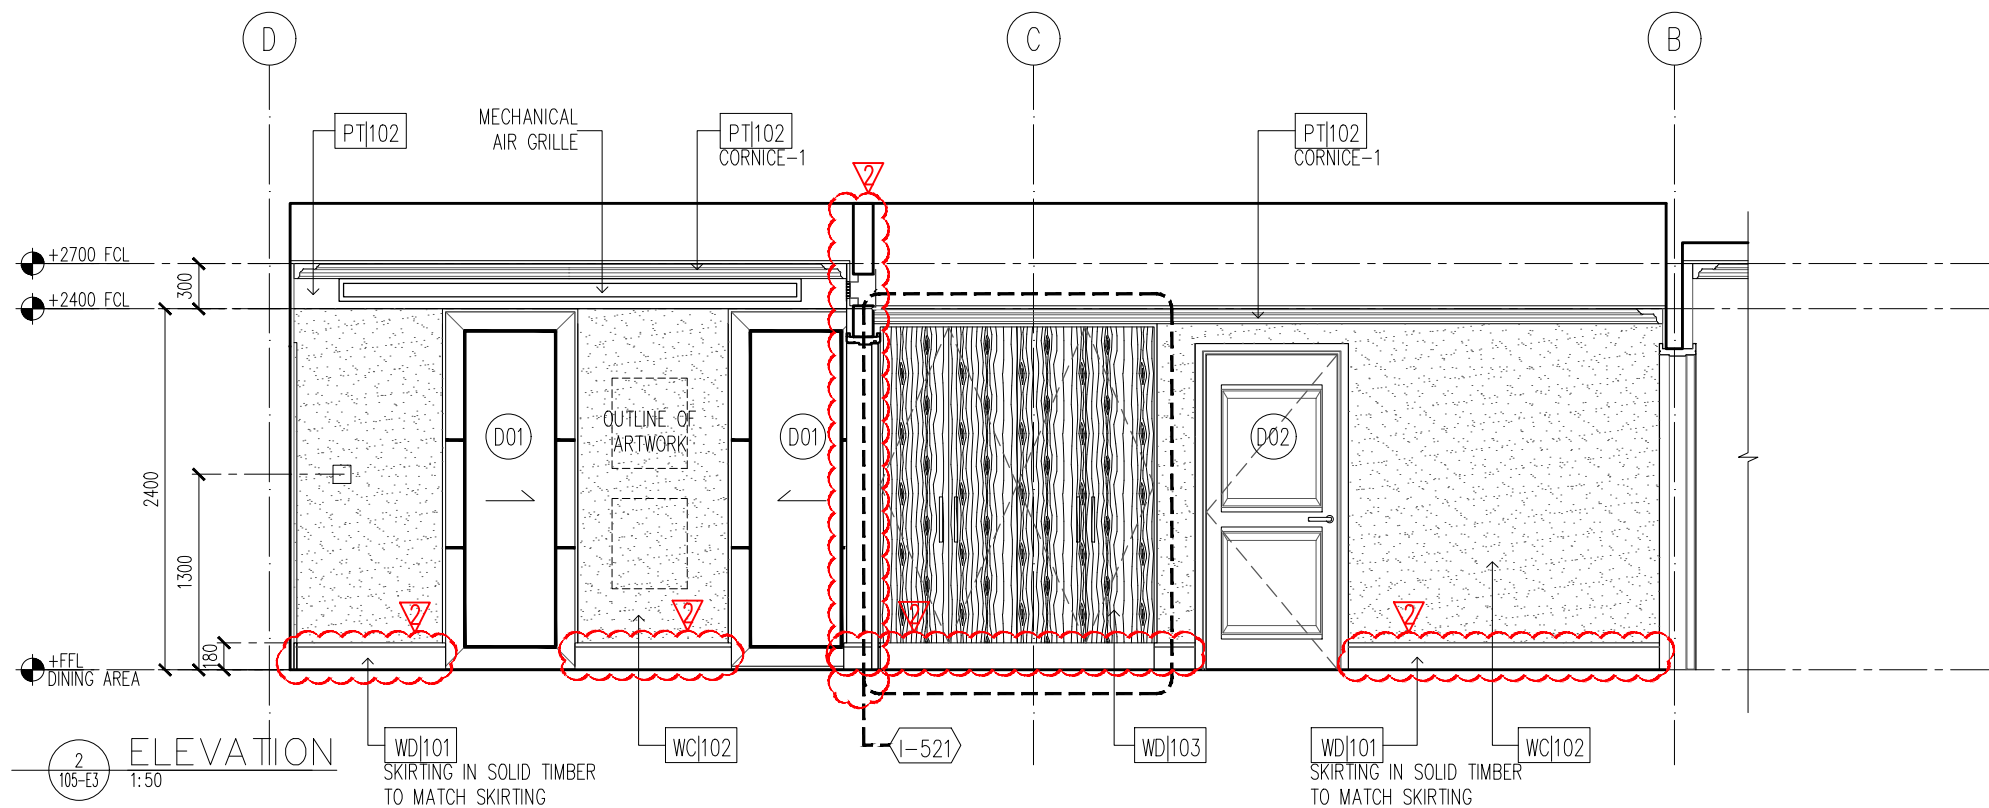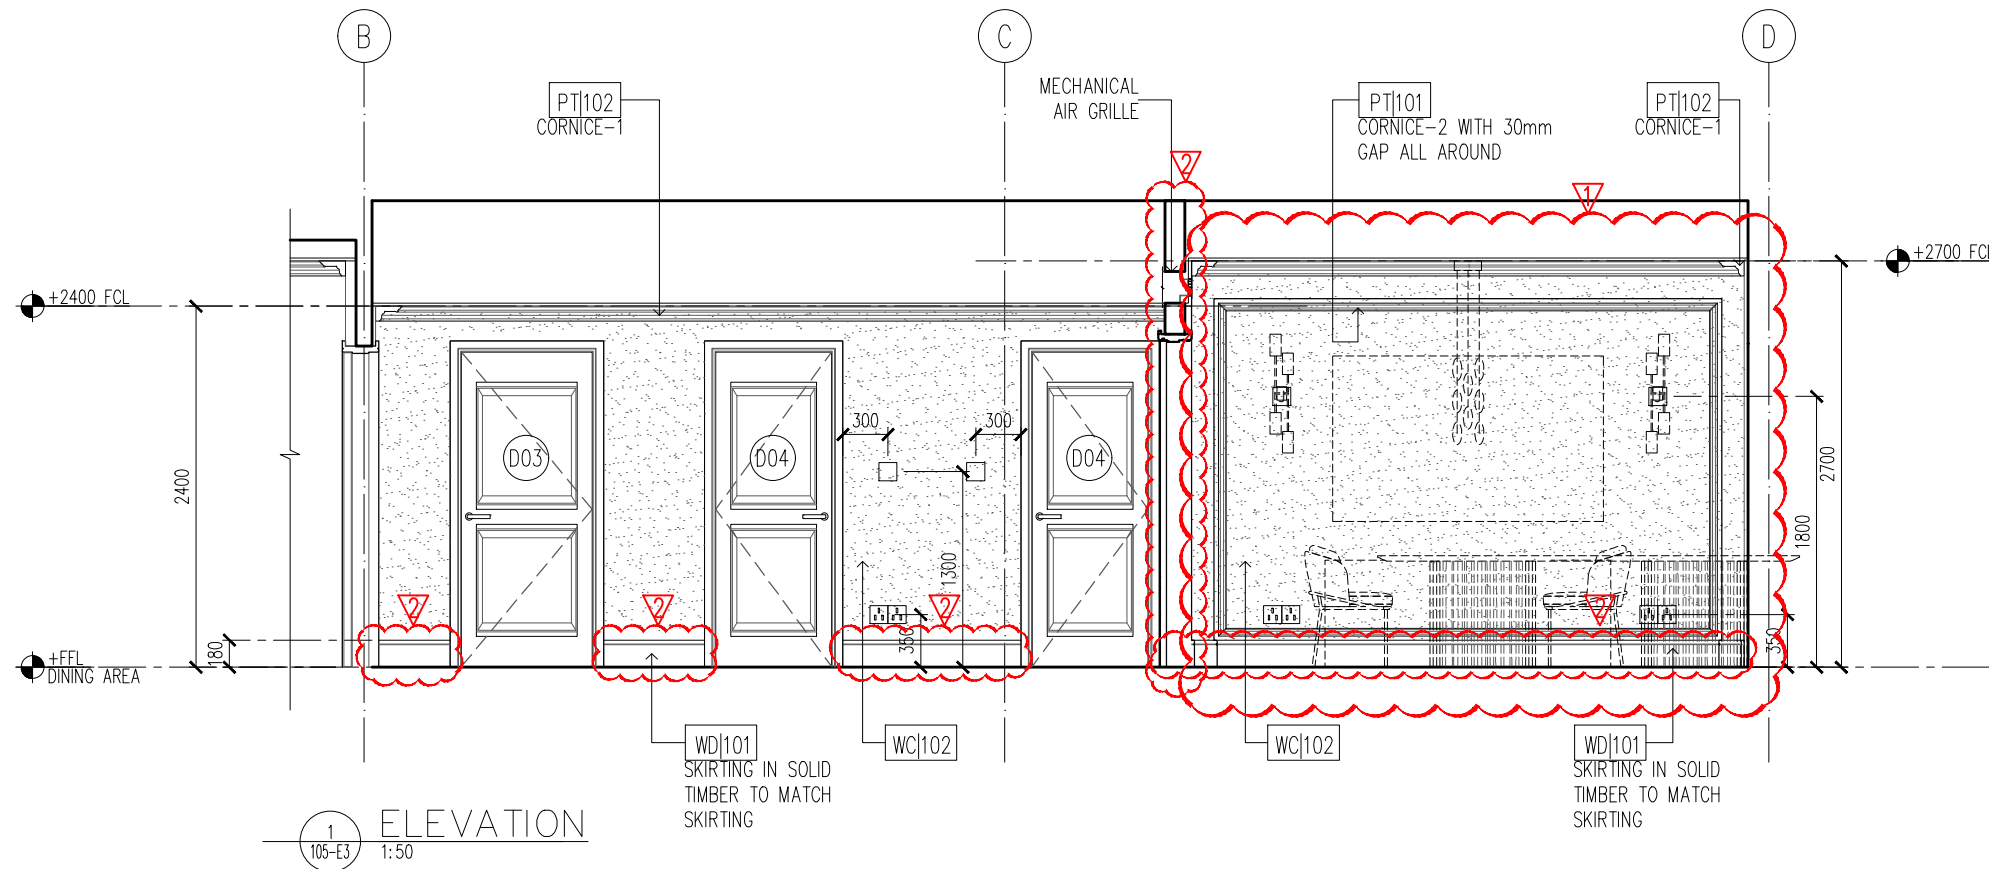

©COPYRIGHT 2019 WARNER WONG PTE LTD | WOW ARCHITECTS PTE LTD. DRAWINGS AND SAMPLES PROPERTY OF WARNERWONG PTE LTD | WOW ARCHITECTS PTE LTD. NOT FOR CONSTRUCTION. ALL INFORMATION CONTAINED HEREIN IS FOR DESIGN PURPOSES ONLY. ALL DIMENSIONS TO BE CONFIRMED ON SITE PRIOR TO COMMENCEMENT OF WORK. ALL DISCREPANCIES TO BE REFERRED TO THE CONSULTANT FOR CLARIFICATION PRIOR TO EXECUTION. NO STRUCTURAL CHANGES TO BE CARRIED OUT WITHOUT PRIOR CONSENT FROM STRUCTURAL CONSULTANT AND STATUTORY AUTHORITIES.

**DRAWN**  
RYM  
**DATE**  
16-Jul-19  
06-Aug-19

**CHECKED**  
AP  
**PURPOSE OF SUBMISSION**  
REVISION 1  
REVISION 2

**LEGEND**

**HCL LONDON RESIDENCE**  
LONDON, UNITED KINGDOM



**CONSTRUCTION**  
SCALE 1:50

FOR COORDINATION  
WARNER WONG  
DESIGN  
16\_JULY\_2019  
Date of Issue

HLR-CD-I-E3-REV2

**WOW**

WOW ARCHITECTS

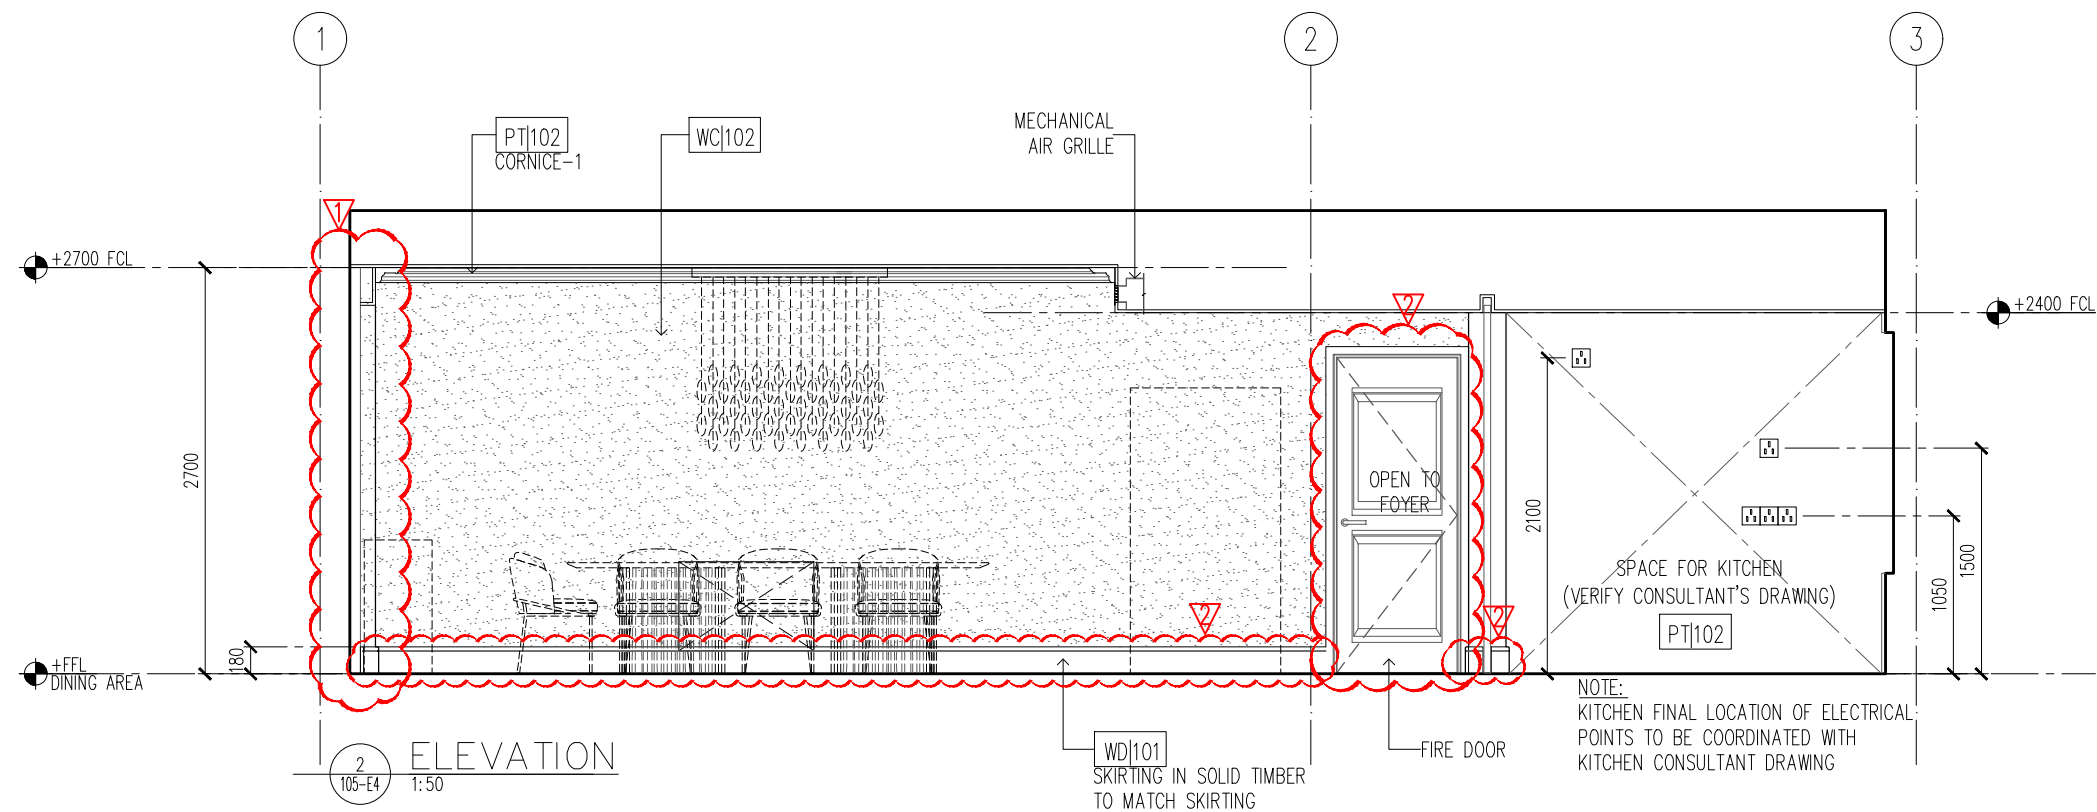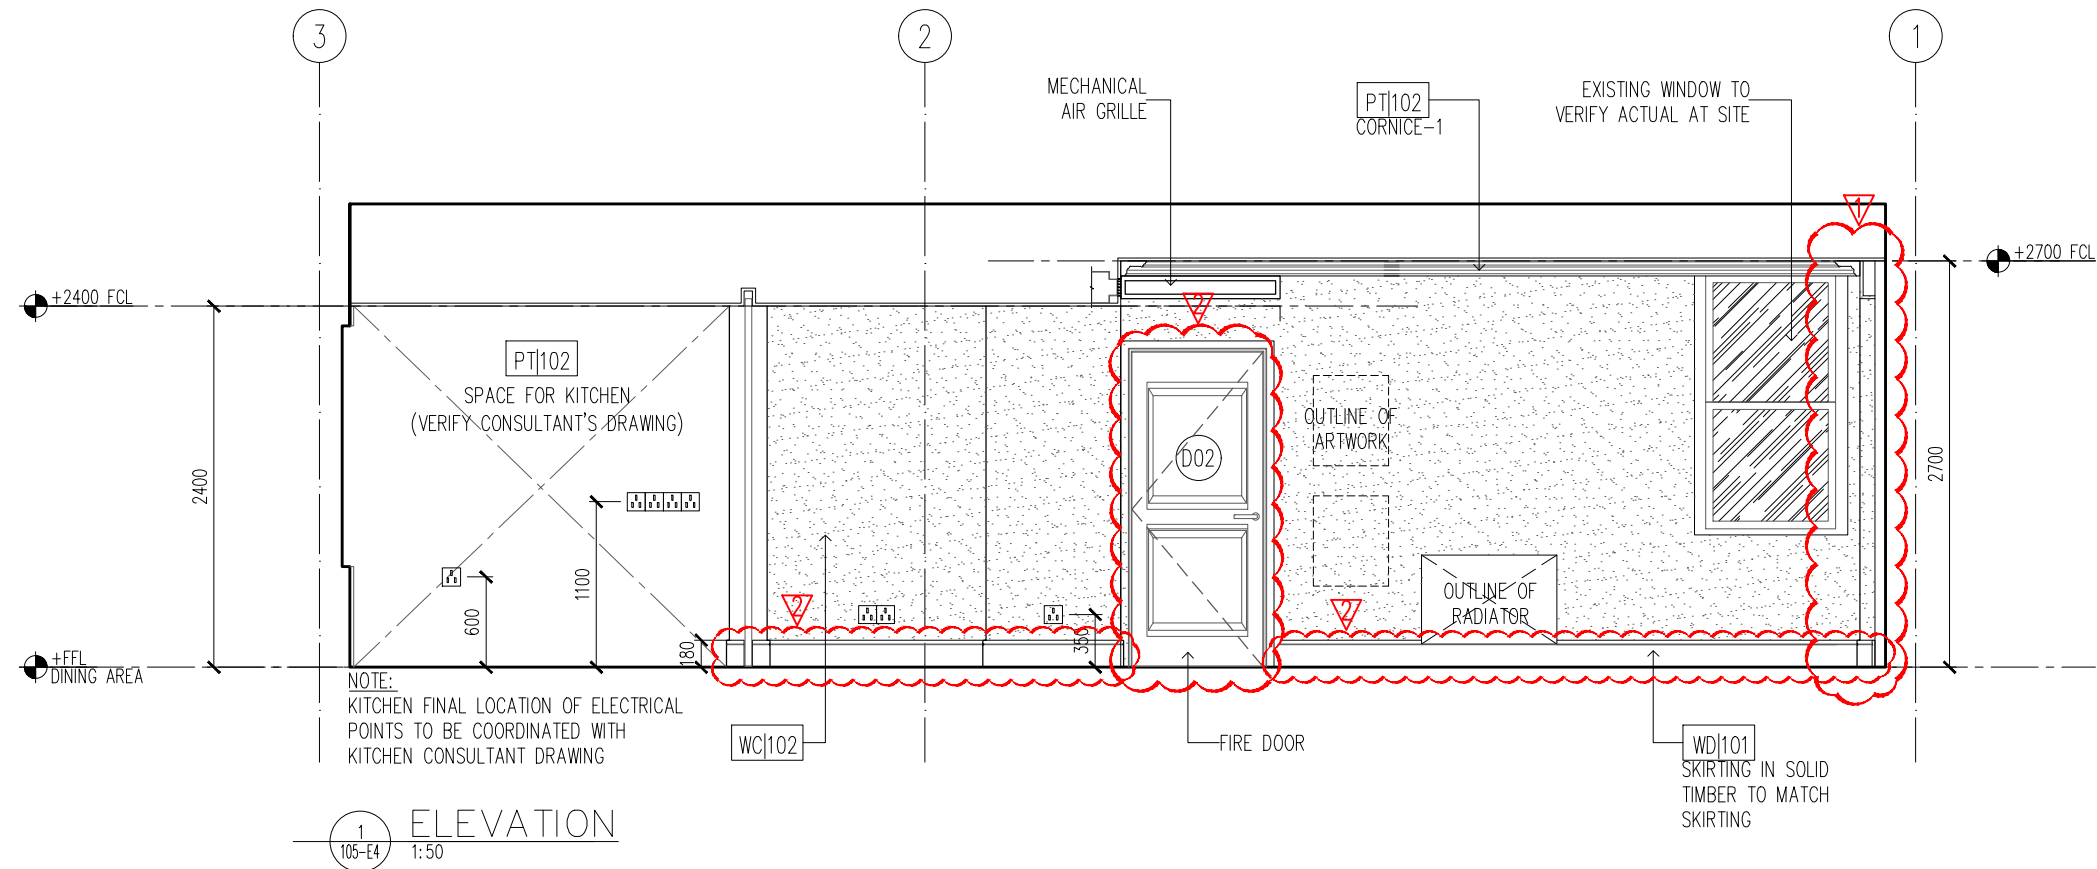

©COPYRIGHT 2019 WARNER WONG PTE LTD | WOW ARCHITECTS PTE LTD. DRAWINGS AND SAMPLES PROPERTY OF WARNERWONG PTE LTD | WOW ARCHITECTS PTE LTD. NOT FOR CONSTRUCTION. ALL INFORMATION CONTAINED HEREIN IS FOR DESIGN PURPOSES ONLY. ALL DIMENSIONS TO BE CONFIRMED ON SITE PRIOR TO COMMENCEMENT OF WORK. ALL DISCREPANCIES TO BE REFERRED TO THE CONSULTANT FOR CLARIFICATION PRIOR TO EXECUTION. NO STRUCTURAL CHANGES TO BE CARRIED OUT WITHOUT PRIOR CONSENT FROM STRUCTURAL CONSULTANT AND STATUTORY AUTHORITIES.

**DRAWN**  
RYM  
**DATE**  
16-Jul-19  
06-Aug-19

**CHECKED**  
AP  
**PURPOSE OF SUBMISSION**  
REVISION 1  
REVISION 2

**LEGEND**

**HCL LONDON RESIDENCE**  
LONDON, UNITED KINGDOM

**CONSTRUCTION**  
SCALE 1:50







FOR COORDINATION  
WARNER WONG  
DESIGN  
16 JULY 2019  
Date of Issue

HLR-CD-I-E4-REV2

**WOW**

WOW ARCHITECTS

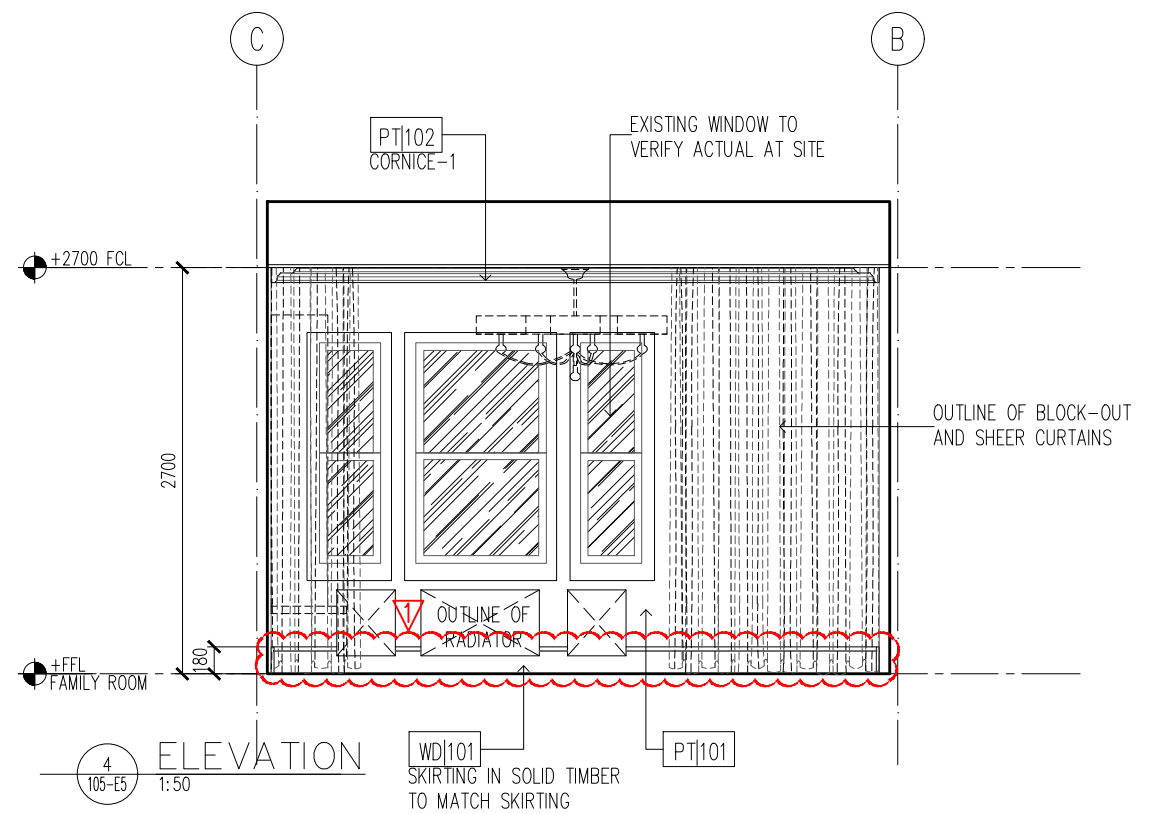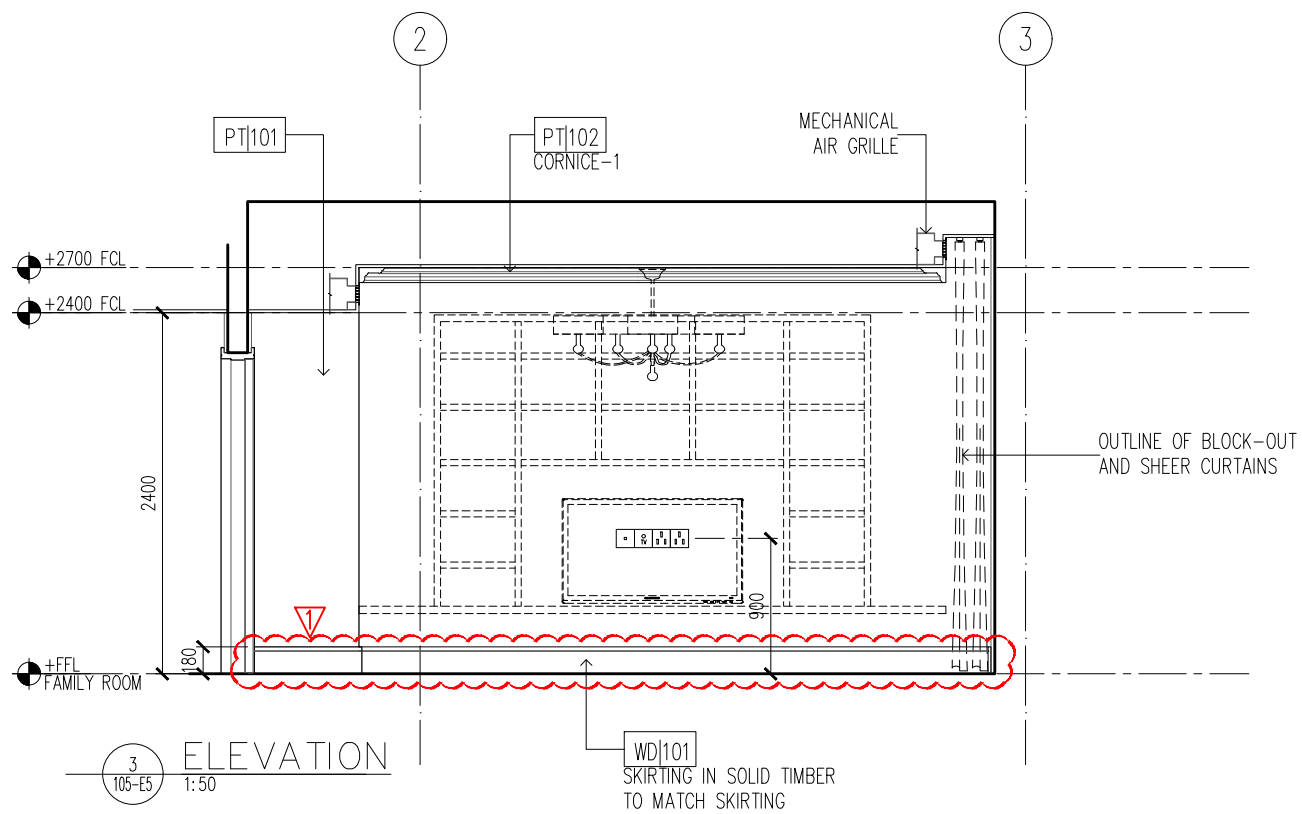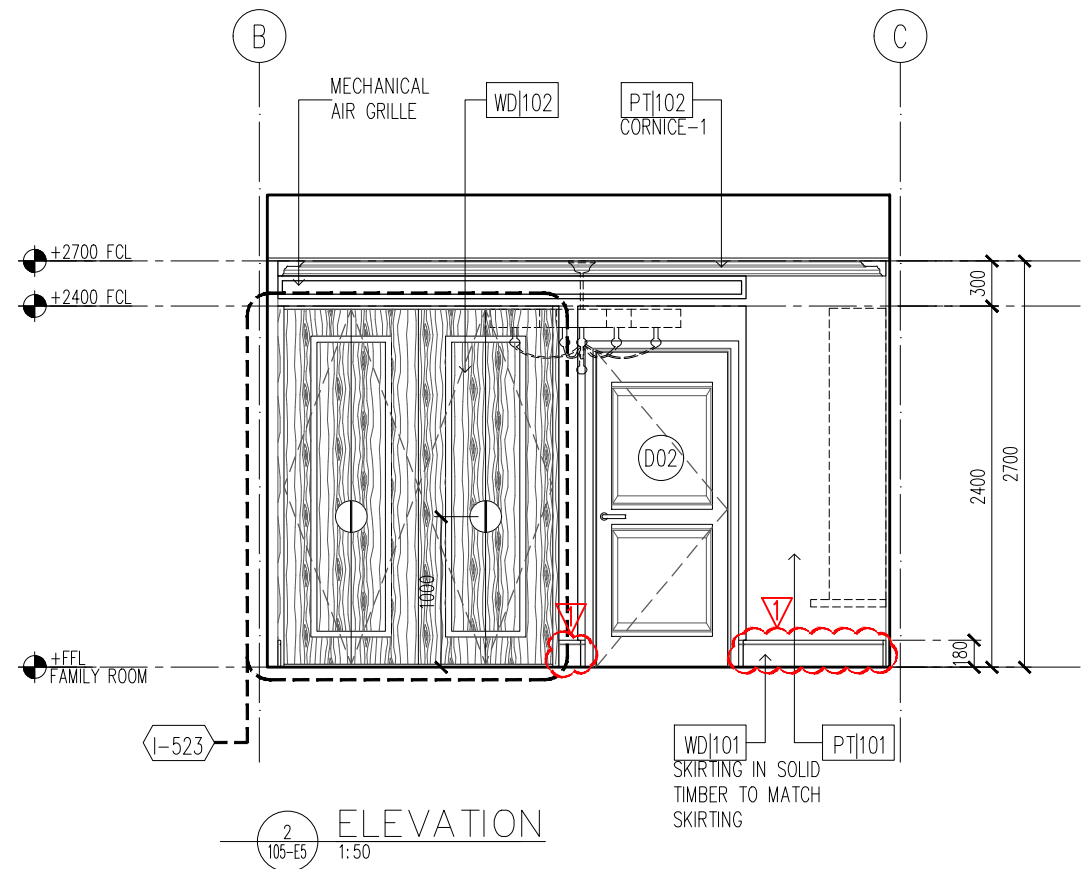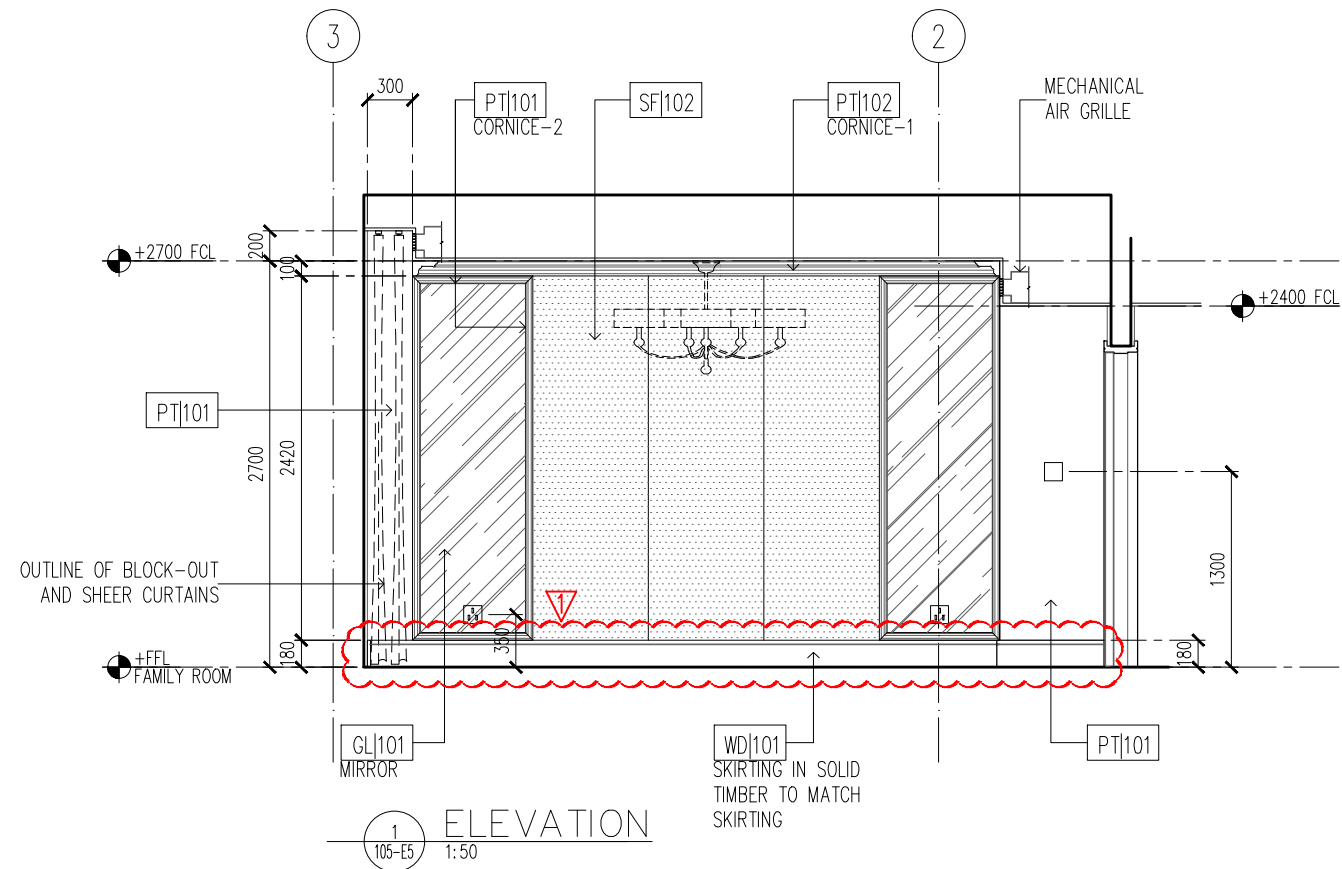

© COPYRIGHT 2019 WARNER WONG PTE LTD | WOW ARCHITECTS PTE LTD. DRAWINGS AND SAMPLES PROPERTY OF WARNER WONG PTE LTD | WOW ARCHITECTS PTE LTD. NOT FOR CONSTRUCTION. ALL INFORMATION CONTAINED HEREIN IS FOR DESIGN PURPOSES ONLY. ALL DIMENSIONS TO BE CONFIRMED ON SITE PRIOR TO COMMENCEMENT OF WORK. ALL DISCREPANCIES TO BE REFERRED TO THE CONSULTANT FOR CLARIFICATION PRIOR TO EXECUTION. NO STRUCTURAL CHANGES TO BE CARRIED OUT WITHOUT PRIOR CONSENT FROM STRUCTURAL CONSULTANT AND STATUTORY AUTHORITIES.

DRAWN	CHECKED	LEGEND
RYM	AP	
DATE	PURPOSE OF SUBMISSION	
20-Jun-19	FOR COORDINATION	
06-Aug-19	REVISION 1	

PLOT DATE: 2019.08.06 / 11:19  
FILE: P:\HLR\ID\DRAWINGS\ISSUED\20190806\_CD Rev 1\DWG\CAD\HLR-CD-I-E5-REV1.dwg

HCL LONDON RESIDENCE  
LONDON, UNITED KINGDOM





CONSTRUCTION SCALE 1:50

FOR COORDINATION  
WARNER WONG  
DESIGN  
16 JULY 2019  
Date of Issue

HLR-CD-I-E5-REV1

WOW

WOW ARCHITECTS

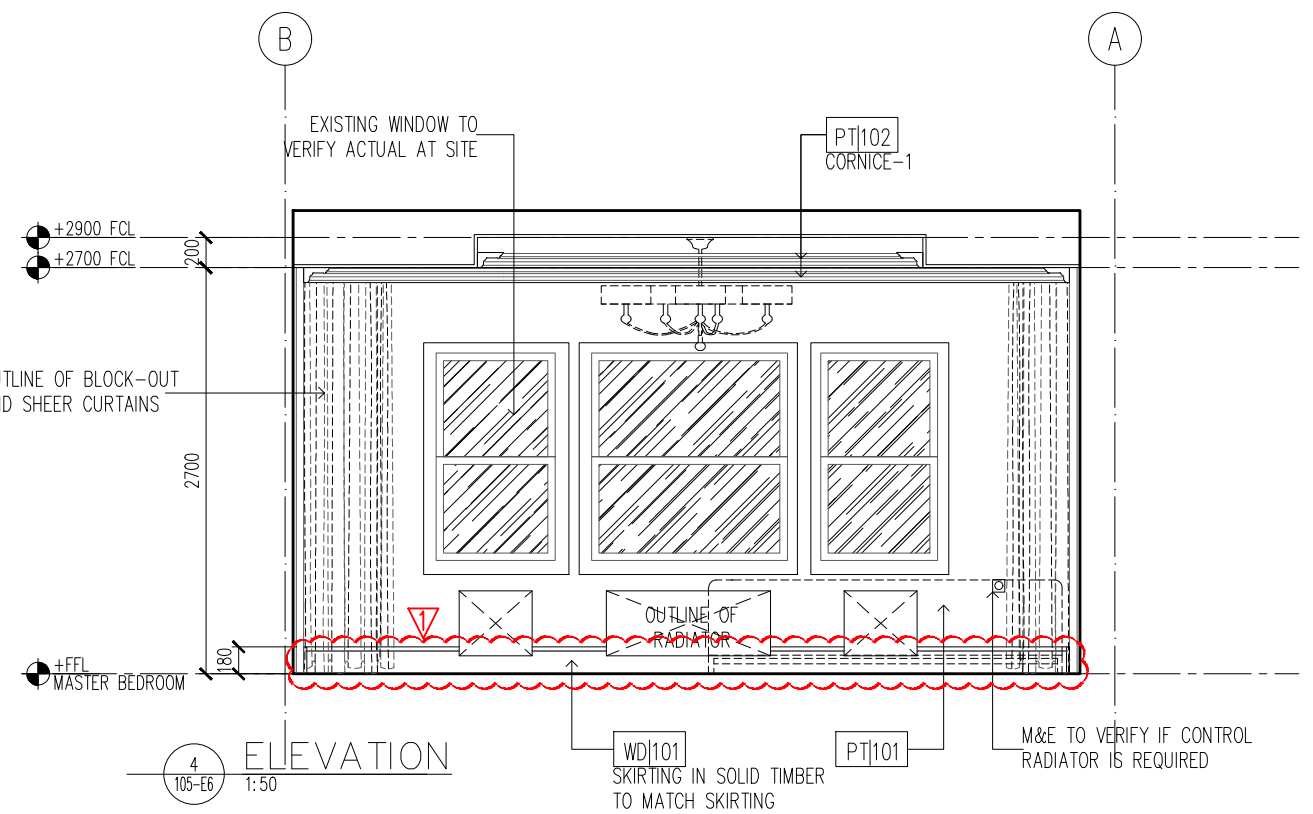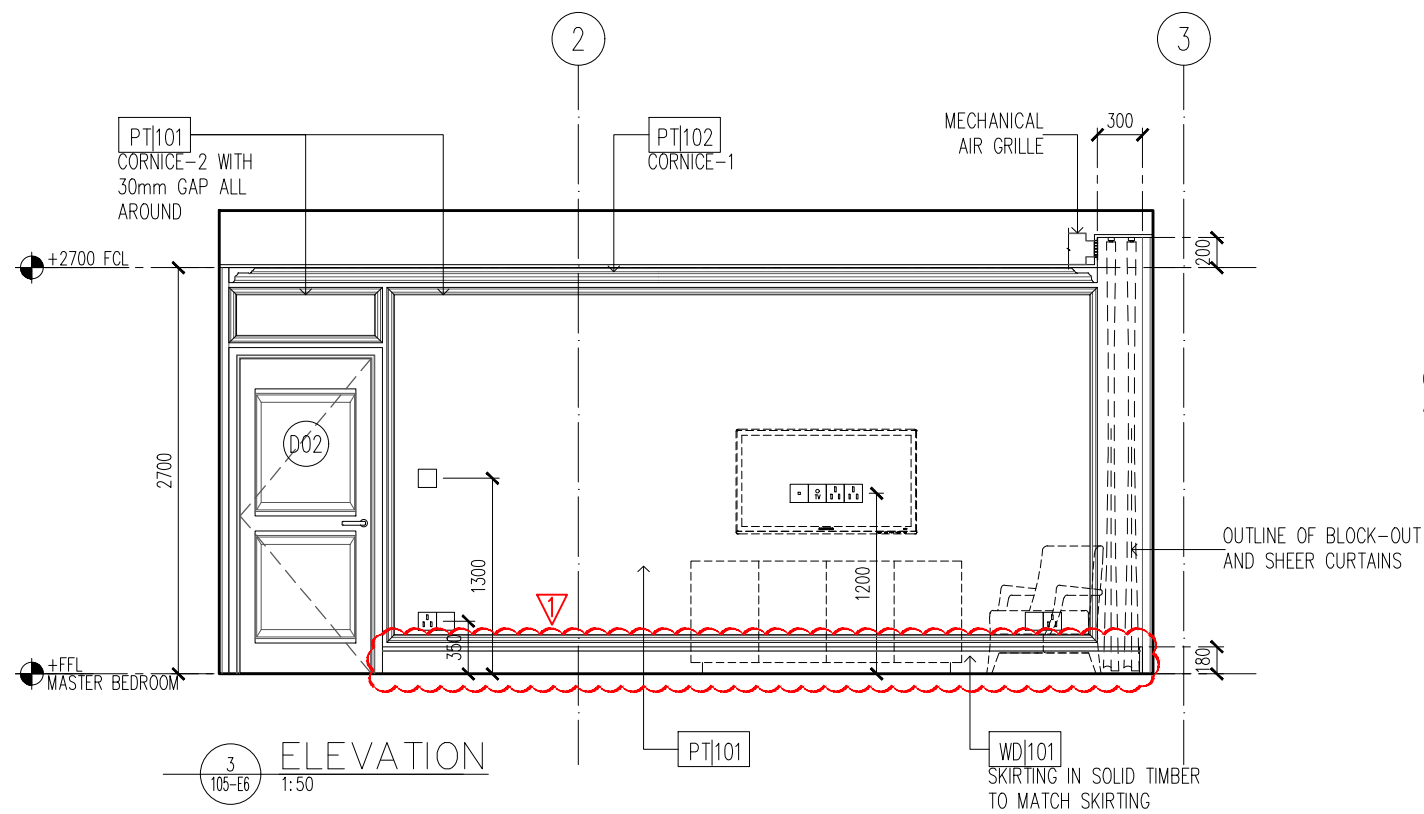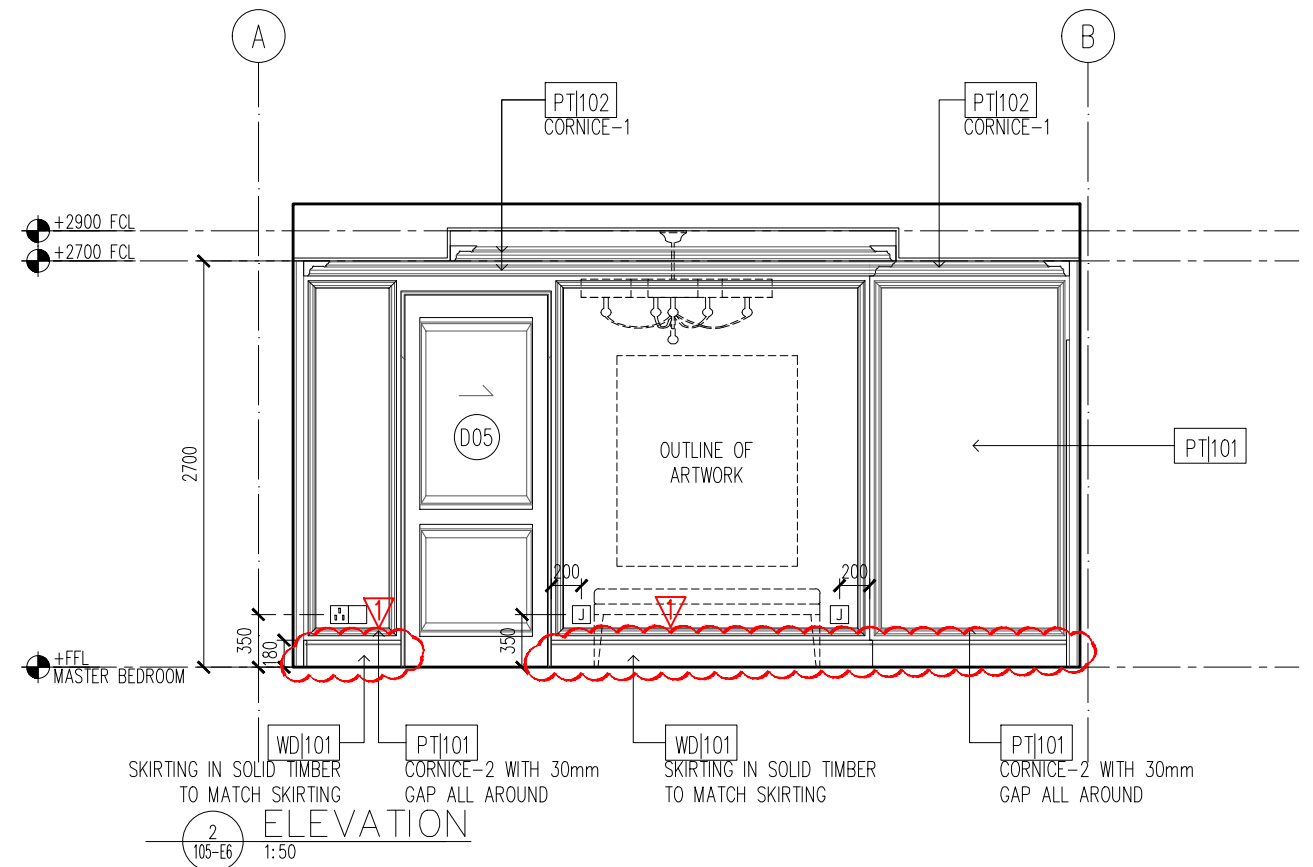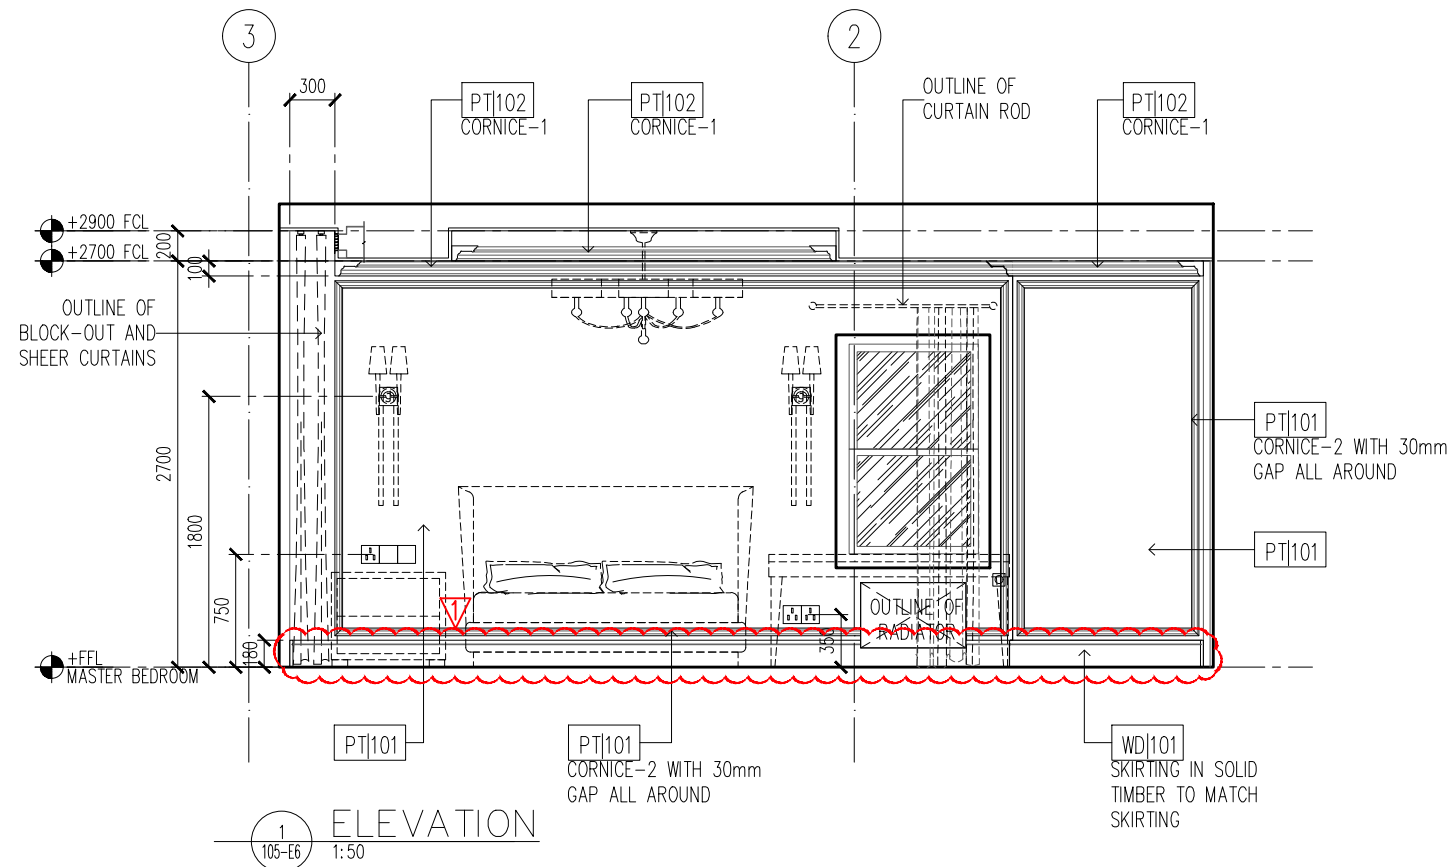

© COPYRIGHT 2019 WARNER WONG PTE LTD | WOW ARCHITECTS PTE LTD. DRAWINGS AND SAMPLES PROPERTY OF WARNER WONG PTE LTD | WOW ARCHITECTS PTE LTD. NOT FOR CONSTRUCTION. ALL INFORMATION CONTAINED HEREIN IS FOR DESIGN PURPOSES ONLY. ALL DIMENSIONS TO BE CONFIRMED ON SITE PRIOR TO COMMENCEMENT OF WORK. ALL DISCREPANCIES TO BE REFERRED TO THE CONSULTANT FOR CLARIFICATION PRIOR TO EXECUTION. NO STRUCTURAL CHANGES TO BE CARRIED OUT WITHOUT PRIOR CONSENT FROM STRUCTURAL CONSULTANT AND STATUTORY AUTHORITIES.

**DRAWN**  
RYM  
**DATE**  
20-Jun-19  
06-Aug-19

**CHECKED**  
AP  
**PURPOSE OF SUBMISSION**  
FOR COORDINATION  
REVISION 1

**LEGEND**

HCL LONDON RESIDENCE  
LONDON, UNITED KINGDOM



CONSTRUCTION  
SCALE 1:50

FOR COORDINATION  
WARNER WONG  
DESIGN  
16 JULY 2019  
Date of Issue

HLR-CD-I-E6-REV1

WOW

WOW ARCHITECTS

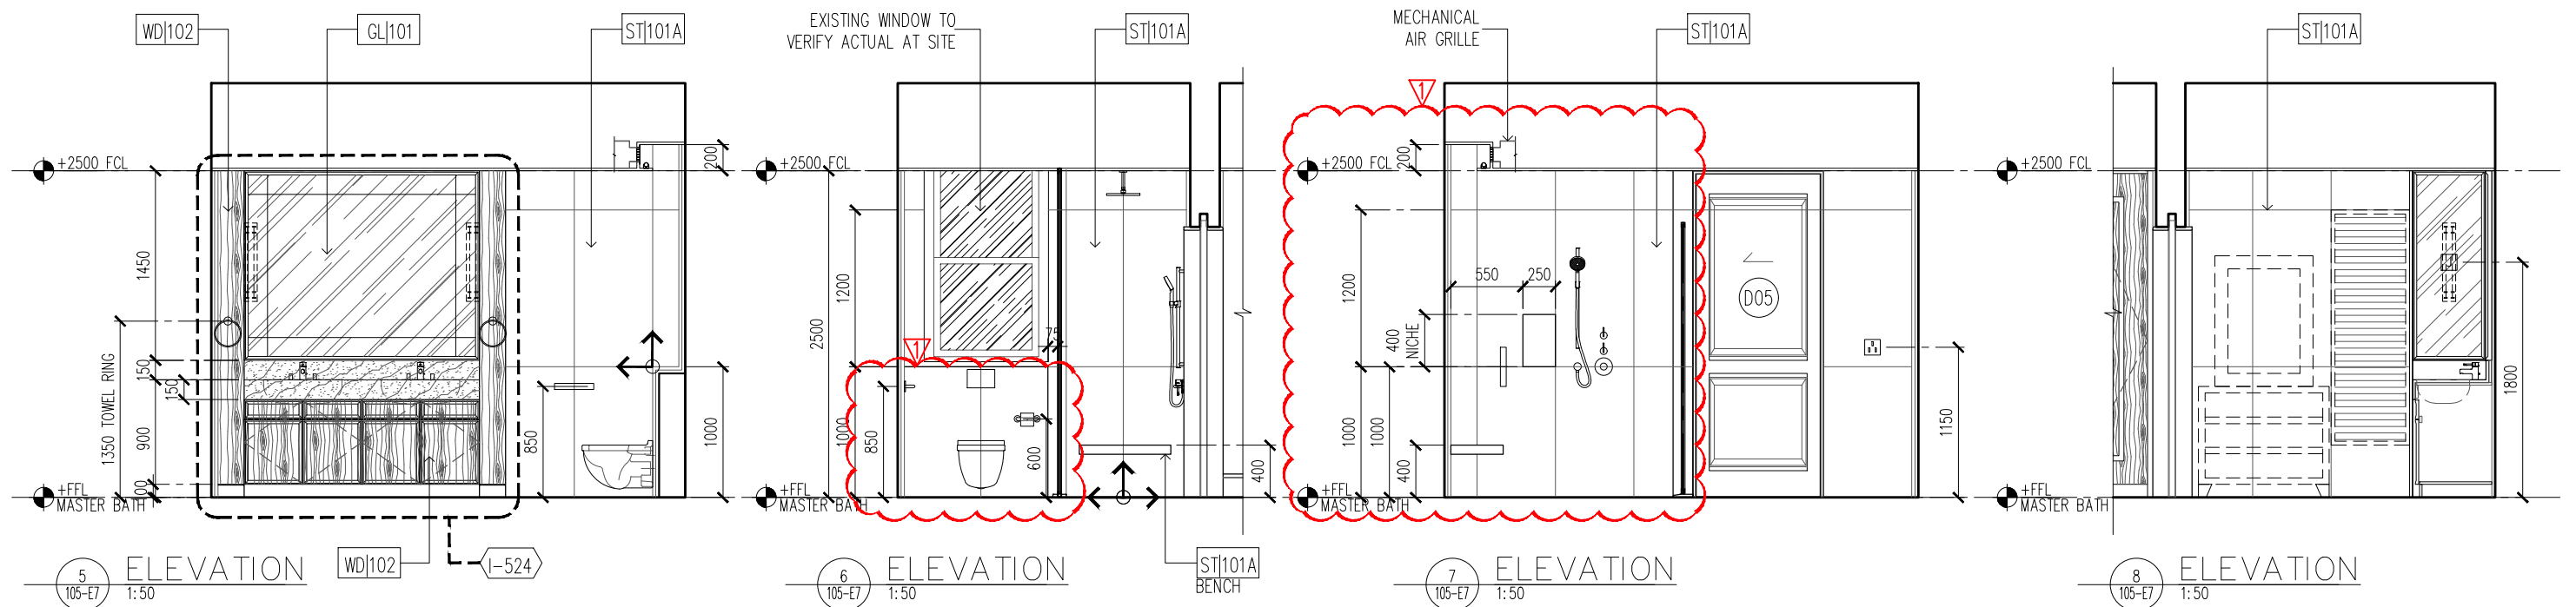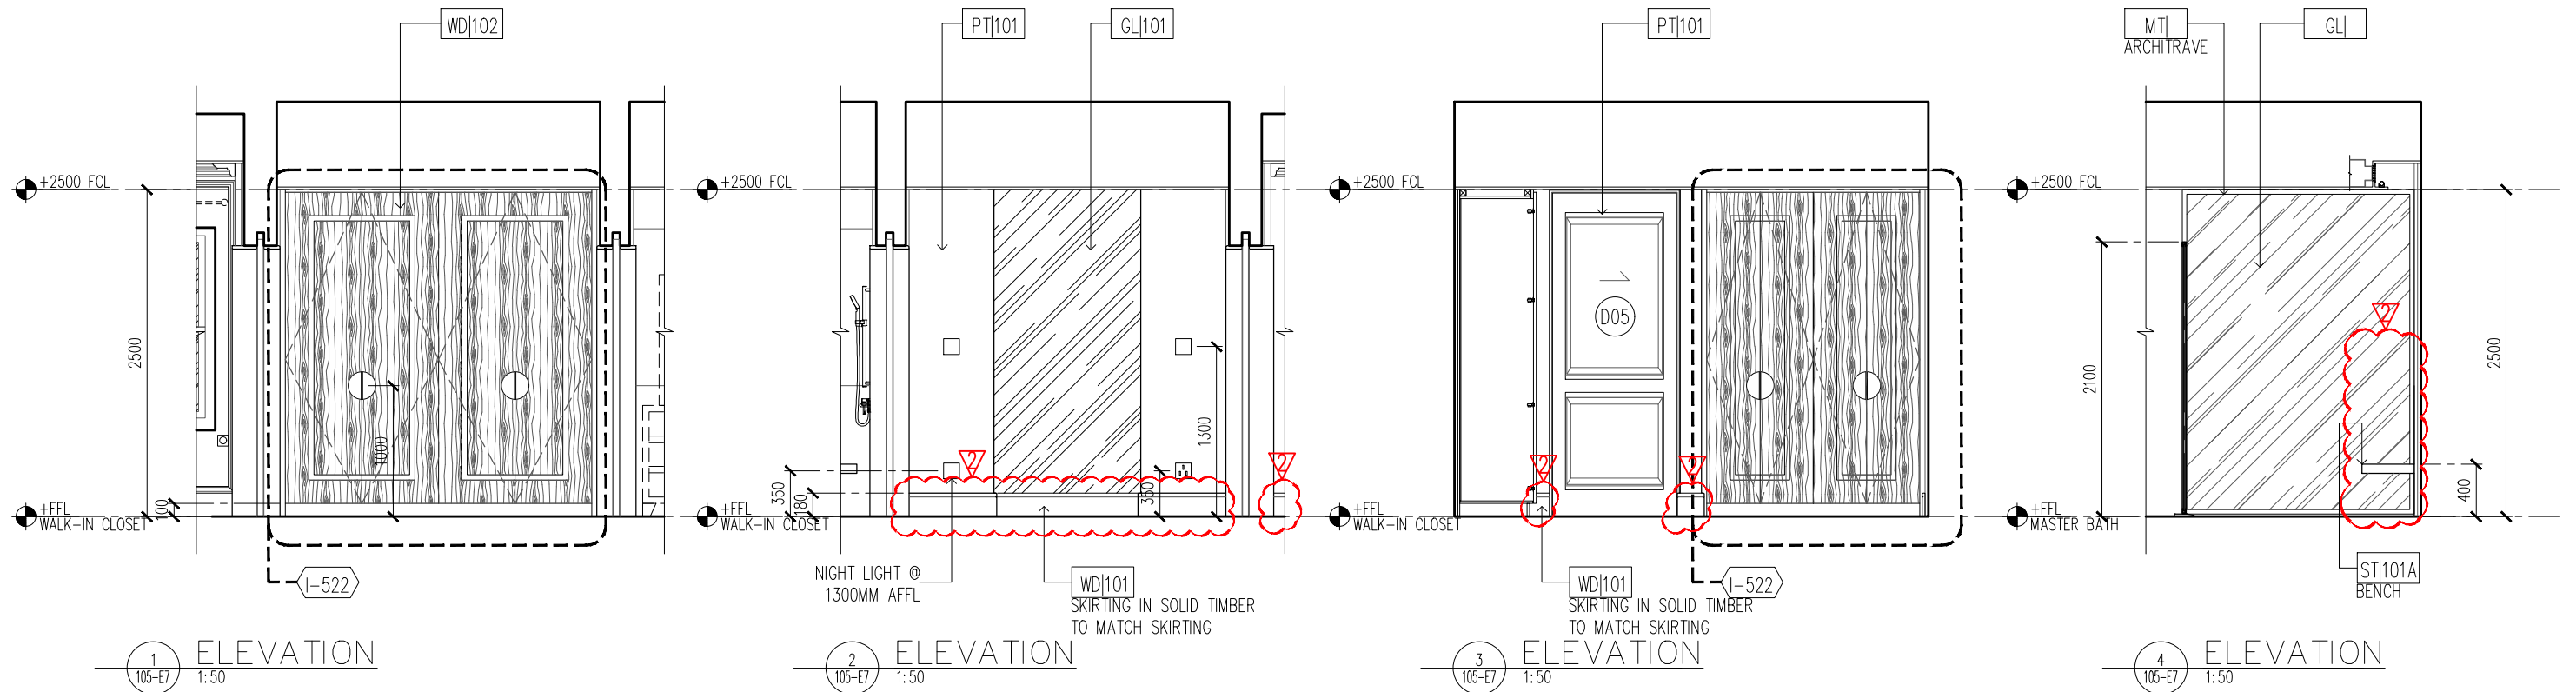

© COPYRIGHT 2019 WARNER WONG PTE LTD | WOW ARCHITECTS PTE LTD. DRAWINGS AND SAMPLES PROPERTY OF WARNER WONG PTE LTD | WOW ARCHITECTS PTE LTD. NOT FOR CONSTRUCTION. ALL INFORMATION CONTAINED HEREIN IS FOR DESIGN PURPOSES ONLY. ALL DIMENSIONS TO BE CONFIRMED ON SITE PRIOR TO COMMENCEMENT OF WORK. ALL DISCREPANCIES TO BE REFERRED TO THE CONSULTANT FOR CLARIFICATION PRIOR TO EXECUTION. NO STRUCTURAL CHANGES TO BE CARRIED OUT WITHOUT PRIOR CONSENT FROM STRUCTURAL CONSULTANT AND STATUTORY AUTHORITIES.


DRAWN	CHECKED	LEGEND
RYM	AP	
DATE	PURPOSE OF SUBMISSION	
16-Jul-19	REVISION 1	
06-Aug-19	REVISION 2	

HCL LONDON RESIDENCE  
LONDON, UNITED KINGDOM

CONSTRUCTION SCALE 1:50

FOR COORDINATION  
WARNER WONG DESIGN  
16 JULY 2019  
Date of Issue

**WOW**  
WOW ARCHITECTS

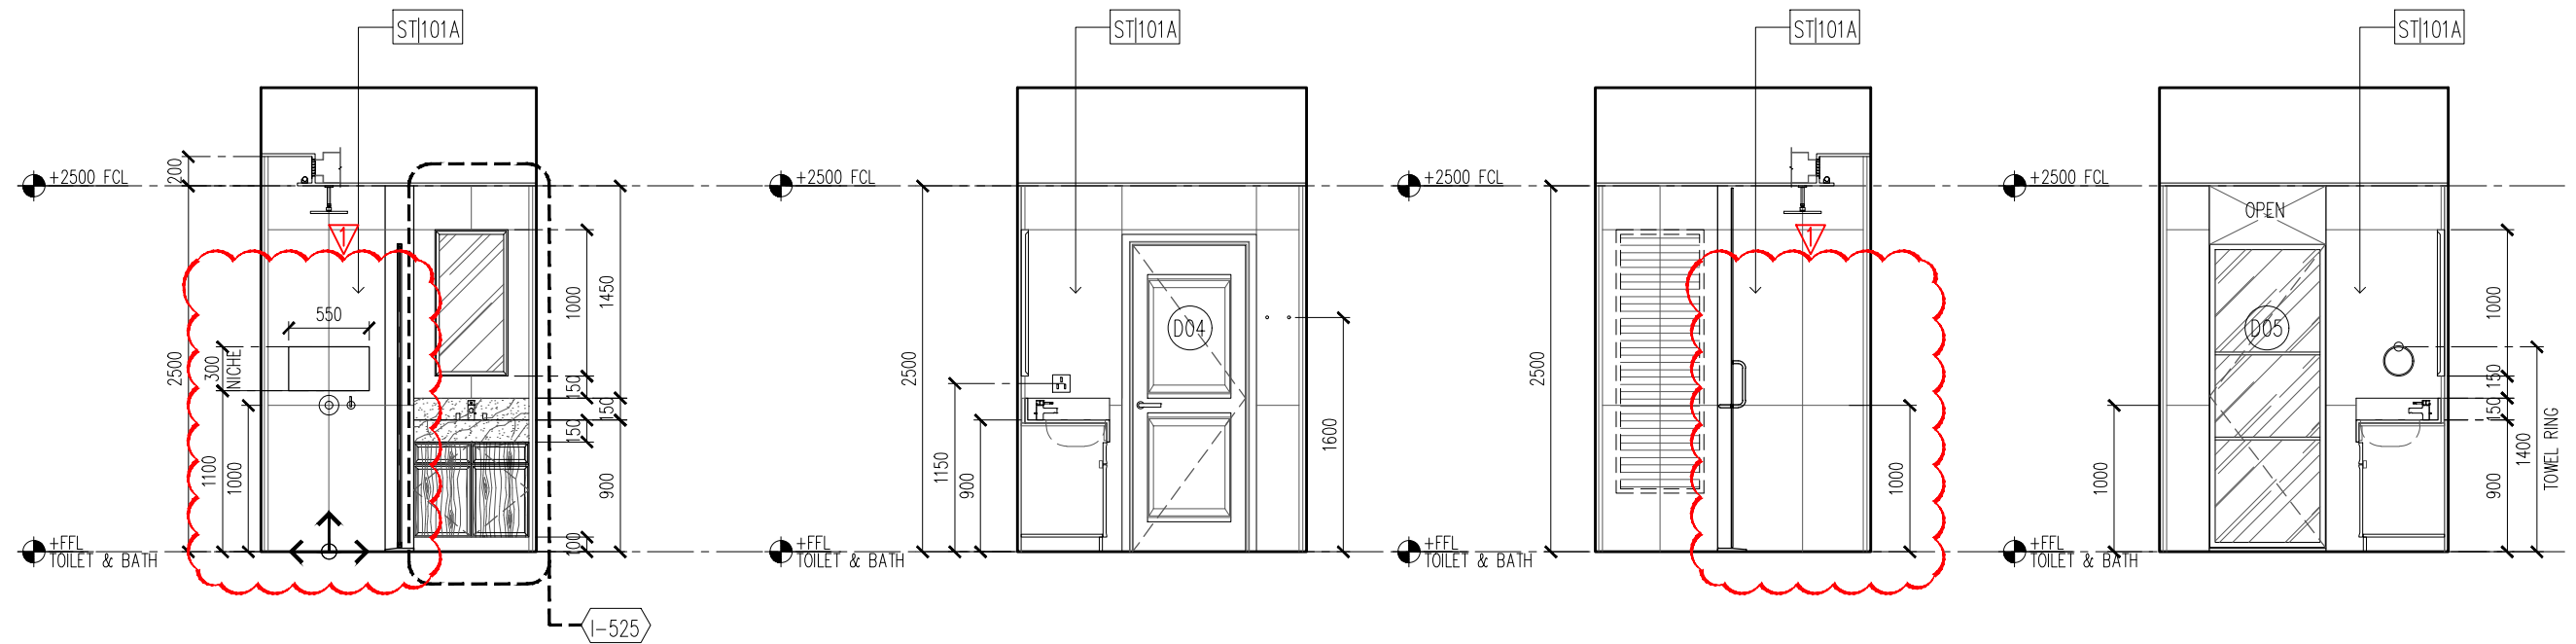


1 ELEVATION  
105-E8 1:50

2 ELEVATION  
105-E8 1:50

3 ELEVATION  
105-E8 1:50

4 ELEVATION  
105-E8 1:50

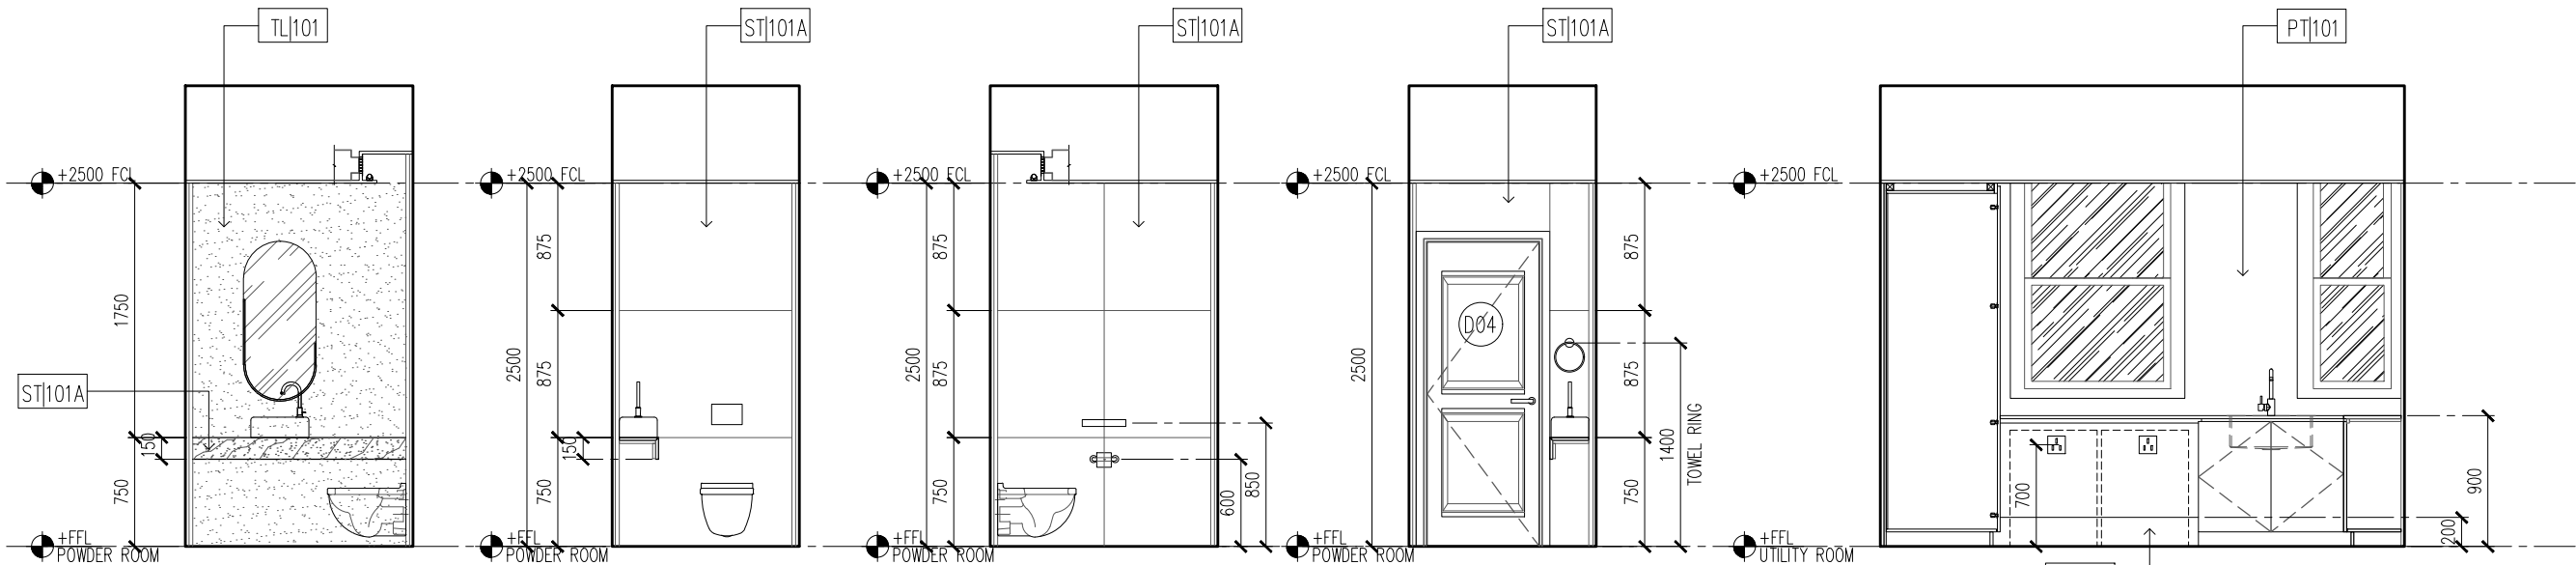

5 ELEVATION  
105-E8 1:50

6 ELEVATION  
105-E8 1:50

7 ELEVATION  
105-E8 1:50

8 ELEVATION  
105-E8 1:50

9 ELEVATION  
105-E8 1:50

©COPYRIGHT 2019 WARNER WONG PTE LTD | WOW ARCHITECTS PTE LTD. DRAWINGS AND SAMPLES PROPERTY OF WARNERWONG PTE LTD | WOW ARCHITECTS PTE LTD. NOT FOR CONSTRUCTION. ALL INFORMATION CONTAINED HEREIN IS FOR DESIGN PURPOSES ONLY. ALL DIMENSIONS TO BE CONFIRMED ON SITE PRIOR TO COMMENCEMENT OF WORK. ALL DISCREPANCIES TO BE REFERRED TO THE CONSULTANT FOR CLARIFICATION PRIOR TO EXECUTION. NO STRUCTURAL CHANGES TO BE CARRIED OUT WITHOUT PRIOR CONSENT FROM STRUCTURAL CONSULTANT AND STATUTORY AUTHORITIES.

**DRAWN**  
RYM  
**DATE**  
16-Jul-19  
06-Aug-19

**CHECKED**  
AP  
**PURPOSE OF SUBMISSION**  
FOR COORDINATION  
REVISION 1

**LEGEND**

HCL LONDON RESIDENCE  
LONDON, UNITED KINGDOM

CONSTRUCTION SCALE 1:50

FOR COORDINATION  
WARNER WONG DESIGN  
16 JULY 2019  
Date of Issue

WOW

WOW ARCHITECTS



INTERIOR DESIGN

		Transmittal No		
		Day	Month	Year
		Size	Latest Revision	
			20190225	20190716
			20190806	
DRAWING NO.	DRAWING NAME	SCALE	REVISIONS	
<b>COVER SHEET</b>				
Cover sheet				
Symbols and Legends				
General Notes				
<b>PLANS</b>				
HLR-DD-I-PDP	Partition and Wall Finishes Plan	1 75	A3	✓
HLR-DD-I-WFP	Floor Finishes Plan	1 75	A3	
HLR-DD-I-RCP	Reflected Ceiling Plan	1 75	A3	✓ ✓
HLR-DD-I-ELE	Electrical Layout Plan	1 75	A3	✓
HLR-DD-I-LLP	Furniture and Millwork Plan	1 75	A3	✓
HLR-DD-I-FUR	Furniture and Millwork Plan	1 75	A3	✓
<b>ELEVATIONS</b>				
HLR-DD-I-105-E1	Living & Foyer Elevations	1 50	A3	✓
HLR-DD-I-105-E2	Living & Foyer Elevations	1 50	A3	✓
HLR-DD-I-105-E3	Dining & Corridor Elevations	1 50	A3	✓ ✓
HLR-DD-I-105-E4	Dining & Corridor Elevations	1 50	A3	✓ ✓
HLR-DD-I-105-E5	Family Room Elevations	1 50	A3	✓
HLR-DD-I-105-E6	Master Bedroom Elevations	1 50	A3	✓
HLR-DD-I-105-E7	Master Wardrobe & Bath Elevations	1 50	A3	✓ ✓
HLR-DD-I-105-E8	Toilet and Bath, Powder, Laundry	1 50	A3	✓ ✓
<b>DETAILS</b>				
HLR-DD-I-501A	Typical Floor Details	1 5	A3	
HLR-DD-I-501B	Typical Wall to Floor Details	1 5	A3	
HLR-DD-I-502A	Typical Wall Details	1 5	A3	
HLR-DD-I-502B	Typical Wall Moulding Profile	1 5	A3	
HLR-DD-I-503A	Typical Ceiling Details	1 5	A3	
HLR-DD-I-503B	Typical Ceiling Details	1 5	A3	
HLR-DD-I-504A	Staircase Detail	1 10	A3	
HLR-DD-I-504B	Staircase Detail	1 5	A3	

INTERIOR DESIGN

		Transmittal No		
		Day	Month	Year
		Size	Latest Revision	
			20190225	20190716
DRAWING NO.	DRAWING NAME	SCALE	REVISIONS	
<b>DOOR DETAILS</b>				
HLR-DD-I-510	Door Panel Details	AS SHOWN	A3	
HLR-DD-I-511	Door Panel Details	AS SHOWN	A3	
HLR-DD-I-511A	Door Panel Details	AS SHOWN	A3	✓
HLR-DD-I-511B	Door Panel Details	AS SHOWN	A3	✓
HLR-DD-I-512	Door Frame Details	1 5	A3	✓
HLR-DD-I-512A	Door Frame Details	1 5	A3	✓
<b>MILLWORKS</b>				
HLR-DD-I-520	Fireplace Detail	AS SHOWN	A3	
HLR-DD-I-521	Wardrobe @ Corridor	AS SHOWN	A3	
HLR-DD-I-522A	Wardrobe @ Master Wardrobe	AS SHOWN	A3	
HLR-DD-I-522B	Wardrobe @ Master Wardrobe	AS SHOWN	A3	
HLR-DD-I-522C	Wardrobe Sections	AS SHOWN	A3	
HLR-DD-I-523	Wardrobe @ Family Room	AS SHOWN	A3	
HLR-DD-I-524	Vanity Counter @ Master Bathroom	AS SHOWN	A3	
HLR-DD-I-525	Vanity Counter @ Guest Bathroom	AS SHOWN	A3	
HLR-DD-I-526	Shower Bench at Master Bathroom	AS SHOWN	A3	
HLR-DD-I-527	Vanity Counter at Powder Room	AS SHOWN	A3	
HLR-DD-I-528A	Counter at Utility Room	AS SHOWN	A3	
HLR-DD-I-528B	Counter at Utility Room	AS SHOWN	A3	

INTERIOR DESIGN

Transmittal No  
Day  
Month  
Year  
Size  
Latest Revision  
20190225  
20190716  
20190806

DRAWING NO.	DRAWING NAME	SCALE	REVISIONS
-------------	--------------	-------	-----------

INTERIOR DESIGN

Transmittal No  
Day  
Month  
Year  
Size  
Latest Revision  
20190225  
20190716

DRAWING NO.	DRAWING NAME	SCALE	REVISIONS
-------------	--------------	-------	-----------


STAGE: C=Concept S=Schematic D=Design Development T=Tender G=Construction	<b>D</b>
CLIENT	
STRUCTURAL	
QUANTITY SURVEYOR	
M.E.P ENGINEER	
INTERIOR DESIGNER	
OTHERS	
ISSUE TYPE	

STAGE: C=Concept S=Schematic D=Design Development T=Tender G=Construction	<b>D</b>
CLIENT	
STRUCTURAL	
QUANTITY SURVEYOR	
M.E.P ENGINEER	
INTERIOR DESIGNER	
OTHERS	
ISSUE TYPE	

ISSUED BY	NAME	DATE	SIGNATURE
	Warner Wong Design	6 8 19	_____
RECEIVED BY			_____



# REFLECTED CEILING PLAN

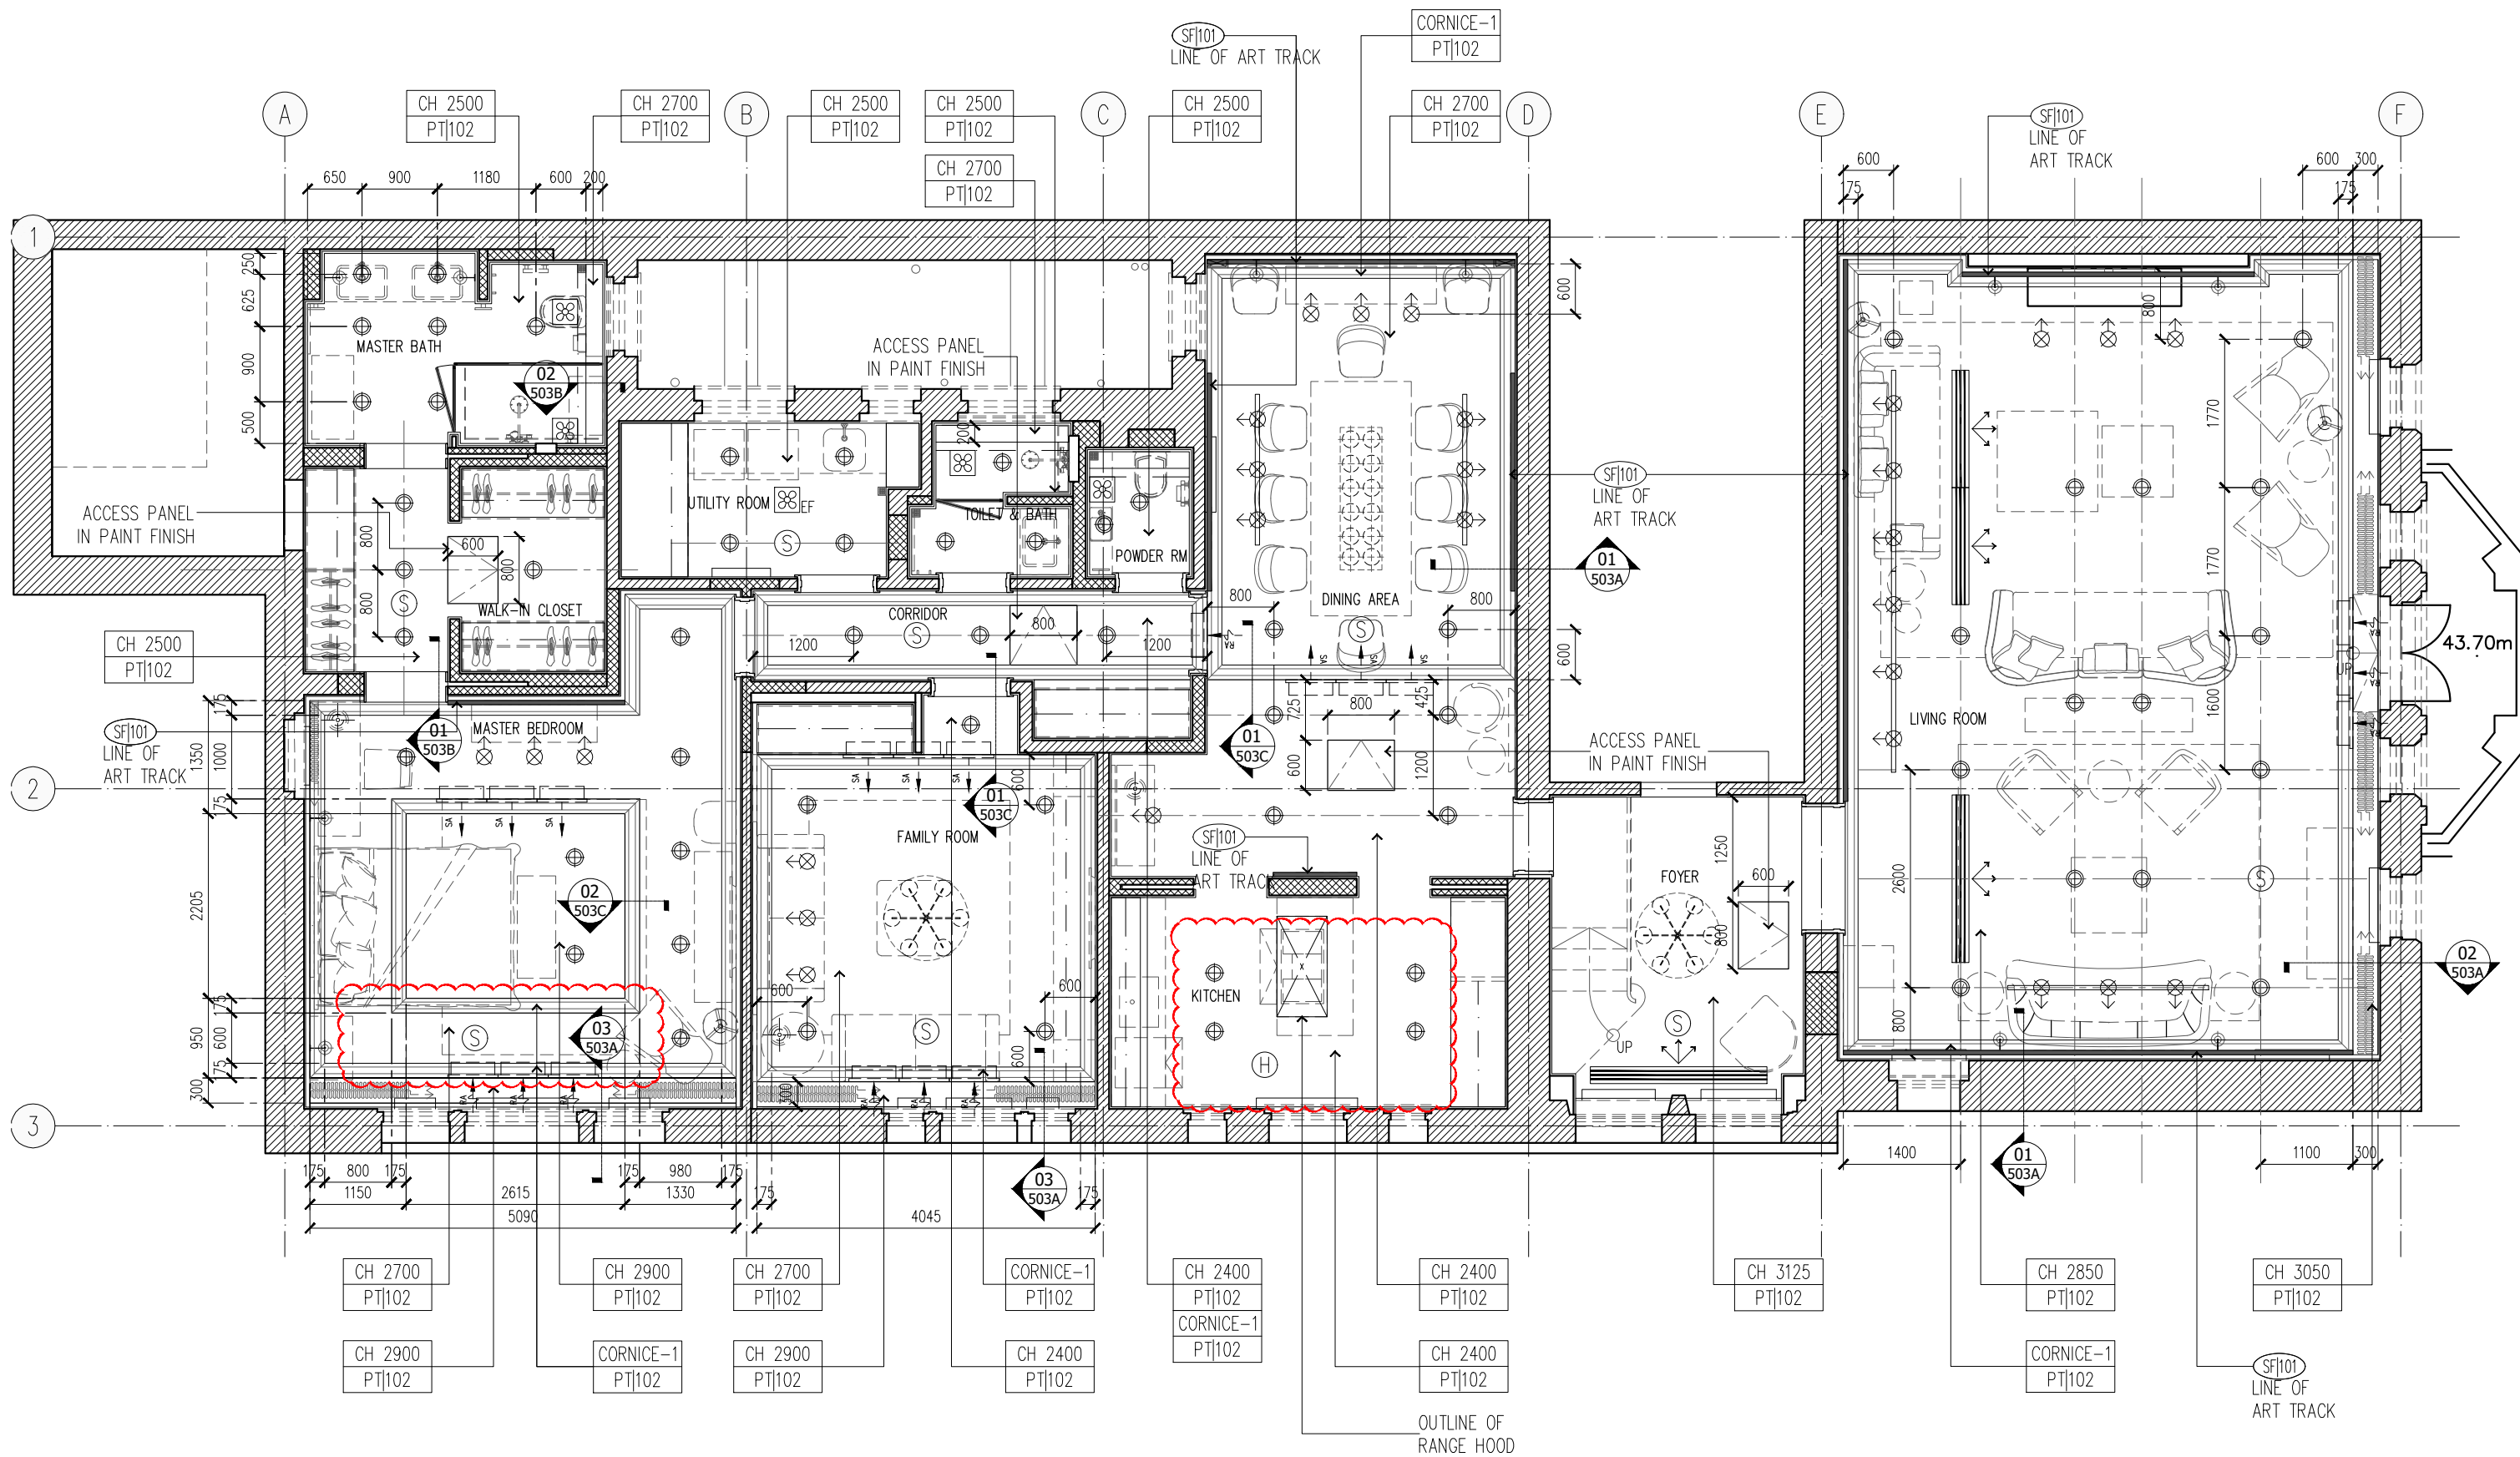

© COPYRIGHT 2019 WARNER WONG PTE LTD | WOW ARCHITECTS PTE LTD. DRAWINGS AND SAMPLES PROPERTY OF WARNERWONG PTE LTD | WOW ARCHITECTS PTE LTD. NOT FOR CONSTRUCTION. ALL INFORMATION CONTAINED HEREIN IS FOR DESIGN PURPOSES ONLY. ALL DIMENSIONS TO BE CONFIRMED ON SITE PRIOR TO COMMENCEMENT OF WORK. ALL DISCREPANCIES TO BE REFERRED TO THE CONSULTANT FOR CLARIFICATION PRIOR TO EXECUTION. NO STRUCTURAL CHANGES TO BE CARRIED OUT WITHOUT PRIOR CONSENT FROM STRUCTURAL CONSULTANT AND STATUTORY AUTHORITIES.

<b>DRAWN</b> RYM	<b>CHECKED</b> AP	<b>LEGEND</b>
<b>DATE</b> 16-Jul-19 06-Aug-19	<b>PURPOSE OF SUBMISSION</b> FOR COORDINATION REVISION 1	

**HCL LONDON RESIDENCE**  
LONDON, UNITED KINGDOM

**CONSTRUCTION**  
SCALE 1:75

FOR COORDINATION  
WARNER WONG  
DESIGN  
16 JULY 2019  
Date of Issue

