

LICENSING LEGEND

	FIRE ALARM CALL POINT		AREA COVERED BY AUTOMATIC HEAT DETECTORS	FD 30	FIRE RATING IN MINUTES		SIGN: FIRE ESCAPE KEEP CLEAR (BS5499)		ILLUMINATED BLADE SIGN: 'FIRE EXIT' OR GRAPHIC EQUIVALENT. 75MM LETTERS (BS5499)
	9 LITRE WATER FIRE EXTINGUISHER		AREA COVERED BY AUTOMATIC SMOKE DETECTORS	PB	PANIC BARS		SIGN: 'FIRE EXIT' OR GRAPHIC EQUIVALENT. 75MM LETTERS (BS5499)		ILLUMINATED BLADE SIGN: 'FIRE EXIT' OR GRAPHIC EQUIVALENT WITH ARROW. 75MM LETTERS (BS5499)
	2 KG CARBON DIOXIDE FIRE EXTINGUISHER (OR HALON)		SPRINKLER HEAD TO BS 5750	SC	SELF CLOSER		DIRECTIONAL ARROW TO BE PROVIDED WITH S22 NOTICE (BS5499)	LICENSING KEY — DENISE AREA — SALE OF ALCOHOL AND PROVISION FOR LATE NIGHT REFRESHMENTS	
	9 LITRE FOAM FIRE EXTINGUISHER		AREA COVERED BY EMERGENCY LIGHTING (BS 5265)	LK	LOCK		FIRE ALARM SOUNDER		
	FIRE BLANKET IN CONTAINER		DEDICATED EMERGENCY LIGHT FITTING	1050 CL.	CLEAR ESCAPE DISTANCE ≤ 220 PPL				
			SIGN: FIRE DOOR KEEP SHUT. 5MM LETTERS (BS5499) BOTH SIDES		SIGN: FIRE DOOR KEEP LOCKED (BS5499)				

FIRE NOTES

FIRE ALARM SYSTEM TO BE IN ACCORDANCE WITH BS5839


FIRE DETECTION SYSTEM TO: BS5839 PART 1 2002 TO L1 CATEGORY

FIRE EXIT SIGNAGE TO BE IN ACCORDANCE WITH BS5499

SMOKE DETECTION TO ALL VOIDS / ENCLOSED AREAS

REVISIONS

Rev.	Date	Comment
A	07.11.11	DIMENSIONS ADDED AND TABLES AND CHAIRS ALTERED
B	24.01.12	2X TABLES AND 4X EXTERNAL CHAIRS REMOVED

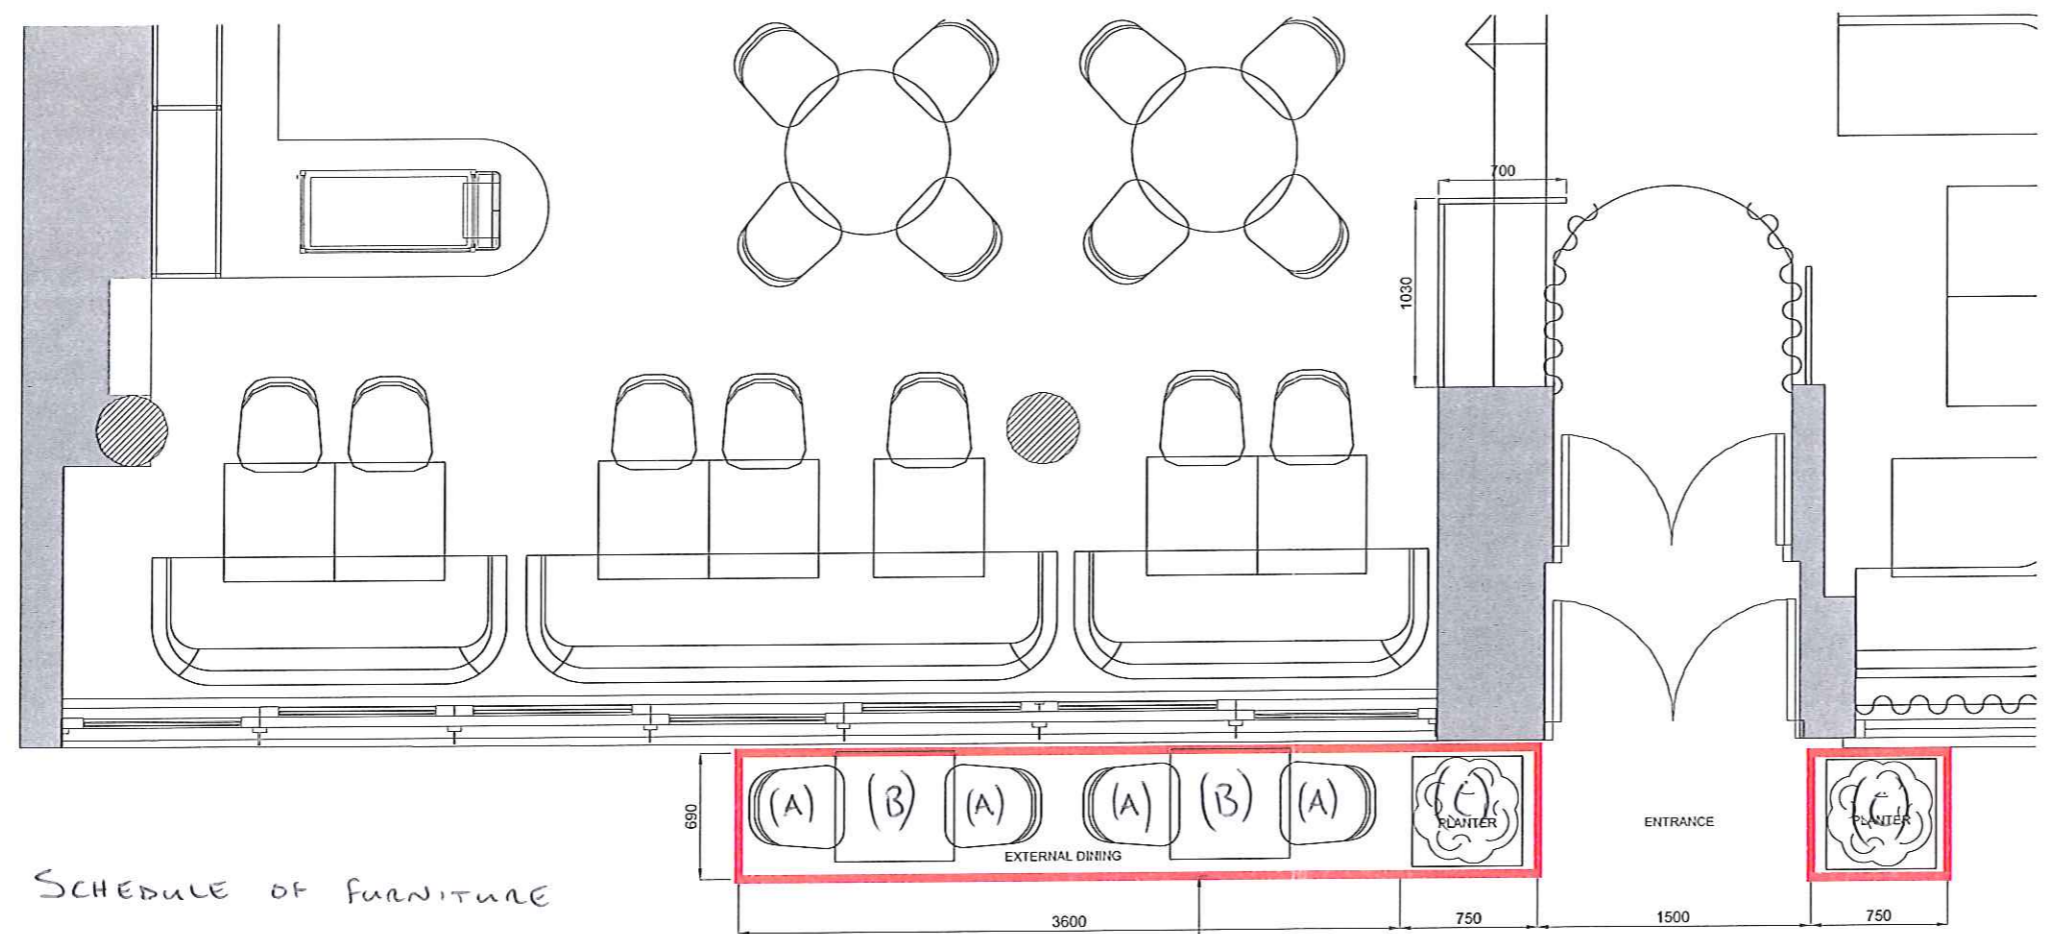

SCHEDULE OF FURNITURE

- (A) EXTERIOR CHAIR
450MM X 500MM
- (B) EXTERIOR TABLE
600MM X 600MM
- (C) PLANTERS
400MM X 400MM

NOTES

- THE DRAWINGS SHOW DESIGN INTENT ONLY. ALL DIMENSIONS TO BE CHECKED ON SITE PRIOR TO CONSTRUCTION OR PRODUCTION. CONSTRUCTION DETAILS TO BE CONFIRMED BY CONTRACTOR/MANUFACTURER BY SUBMITTING SHOP DRAWINGS FOR DESIGNER'S APPROVAL.
- DESIGN DRAWING IS NOT TO BE SCALED FOR PRODUCTION AND CONSTRUCTION PURPOSES.
- ALL DISCREPANCIES AND OMISSIONS ON SITE MUST BE REPORTED TO DESIGNER FOR THEIR COMMENTS OR APPROVAL PRIOR TO COMMENCING WORK.
- ALL ELECTRICAL, LIGHTING, HVAC AND PLUMBING ISSUES TO BE REFERRED TO ENGINEER'S DRAWINGS PRIOR TO COMMENCEMENT OF WORKS.
- ALL DESIGNS ARE SUBJECT TO APPROVAL BY STATUTORY AUTHORITIES AND ANY NECESSARY ALTERATIONS SHOULD BE MADE IF REQUIRED TO COMPLY WITH STATUTORY REQUIREMENTS.
- ALL DESIGN CONCEPTS AND DRAWINGS ARE THE PROPERTY OF MARTIN BRUDNIZKI AND ARE COVERED BY COPYRIGHT. NO REPRODUCTIONS, ADAPTATIONS AND/OR COPIES MAY BE MADE WITHOUT WRITTEN PERMISSION BY MARTIN BRUDNIZKI.

LICENSING

A1 Sheet

Project
CÔTE HAMPSTEAD

Title
PROPOSED EXTERNAL LICENSING PLAN

Date
04.11.11


Scale
1:50

Project No
36511

Dwg No
GA-G-01-LL-E

Rev.
B

01 EXTERNAL LICENSING PLAN
1:20 @ A1

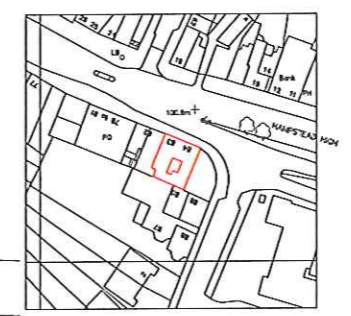

02 LOCATION PLAN
1:1250 @ A1

MARTIN BRUDNIZKI
DESIGN STUDIO LTD
Unit 1G Chelsea Reach
79-89 Lots Road London SW10 0RN
Tel +44 (0)20 7376 7555
Fax +44 (0)20 7376 7444