


REFER TO BOILER PLANT ROOM LAYOUT DRAWING No. L18051-IN2-00-00-DR-ME-1501

- CABLE CONTAINMENT RISING TO FLOORS ABOVE:
1. 100x50 GALVANISED STEEL L&P TRUNKING
  2. 225x50 GALVANISED STEEL LV SUB-MAINS TRUNKING.
  3. 150x50MM COMBINED ELV GALVANISED STEEL CABLE TRAY FOR FIRE ALARM & I.T.

50x50mm GALVANISED STEEL CABLE TRAY FOR COMBINED ELV  
50x50mm GALVANISED STEEL CABLE TRAY LV SUB-MAINS

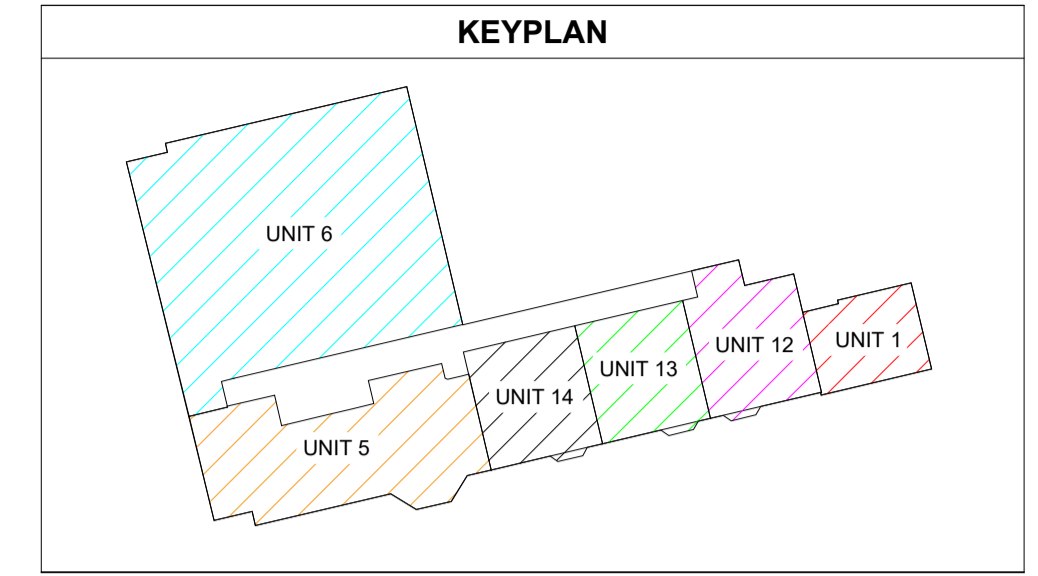


**NOTES**

- 1.00 THIS DRAWING IS REPRESENTATIVE OF PRIMARY CONTAINMENT INSTALLATIONS. ANY ADDITIONAL CABLE CONTAINMENT OR CONDUIT RUNS REQUIRED BY THE SPECIFICATION OR REQUIRED BY THE CONTRACTOR TO PROVIDE A COMPLETE INSTALLATION WILL BE DEEMED TO BE INCLUDED.
- 2.00 THIS DRAWING IS TO READ IN CONJUNCTION WITH ALL OTHER SERVICES INSTALLATION DRAWINGS AND WITH CO-ORDINATED MECHANICAL AND ELECTRICAL DRAWINGS PREPARED BY IN2 ENGINEERING DESIGN PARTNERSHIP.
- 3.00 ALL CABLE CONTAINMENT SYSTEMS AT ROOF LEVEL SHALL BE OF GALVANISED STEEL CONSTRUCTION RAISED "OFF" THE ROOF LEVEL ON UNI-STRUT SUPPORT BRACKETS.
- 4.00 A SPACING OF 300mm WILL BE PROVIDED BETWEEN ALL L.V. POWER DISTRIBUTION CABLE TRAY / LADDER SYSTEMS AND FIRE DETECTION CONTAINMENT SYSTEMS

**CABLE CONTAINMENT SYSTEM REFERENCE KEY**

- 225x50mm GALVANISED STEEL CABLE TRAY AT HIGH LEVEL FOR SUB-MAINS CABLE INSTALLATION.
- 100x50mm GALVANISED STEEL TRUNKING AT HIGH LEVEL FOR LIGHTING & GENERAL SERVICES.
- 150x50mm COMBINED ELV GALVANISED STEEL CABLE TRAY FOR I.T. STRUCTURED CABLING & FIRE ALARM.

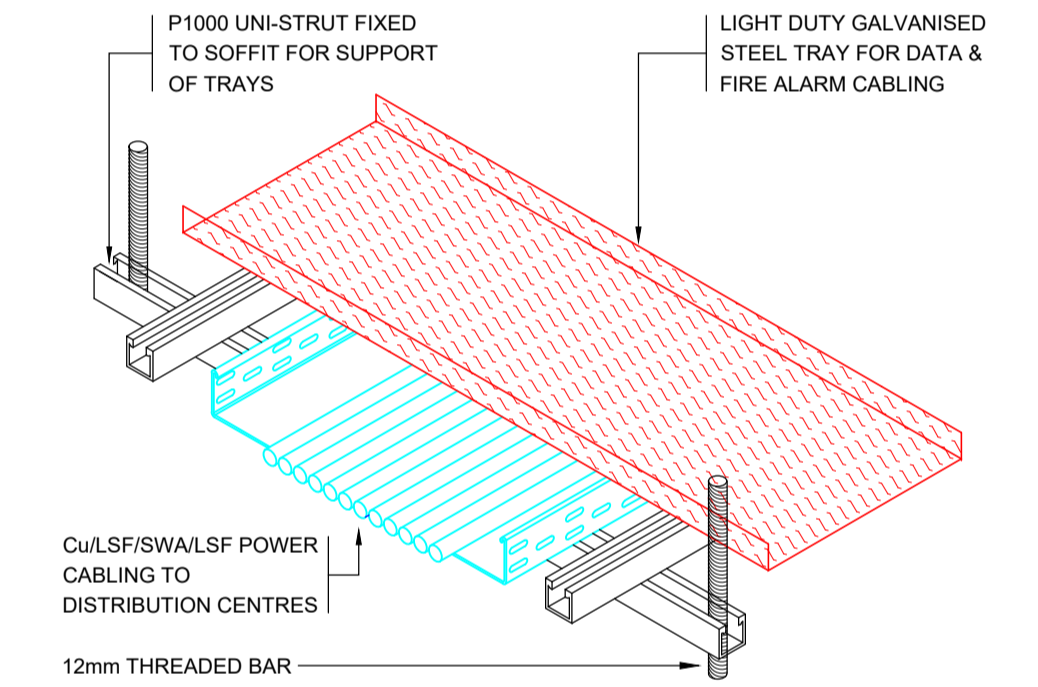

DETAIL OF CABLE TRAY CROSS OVER

NOTE: ARCHITECTURAL DRAWING USED FOR COMPILATION OF IN2 DRAWING. ARCHITECTURAL DRAWING REVISION: DATE RECEIVED: 14.06.2019

STATUS	DATE	DESCRIPTION	DRN	ENG	APP	REV
S4	18.06.2019	CONSTRUCTION ISSUE	JDT	TH	BF	C2
S4	18.10.2018	CONSTRUCTION ISSUE	KO	TH	BF	C1

**IN2**  
ENGINEERING DESIGN PARTNERSHIP  
DUBLIN . ATHLONE . BELFAST . LONDON



PROJECT  
**BELSIZE PARK FIRESTATION**

CLIENT  
**PLATINUM LAND**

DRAWING TITLE  
ELECTRICAL SERVICES INSTALLATION  
GROUND FLOOR LEVEL  
CABLE CONTAINMENT SERVICES LAYOUT

SCALE 1:100 @ A1  
1:200 @ A3

SIZE **A1**


PROJECT REF: **L18051**

DRAWING No. **L18051-IN2-00-00-DR-E-7001**

STATUS  
**S4**

REVISION  
**C2**




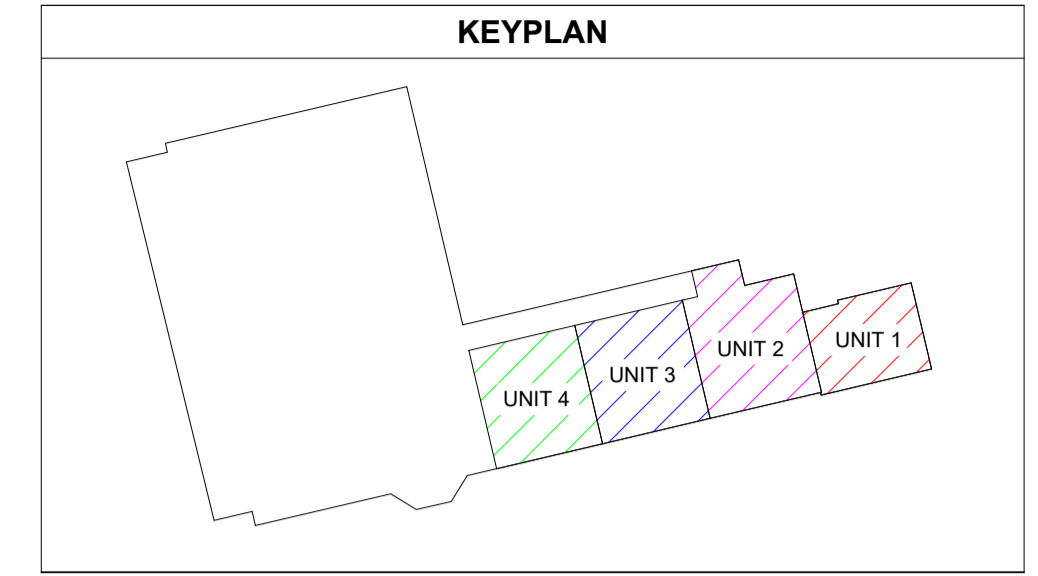

- NOTES**
- 1.00 THIS DRAWING IS REPRESENTATIVE OF PRIMARY CONTAINMENT INSTALLATIONS. ANY ADDITIONAL CABLE CONTAINMENT OR CONDUIT RUNS REQUIRED BY THE SPECIFICATION OR REQUIRED BY THE CONTRACTOR TO PROVIDE A COMPLETE INSTALLATION WILL BE DEEMED TO BE INCLUDED.
  - 2.00 THIS DRAWING IS TO BE READ IN CONJUNCTION WITH ALL OTHER SERVICES INSTALLATION DRAWINGS AND WITH CO-ORDINATED MECHANICAL AND ELECTRICAL DRAWINGS PREPARED BY IN2 ENGINEERING DESIGN PARTNERSHIP.
  - 3.00 ALL CABLE CONTAINMENT SYSTEMS AT ROOF LEVEL SHALL BE OF GALVANISED STEEL CONSTRUCTION RAISED "OFF" THE ROOF LEVEL ON UNI-STRUT SUPPORT BRACKETS.
  - 4.00 A SPACING OF 300mm WILL BE PROVIDED BETWEEN ALL L.V. POWER DISTRIBUTION CABLE TRAY / LADDER SYSTEMS AND FIRE DETECTION CONTAINMENT SYSTEMS

**CABLE CONTAINMENT SYSTEM REFERENCE KEY**

	225x50mm GALVANISED STEEL CABLE TRAY AT HIGH LEVEL FOR SUB-MAINS CABLE INSTALLATION.
	100x50mm GALVANISED STEEL TRUNKING AT HIGH LEVEL FOR LIGHTING & GENERAL SERVICES.
	150x50mm COMBINED ELV GALVANISED STEEL CABLE TRAY FOR I.T. STRUCTURED CABLING & FIRE ALARM.

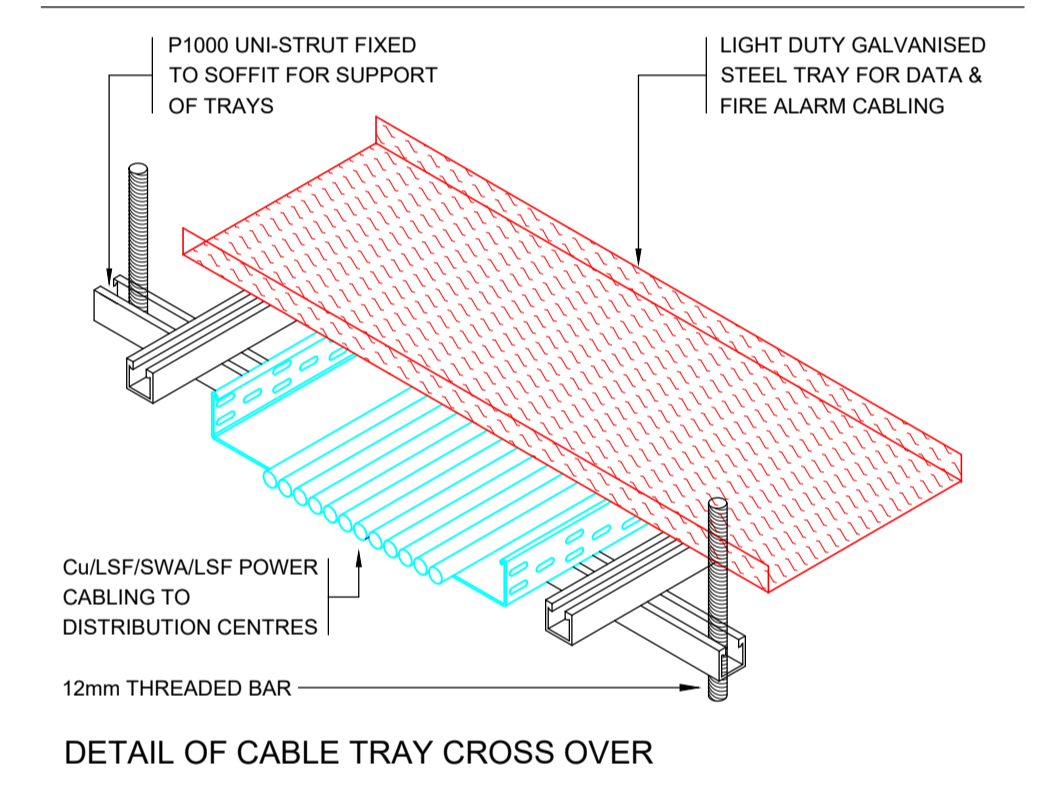

NOTE: ARCHITECTURAL DRAWING USED FOR COMPILATION OF IN2 DRAWING. ARCHITECTURAL DRAWING REVISION: DATE RECEIVED: 14.06.2019

STATUS	DATE	DESCRIPTION	DRN	ENG	APP	REV
S4	18.06.2019	CONSTRUCTION ISSUE	JDT	TH	BF	C2
S4	18.10.2018	CONSTRUCTION ISSUE	KO	TH	BF	C1

**IN2**  
ENGINEERING DESIGN PARTNERSHIP  
DUBLIN . ATHLONE . BELFAST . LONDON



PROJECT  
**BELSIZE PARK FIRESTATION**


CLIENT  
**PLATINUM LAND**

DRAWING TITLE  
ELECTRICAL SERVICES INSTALLATION  
BASEMENT LEVEL 1  
CABLE CONTAINMENT SERVICES LAYOUT

SCALE	SIZE	PROJECT REF:	DRAWING No.
1:100 @ A1 1:200 @ A3	A1	L18051	L18051-IN2-00-B1-DR-E-7001

STATUS	REVISION
S4	C2




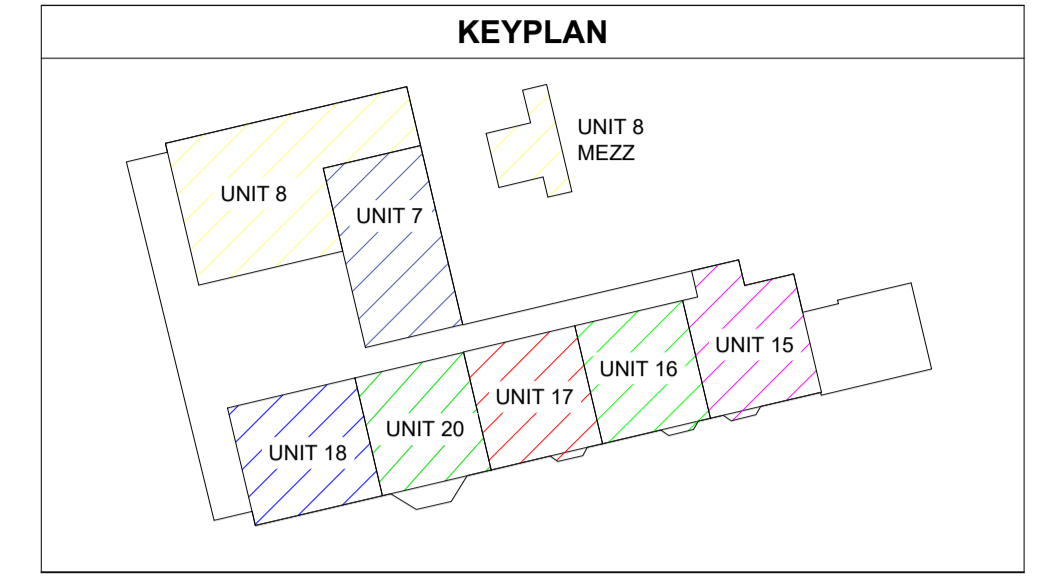

- NOTES**
- 1.00 THIS DRAWING IS REPRESENTATIVE OF PRIMARY CONTAINMENT INSTALLATIONS. ANY ADDITIONAL CABLE CONTAINMENT OR CONDUIT RUNS REQUIRED BY THE SPECIFICATION OR REQUIRED BY THE CONTRACTOR TO PROVIDE A COMPLETE INSTALLATION WILL BE DEEMED TO BE INCLUDED.
  - 2.00 THIS DRAWING IS TO READ IN CONJUNCTION WITH ALL OTHER SERVICES INSTALLATION DRAWINGS AND WITH CO-ORDINATED MECHANICAL AND ELECTRICAL DRAWINGS PREPARED BY IN2 ENGINEERING DESIGN PARTNERSHIP.
  - 3.00 ALL CABLE CONTAINMENT SYSTEMS AT ROOF LEVEL SHALL BE OF GALVANISED STEEL CONSTRUCTION RAISED "OFF" THE ROOF LEVEL ON UNI-STRUT SUPPORT BRACKETS.
  - 4.00 A SPACING OF 300mm WILL BE PROVIDED BETWEEN ALL L.V. POWER DISTRIBUTION CABLE TRAY / LADDER SYSTEMS AND FIRE DETECTION CONTAINMENT SYSTEMS

**CABLE CONTAINMENT SYSTEM REFERENCE KEY**

	225x50mm GALVANISED STEEL CABLE TRAY AT HIGH LEVEL FOR SUB-MAINS CABLE INSTALLATION.
	100x50mm GALVANISED STEEL TRUNKING AT HIGH LEVEL FOR LIGHTING & GENERAL SERVICES.
	150x50mm COMBINED ELV GALVANISED STEEL CABLE TRAY FOR I.T. STRUCTURED CABLING & FIRE ALARM.

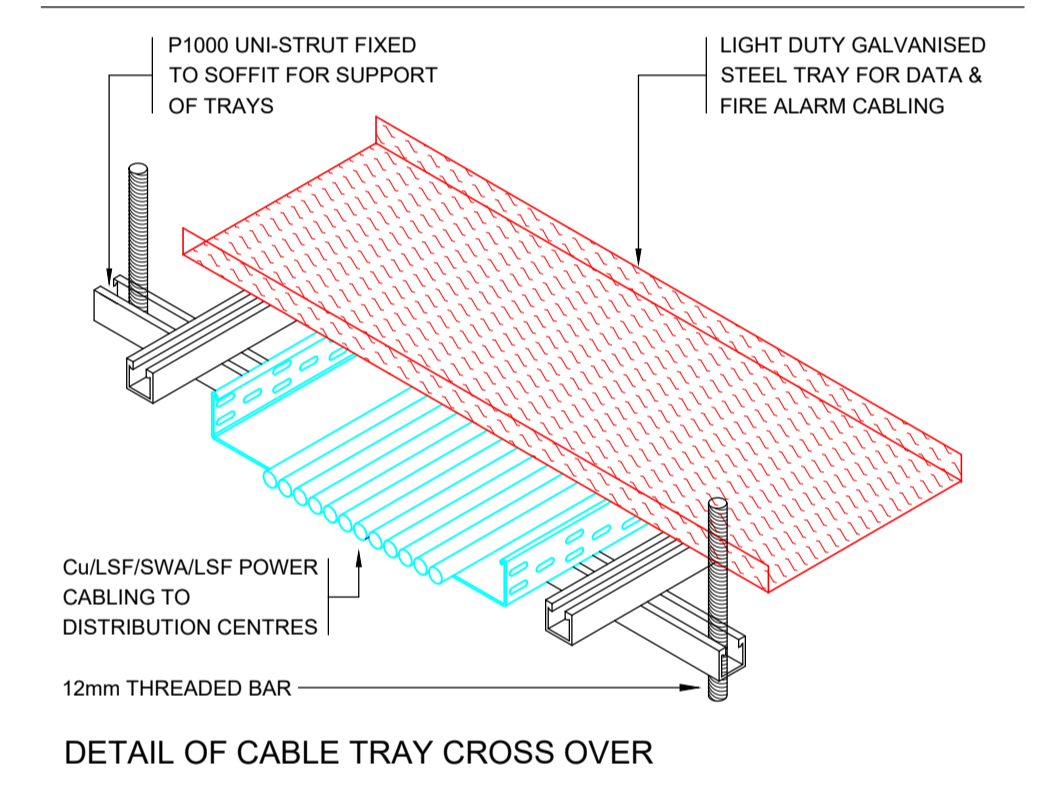

NOTE: ARCHITECTURAL DRAWING USED FOR COMPILATION OF IN2 DRAWING. ARCHITECTURAL DRAWING REVISION : DATE RECEIVED : 14.06.2019

STATUS	DATE	DESCRIPTION	DRN	ENG	APP	REV
S4	18.06.2019	CONSTRUCTION ISSUE	JDT	TH	BF	C2
S4	18.10.2018	CONSTRUCTION ISSUE	KO	TH	BF	C1

**IN2**  
ENGINEERING DESIGN PARTNERSHIP  
DUBLIN . ATHLONE . BELFAST . LONDON





PROJECT  
**BELSIZE PARK FIRESTATION**



CLIENT  
**PLATINUM LAND**

DRAWING TITLE <b>ELECTRICAL SERVICES INSTALLATION FIRST FLOOR LEVEL CABLE CONTAINMENT SERVICES LAYOUT</b>		STATUS <b>S4</b>
SCALE 1:100 @ A1 1:200 @ A3	PROJECT REF: <b>L18051</b>	REVISION <b>C2</b>
SIZE <b>A1</b>	DRAWING No. <b>L18051-IN2-00-01-DR-E-7001</b>	



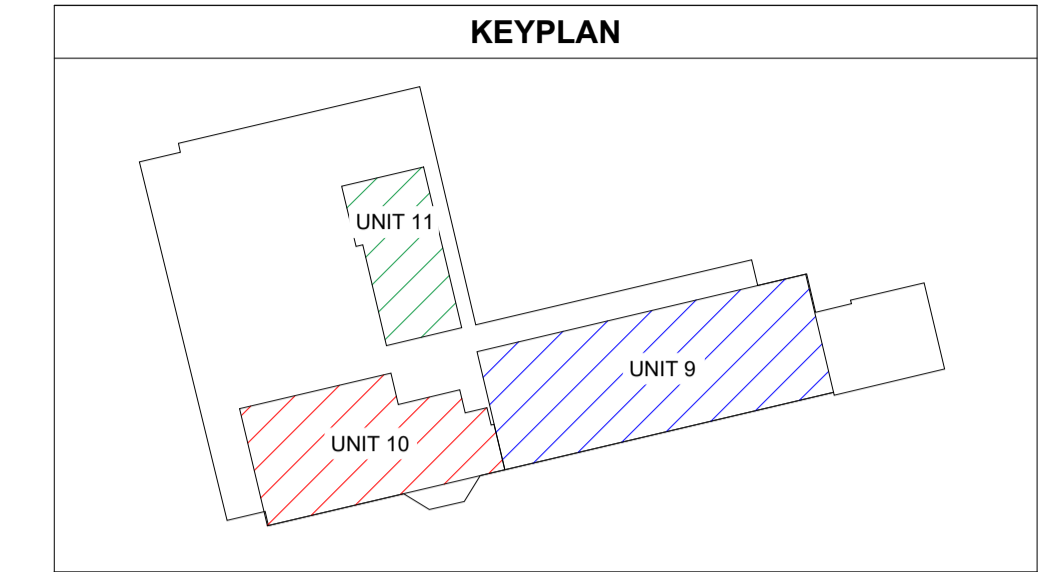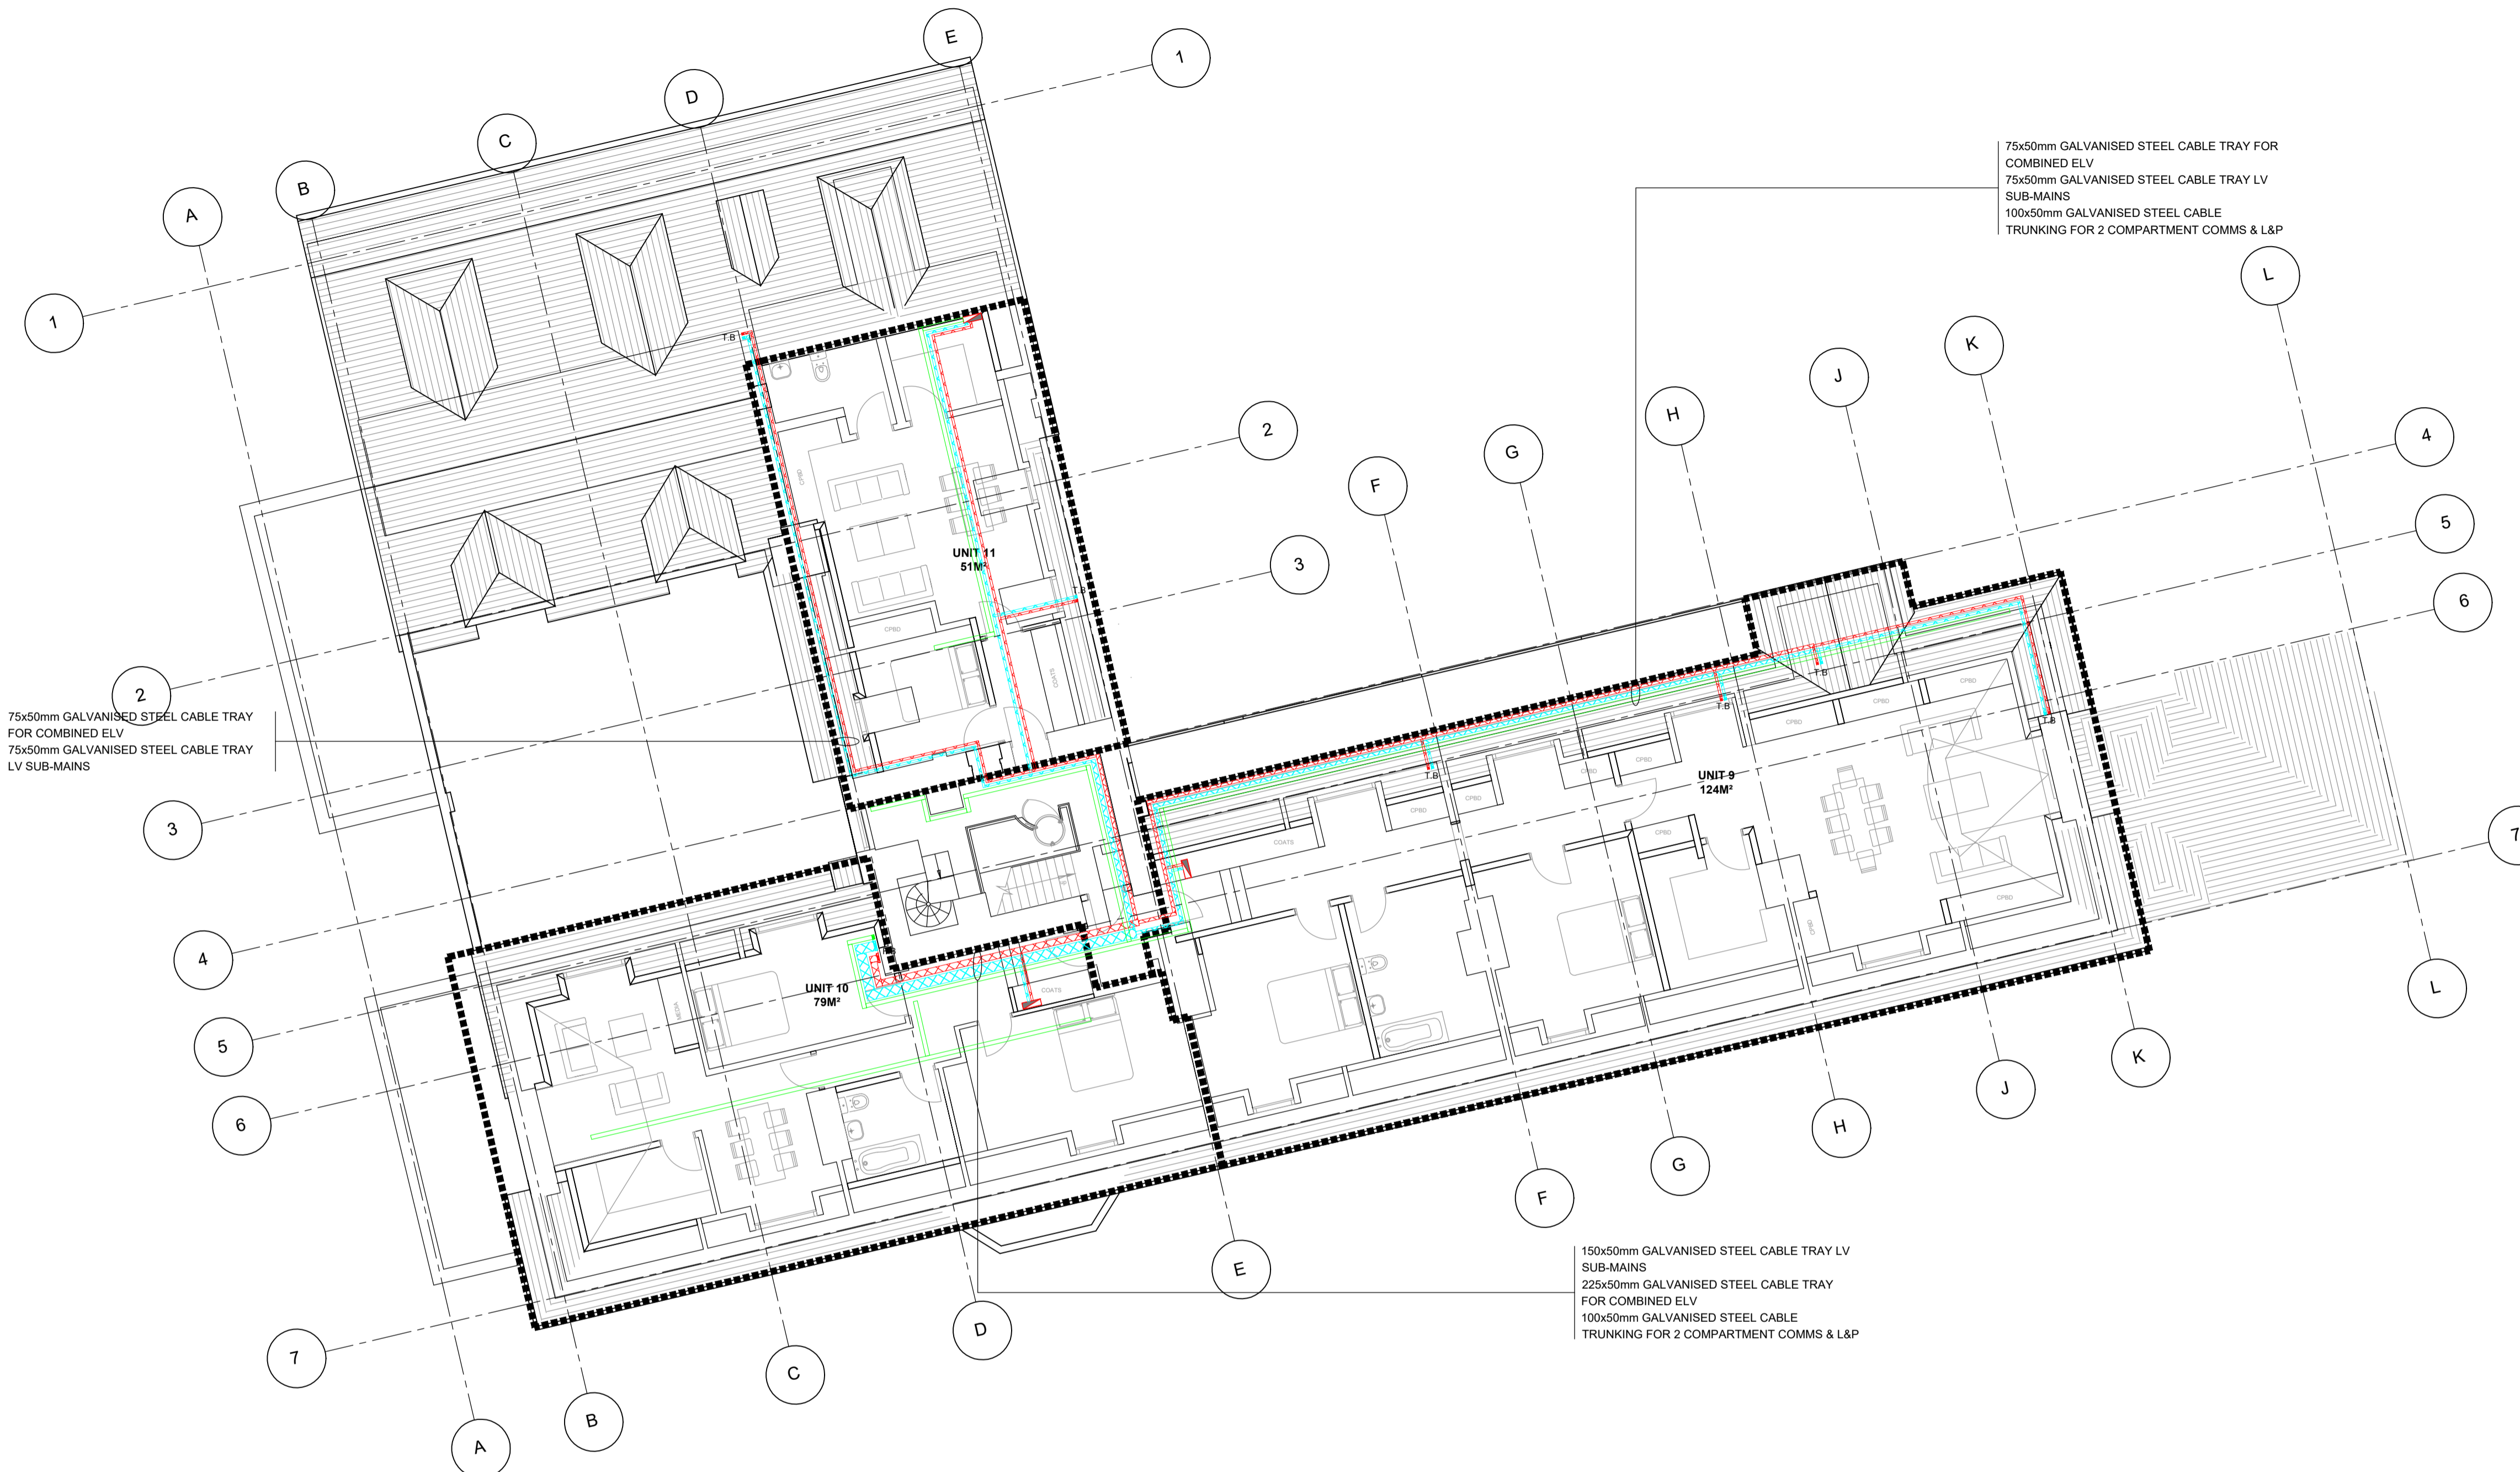

- NOTES**
- 1.00 THIS DRAWING IS REPRESENTATIVE OF PRIMARY CONTAINMENT INSTALLATIONS. ANY ADDITIONAL CABLE CONTAINMENT OR CONDUIT RUNS REQUIRED BY THE SPECIFICATION OR REQUIRED BY THE CONTRACTOR TO PROVIDE A COMPLETE INSTALLATION WILL BE DEEMED TO BE INCLUDED.
  - 2.00 THIS DRAWING IS TO READ IN CONJUNCTION WITH ALL OTHER SERVICES INSTALLATION DRAWINGS AND WITH CO-ORDINATED MECHANICAL AND ELECTRICAL DRAWINGS PREPARED BY IN2 ENGINEERING DESIGN PARTNERSHIP.
  - 3.00 ALL CABLE CONTAINMENT SYSTEMS AT ROOF LEVEL SHALL BE OF GALVANISED STEEL CONSTRUCTION RAISED "OFF" THE ROOF LEVEL ON UNI-STRUT SUPPORT BRACKETS.
  - 4.00 A SPACING OF 300mm WILL BE PROVIDED BETWEEN ALL L.V. POWER DISTRIBUTION CABLE TRAY / LADDER SYSTEMS AND FIRE DETECTION CONTAINMENT SYSTEMS

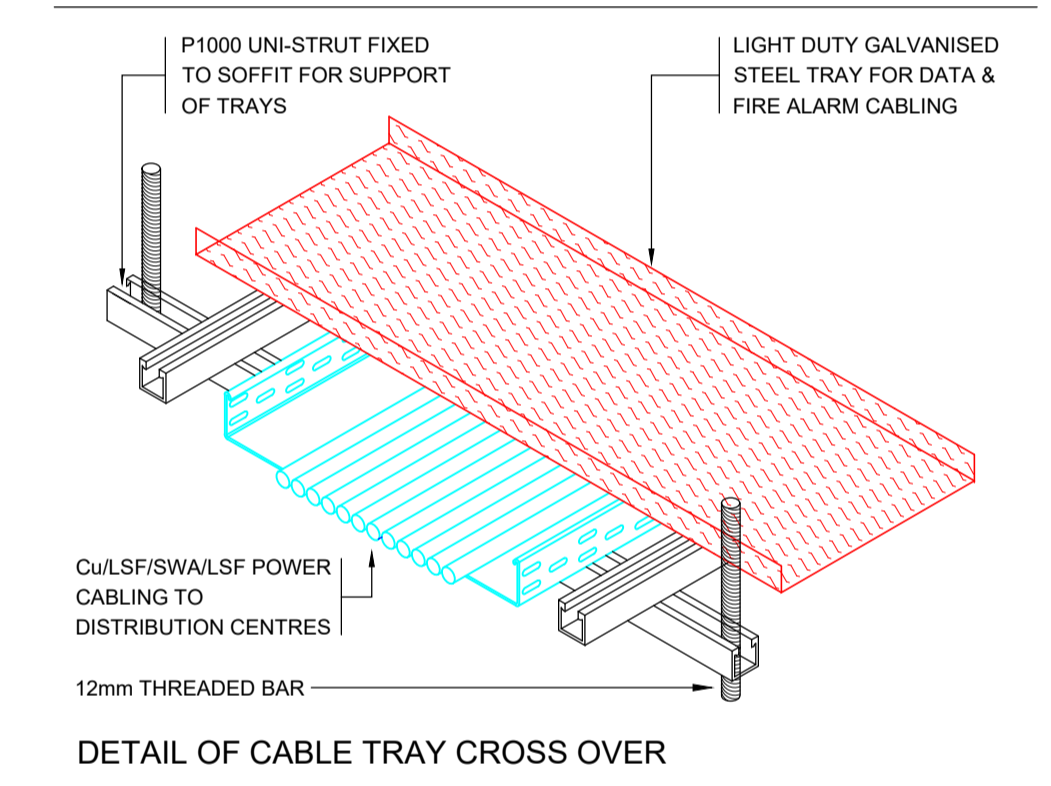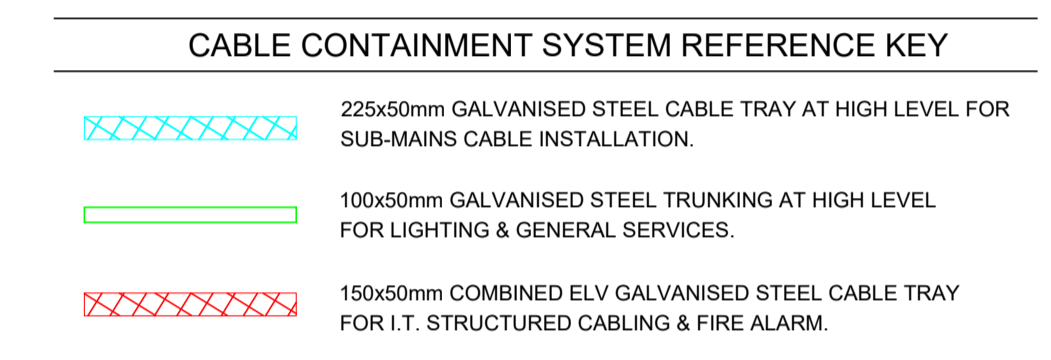

NOTE: ARCHITECTURAL DRAWING USED FOR COMPILATION OF IN2 DRAWING. ARCHITECTURAL DRAWING REVISION: DATE RECEIVED: 14.06.2019

STATUS	DATE	DESCRIPTION	DRN	ENG	APP	REV
S4	18.06.2019	CONSTRUCTION ISSUE	JDT	TH	BF	C2
S4	18.10.2018	CONSTRUCTION ISSUE	KO	TH	BF	C1

**IN2**  
ENGINEERING DESIGN PARTNERSHIP  
DUBLIN . ATHLONE . BELFAST . LONDON



PROJECT  
**BELSIZE PARK FIRESTATION**

CLIENT  
**PLATINUM LAND**

DRAWING TITLE  
ELECTRICAL SERVICES INSTALLATION  
SECOND FLOOR LEVEL  
CABLE CONTAINMENT SERVICES LAYOUT

SCALE  
1:100 @ A1  
1:200 @ A3

PROJECT REF: **A1 L18051**

DRAWING No.  
L18051-IN2-00-02-DR-E-7001

STATUS  
**S4**

REVISION  
**C2**