




— Green line denotes the extent of the premises.
— Blue line denotes area to be used for the performance of a play.
— Red line denotes area to be used for the sale of alcohol, including regulated entertainment and late night refreshments.

The position of fire safety equipment as shown on the plan or such position as agreed from time to time in consultation with the fire authority.

FIRE SAFETY REQUIREMENTS			
	ILLUMINATED EMERGENCY EXIT SIGN (MAINTAINED)		CARBON DIOXIDE EXTINGUISHER
	EMERGENCY LIGHT FITTINGS		FOAM EXTINGUISHER
	SMOKE DETECTOR		WATER EXTINGUISHER
	HEAT DETECTOR		FIRE PROCEDURE NOTICE
	SMOKE DETECTOR WITH SOUNDER		FIRE BLANKET
	HEAT DETECTOR WITH SOUNDER		FIRE RESISTING DOOR
	FIRE ALARM CALL POINT		FIRE ALARM PANEL
	SOUNDER		EXIT DOORS FITTED WITH PUSH BARS AND PANIC BOLTS PUSH BAR TO OPEN: NOTICE TO BE FITTED ABOVE THE PUSH BAR IN 50mm HIGH WHITE LETTERING ON GREEN BACKGROUND. PUSH BARS FITTED BETWEEN 900mm & 1100mm ABOVE FINISHED FLOOR LEVEL FASTENINGS INSTALLED TO B.S.5725 - PART 1 - 1981
			NOTICE FIRE DOOR KEEP LOCKED SHUT IN 50mm HIGH WHITE LETTERING ON BLUE BACKGROUND.
			NOTICE FIRE DOOR KEEP SHUT IN 50mm HIGH WHITE LETTERING ON BLUE BACKGROUND.
			NOTICE FIRE DOOR KEEP CLEAR IN 50mm HIGH WHITE LETTERING ON BLUE BACKGROUND.
			VISION PANEL IN DOOR
			EMERGENCY LIGHTS The emergency lighting system which must illuminate the escape route if the mains supply fails, must be fitted in accordance with B.S.5269
			FIRE ALARM The fire alarm system should comply with B.S.5839 - Part 1 1999 and should be audible throughout the building
			Fire fighting Equipment. 9 litre water type fire extinguisher. 4.5kg capacity (34B rating) carbon dioxide content extinguisher. Extinguishers to be placed on wall brackets so that the top of the extinguisher is about 1m above floor. An approved fire blanket and container should be provided for the kitchen
			Fire exit signs conforming to the requirements of B.S.5499. Directional fire exit signs conforming to the requirements of B.S.5499 to be positioned at each change of direction or each part escape route where the exit doors are not readily visible to persons using the escape route.

THIS DRAWING HAS BEEN PRODUCED FROM EXISTING AND PROPOSED DRAWINGS SUPPLIED BY THE CLIENT INDICATING THE POSITIONS OF THE EMERGENCY LIGHTING AND FIRE DETECTION SYSTEM.

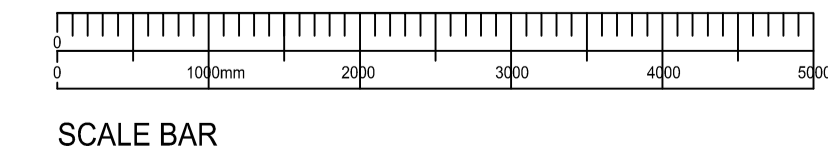

Thomas Moss
 Architectural Design and Surveying Services
 Summit House, Horsecroft Road, The Pinnacles, Harlow, Essex, CM19 5BN
 Tel: 07702 477199
 E-Mail: t.moss@pentbrook.co.uk

Client: LABTECH INVESTMENTS LTD

Project: SELKIRK HOUSE
 166 HIGH HOLBORN
 LONDON

Drawing Title: LICENSING DRAWING
 FIRST FLOOR LAYOUT

Drawing No: 251/19/04
 Scale: 1:100@A1 & 1:200@A3
 Date: 3.9.2019
 Drawn By: TAM

Revision:

Drawing not to be scaled. Dimensions indicated must be checked on site before manufacture by contractor, any discrepancy should be reported immediately.