

FOR CONTINUATION SEE DRG No. - 63-101S2

FOR CONTINUATION SEE DRG No. - 63-101N2

1 Lighting Layout Level 01 (Block N1)
 1 : 100

MDB-01-N2-01		
CCT	LCM	FCU
411/L/1L1	LCM-01-N2-01	
411/L/2L1	LCM-01-N2-02	
411/L/3L1	LCM-01-N2-03	
411/P/3L1		FCU-01-N2-01
411/P/4L1		FCU-01-N2-02
		FCU-01-N2-03

SERVICES DATUM LEVELS
 ALL SERVICES ABOVE DATUM DENOTED THIS:-
 [XXXX] DISTANCE IN mm TO US OF RECTANGULAR & FLAT OVAL DUCTS, ELECTRICAL BUSBARS, CABLE LADDERS, TRAYS, TRUNKING, & CENTRE LINE OF CIRCUITS & PIPEWORK. LEVELS PREFIXED IL INDICATES INVERT LEVEL OF SOIL, GRAVITY RAINWATER & CONDENSATE PIPE ABOVE DATUM LEVEL. LEVELS PREFIXED T.O.P INDICATES LEVEL TO TOP OF PIPE FOR SIPHONIC RAINWATER ABOVE DATUM

Status Code (as defined in BS1192)
 D3 - Issued for contractor design
 D4 - Issued for manufacture/procurement

Work in Progress (WIP)
 S0 - Initial Status or WIP


Shared
 S1 - Issued for co-ordination
 S2 - Issued for information
 S3 - Issued for internal review
 S4 - Issued for construction approval

Documentation (Pre-construction)
 D1 - Issued for costing
 D2 - Issued for tender

SOFFIT LEVEL	+ 33750
CEILING LEVEL	-
DATUM LEVEL	+ 31400
FINISHED FLOOR LEVEL	+ 30400
STRUCTURAL SLAB LEVEL	VARIES

- FOR SYMBOLS LEGEND AND ABBREVIATIONS REFER TO DRAWING: KXC-T2-001-E-BSE4507-61-0500
- THIS DRAWING IS TO BE READ IN CONJUNCTION WITH THE ARCHITECTS AND STRUCTURAL ENGINEER DRAWINGS AND SPECIFICATIONS.
- THIS DRAWING IS TO BE READ IN CONJUNCTION WITH THE RELEVANT DETAILS AND SCHEMATICS.
- LIGHT FITTINGS SHOWN IN DOTTED ARE FOR FUTURE CONNECTION.
- O TYPE FITTING SHOWN FOR POSITION AND CIRCUITRY ONLY. LUMINAIRE SUPPLIED BY TOILET FITOUT COMPANY. JOINT BOX (JB) PROVIDED AT HIGH LEVEL ONLY.
- ALL FCU SPURS TO BE POSITIONED WITH ONE METER OF FAN COIL CONNECTION POINT.
- MDB & LCM POSITIONED TO BE COORDINATED WITH HIGH LEVEL CONTAINMENT DRAWINGS POSITIONED TO MATCH INVERTED TRAY LOCATIONS.

C01 XS RA 03/09/19 ISSUED FOR CONSTRUCTION
 P01 XS RA 19/07/19 ISSUED FOR APPROVAL

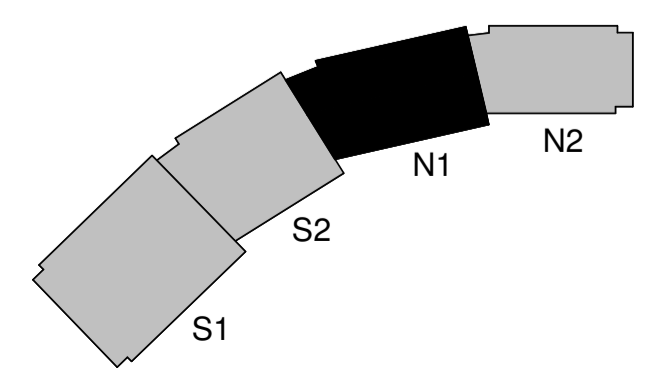

project Kings Cross T Zone
 title Lighting Layout Level 01 (Block N1)
 scale 1 : 100 @ A1
 date 19/07/19
 dcr ref KXC-T2-001-E-BSE4507-63-101N1

purpose of issue
CONSTRUCTION
 BAM job no. 4507
 rev. C01