

FOR CONTINUATION SEE DRG No. - 63-101S2

KEYSWITCH LOCATED BY T2/01/DBL/S1124 FOR EMERGENCY LIGHT TESTING

1 Lighting Layout Level 01 (Block S1)
 1 : 100


SERVICES DATUM LEVELS
 ALL SERVICES ABOVE DATUM DENOTED THUS:-
 [XXXX] DISTANCE IN mm TO U/S OF RECTANGULAR & FLAT OVAL DUCTS, ELECTRICAL BUSBARS, CABLE LADDERS, TRAYS, TRUNKING, & CENTRE LINE OF CIRC DUCTS & PIPEWORK LEVELS PREFIXED I.L INDICATES INVERT LEVEL OF SOIL, GRAVITY RAINWATER & CONDENSATE PIPE ABOVE DATUM LEVEL. LEVELS PREFIXED T.O.P INDICATES LEVEL TO TOP OF PIPE FOR SIPHONIC RAINWATER ABOVE DATUM

SOFFIT LEVEL	+ 33750
CEILING LEVEL	-
DATUM LEVEL	+ 31400
FINISHED FLOOR LEVEL	+ 30400
STRUCTURAL SLAB LEVEL	VARIABLES

Status Code (as defined in BS1192)
 D3 - Issued for contractor design
 D4 - Issued for manufacture/procurement
Work In Progress (WIP)
 S0 - Initial Status or WIP
Shared
 S1 - Issued for co-ordination
 S2 - Issued for information
 S3 - Issued for internal review
 S4 - Issued for construction approval
Documentation (Pre-construction)
 D1 - Issued for costing
 D2 - Issued for tender

- FOR SYMBOLS LEGEND AND ABBREVIATIONS REFER TO DRAWING: KXC-T2-001-E-BSE4507-61-0500
- THIS DRAWING IS TO BE READ IN CONJUNCTION WITH THE ARCHITECTS AND STRUCTURAL ENGINEER DRAWINGS AND SPECIFICATIONS.
- THIS DRAWING IS TO BE READ IN CONJUNCTION WITH THE RELEVANT DETAILS AND SCHEMATICS.
- LIGHT FITTINGS SHOWN IN DOTTED ARE FOR FUTURE CONNECTION.
- O TYPE FITTING SHOWN FOR POSITION AND CIRCUITRY ONLY. LUMINAIRE SUPPLIED BY TOILET FITOUT COMPANY. JOINT BOX (JB) PROVIDED AT HIGH LEVEL ONLY.
- ALL FCU SPURS TO BE POSITIONED WITH ONE METER OF FAN COIL CONNECTION POINT.
- MDB & LCM POSITIONED TO BE COORDINATED WITH HIGH LEVEL CONTAINMENT DRAWINGS POSITIONED TO MATCH INVERTED TRAY LOCATIONS.

G01 XS RA 03/09/19 ISSUED FOR CONSTRUCTION
 P01 XS RA 22/07/19 ISSUED FOR APPROVAL

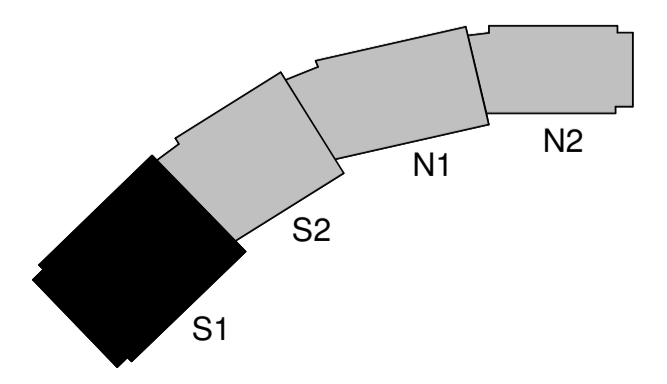

bam
 Services Engineering
 Environmental Services
 Cost Planning
 Feasibility Studies
 3D Visualisation
 Building Information Modelling
 Centrium
 Griffins Way
 St Albans
 Hertfordshire, AL1 2RD
 T 01442 238300
 F 01442 238301
 W www.bam.co.uk

project Kings Cross T Zone
 title Lighting Layout Level 01 (Block S1)
 purpose of issue CONSTRUCTION
 scale 1 : 100 @ A1
 date 22/07/19
 checked R.A
 drawn XS
 BAM job no. 4507
 rev. S4
 doc ref. KXC-T2-001-E-BSE4507-63-101S1
 content C01