
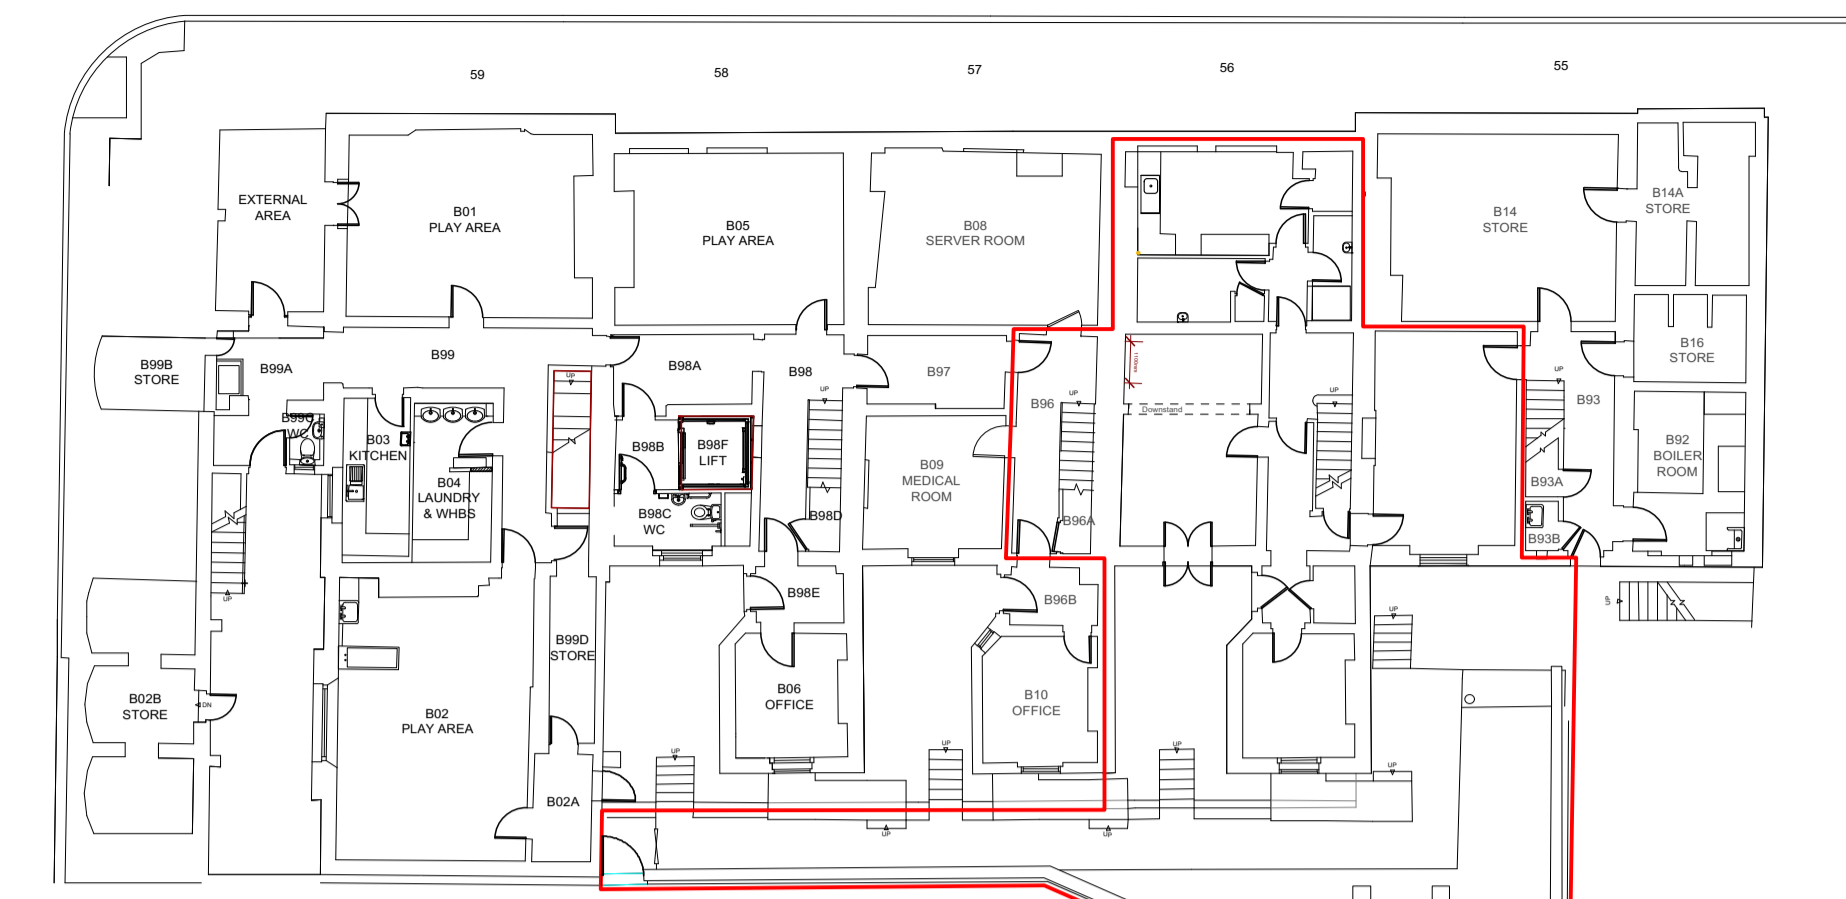


DRAINAGE NOTES:

- - - - - New below ground foul drainage as Schedule of Work Item 12.00
- - - - - Redundant foul drainage to be stripped and removed as Schedule of Work Item 12.02.
- - - - - Existing retained below ground foul drainage

Contractor to allow for all adaptations/alterations to the existing drainage to facilitate the installation.
 Allow to remove and reinstate flooring, finishes and other components necessary to complete the installation.

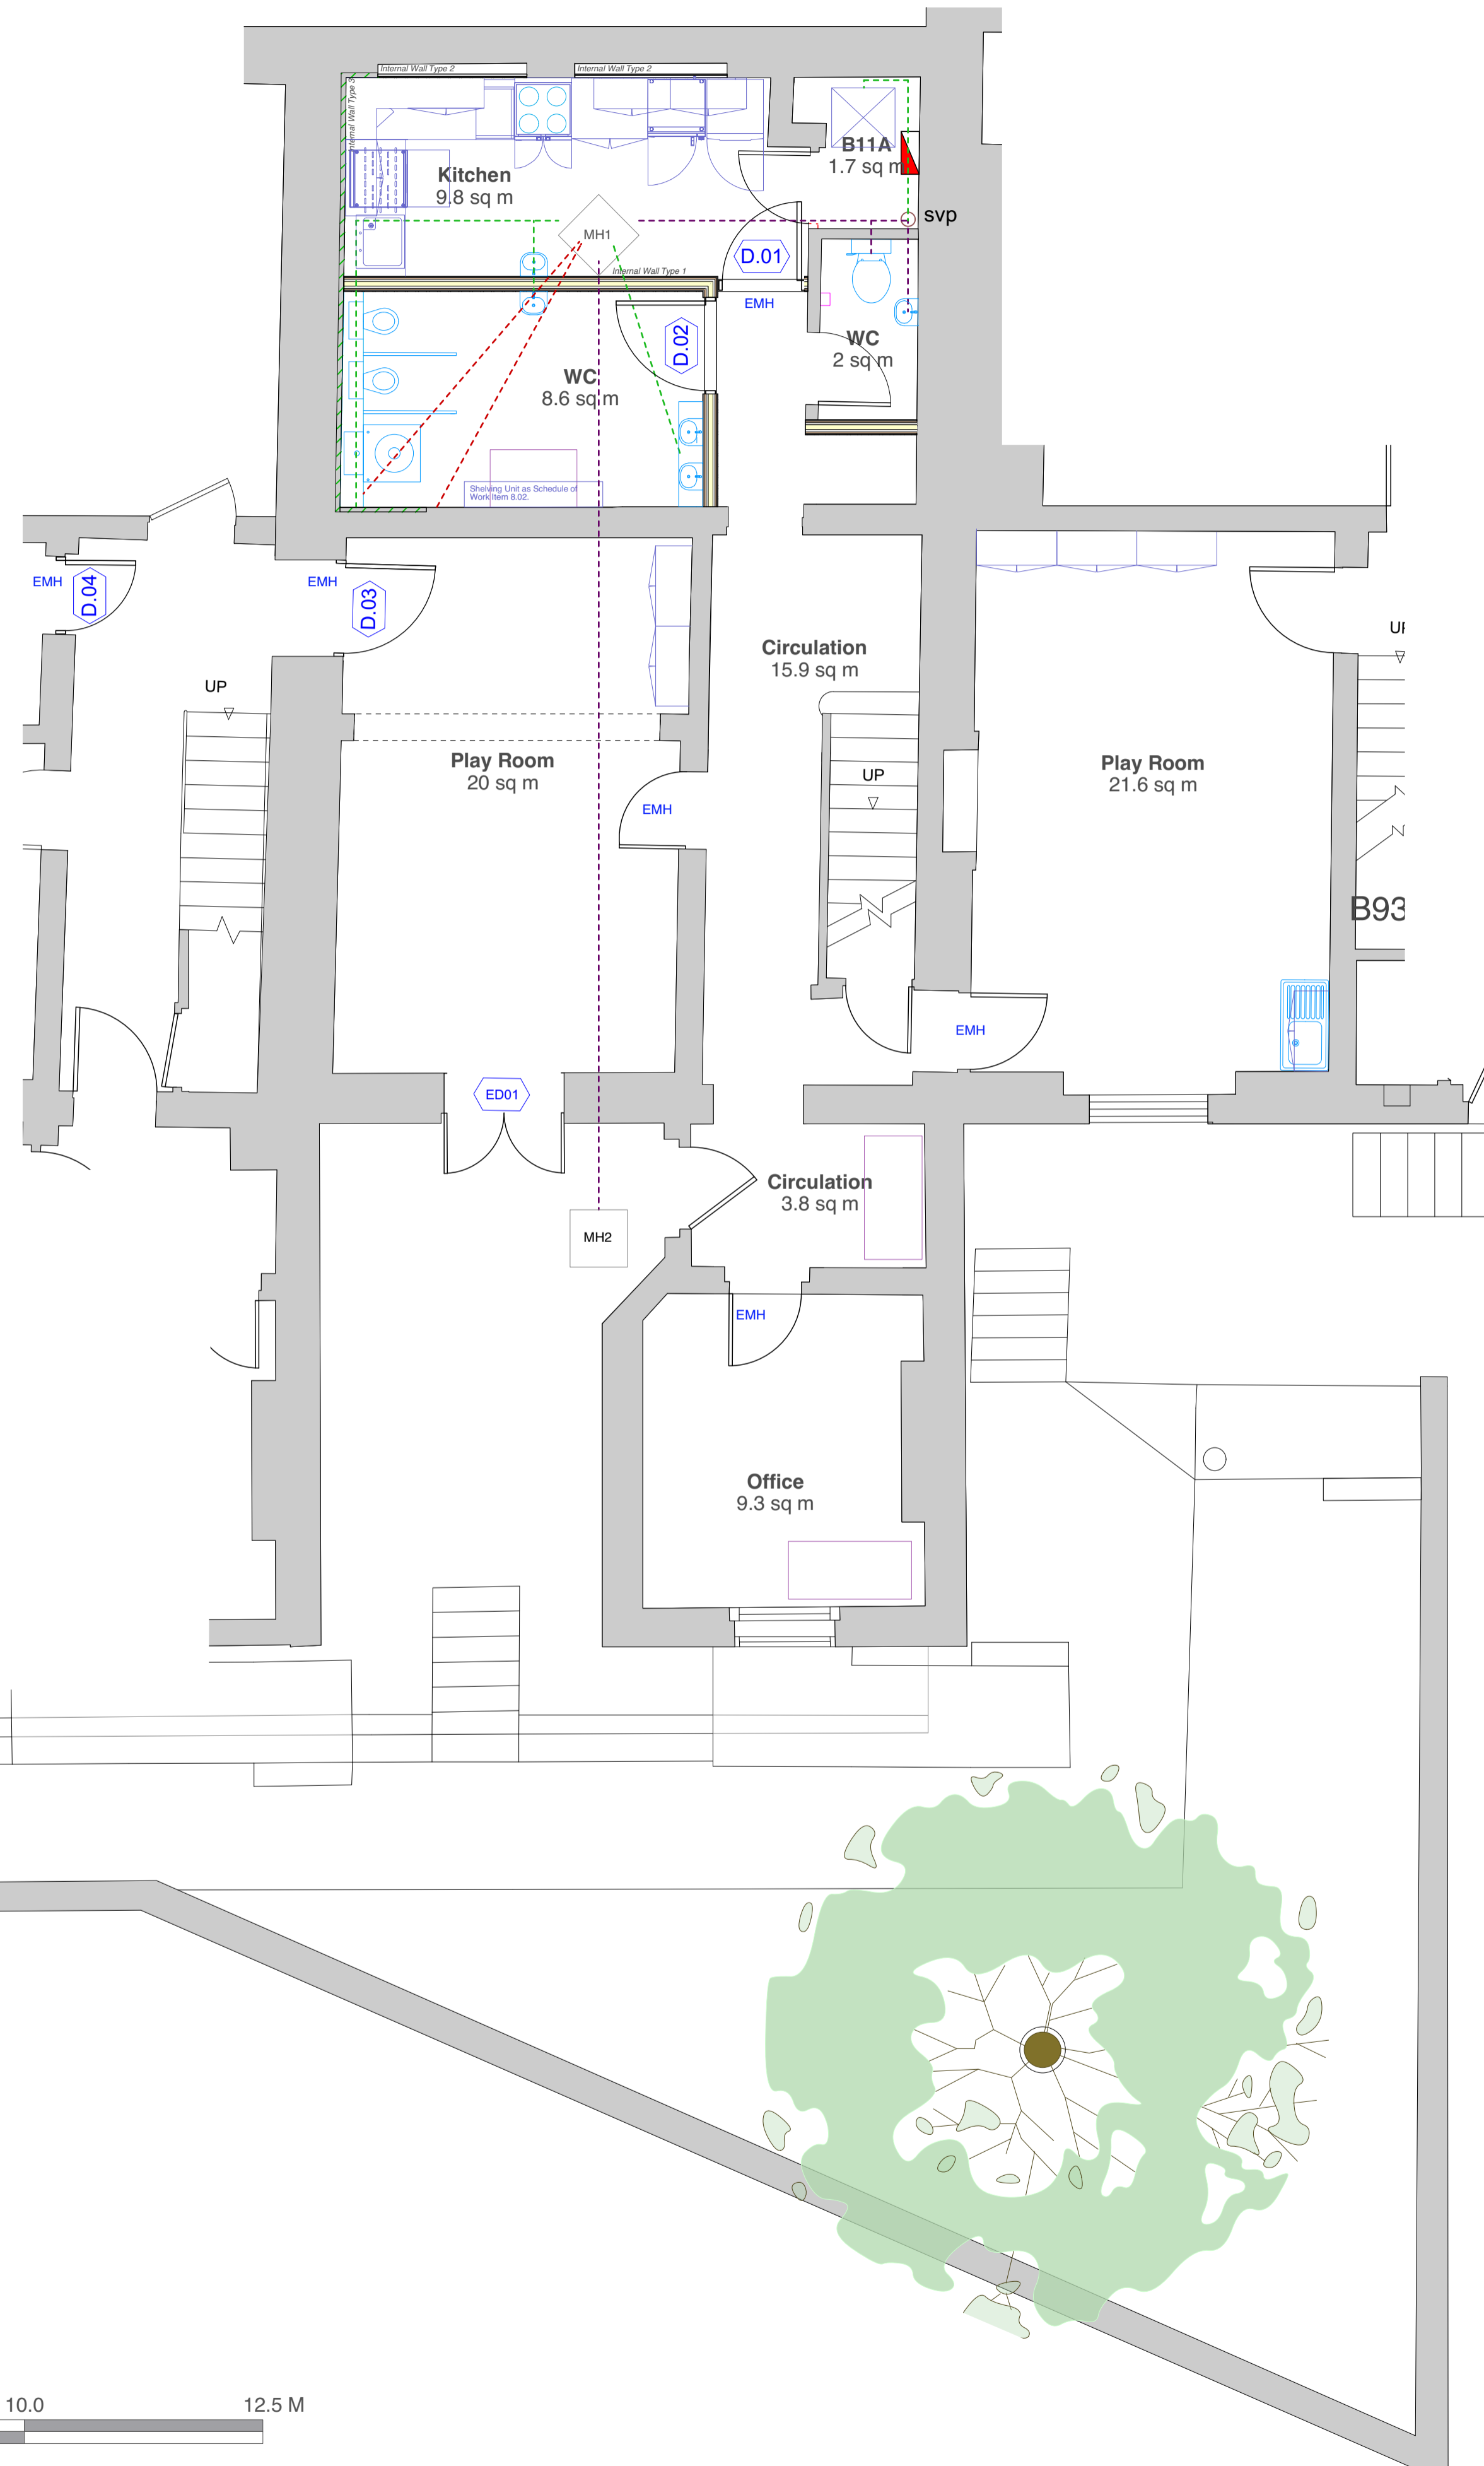

KEY PLAN
Scale 1:200

PROPOSED BELOW GROUND DRAINAGE PLAN



		Project 55-59 Gordon Square Day Nursery	Rev. Date By Ap. Note Drawing Title Proposed Below Ground Drainage Plan
		Client University College London	Project Number 190775 2210-P1
Chartered Architects Chartered Building Surveyors Interior Designers CDM Services Suite 3, Sandford House 1b Clarendon Rd, Teddington TW11 8DH +44 (0)20 8943 5300 www.kendallkingscott.co.uk		Drawing Number - Revision 190775 2210-P1	Date Drawn Checked Status 06/08/19 AP KS TENDER
Scale Paper Size Filename 1:50 A1 190775.vwx		Check all dimensions and levels on site © Copyright Do not scale this drawing	

Only to be used on the site for which designed. The electronic transmission of design information contained in this drawing is carried out on behalf of the User's site and Kendall Kingscott Ltd. We have no liability for any errors or inaccuracies arising therefrom. The production of amended or updated information from this user is entirely the responsibility of the User and Kendall Kingscott Ltd. shall have no responsibility or accept thereof whatsoever.