


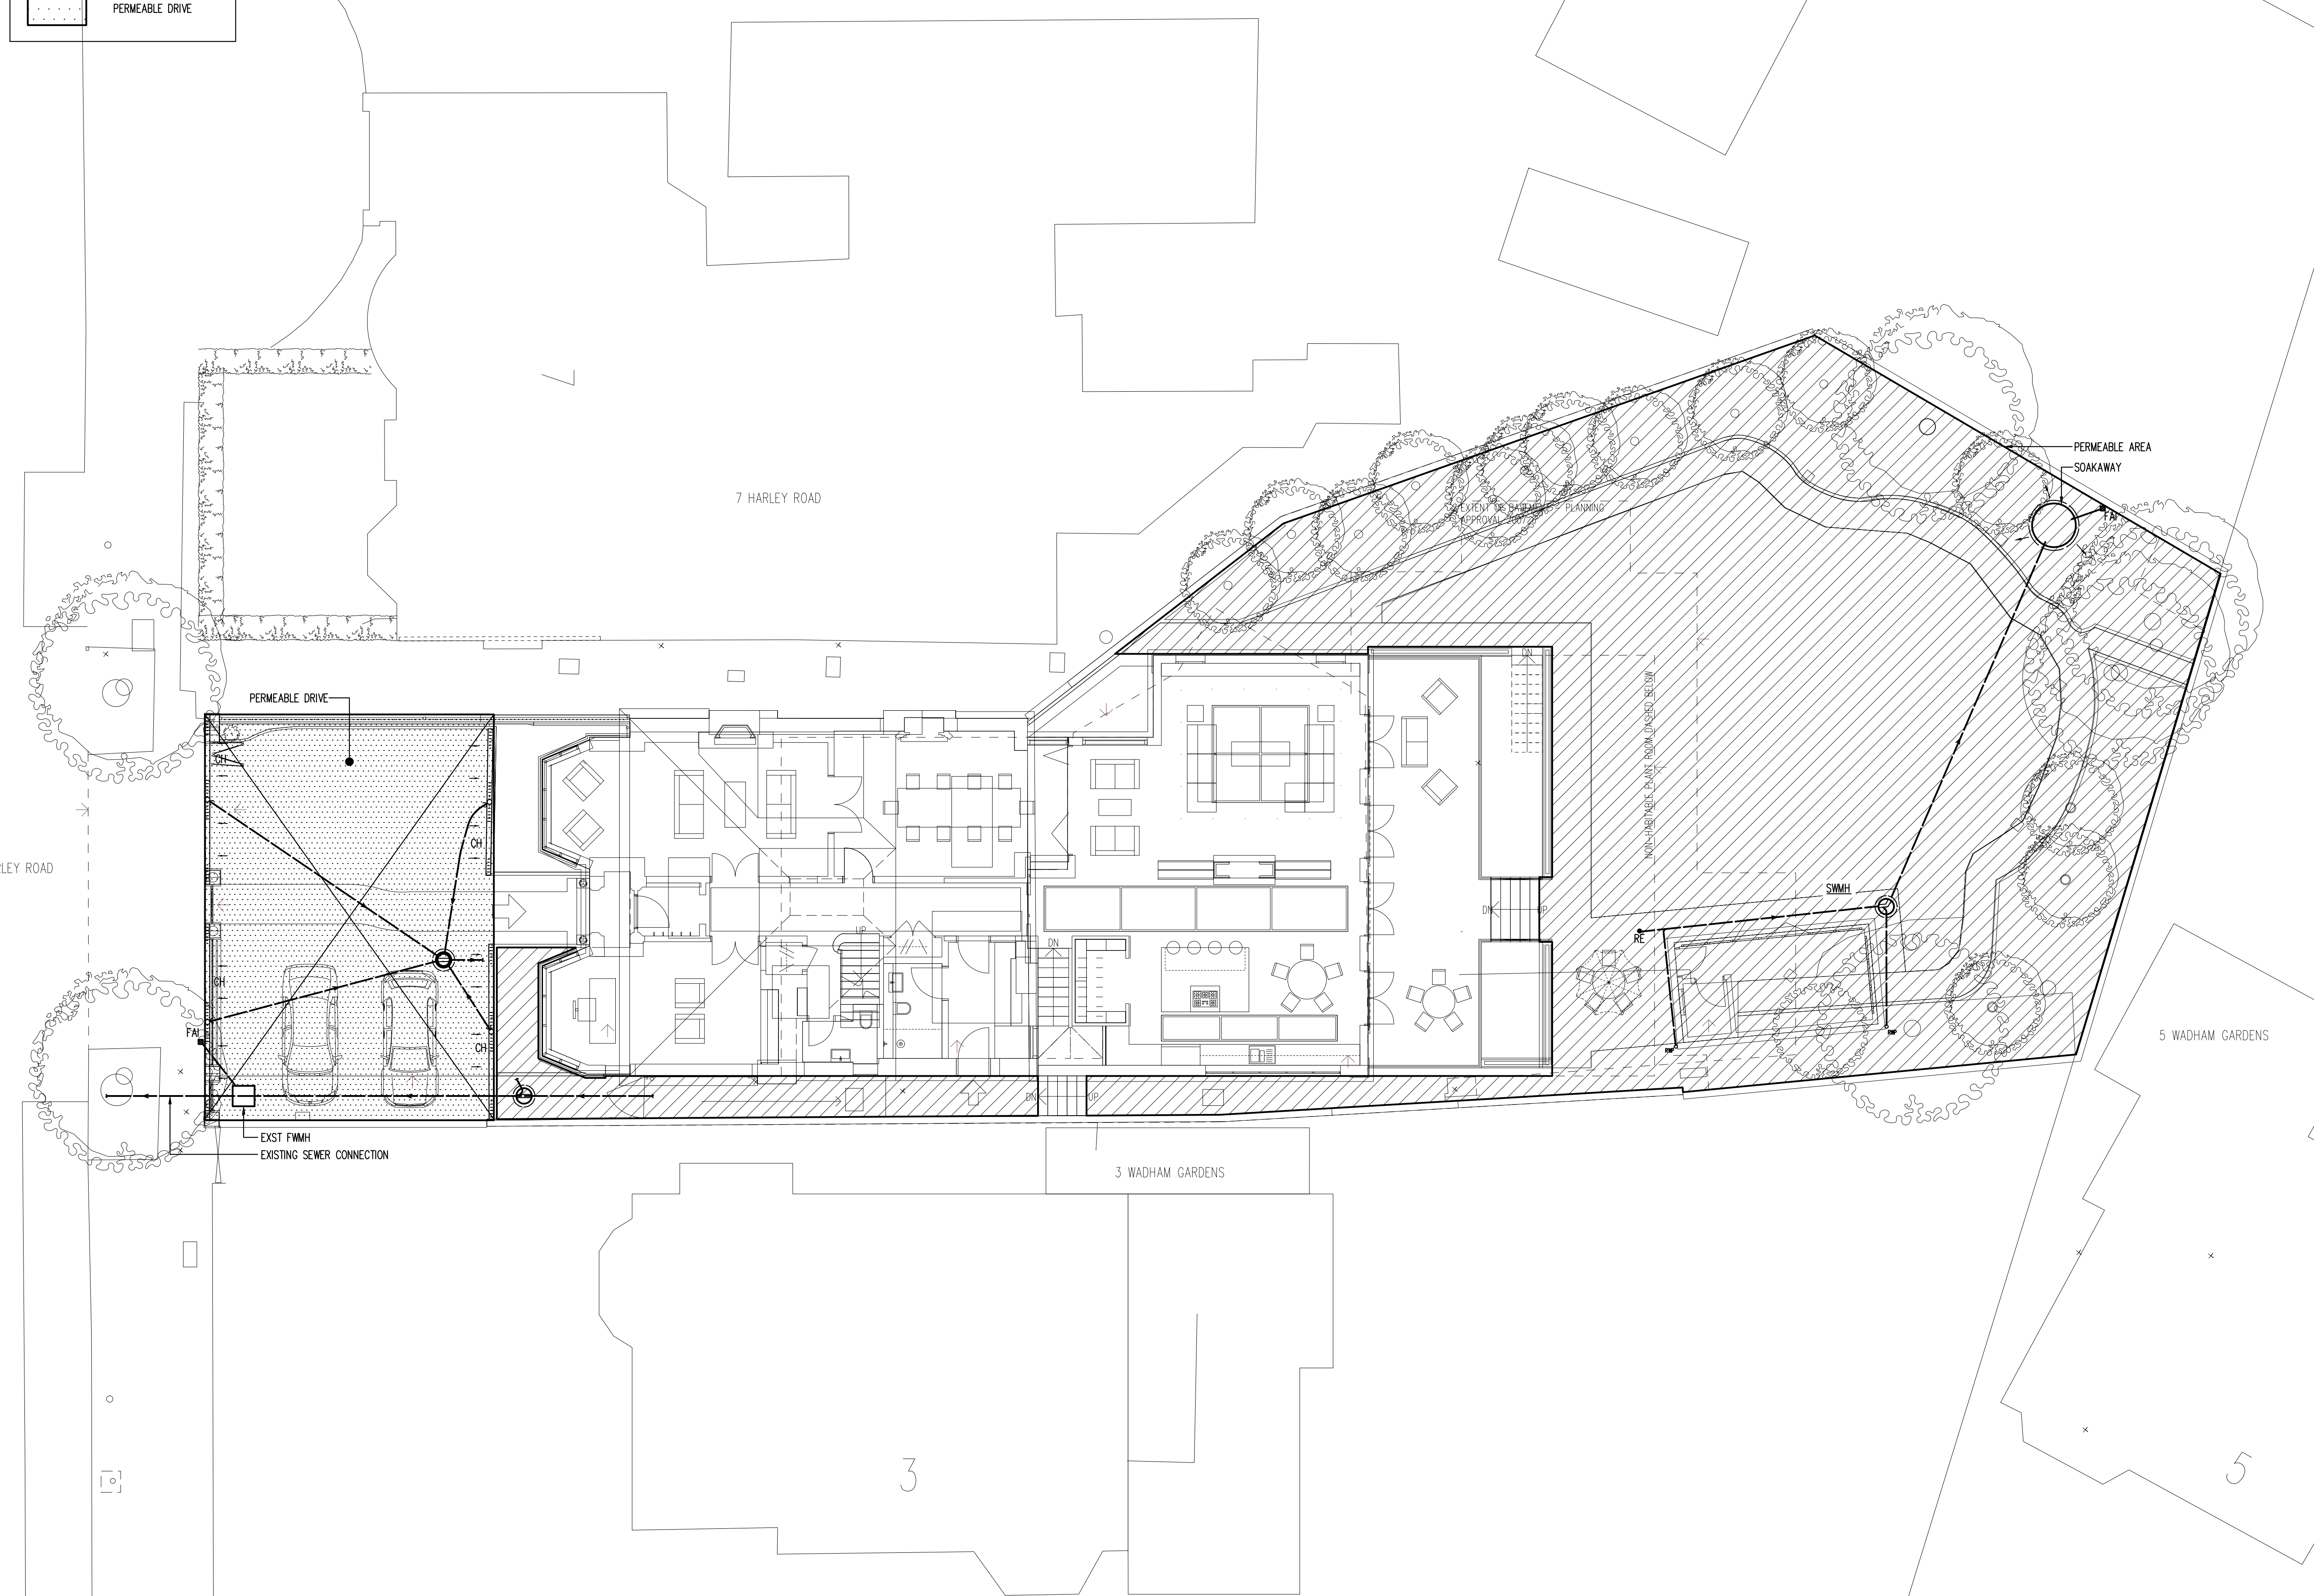

Site

Note	ALL DIMENSIONS TO BE VERIFIED ON SITE BEFORE SETTING OUT OR MAKING ANY SHOP DRAWINGS. THIS DRAWING IS TO BE READ IN CONJUNCTION WITH THE CONSULTANT ENGINEER'S SPECIFICATION.
------	---

Orientation

Rev./Date	REVISIONS
P 22.06.15	PRELIMINARY ISSUE
P1 06.07.15	PLANNING ISSUE
P2 24.07.15	UPDATED PLANNING ISSUE

ME7

ME7 Ltd.
Unit 2, Rays Farm Barns, Roman Road
Ingatestone, Essex CM4 9EH
Email: jb@me7.eu
Web: www.me7.eu
Tel: +44(0)1277 353225
M&E Consultants Energy Consultants



No.	Description
	SITE PLAN DRAINAGE SERVICES

Project

9 HARLEY ROAD
LONDON
NW3 3BX

Architect
SHH Architects
1 Vencourt Place
Ravenscourt Park
Hammersmith, London, W6 9NU
Tel: 0208 600 4171

xref		---
Scale	A1 @ 1:100 A3 @ 1:200	Drawn JB / MF
Date	June 2015	Checked

Issue	PRELIMINARY
-------	-------------

Project No.	Services	Dwg No.	Rev.
607	D	4	P2