



approved by: _____
 date: _____

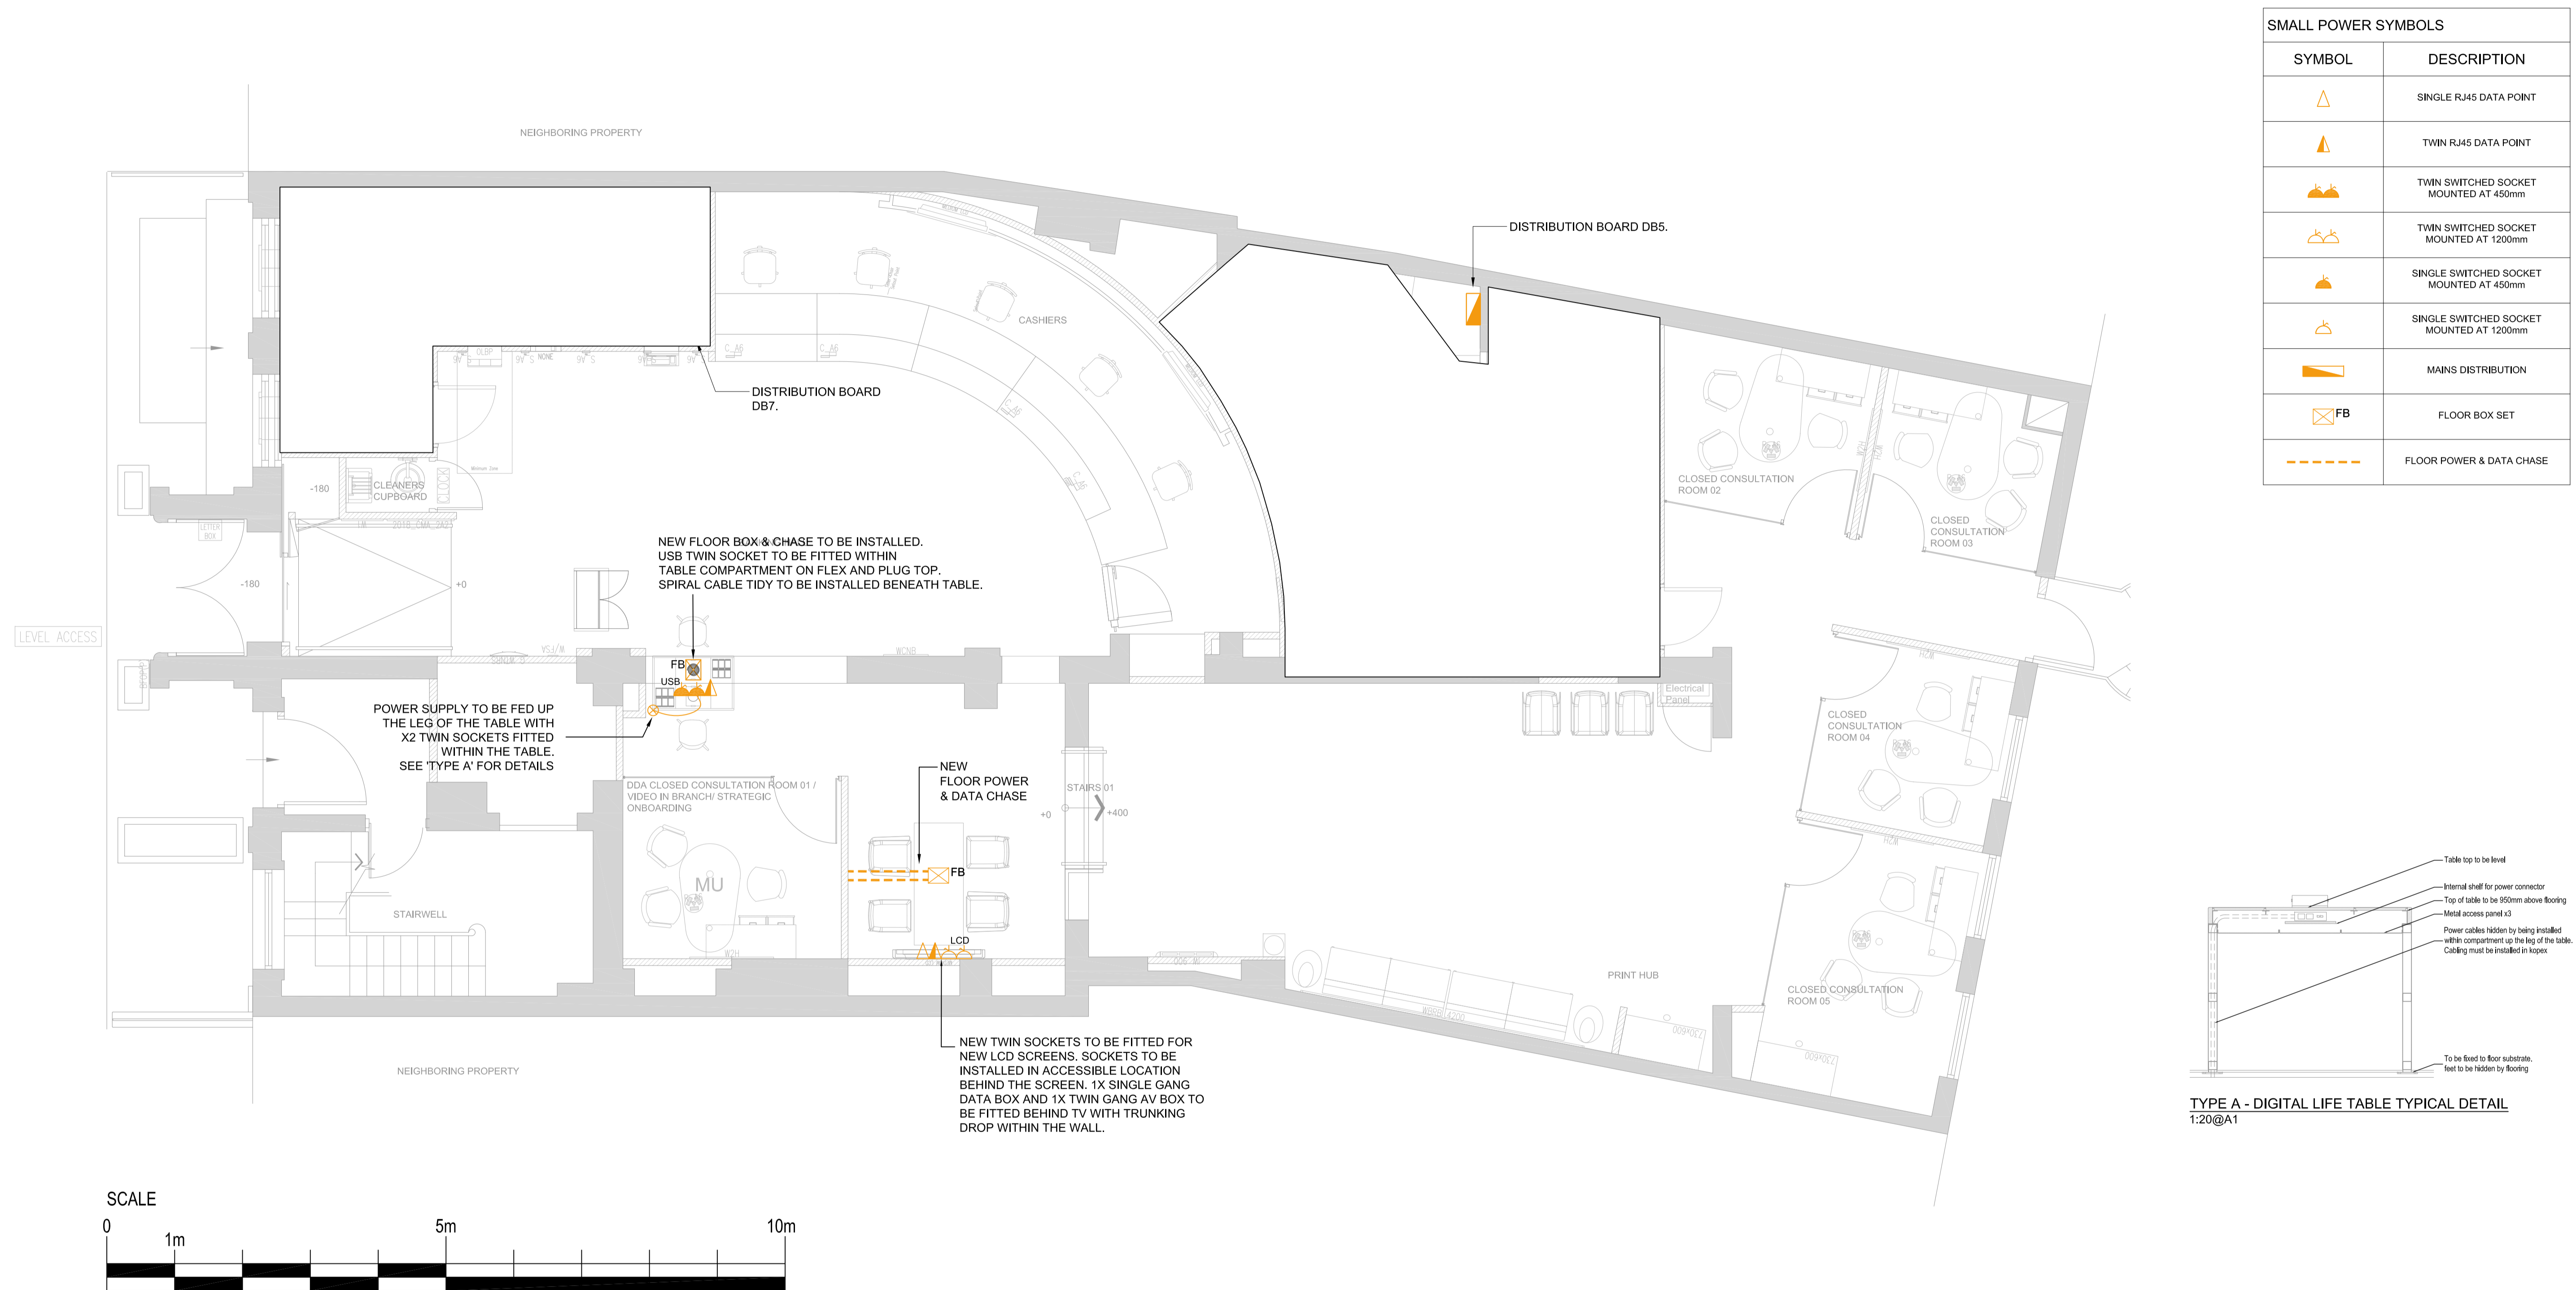

SMALL POWER SYMBOLS	
SYMBOL	DESCRIPTION
	SINGLE RJ45 DATA POINT
	TWIN RJ45 DATA POINT
	TWIN SWITCHED SOCKET MOUNTED AT 450mm
	TWIN SWITCHED SOCKET MOUNTED AT 1200mm
	SINGLE SWITCHED SOCKET MOUNTED AT 450mm
	SINGLE SWITCHED SOCKET MOUNTED AT 1200mm
	MAINS DISTRIBUTION
	FLOOR BOX SET
	FLOOR POWER & DATA CHASE

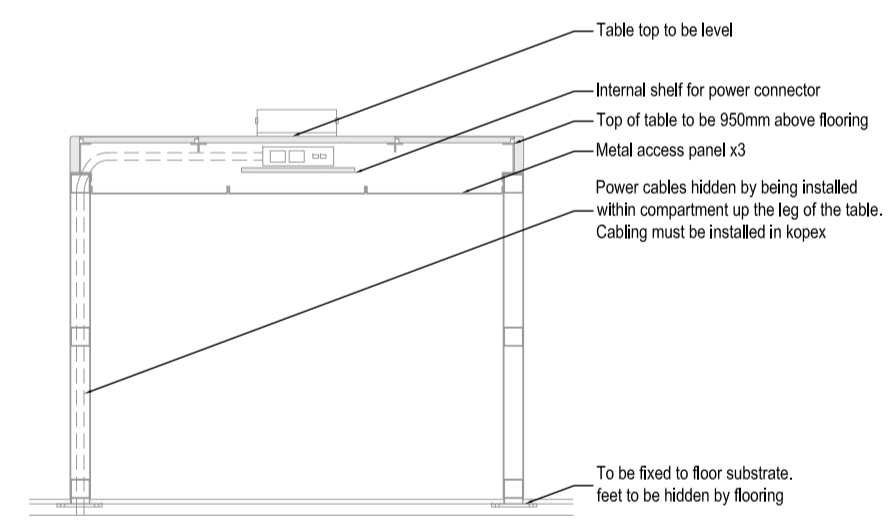

TYPE A - DIGITAL LIFE TABLE TYPICAL DETAIL
 1:20@A1

Rev	Date	Revision	Initials
01	05.11.19	FIRST ISSUE	HN

Stripout Notes:

Special Notes:

General Notes:

Client: **BARCLAYS**

Project: **HAMPSTEAD HIGH ST**
 28 HAMPSTEAD HIGH STREET,
 HAMPSTEAD
 LONDON,
 NW3 1QB

Status: **DESIGN**

All dimensions in mm except where otherwise stated. Dimensions up to 1 metre +/- 0.5mm, Dimensions 1 metre to 5 metres +/- 1mm. Except where otherwise stated © Copyright drawing.

LIGHTING DESIGN
M&E CONTRACTORS
 www.79group.co.uk

Seventynine Lighting Ltd.
 Britannia House,
 Staverton Technology Park,
 Staverton,
 GLE1 6TQ
 Tel (01452) 714391

79

Drawn by: **HN** Checked by: **AC** Drawing title: **GROUND FLOOR SMALL POWER LAYOUT**

Date (first issue): **05.11.19** Scale (at A1): **1:50** Drawing No.: **Barclays-5835-Hampstead-Electrical-GF** Revision No.: **01**