


1 BELOW GROUND DRAINAGE - BASEMENT
1:50

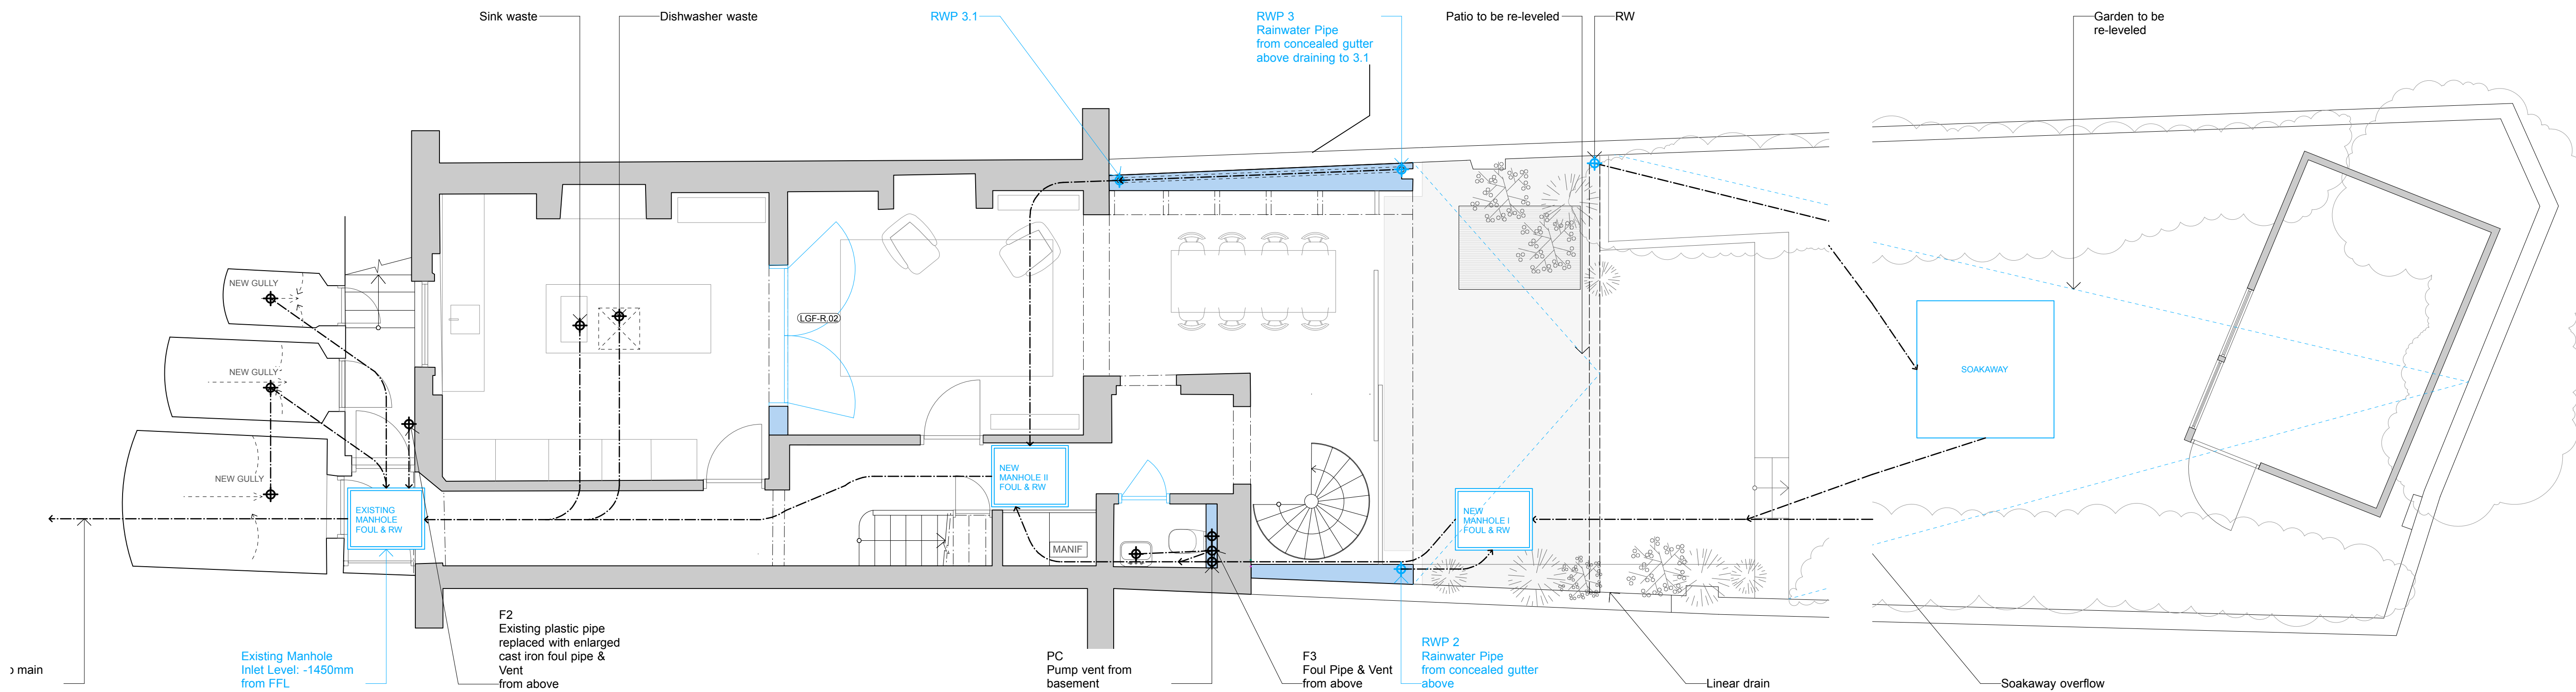


2 BELOW GROUND DRAINAGE - LOWER GROUND FLOOR
1:50


REVISION P3 - 19.11.2019
- Existing front elevation waste pipe replaced with 100mm cast iron waste pipe to act as foul pipe F2.

13 GLOUCESTER CRESCENT		Revision		Date of first issue		DRAINAGE LAYOUT	
Site Address		PLANING P3		10.07.2019		BASEMENT	
Client		A1		Scale		LOWER GROUND FLOOR	
Lara Bireley & Jacobo Quintanilla		Drawn by		1:50		DO NOT SCALE from this drawing.	
Camden		Checked by		mm		All DIMENSIONS are given in MM.	
Structural Engineer		M & E consultant		Job Number		and must be CHECKED on site.	
James Frith		1804		Drawing Number		510	
						© by Michel Schranz Design & Architecture Ltd.	

MS-DA
Michel Schranz Design & Architecture Ltd
South Yellow Hall / Hackney Downs Studios / Amhurst Terrace
London E3 2BT | www.ms-da.com | +44 20339 50199 / 98

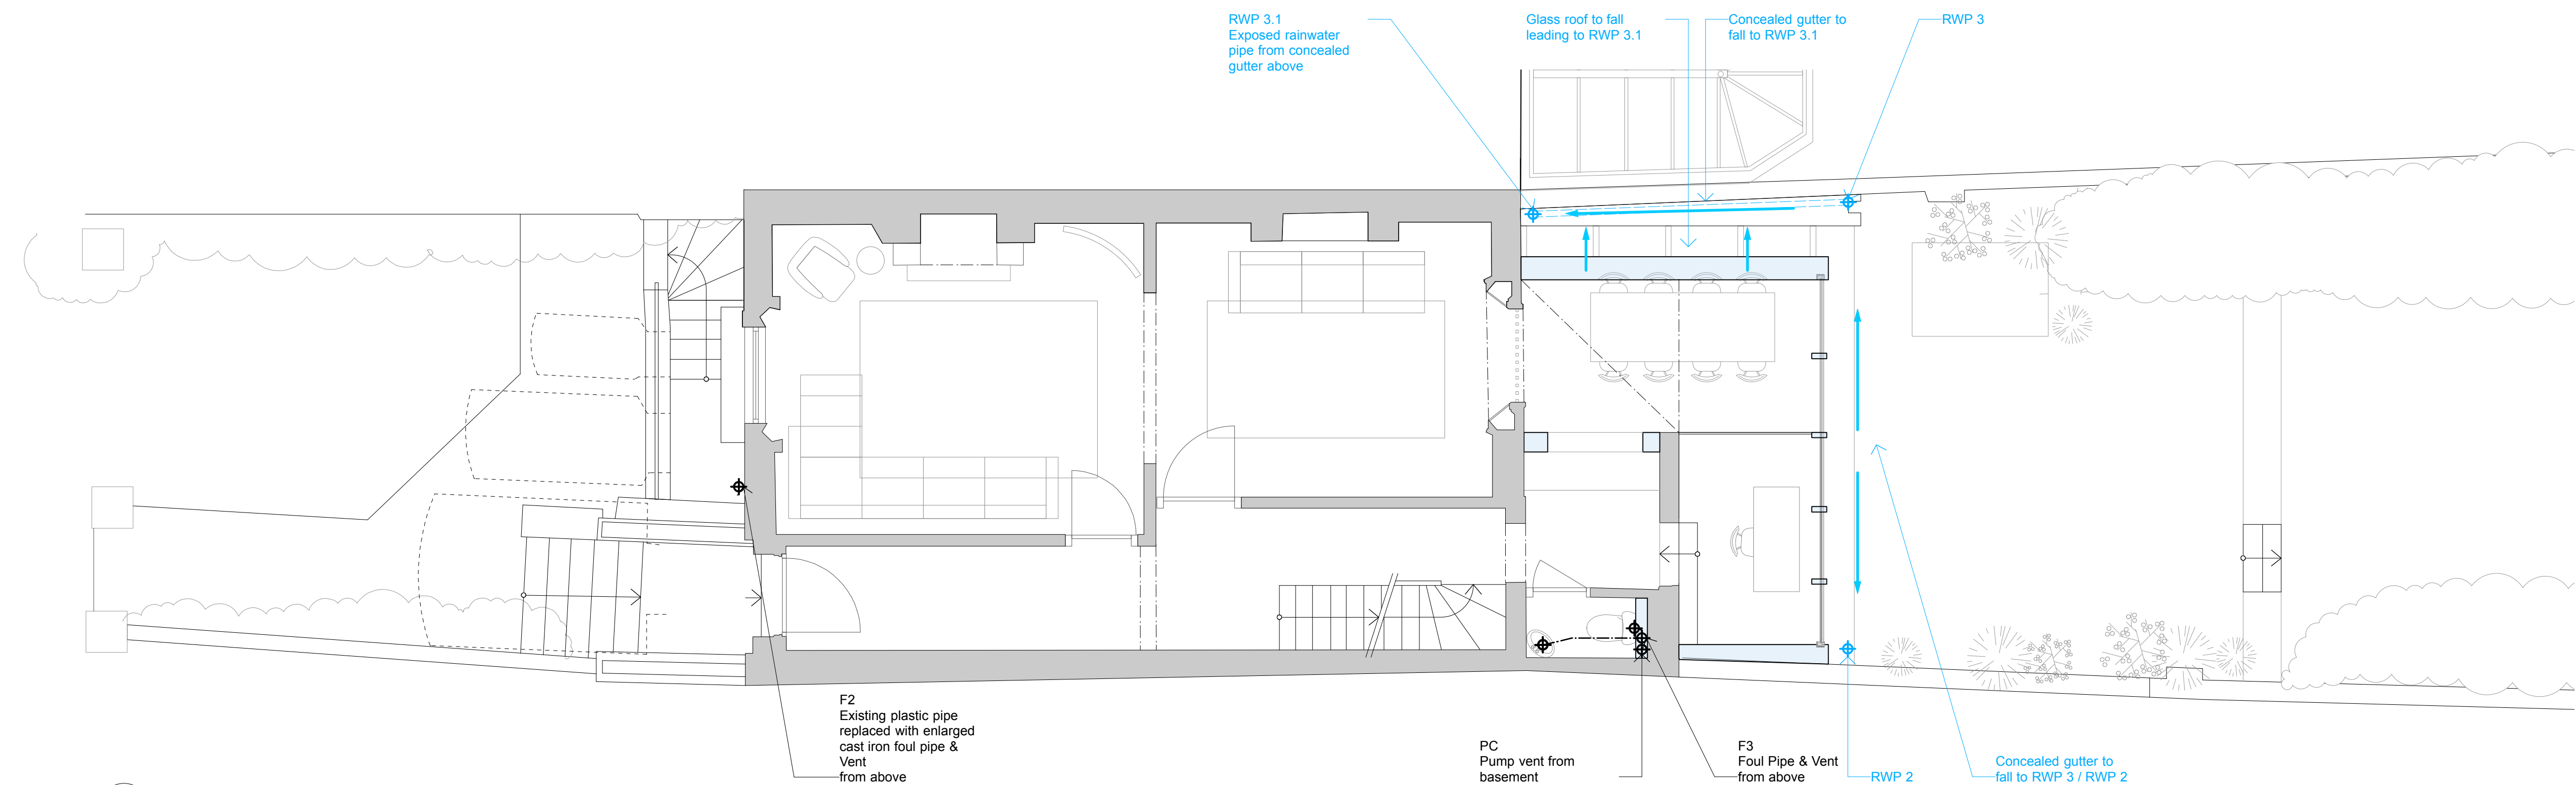

1 DRAINAGE - GROUND FLOOR
1:50 @ A1

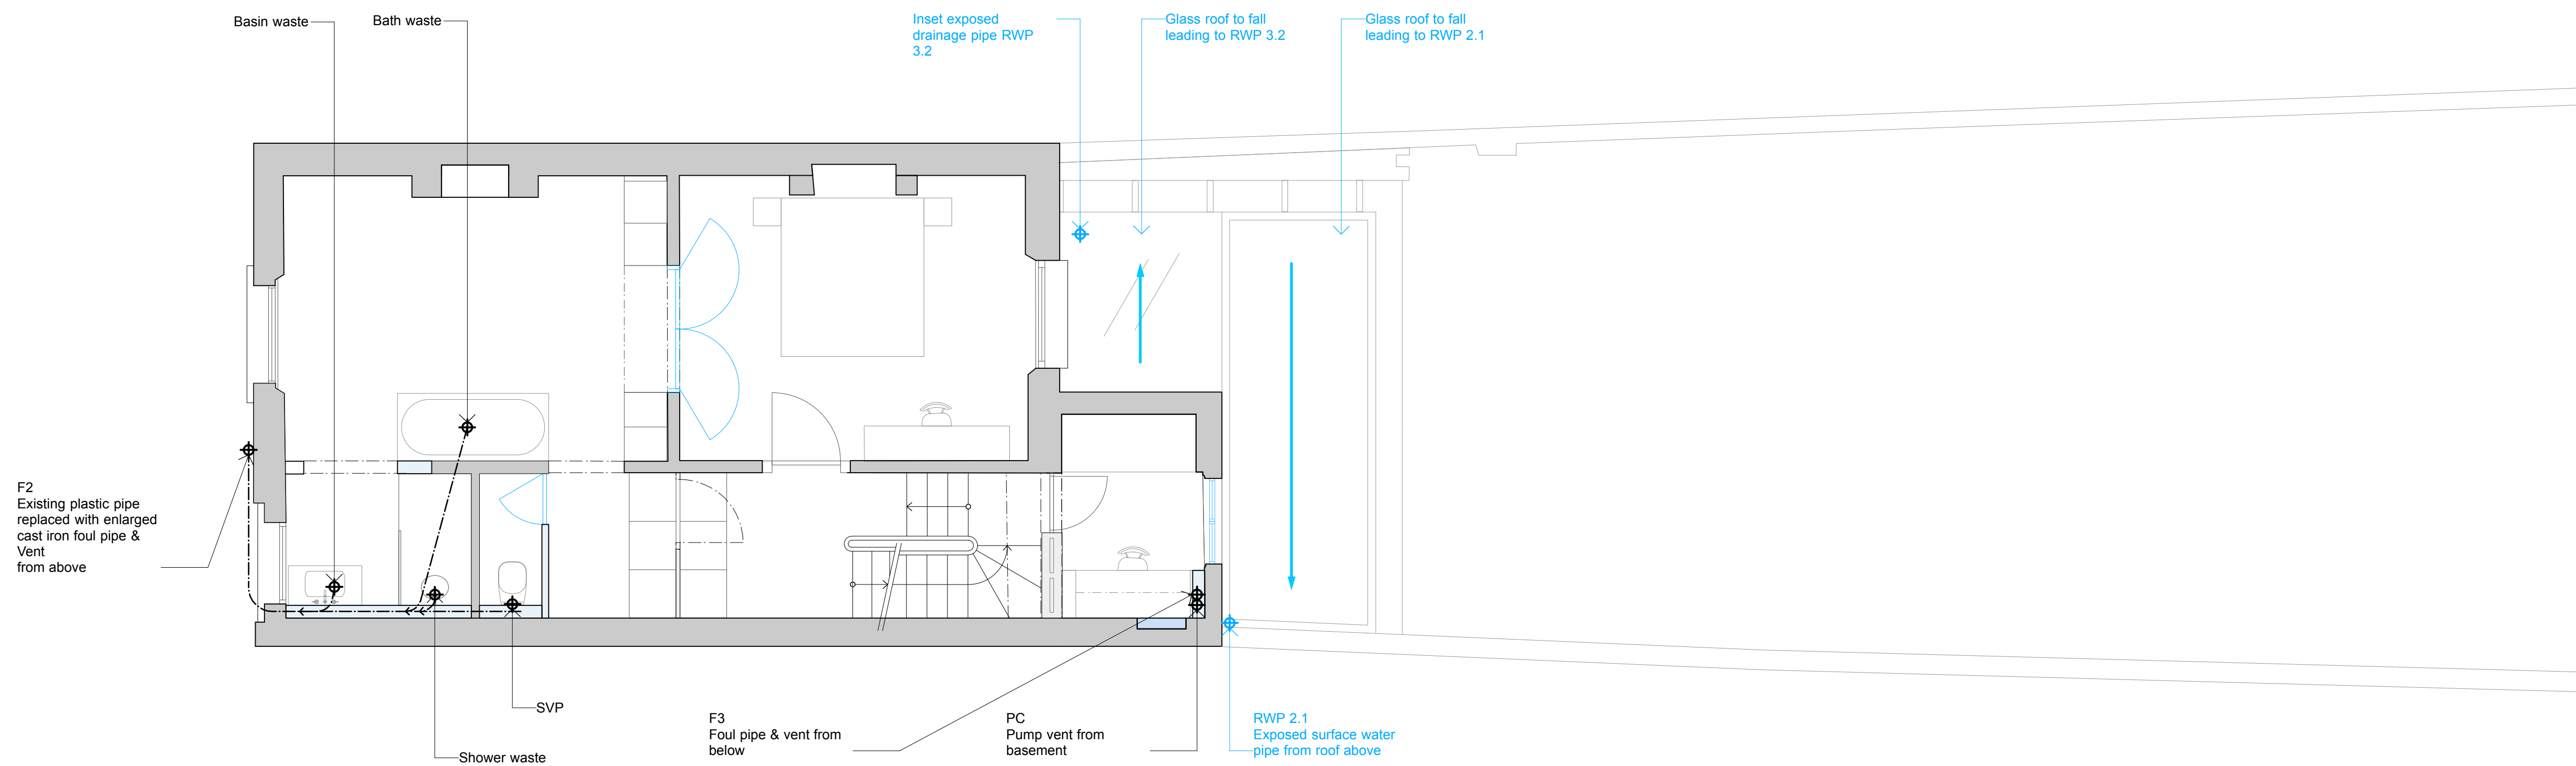

2 DRAINAGE - FIRST FLOOR
1:50 @ A1

REVISION P3 - 19.11.2019
- Existing front elevation waste pipe replaced with 100mm cast
iron waste pipe to act as foul pipe F2.


13 GLOUCESTER CRESCENT
Site Address 13 Gloucester Crescent
Client Council
Lara Bresnley & Jacobo Quintanilla Camden
Structural Engineer M & E consultant
James Frith n/a

Revision PLANNING P3
Plan Size A1
Drawn by ad
Job Number 1804


Date of first issue 10.07.2019
Scale 1:50
Checked by ma
Drawing Number 511

DRAINAGE LAYOUT
GROUND FLOOR
FIRST FLOOR
DO NOT SCALE from this drawing.
All DIMENSIONS are given in MM,
are INDICATIVE only
and must be CHECKED on site.
© by Michel Schrems Design &
Architecture Ltd.


MS-DA
Michel Schrems Design & Architecture Ltd
South Yellow Hall / Hackney Downs Station / Ashurst Terrace
London E8 2BT www.msd-a.com /44 2039 55795 / 98

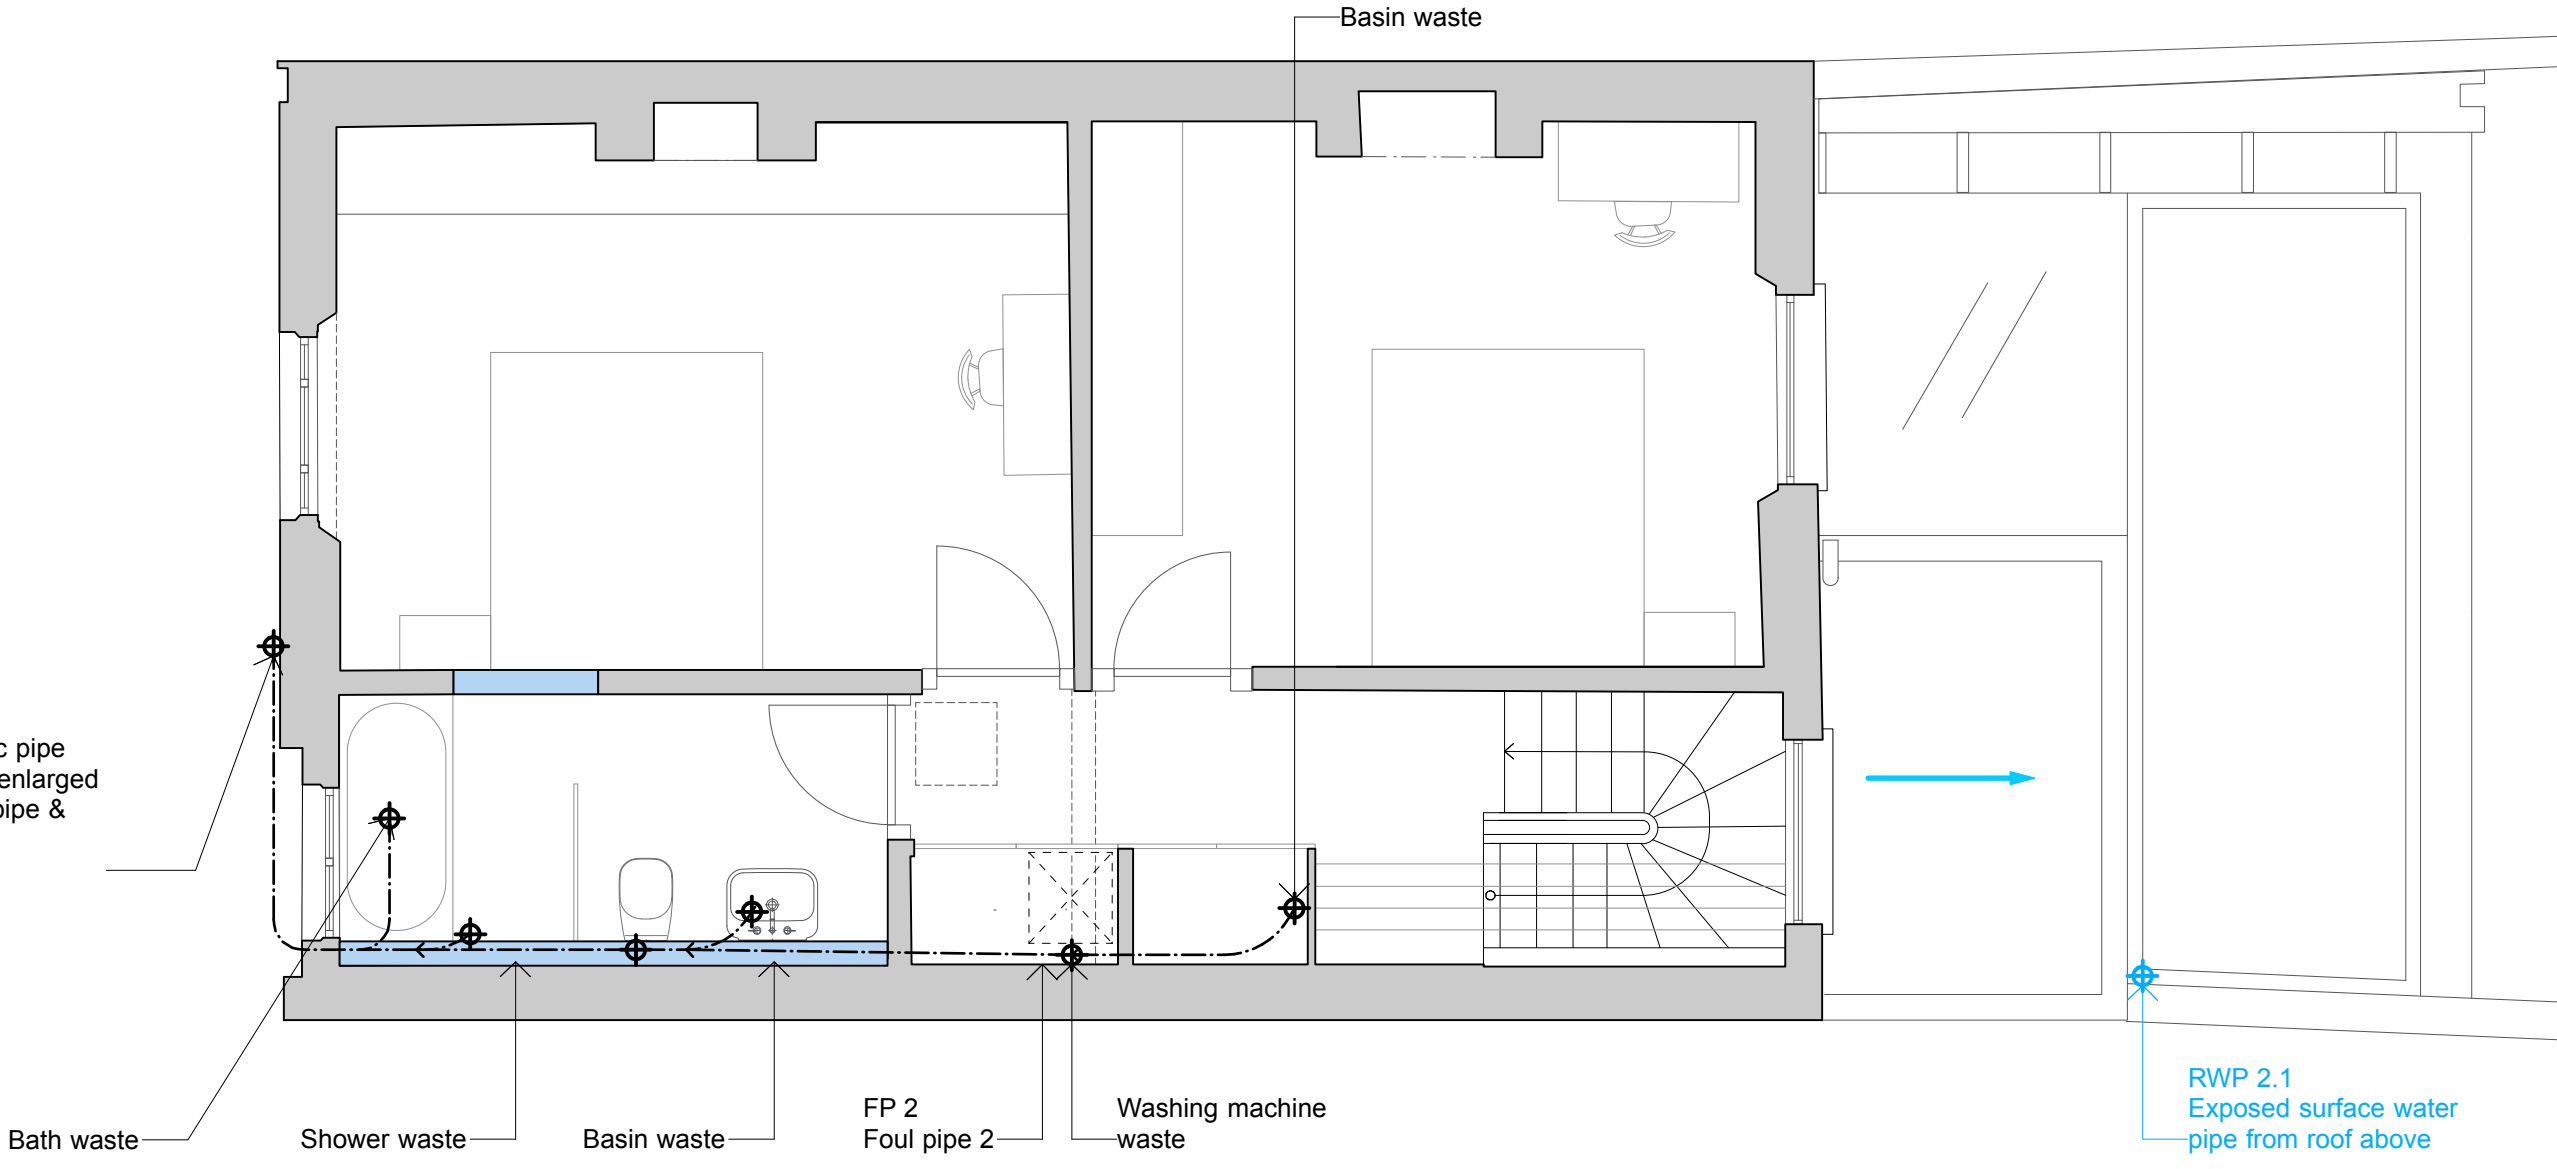


1 DRAINAGE - SECOND FLOOR
1:50 @ A1

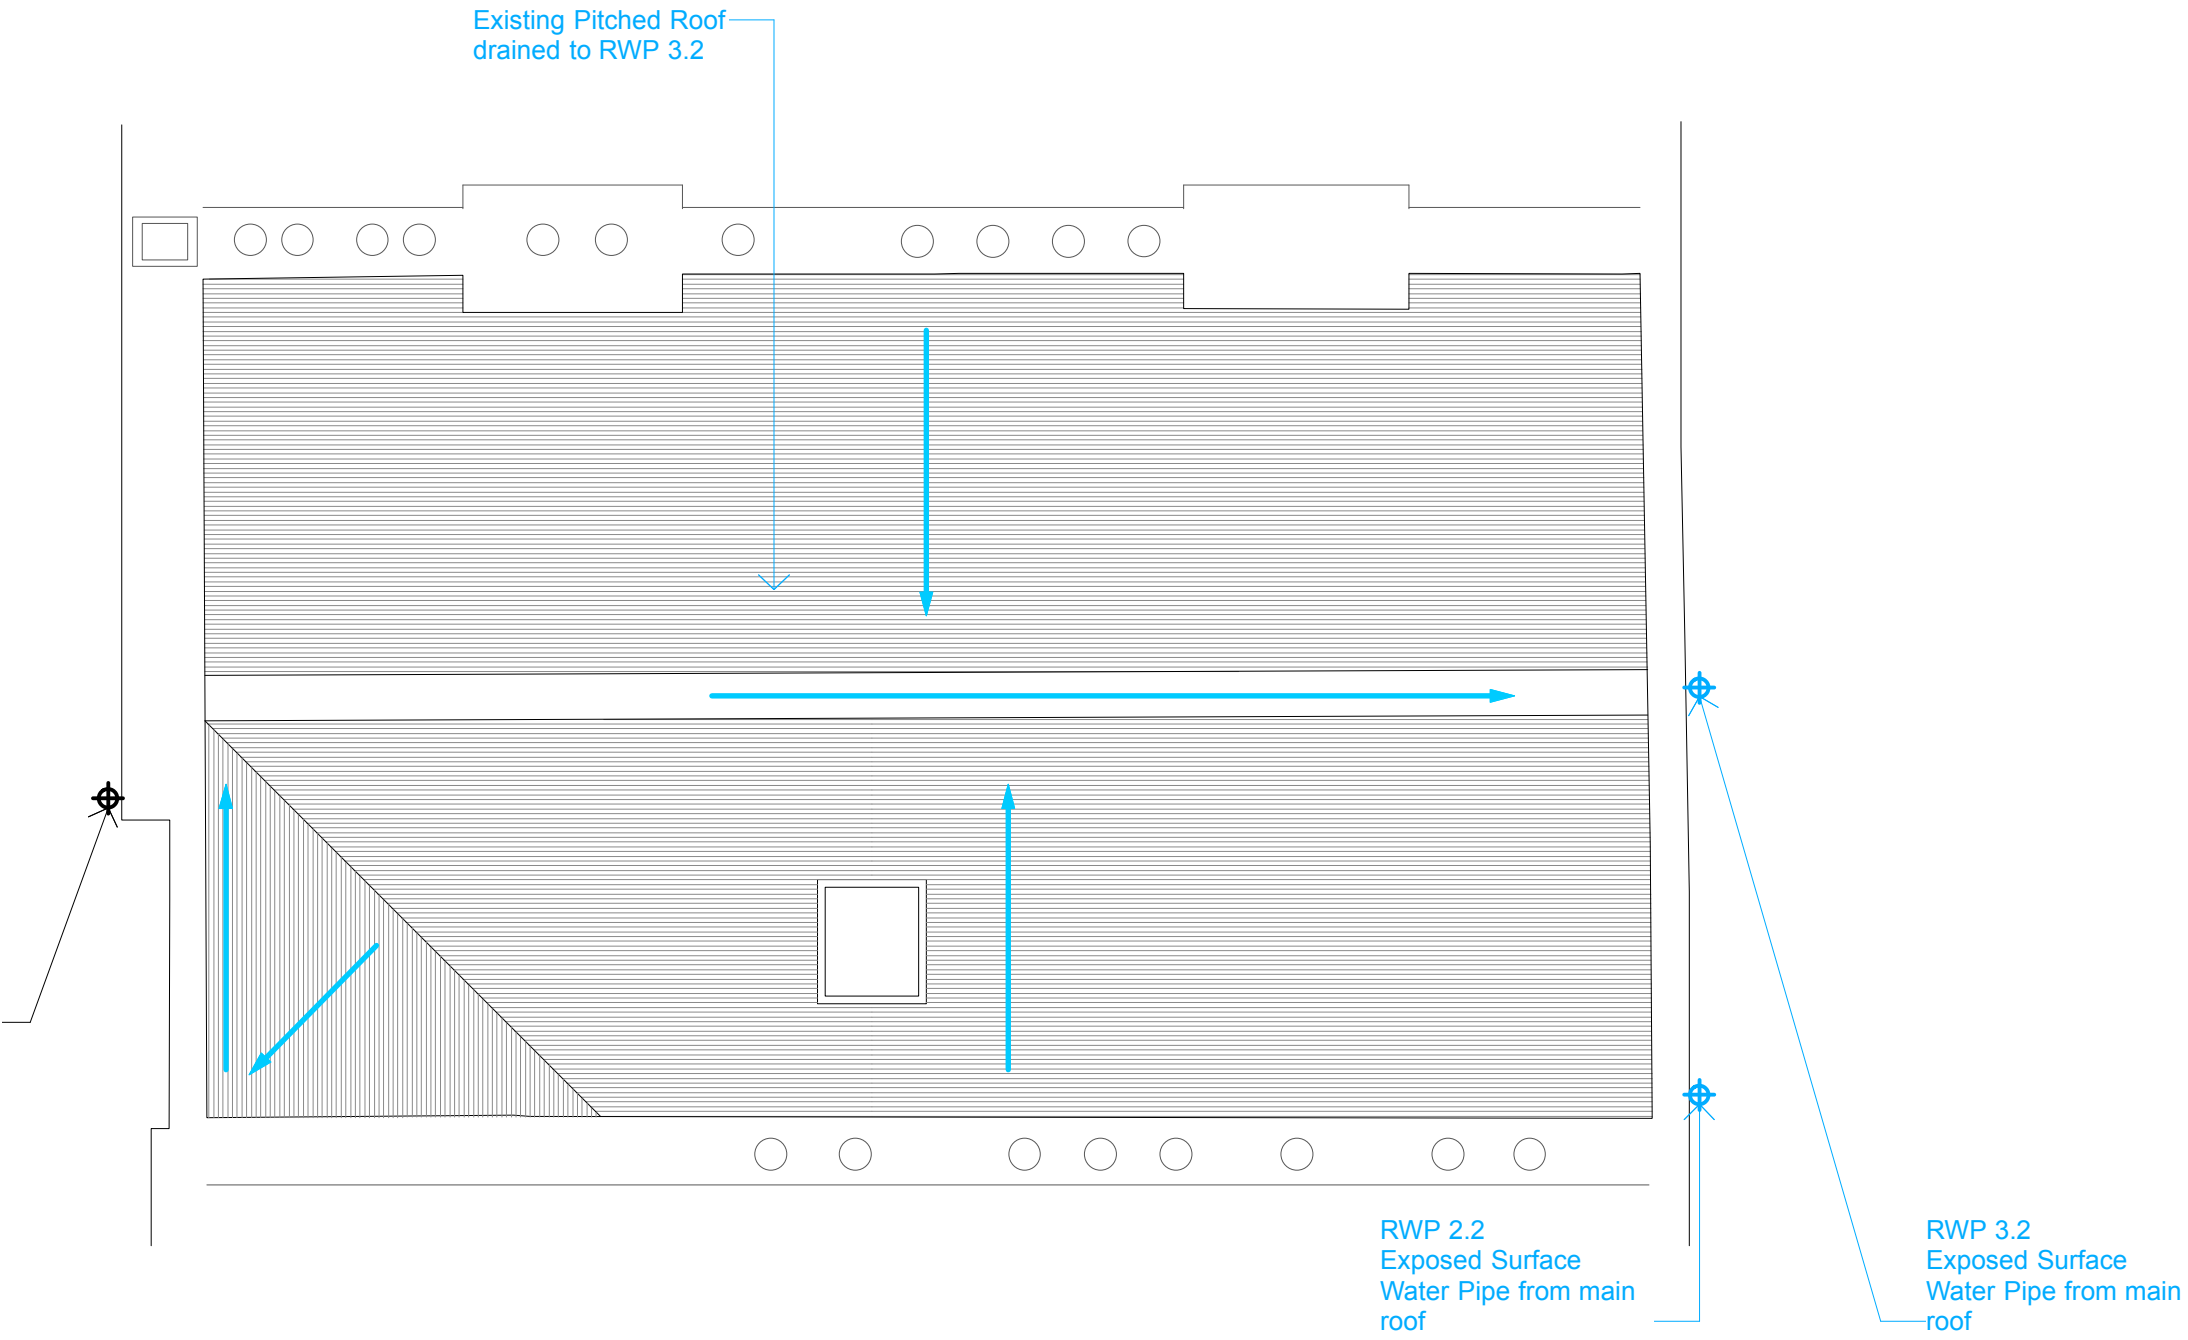

2 DRAINAGE - ROOF TOP VIEW
1:50 @ A1

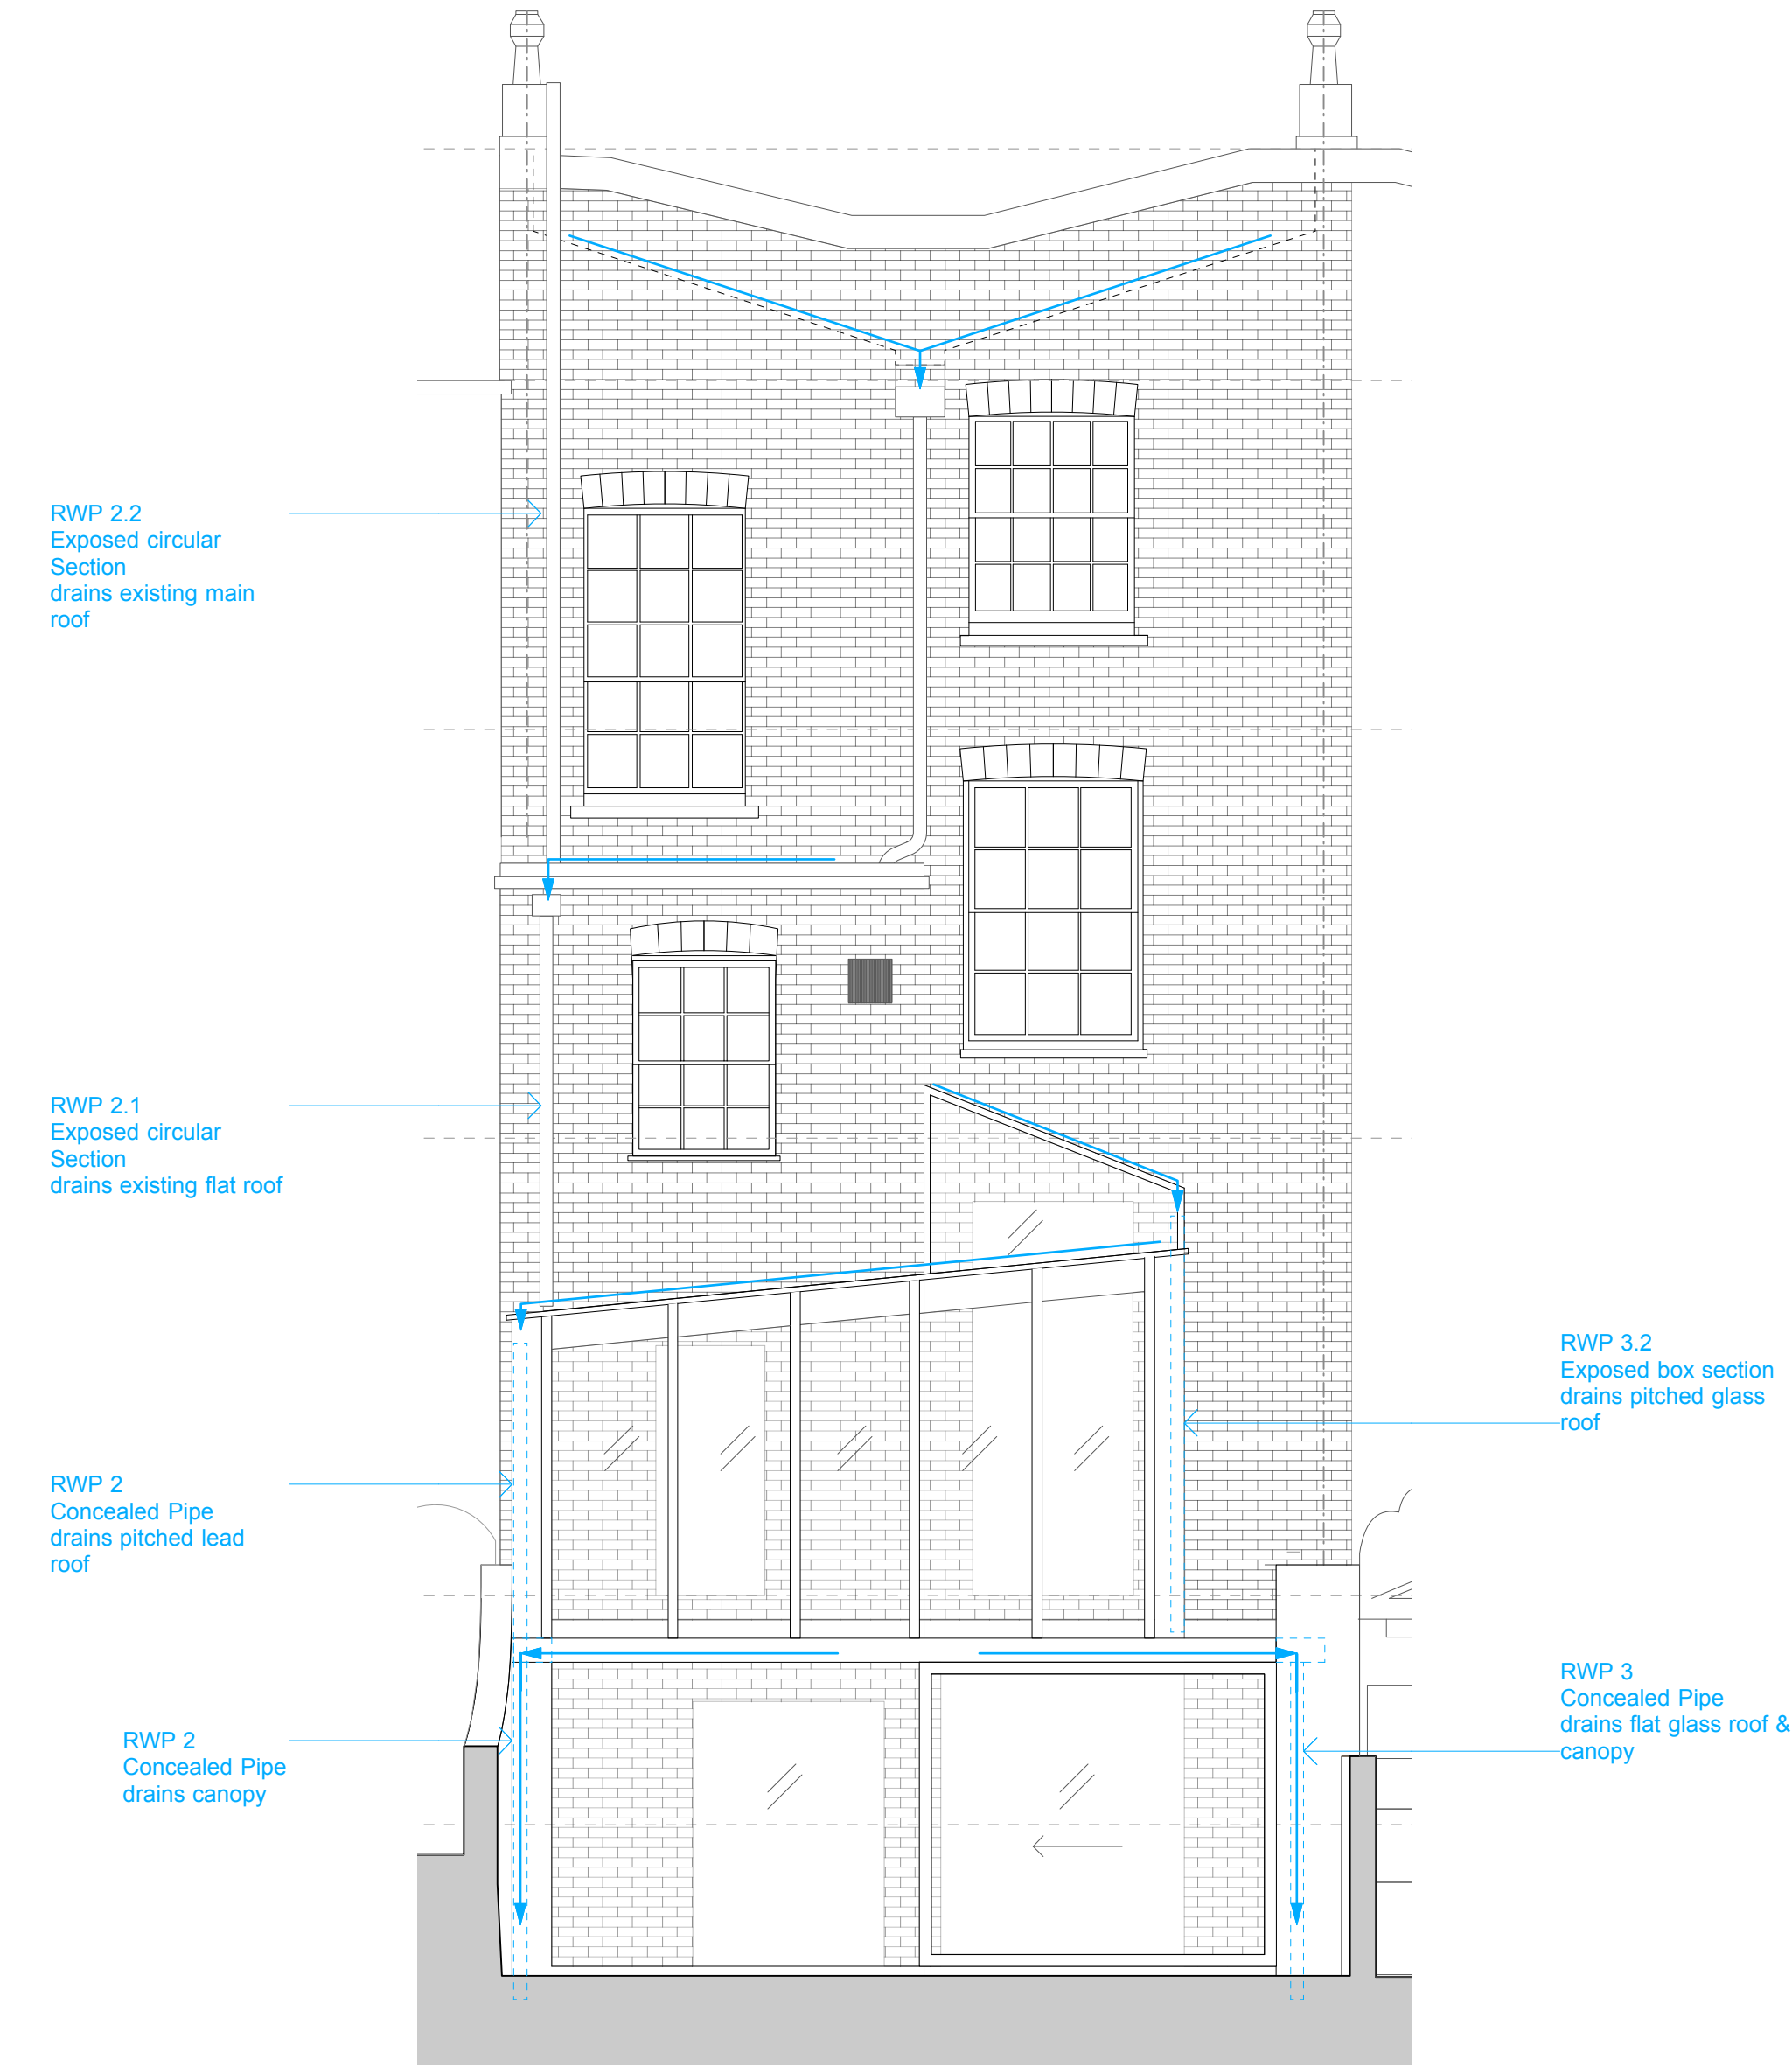

3 DRAINAGE - REAR ELEVATION
1:50 @ A1

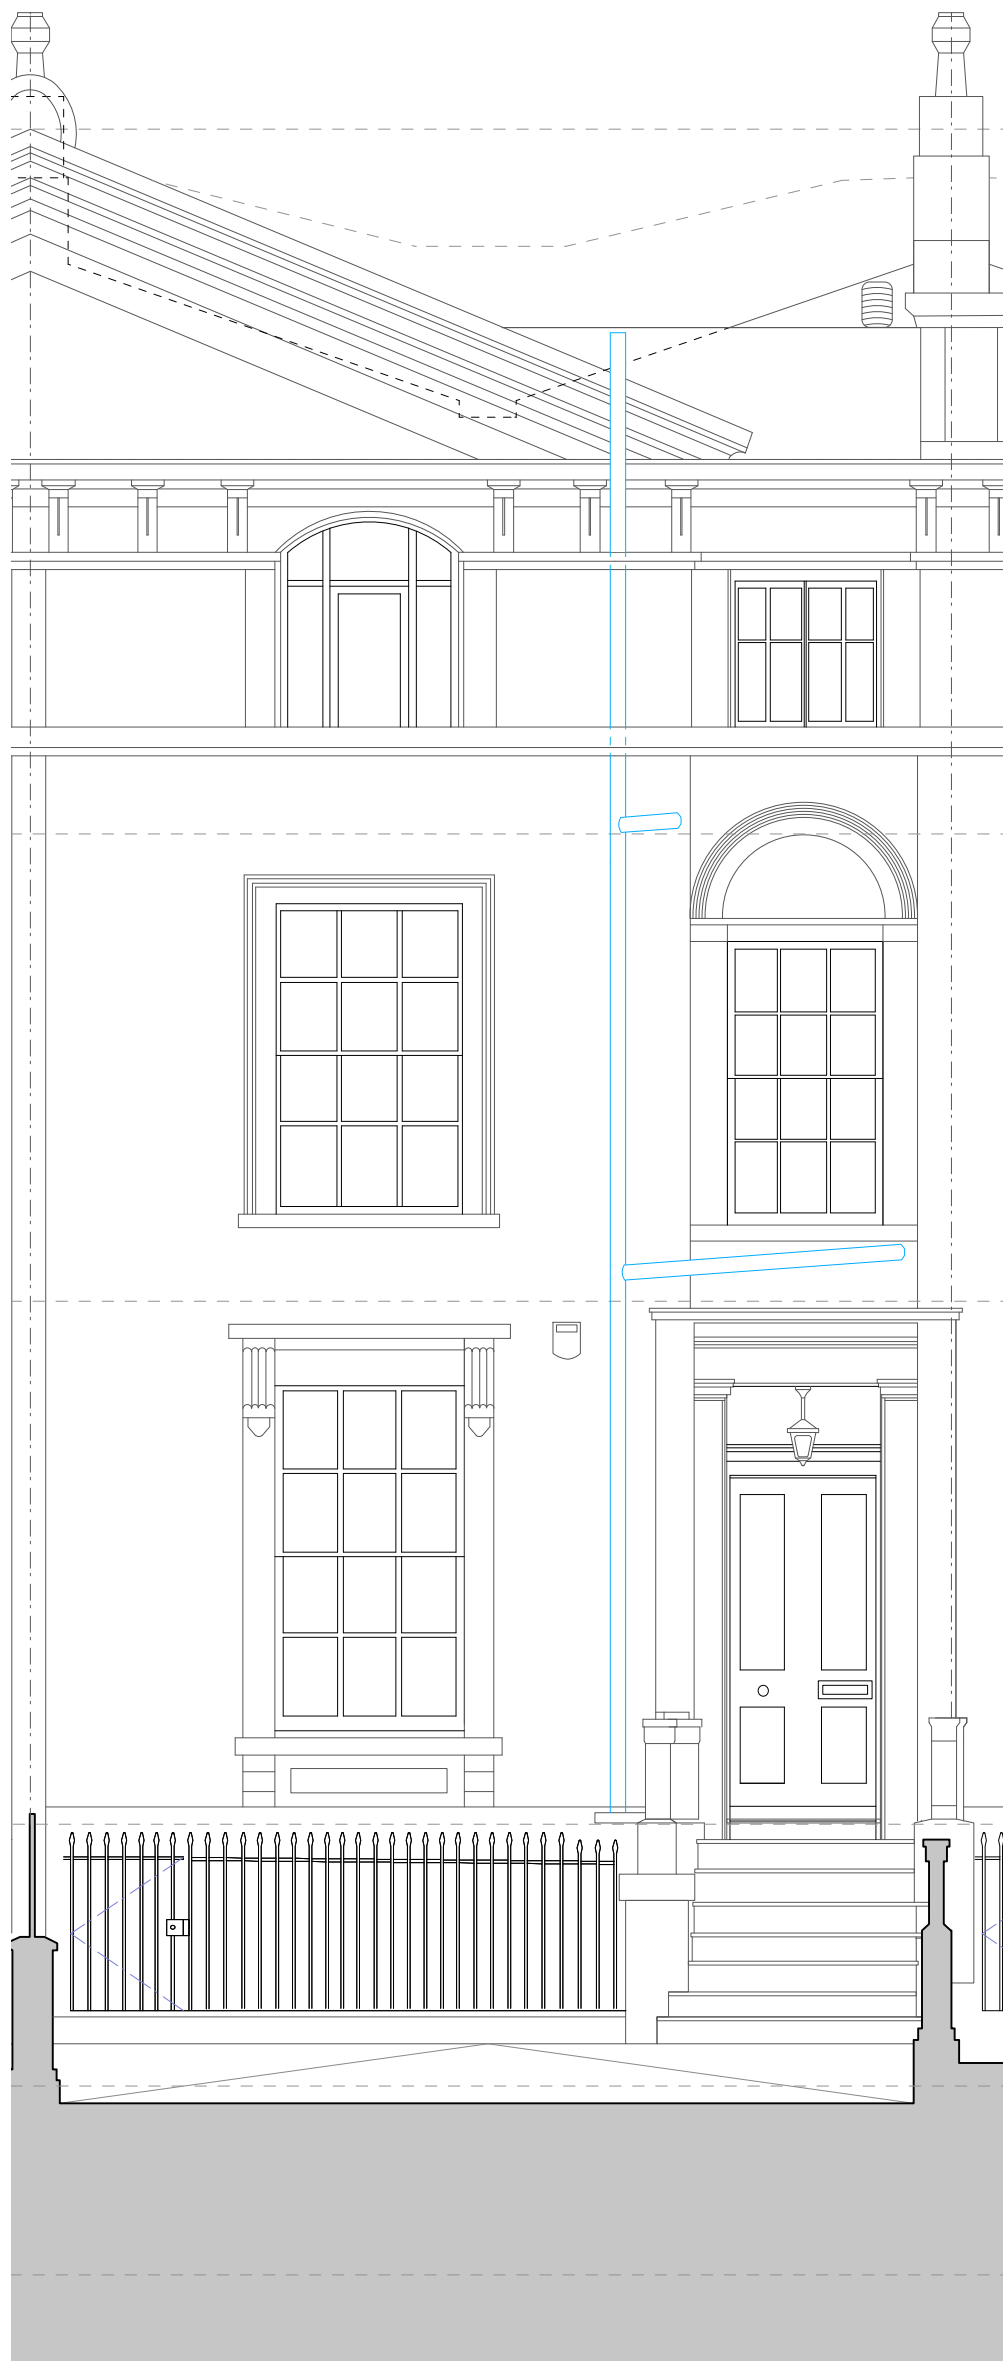

4 DRAINAGE - FRONT ELEVATION
1:50 @ A1