


INDEX	DATE	REASON FOR ISSUE	NAME
W01	28/06/19	Drawing Issue	JH
P01	31/03/19	Revised Layout	JH
P02	01/10/19	Planning update	JH

Caruso St John Architects

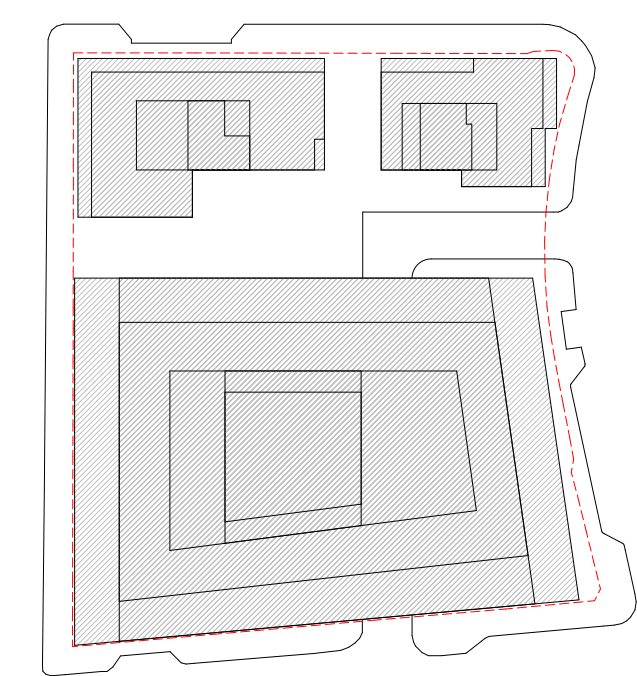

477 St Pancras Commercial Centre
GA - Basement Plan

477	CSJ	00	B1	FP	A	3101	S1	P02
1:100	841 x 1189	28.06.2019	01.10.2019	JH	RH			

STAGE 03 ±0.00 = 0.00 AOD

Client: WRE
22 Whitechapel Street, London, W1J 8NF
Project manager: Blackburn & Co. No 1, Clerk Street, London, SE1 9DG
Architect: Caruso St John Architects LLP 1 Coote Street, London E2 8AG, UK, +44 (0)20 7513 3161, london@carusostjohn.com

Norman Disney & Young


Project: St Pancras Commercial Centre
Title: Future heat exchanger provisions for connection to future heat network
Document Number: Appendix D sketch
Project No: UH4103-001 Drawn: BC Date: 10.10.19 Scale: 1:100 Rev: 1.0

Planning consultant: GeoEd Eco 72 Whitechapel Street, London, W1J 8NF
Structural engineer: AKT II White Cedar Factory 1 Old Street Yard London EC1Y 8AF
Building services: Norman Disney & Young 4 Chiswell Street, London EC1Y 4BP, United Kingdom
Quantity surveyor: Expere Monkslands 5-23 Old Street London EC1Y 9HQ



INDEX	DATE	REASON FOR ISSUE	NAME
W01	28/06/19	Drawing Issue	JH
P01	31/03/19	Revised Layout	JH
P02	01/08/19	Pratt St escape door changed	JH
P03	05/08/19	Short stay cycle parking amended	JH
W02	02/08/19	Information ground floor access	JH
P02	01/10/19	Planning update	JH

Caruso St John Architects

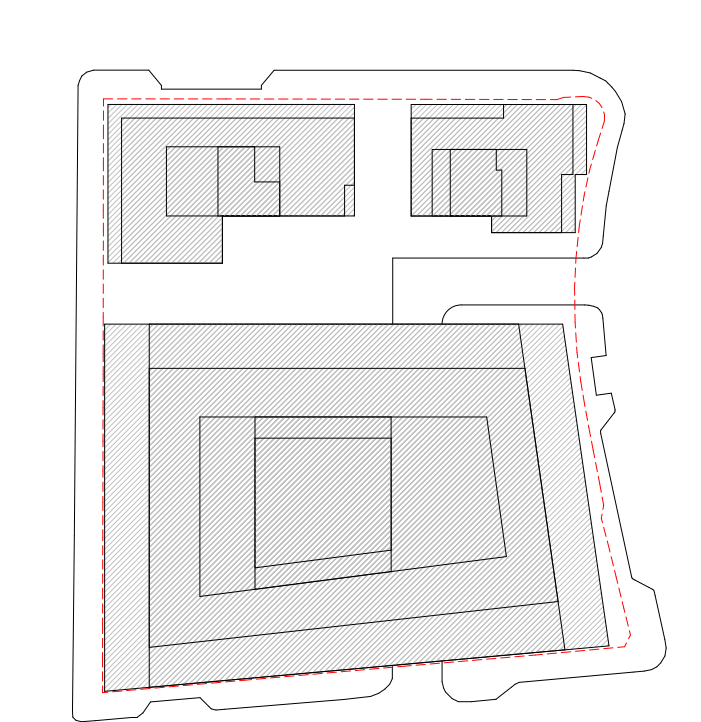

477 St Pancras Commercial Centre
GA - Ground Floor Plan

477	CSJ	00	GF	FP	A	3102	S1	P04
Project	Author	Use	Level	Type	Discipline	Number	System	Version

1:100	841 x 1189	28.06.2019	01.10.2019	JH	RH
Scale	Sheet no. (of 1)	Date	Issue	Author	Checker

STAGE 03 ±0.00 = 0.00 AOD

Client: WRE
 25 Broad St, Mayfair, London W1J 8NF
 Project manager: Blackburn & Co.
 No 1, Clerk Street, London, SE1 9DG
 Architect: Caruso St John Architects LLP
 1 Coote Street, London E2 8AG, UK, +44 (0)20 7513 3161, london@carusostjohn.com

Planning consultant: Gerald Evis
 72 Whitechapel Street, London, W1D 0AY
 Structural engineer: AKT II
 White Collier Factory 1 Old Street Yard London EC1Y 8AF
 Building services: Norman Disney & Hoang
 4 Chiswell Street, London EC1Y 4BP, United Kingdom
 Quantity surveyor: Expere
 Monkslands 5-23 Old Street London EC1Y 9PL

Norman Disney & Hoang
 Title: Future heat exchanger provisions for connection to future heat network
 Document Number: Appendix D sketch
 Project No: UH4103-001 Drawn: BC Date: 10.10.19 Scale: 1:100 Rev: 1.0