
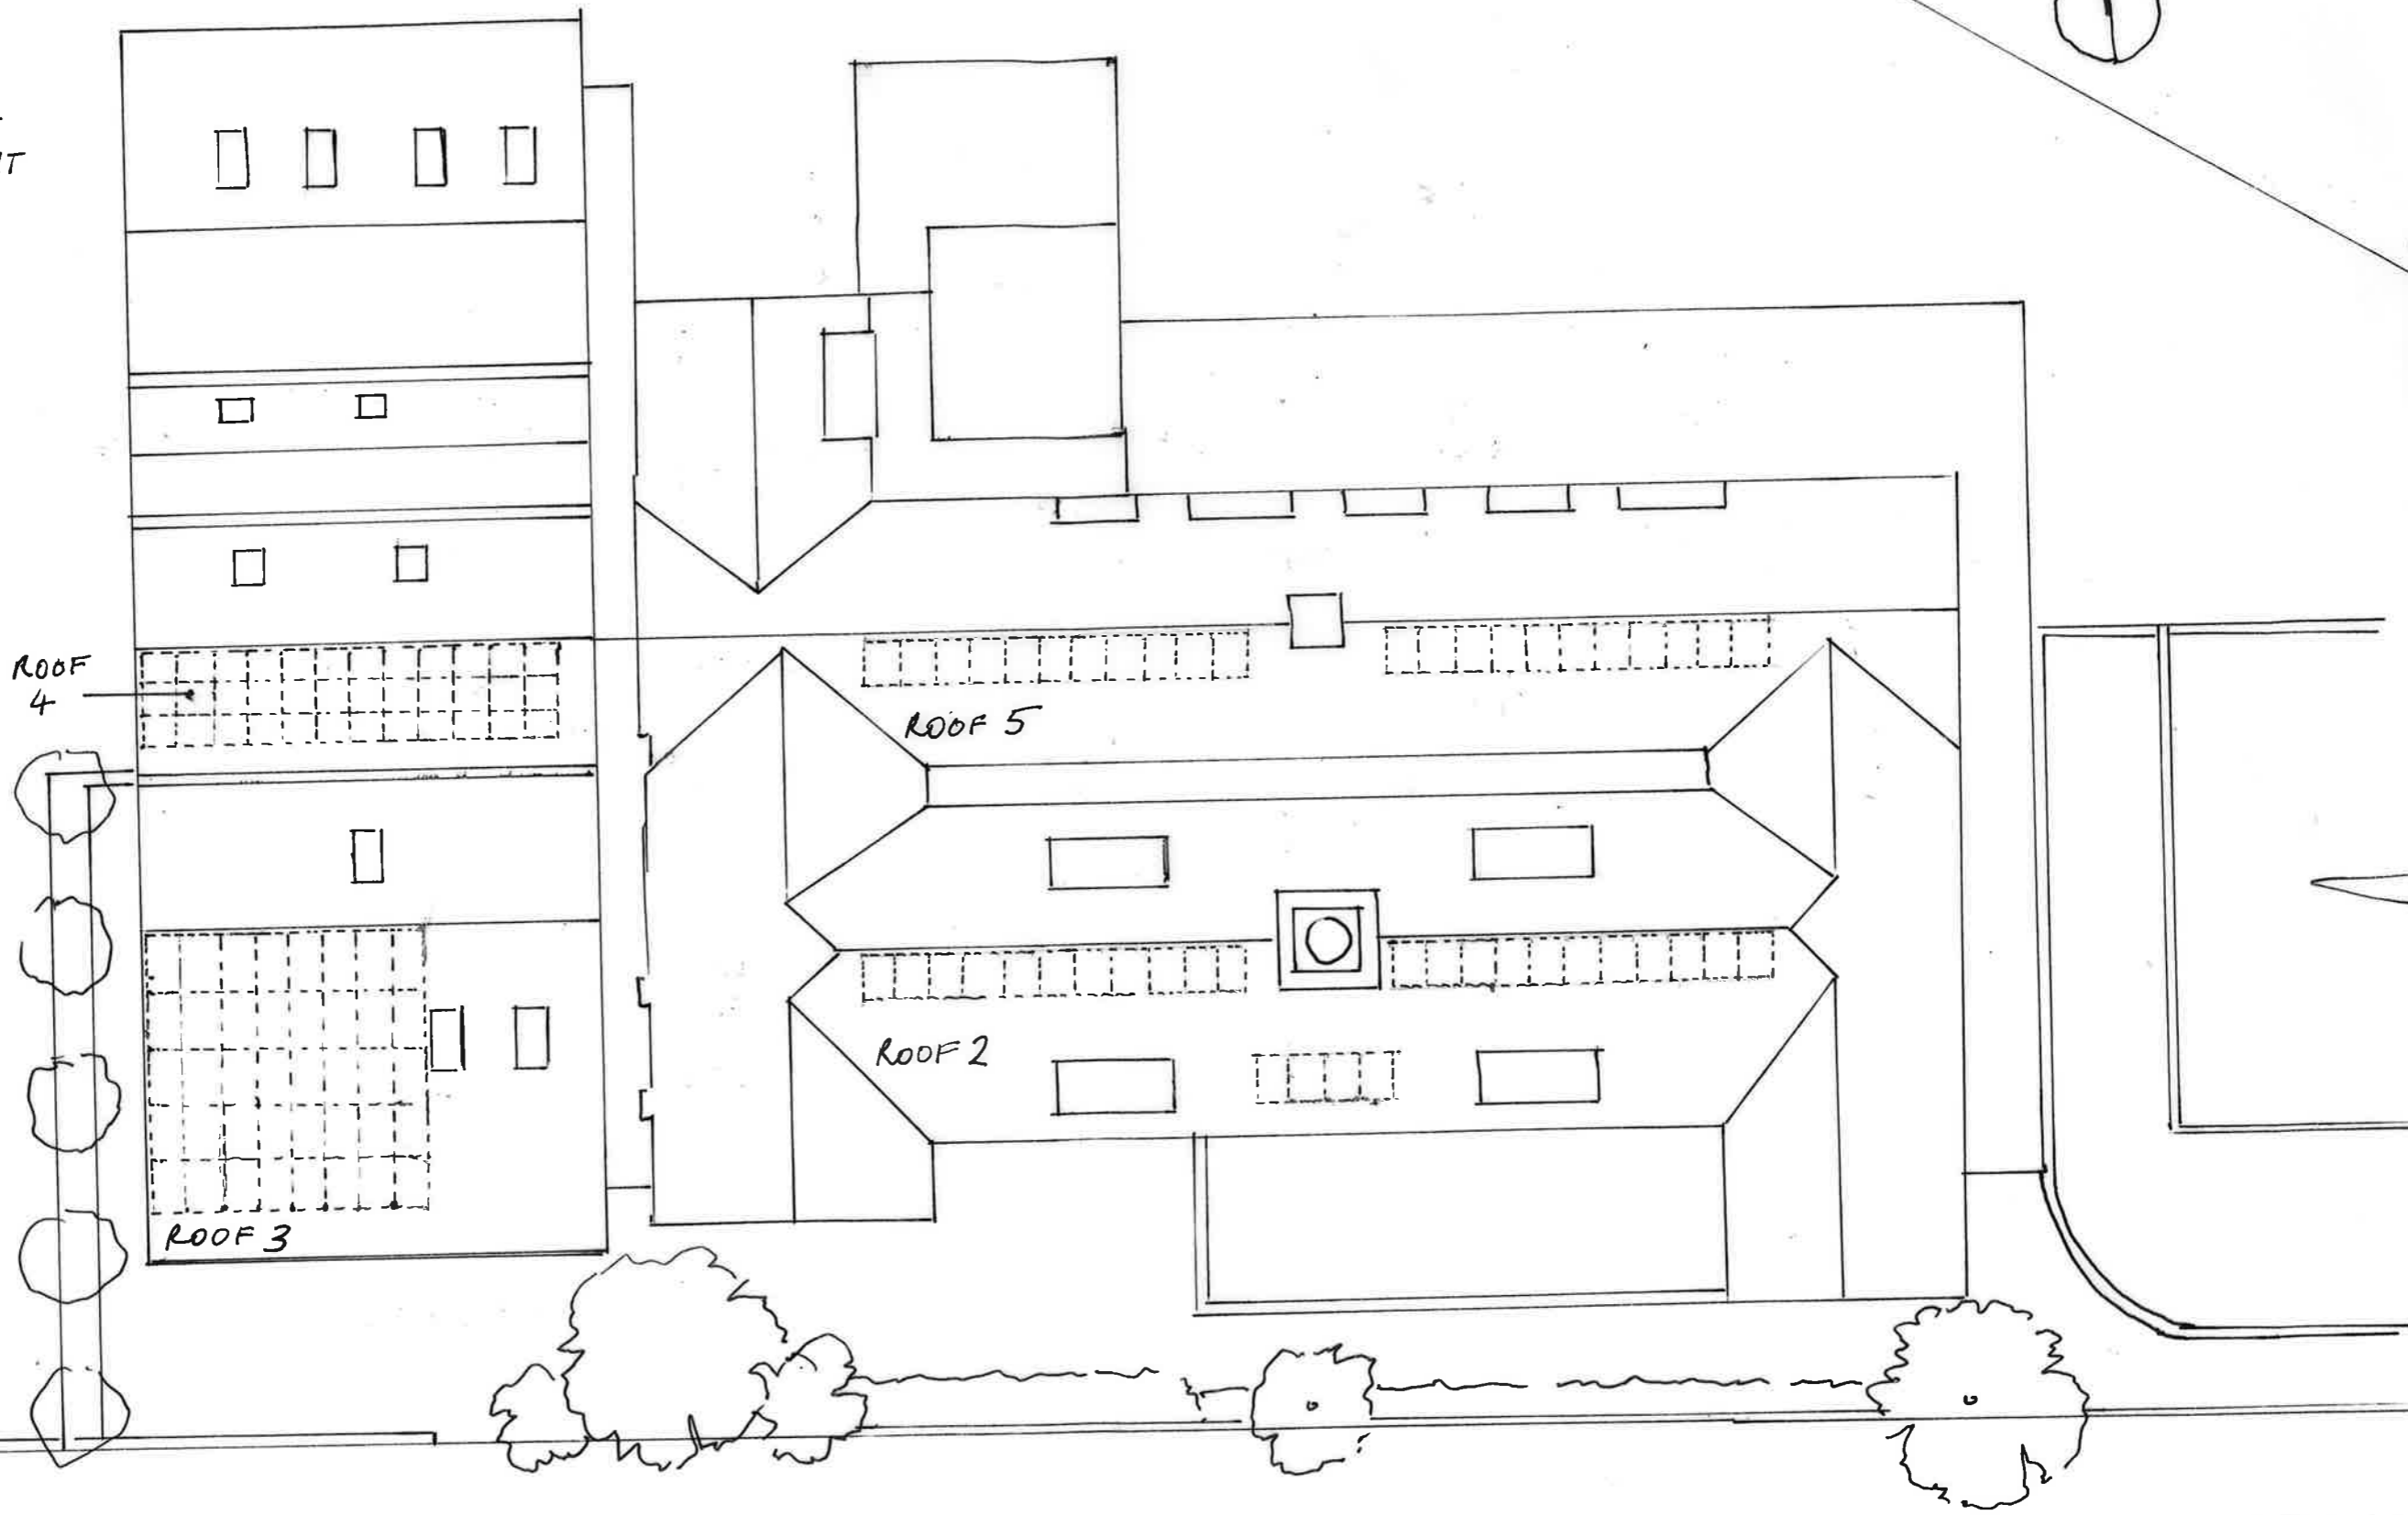


- ▭ - PROPOSED PV PANEL
- - ROOF LIGHT

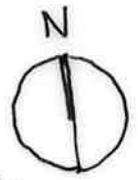

ISLIP STREET

REFER TO DWG 1923-002

KENTISH TOWN PRIMARY SCHOOL
 PV INSTALLATION
 PO ISSUED FOR PLANNING 21.11.19.

LTS ARCHITECTS
 ROOF PLAN 1 of 2
 1923-001 PO
 SCALE 1:200