



ELECTRICAL INFRASTRUCTURE UPGRADE

National Hospital of Neurology and Neurosurgery, Queen Square

Planning Application Drawing Package

Planning Application pack drawing list	
Sheet Number	Sheet Title
5829-MAA-ZZ-ZZ-DR-A-242-S3-P03	PL-Drawings
5829-MAA-ZZ-RF-DR-A-156-S3-P01	PL-ST-Site
5829-MAA-ZZ-RF-DR-A-157-S3-P01	PL-ST-Location
5829-MAA-ZZ-B1-DR-A-175-S3-P01	PL-ST-PhotoSurveyB1
5829-MAA-ZZ-B1-DR-A-176-S3-P01	PL-ST-PhotoSurvey-B1-2
5829-MAA-ZZ-00-DR-A-177-S3-P01	PL-ST-PhotoSurvey00
5829-MAA-ZZ-02-DR-A-178-S3-P01	PL-ST-PhotoSurvey02
5829-MAA-LW-ZZ-DR-A-241-S3-P01	PL-HatchPersp
5829-MAA-SS-FC-DR-A-102-S3-P01	MI-E01-Demol
5829-MAA-SS-FC-DR-A-103-S3-P01	MI-E01-Prop
5829-MAA-SS-FC-DR-A-105-S3-P02	MI-E02-Demol
5829-MAA-SS-FC-DR-A-106-S3-P02	MI-E02-Prop
5829-MAA-SS-B1-DR-A-160-S3-P02	PL-EX-SubsPlan
5829-MAA-SS-B1-DR-A-161-S3-P02	PL-PR-SubsPlan
5829-MAA-SS-SC-DR-A-166-S3-P02	PL-EX-MI-S01
5829-MAA-SS-SC-DR-A-167-S3-P02	PL-PR-MI-S01
5829-MAA-SS-SC-DR-A-168-S3-P02	PL-EX-MI-S02
5829-MAA-SS-SC-DR-A-169-S3-P02	PL-PR-MI-S02
5829-MAA-AW-FC-DR-A-193-S3-P03	AW-E01-Demol
5829-MAA-AW-FC-DR-A-194-S3-P03	AW-E01-Prop
5829-MAA-AW-B1-DR-A-162-S3-P02	PL-EX-AWSPlan
5829-MAA-AW-B1-DR-A-163-S3-P02	PL-PR-AWSPlan
5829-MAA-AW-SC-DR-A-170-S3-P02	PL-EX-AWS-S01
5829-MAA-AW-SC-DR-A-171-S3-P02	PL-PR-AWS-S01
5829-MAA-CW-FC-DR-A-220-S3-P01	CW-E01-Demol
5829-MAA-CW-FC-DR-A-221-S3-P01	CW-E01-Prop
5829-MAA-CW-B1-DR-A-164-S3-P02	PL-EX-CWSPlan
5829-MAA-CW-B1-DR-A-165-S3-P02	PL-PR-CWSPlan
5829-MAA-CW-SC-DR-A-172-S3-P02	PL-EX-CW-S01
5829-MAA-CW-SC-DR-A-173-S3-P02	PL-PR-CW-S01
5829-MAA-LW-00-DR-A-180-S3-P01	PL-EX-LWPlan
5829-MAA-LW-00-DR-A-181-S3-P01	PL-PR-LWPlan
5829-MAA-CR-02-DR-A-197-S3-P03	Plant-Existing
5829-MAA-CR-02-DR-A-198-S3-P04	Plant-Proposed
5829-MAA-CR-00-DR-A-182-S3-P01	PL-EX-FRooFPlan
5829-MAA-CR-00-DR-A-183-S3-P02	PL-PR-FRooFPlan
5829-MAA-DT-ZZ-DR-A-125-S3-P02	D01-AccessCover

Copyright. All Rights Reserved.
This work is copyright and cannot be produced or copied in any form or by any means (graphic, electronic or mechanical including photocopying) without the written permission of the originator.
Any licensee, express or implied, to use this document for any purpose whatsoever is restricted to the terms of the agreement or implied agreement between the originator and the instructing party.

DO NOT SCALE FROM THIS DRAWING. WORK ONLY FROM FIGURED DIMENSIONS.
THIS DRAWING TO BE READ IN CONJUNCTION WITH RELEVANT CONSULTANT'S DRAWINGS.

KEY PLAN

REV P01 | DATE 19/09/2018 | DRAWN / CHECKED / APPROVED AS / BW / BW
First Issue

REV P02 | DATE 01/11/2018 | DRAWN / CHECKED / APPROVED AS/BW/BW
Location change for plant

REV P03 | DATE 18/11/2019 | DRAWN / CHECKED / APPROVED AS/BW/BW
Minor changes to structural design

22a Arlington Way
London EC1R 1UY
+44 (0)20 7490 1904
london@medicallarchitecture.com
medicallarchitecture.com

Medical
Architecture

CLIENT
UNIVERSITY COLLEGE LONDON HOSPITALS

PROJECT
NHNN
5829 Queen Square Mains Power
Infrastructure Replacement

TITLE
PLANNING APPLICATION
Drawing Package

STAGE
02

STATUS
S3


PROJECT NUMBER
775

SCALE @A3
N/A

DRAWING NUMBER
5829-MAA-ZZ-ZZ-DR-A-242-S3-P03

REVISION
P03

FILE REFERENCE
\\Lon-srv-01\projects\775_UCLH_ElectricalInfrastructure\Design\Location\01_Zone\DWG

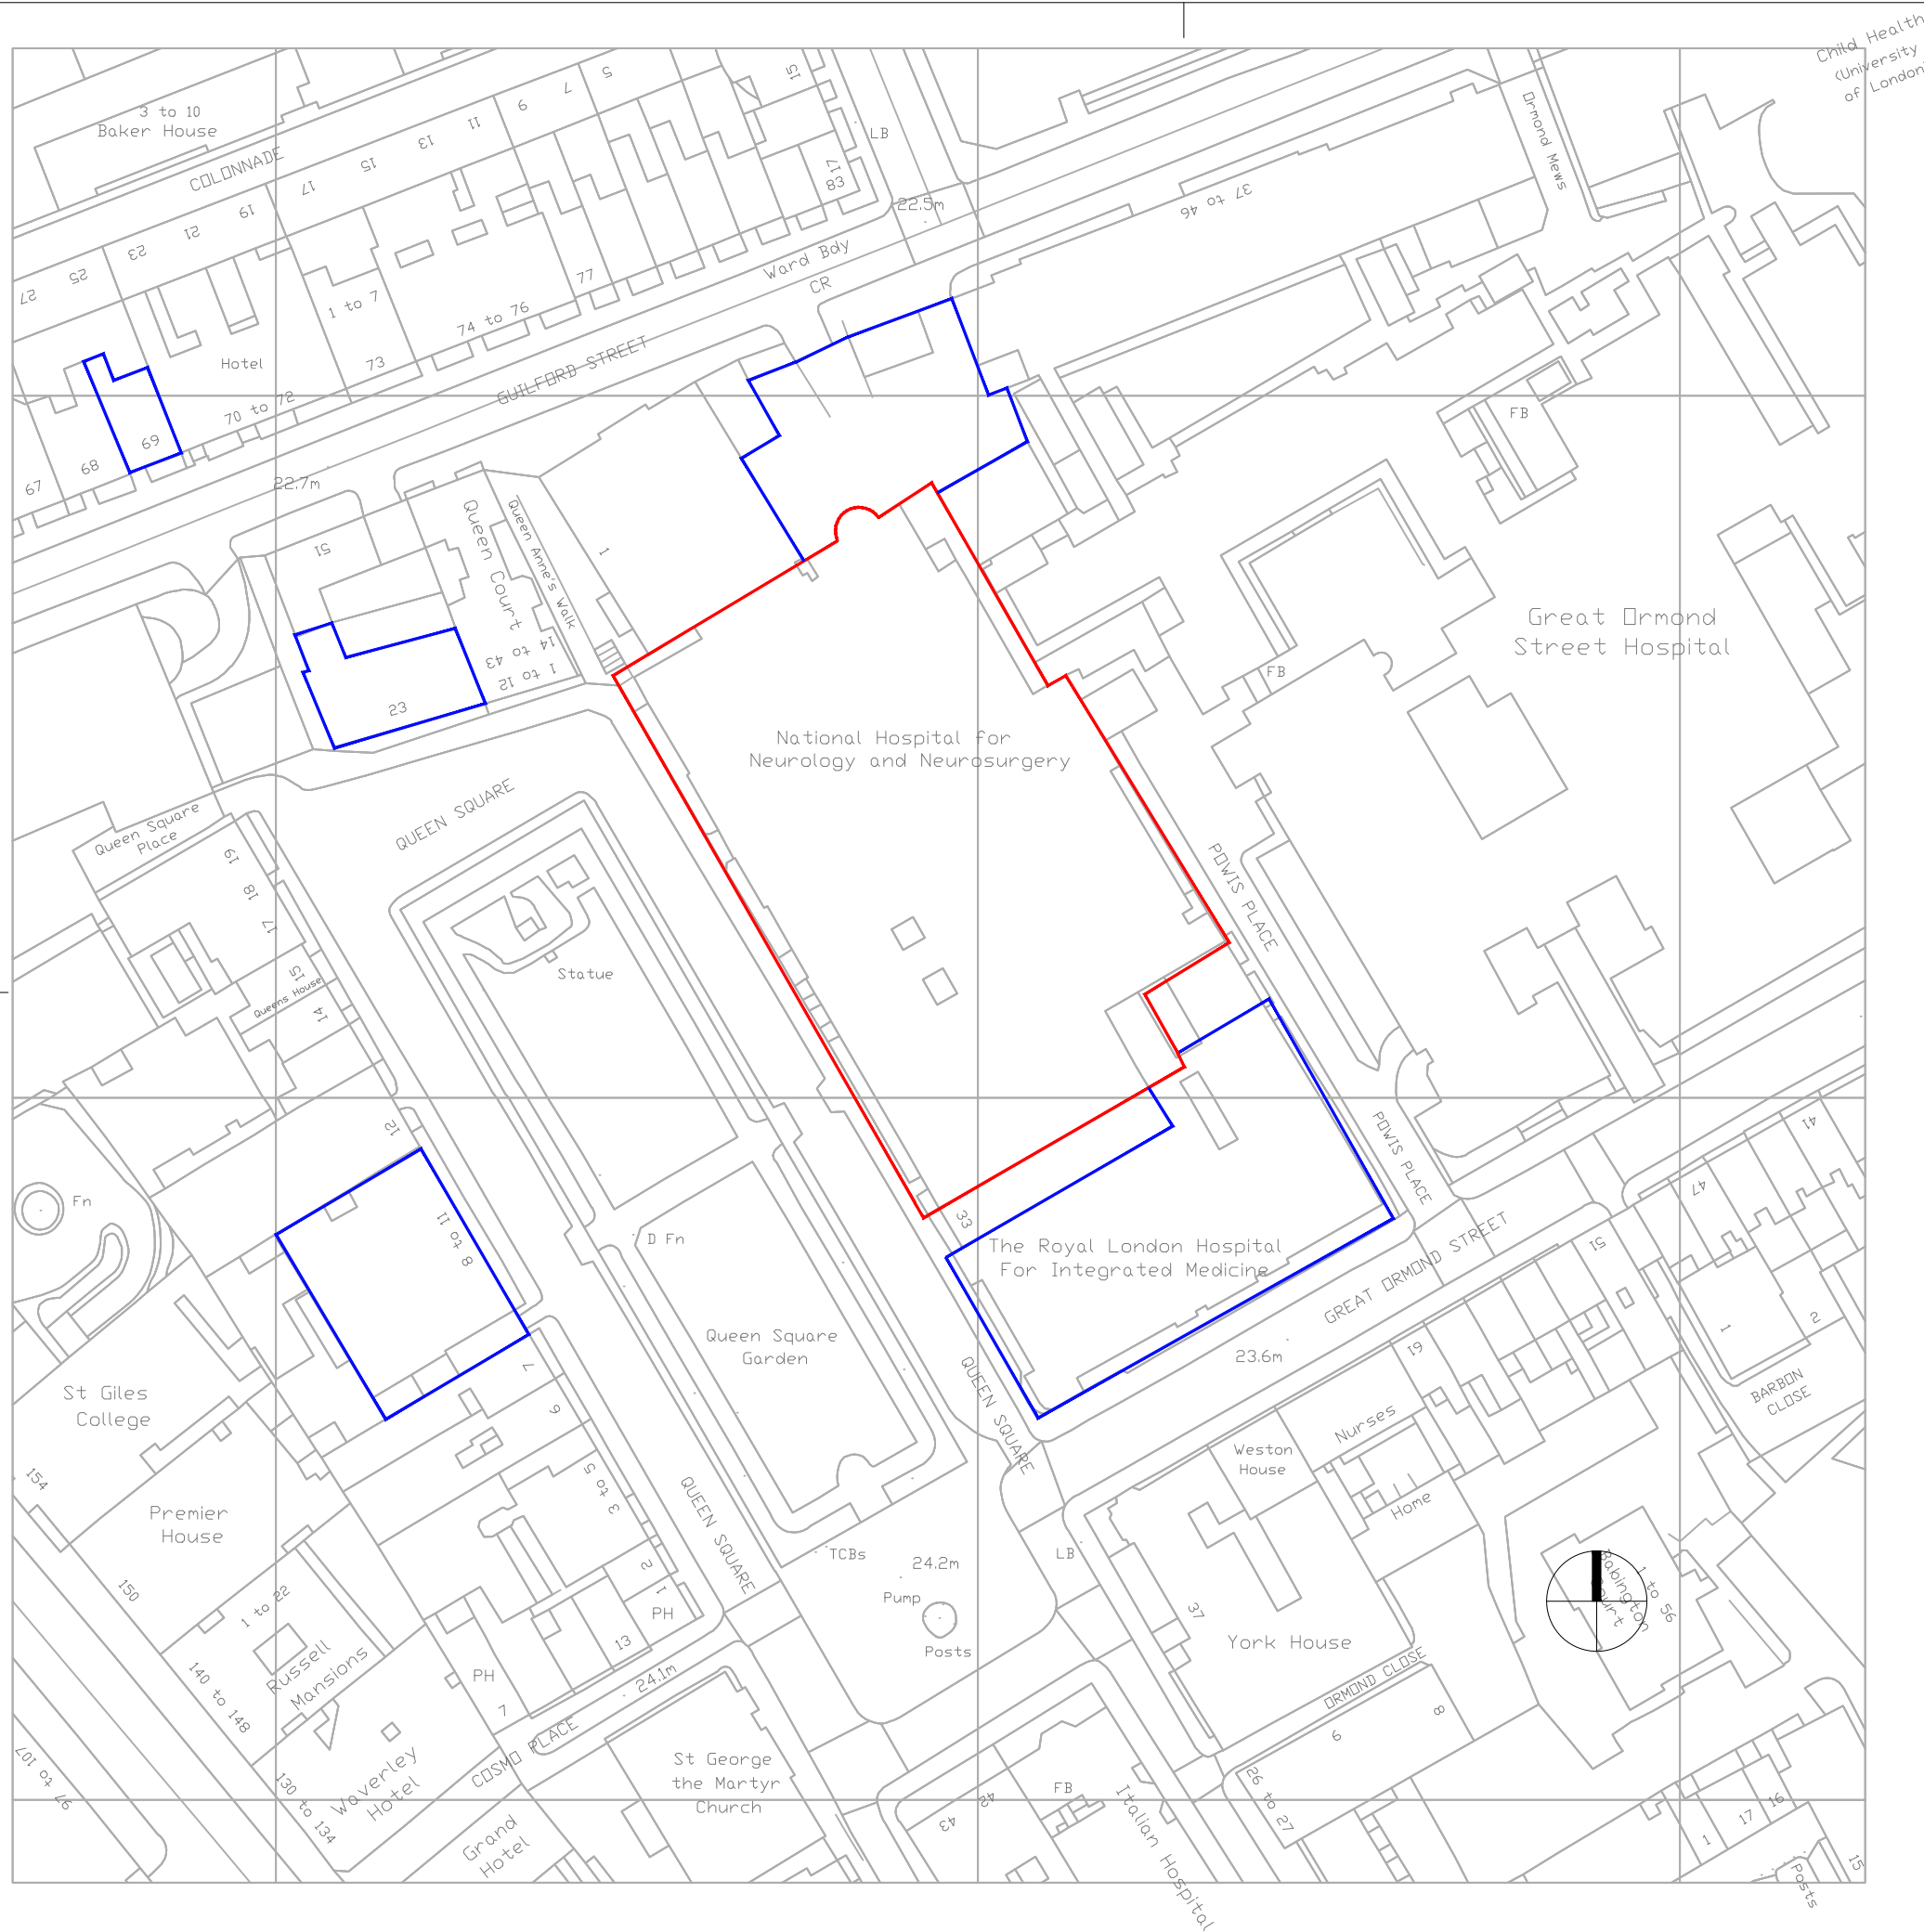

Copyright. All Rights Reserved.
This work is copyright and cannot be produced or copied in any form or by any means (graphic, electronic or mechanical including photocopying) without the written permission of the originator. Any license, express or implied, to use this document for any purpose whatsoever is restricted to the terms of the agreement or implied agreement between the originator and the instructing party.

DO NOT SCALE FROM THIS DRAWING. WORK ONLY FROM FIGURED DIMENSIONS.
THIS DRAWING TO BE READ IN CONJUNCTION WITH RELEVANT CONSULTANT'S DRAWINGS.

KEY PLAN

LEGEND



Owned by UCLH



Site extent

REV P01	DATE 14/08/2018	DRAWN / CHECKED / APPROVED AS / BW / BW
First Issue		

22a Arlington Way
London EC1R 1UY
+44 (0)20 7490 1904
london@medicalarchitecture.com
medicalarchitecture.com

Medical
Architecture

CLIENT
UNIVERSITY COLLEGE LONDON HOSPITALS

PROJECT
NHNN
5829 Queen Square Mains Power
Infrastructure Replacement

TITLE
PLANNING APPLICATION
Site Location Plan

STAGE	STATUS
02	S3

PROJECT NUMBER	SCALE @A3
775	1:1000

DRAWING NUMBER	REVISION
5829-MAA-ZZ-RF-DR-A-156-S3-P01	P01

FILE REFERENCE


KEY PLAN

REV P01 | DATE 15/08/2018 | DRAWN / CHECKED / APPROVED AS / BW / BW
First Issue


Legend

- Albany Wing
- Chandler Wing North
- Chandler Wing South
- Queen Mary Wing
- Queen Square House (UCL)
- Project Site Areas
- Duct works and trenches
- UCLH Demise as per Ordnance Survey Plan (see site plan for details)

Second Floor Plan

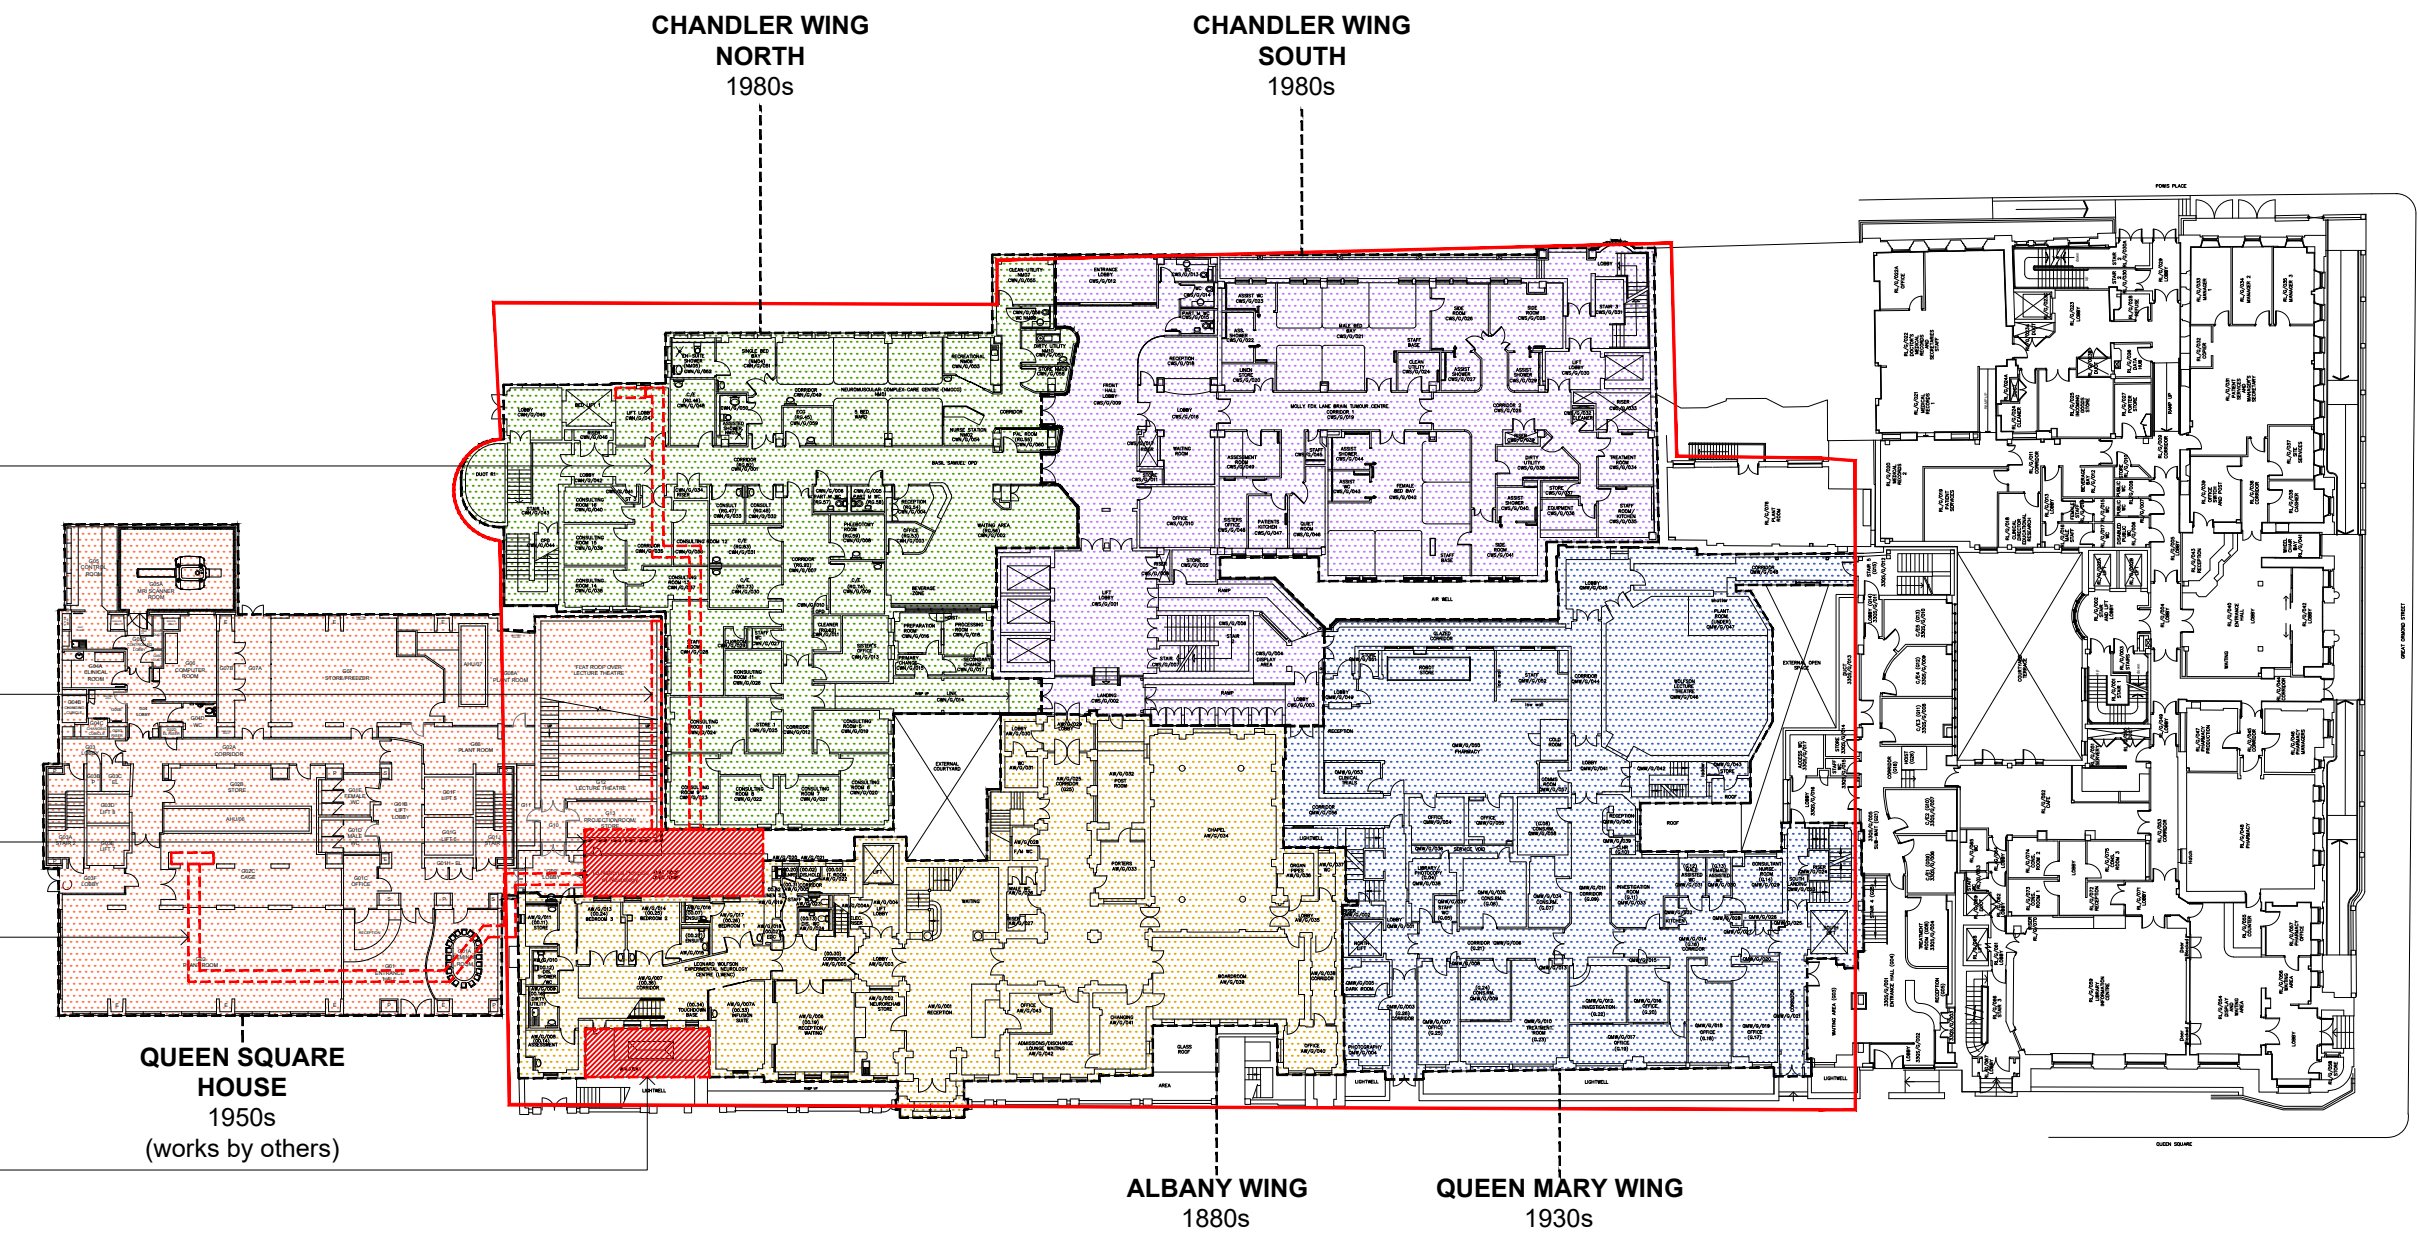

Ground Floor Plan

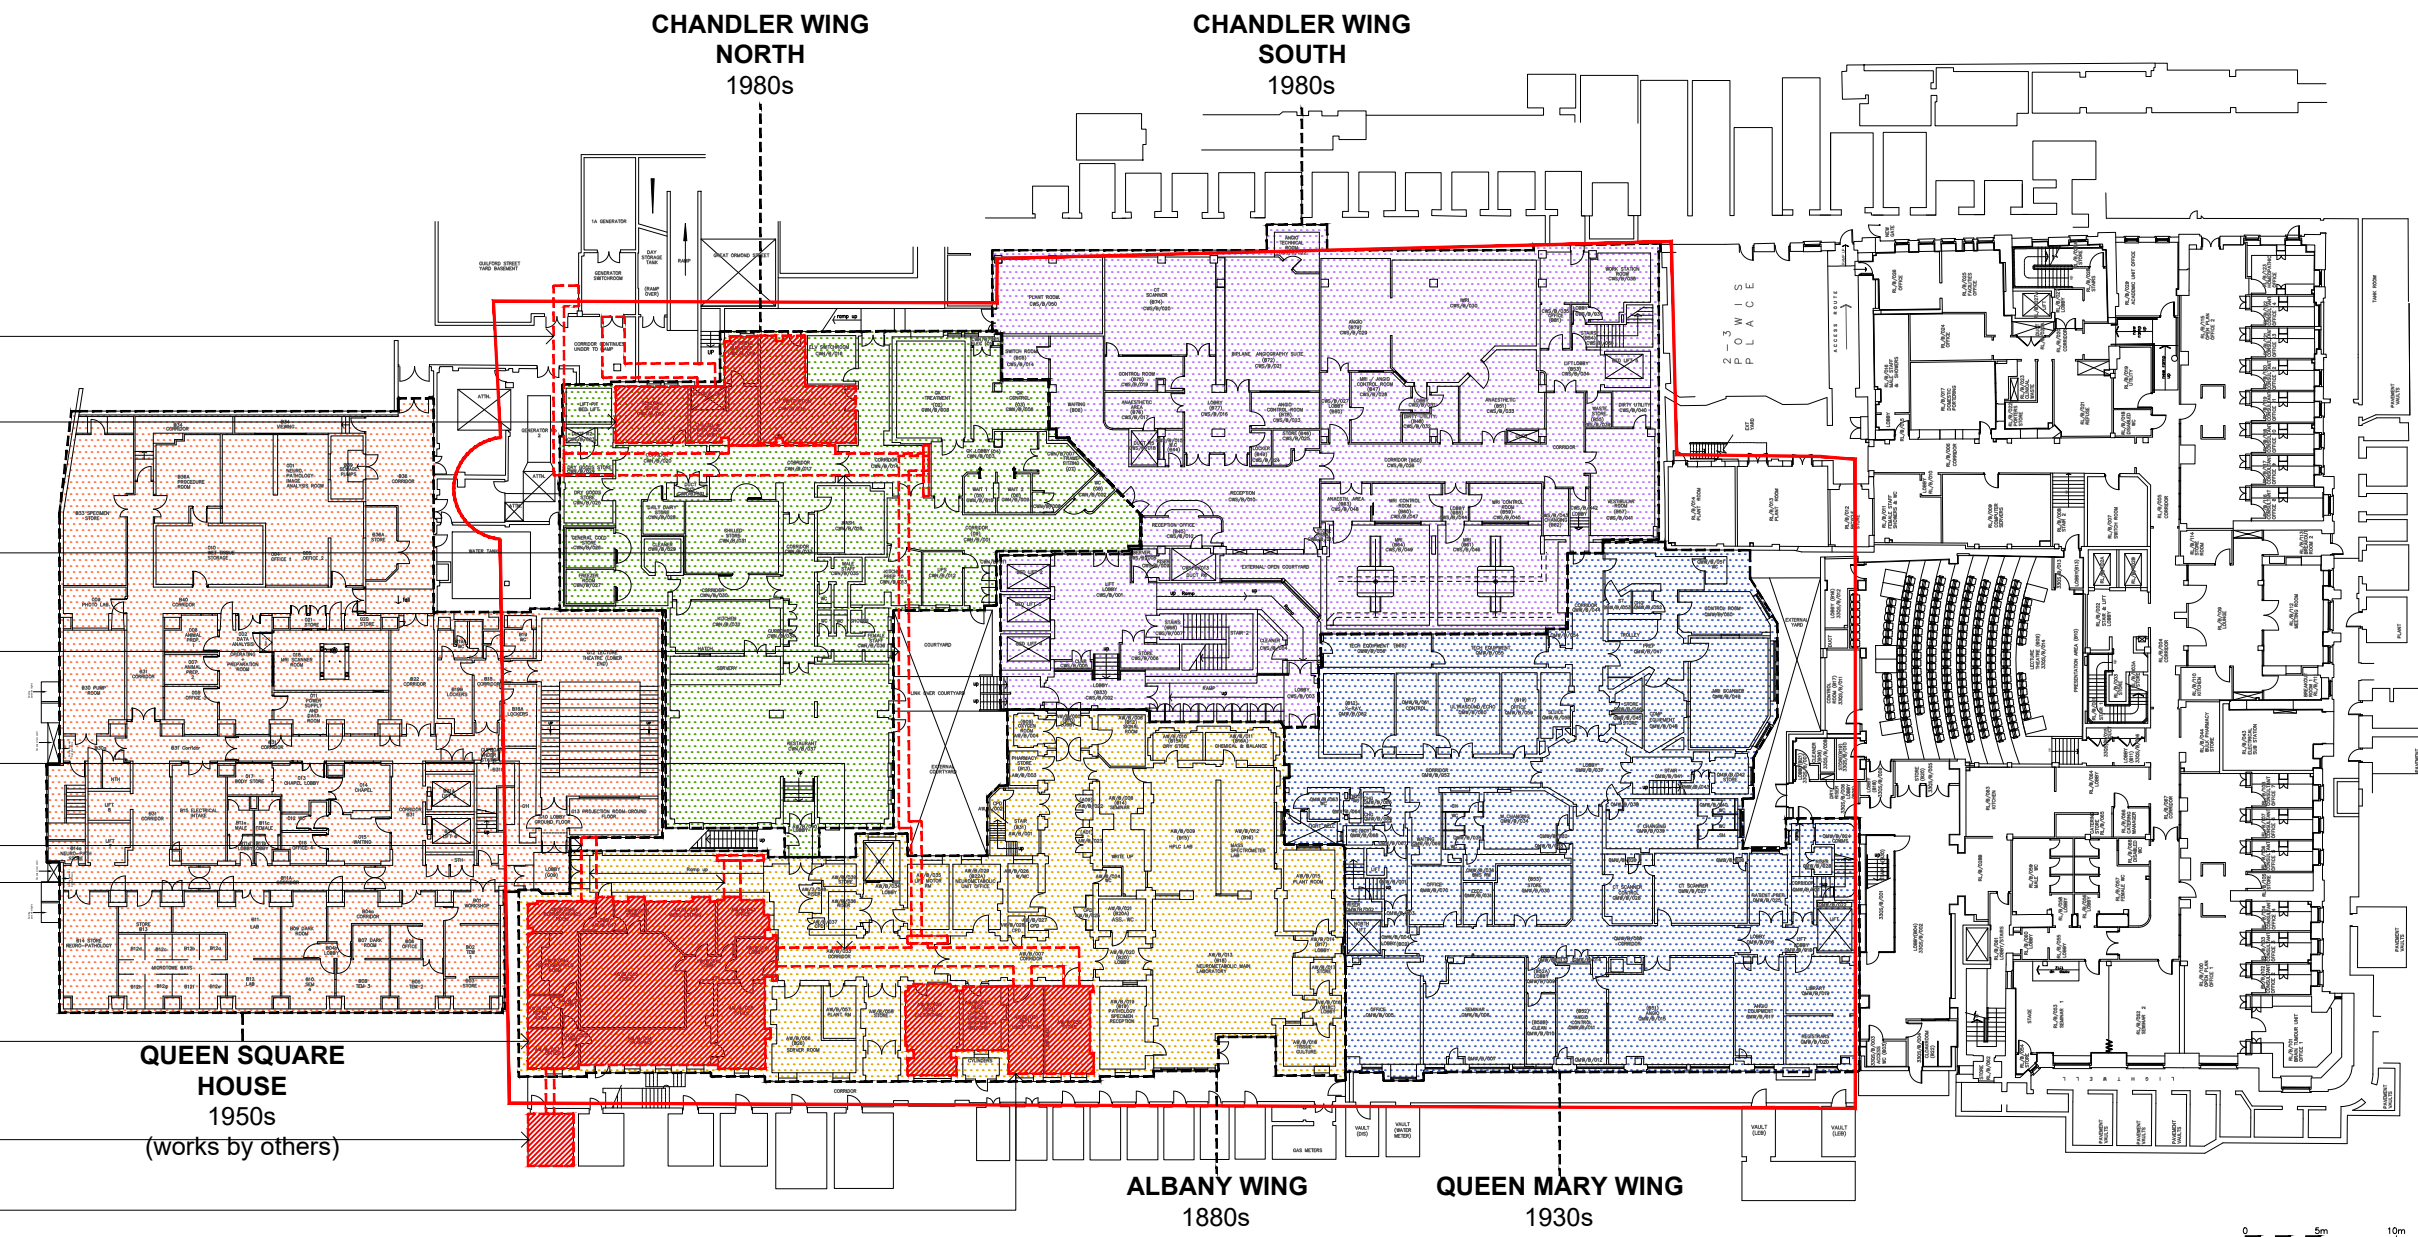

Basement Plan

4 Northington Street
London WC1N 2JG
+44 (0)20 7480 1904
london@medicalarchitecture.com
medicalarchitecture.com

Medical
Architecture

CLIENT
UNIVERSITY COLLEGE LONDON HOSPITALS

PROJECT
NHNN
5829 Queen Square Mains Power
Infrastructure Replacement


TITLE
PLANNING APPLICATION
Basement, Ground Floor, and Second Floor Plans

STAGE 02 STATUS S3

PROJECT NUMBER 775 SCALE @A1 1:500

DRAWING NUMBER 5829-MAA-ZZ-RF-DR-A-157-S3-P01 REVISION P01

FILE REFERENCE
\\Lon-arv-01\projects\775_UCLH_ElectricalInfrastructure\Design\Location\01_Zone\DWG

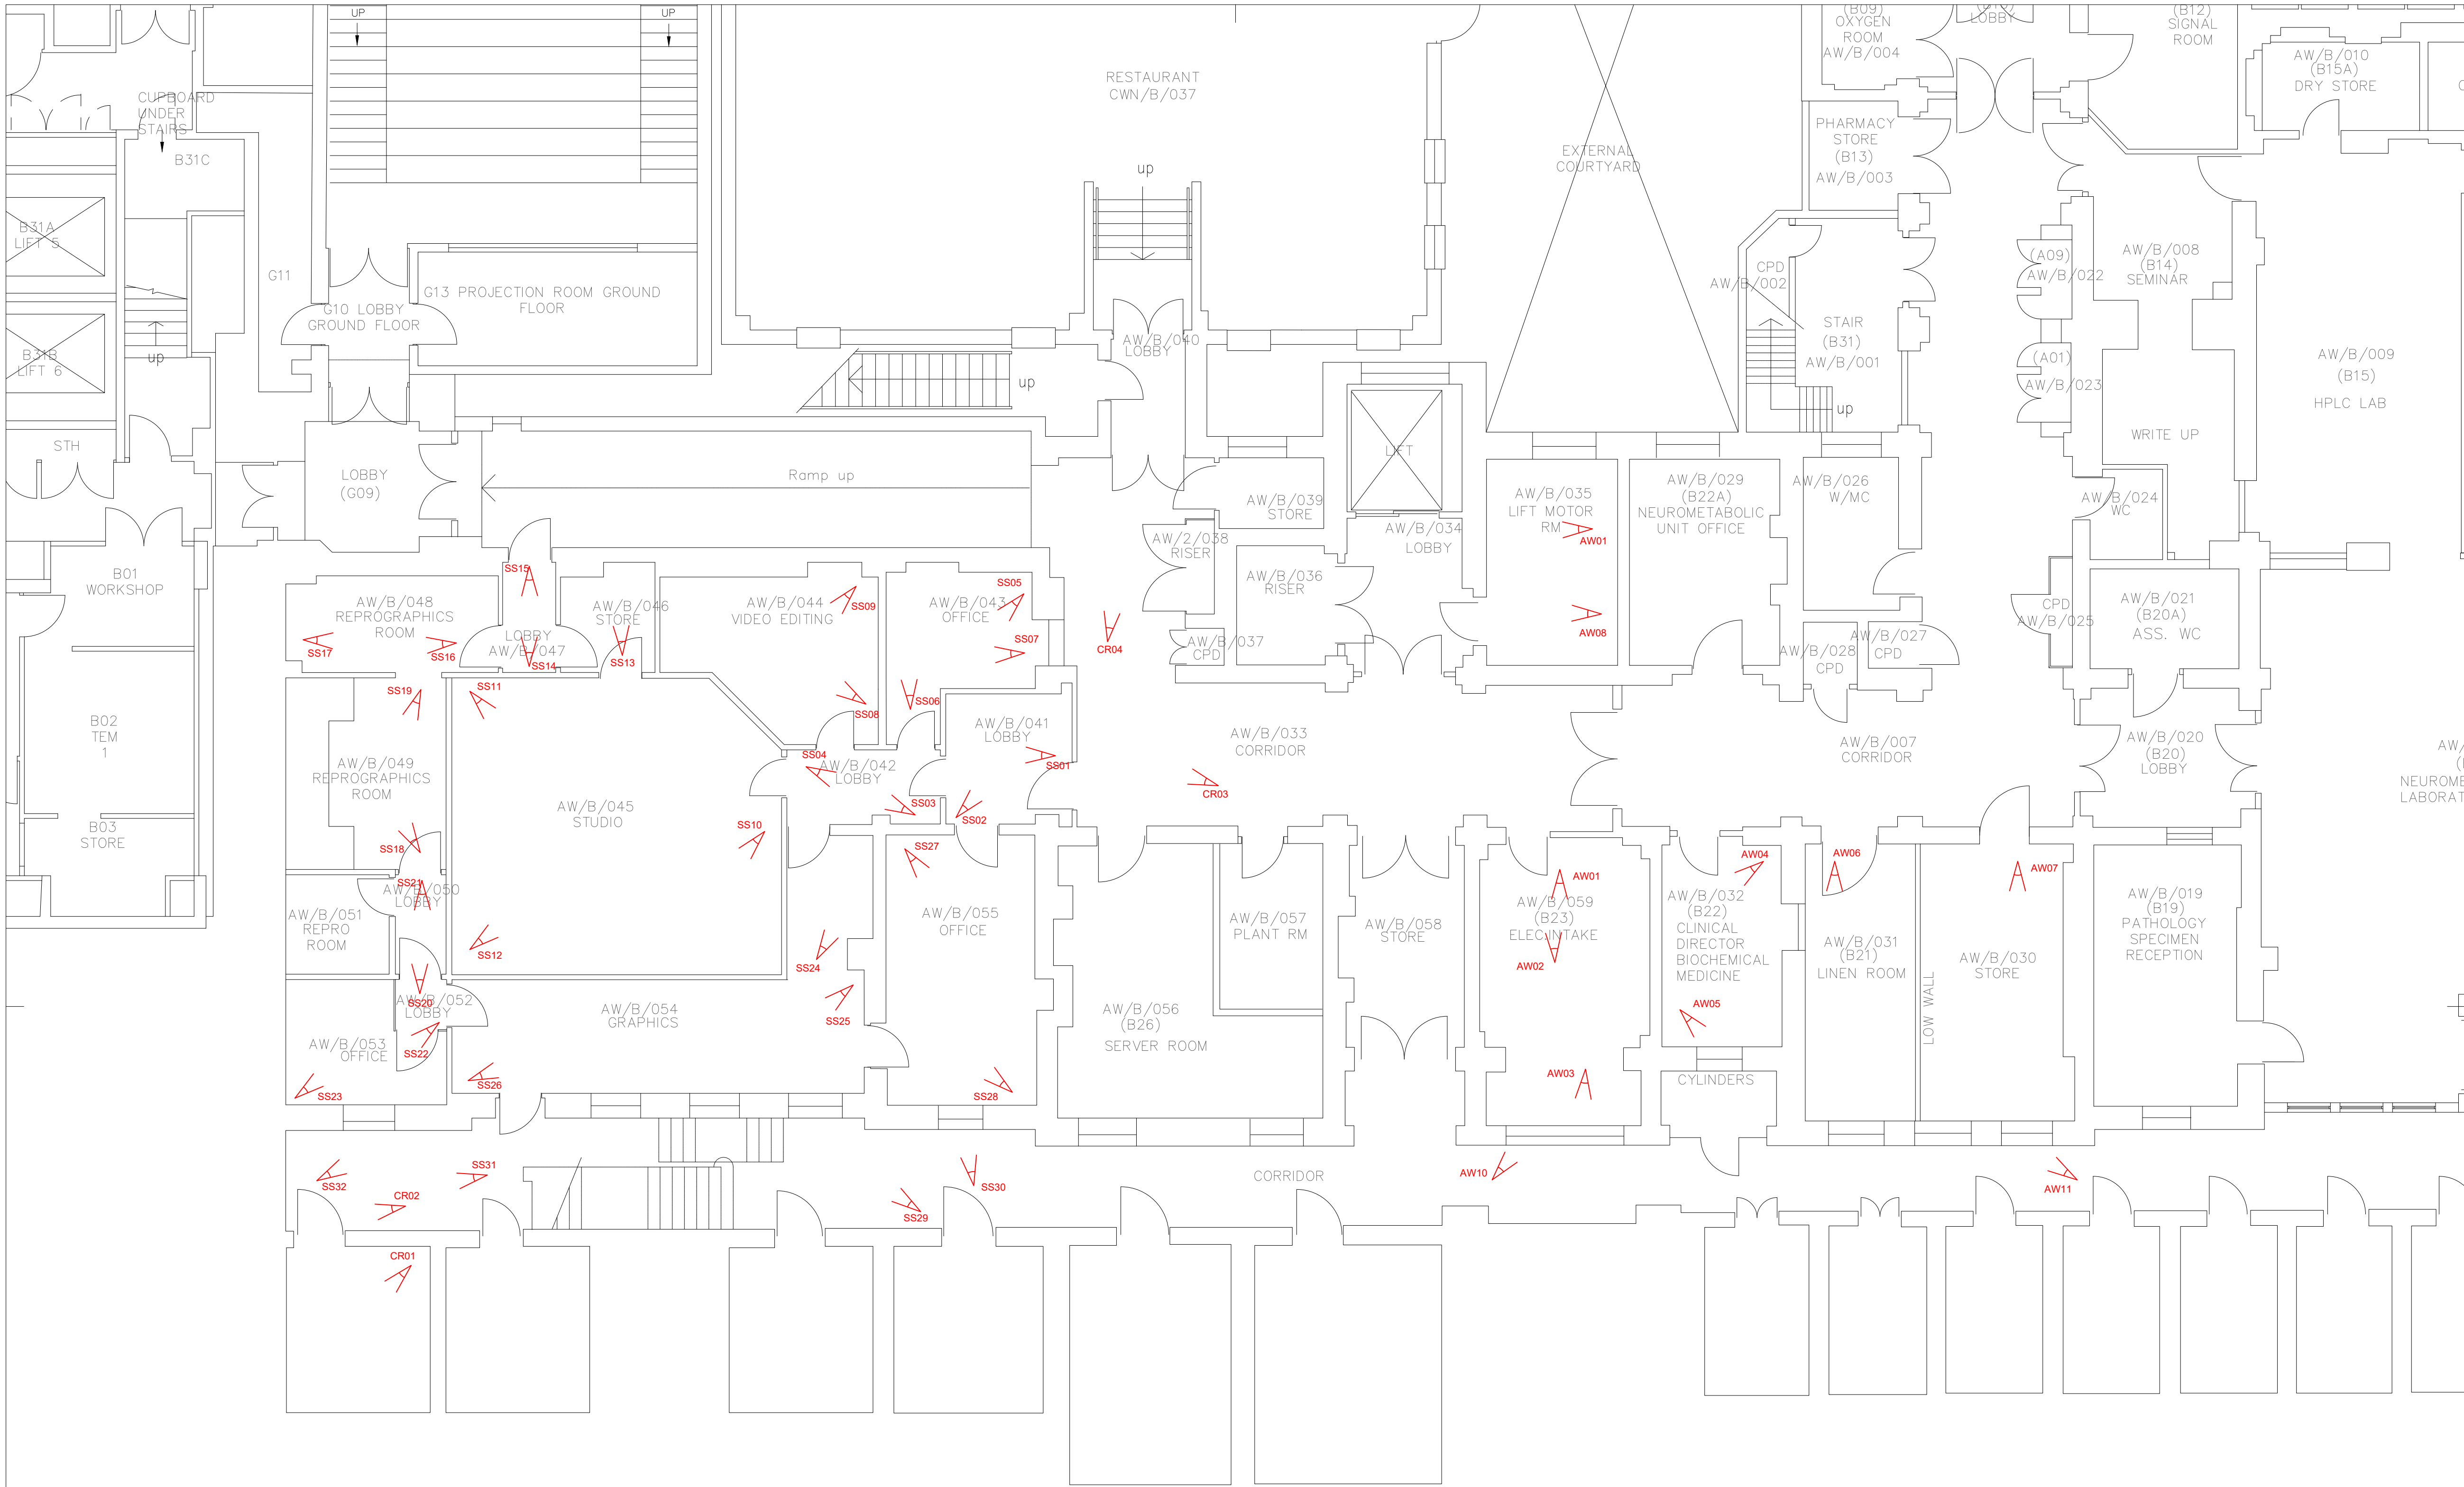

Copyright. All Rights Reserved.
This work is copyright and cannot be produced or copied in any form or by any means (graphic, electronic or mechanical including photocopying) without the written permission of the originator. Any license, express or implied, to use this document for any purpose whatsoever is restricted to the terms of the agreement or implied agreement between the originator and the instructing party.
DO NOT SCALE FROM THIS DRAWING. WORK ONLY FROM FIGURED DIMENSIONS.
THIS DRAWING TO BE READ IN CONJUNCTION WITH RELEVANT CONSULTANT'S DRAWINGS.

KEY PLAN

REV P01 | DATE 15/08/2018 | DRAWN / CHECKED / APPROVED AS / BW / BW
First Issue

4 Northington Street
London WC1N 2JG
+44 (0)20 7480 1904
london@medicalarchitecture.com
medicalarchitecture.com

Medical Architecture

CLIENT
UNIVERSITY COLLEGE LONDON HOSPITALS

PROJECT
NHNN
5829 Queen Square Mains Power
Infrastructure Replacement

TITLE
PLANNING APPLICATION
Photo Survey Locations
Basement Plan

STAGE 02	STATUS S3
PROJECT NUMBER 775	SCALE @A1 1:75
DRAWING NUMBER 5829-MAA-ZZ-B1-DR-A-175-S3-P01	REVISION P01

FILE REFERENCE
\\Lon-arc-01\projects\775_UCLH_ElectricalInfrastructure\Design\Location\01_Zone\DWG


FILE REFERENCE
\\Lon-srv-01\projects\775_UCLH_Electrical\Infrastructure\Design\Location\01_Zone\DWG

DO NOT SCALE FROM THIS DRAWING. WORK ONLY FROM FIGURED DIMENSIONS.
THIS DRAWING TO BE READ IN CONJUNCTION WITH RELEVANT CONSULTANT'S DRAWINGS.

[illegible]

Medical
Architecture

FILE REFERENCE
\\Lon-srv-01\projects\775_UCLH_Electrical\Infrastructure\Design\Location\01_Zone\DWG

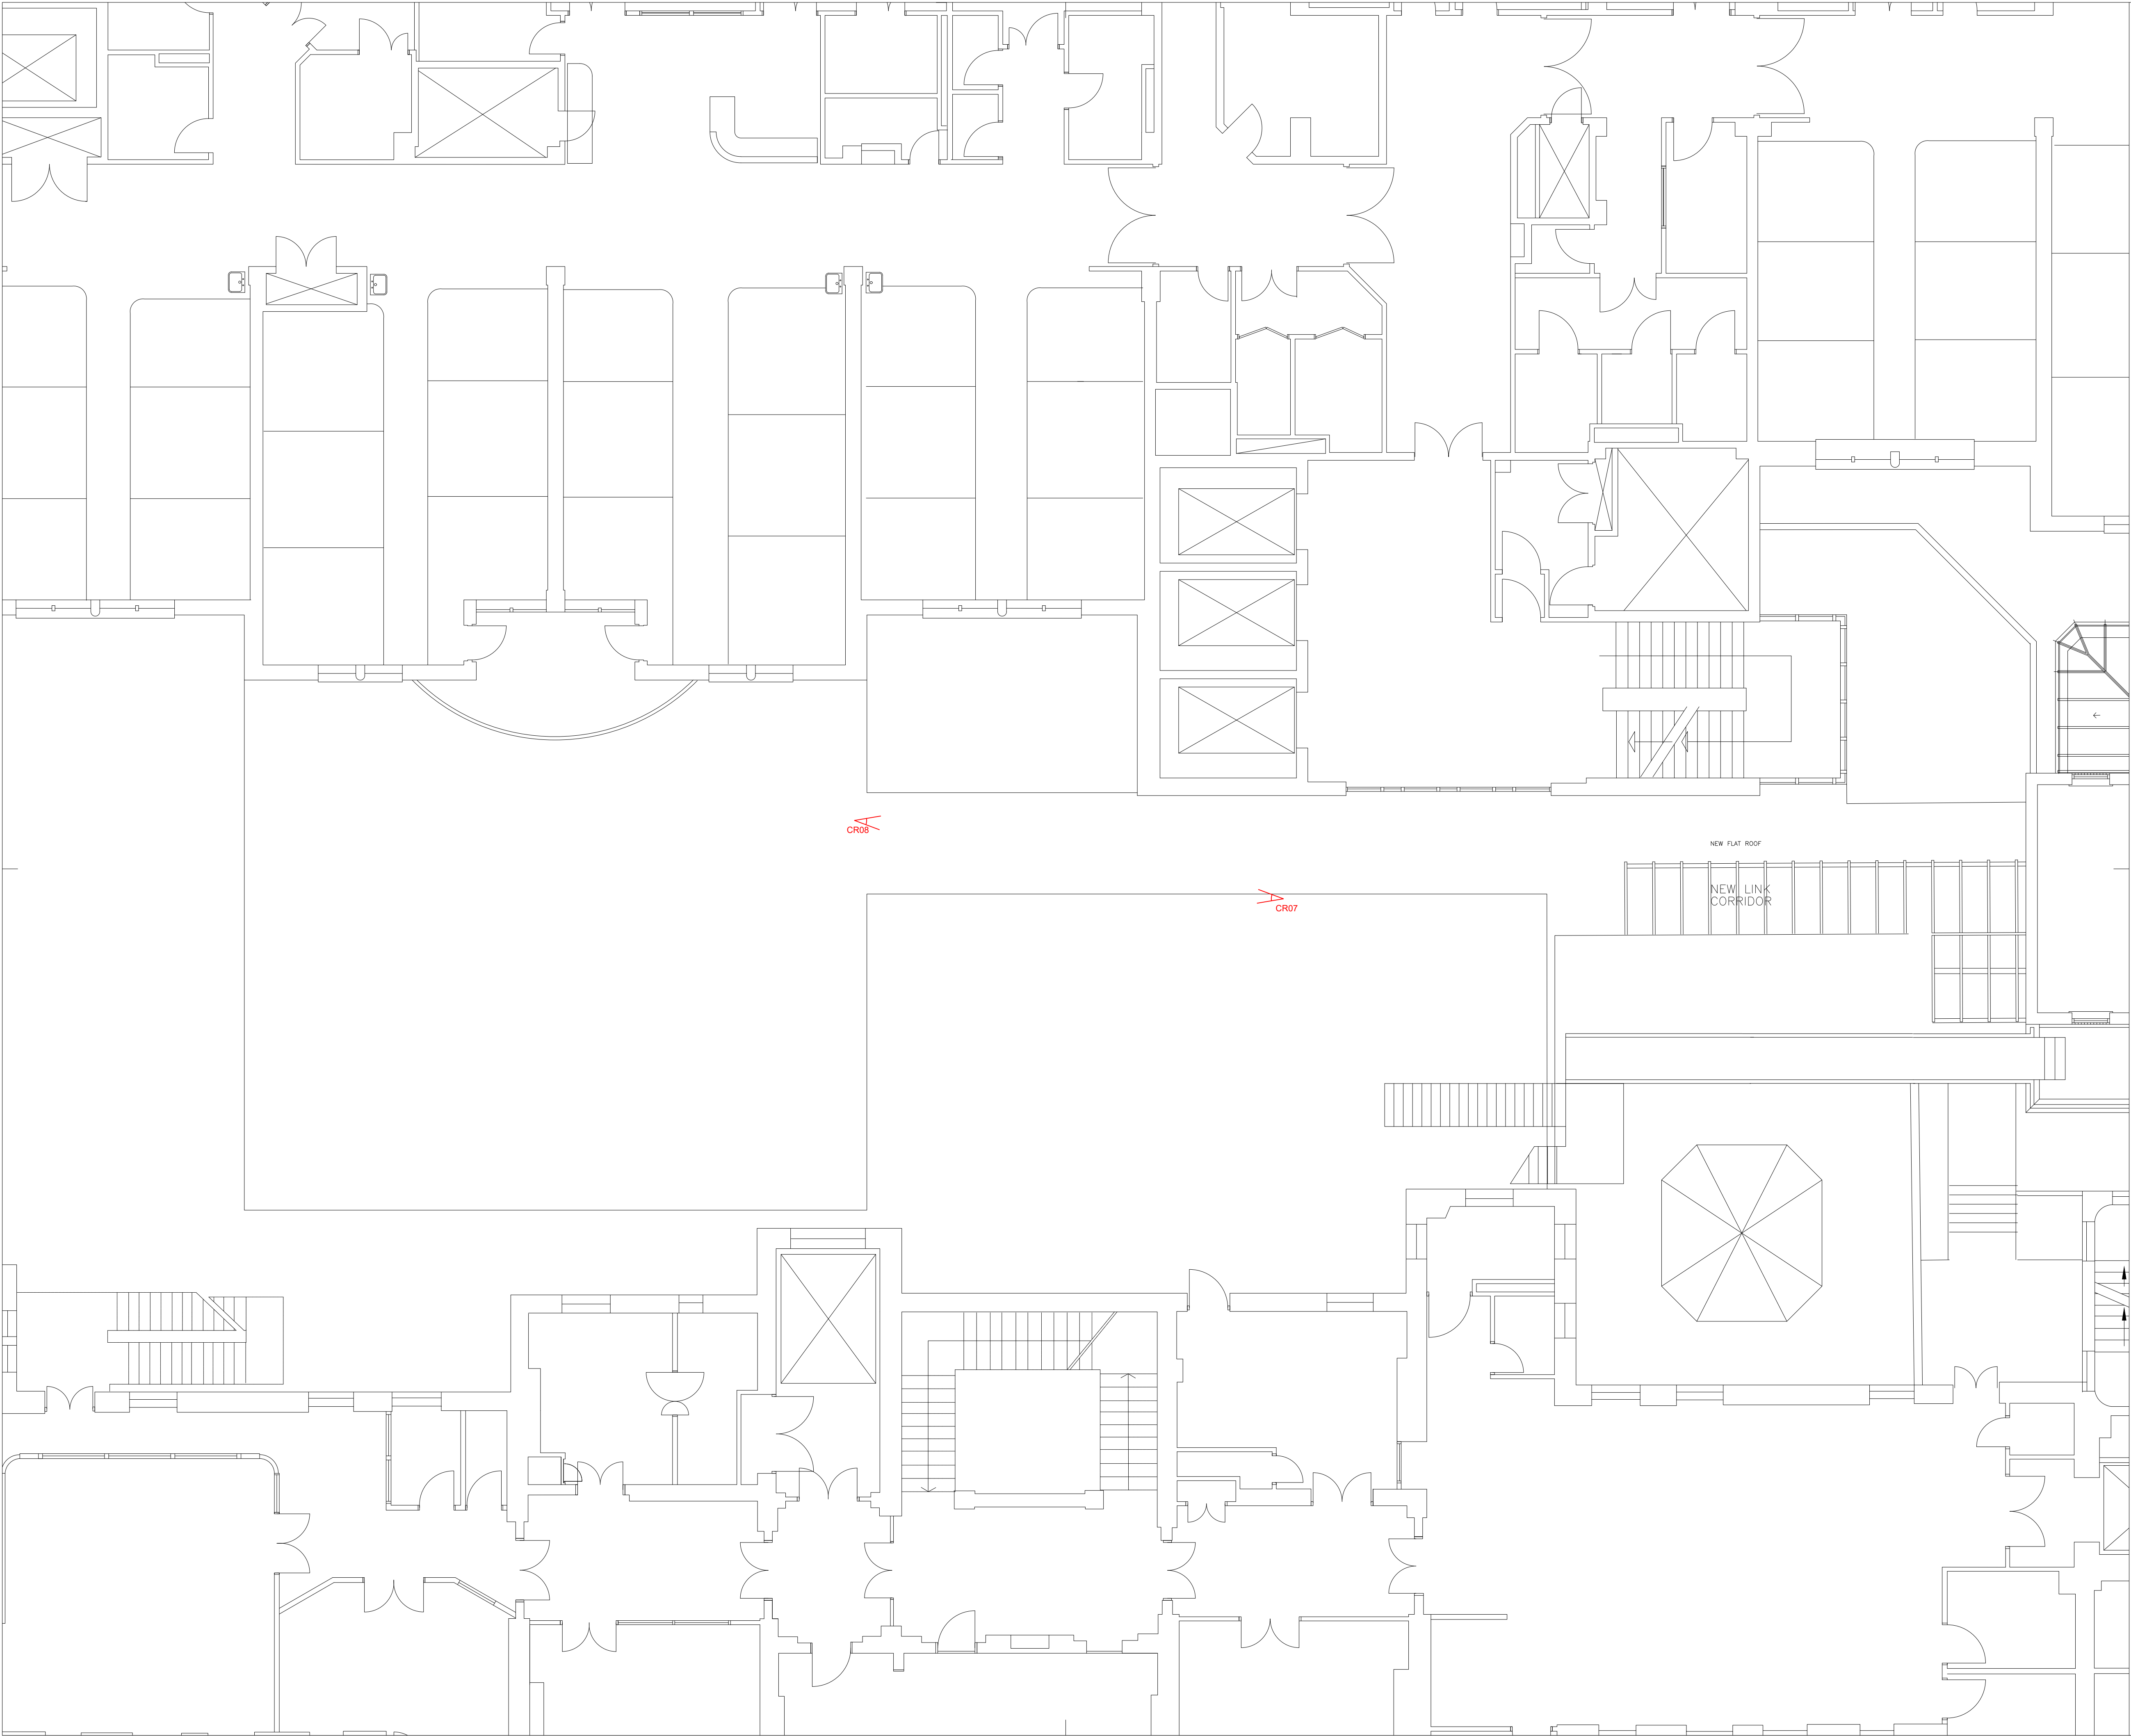

Copyright. All Rights Reserved.
This work is copyright and cannot be produced or copied in any form or by any means (graphic, electronic or mechanical including photocopying) without the written permission of the originator. Any license, express or implied, to use this document for any purpose whatsoever is restricted to the terms of the agreement or implied agreement between the originator and the instructing party.

DO NOT SCALE FROM THIS DRAWING. WORK ONLY FROM FIGURED DIMENSIONS.
THIS DRAWING TO BE READ IN CONJUNCTION WITH RELEVANT CONSULTANT'S DRAWINGS.

KEY PLAN

REV P01 | DATE 15/08/2018 | DRAWN / CHECKED / APPROVED AS / BW / BW
First Issue

4 Northington Street
London WC1N 2JG
+44 (0)20 7480 1904
london@medicalarchitecture.com
medicalarchitecture.com

Medical
Architecture

CLIENT
UNIVERSITY COLLEGE LONDON HOSPITALS

PROJECT
NHNN
5829 Queen Square Mains Power
Infrastructure Replacement

TITLE
PLANNING APPLICATION
Photo Survey Locations
Second floor plan

STAGE | STATUS
02 | S3

PROJECT NUMBER | SCALE @A1
775 | 1:500

DRAWING NUMBER | REVISION
5829-MAA-ZZ-02-DR-A-178-S3-P01 | P01

FILE REFERENCE
\\Lon-arc-01\projects\775_UCLH_ElectricalInfrastructure\Design\Location\01_Zone\DWG

KEY PLAN

REV P01 | DATE 19/09/2018 | DRAWN / CHECKED / APPROVED AS / BW / BW
First Issue



FLAT ROOF BEFORE



FLAT ROOF AFTER

22a Arlington Way
London EC1R 1UY
+44 (0)20 7490 1904
london@medicalarchitecture.com
medicalarchitecture.com

Medical
Architecture

CLIENT
UNIVERSITY COLLEGE LONDON HOSPITALS

PROJECT
NHNN
5829 Queen Square Mains Power
Infrastructure Replacement

TITLE
PLANNING APPLICATION
Access Hatch Perspectives

STAGE 02 | STATUS S3

PROJECT NUMBER 775 | SCALE @A3 N/A

DRAWING NUMBER 5829-MAA-LW-ZZ-DR-A-241-S3-P01 | REVISION P01

FILE REFERENCE
\\Lon-srv-01\projects\775_UCLH_ElectricalInfrastructure\Design\Location\01_Zone\DWG