


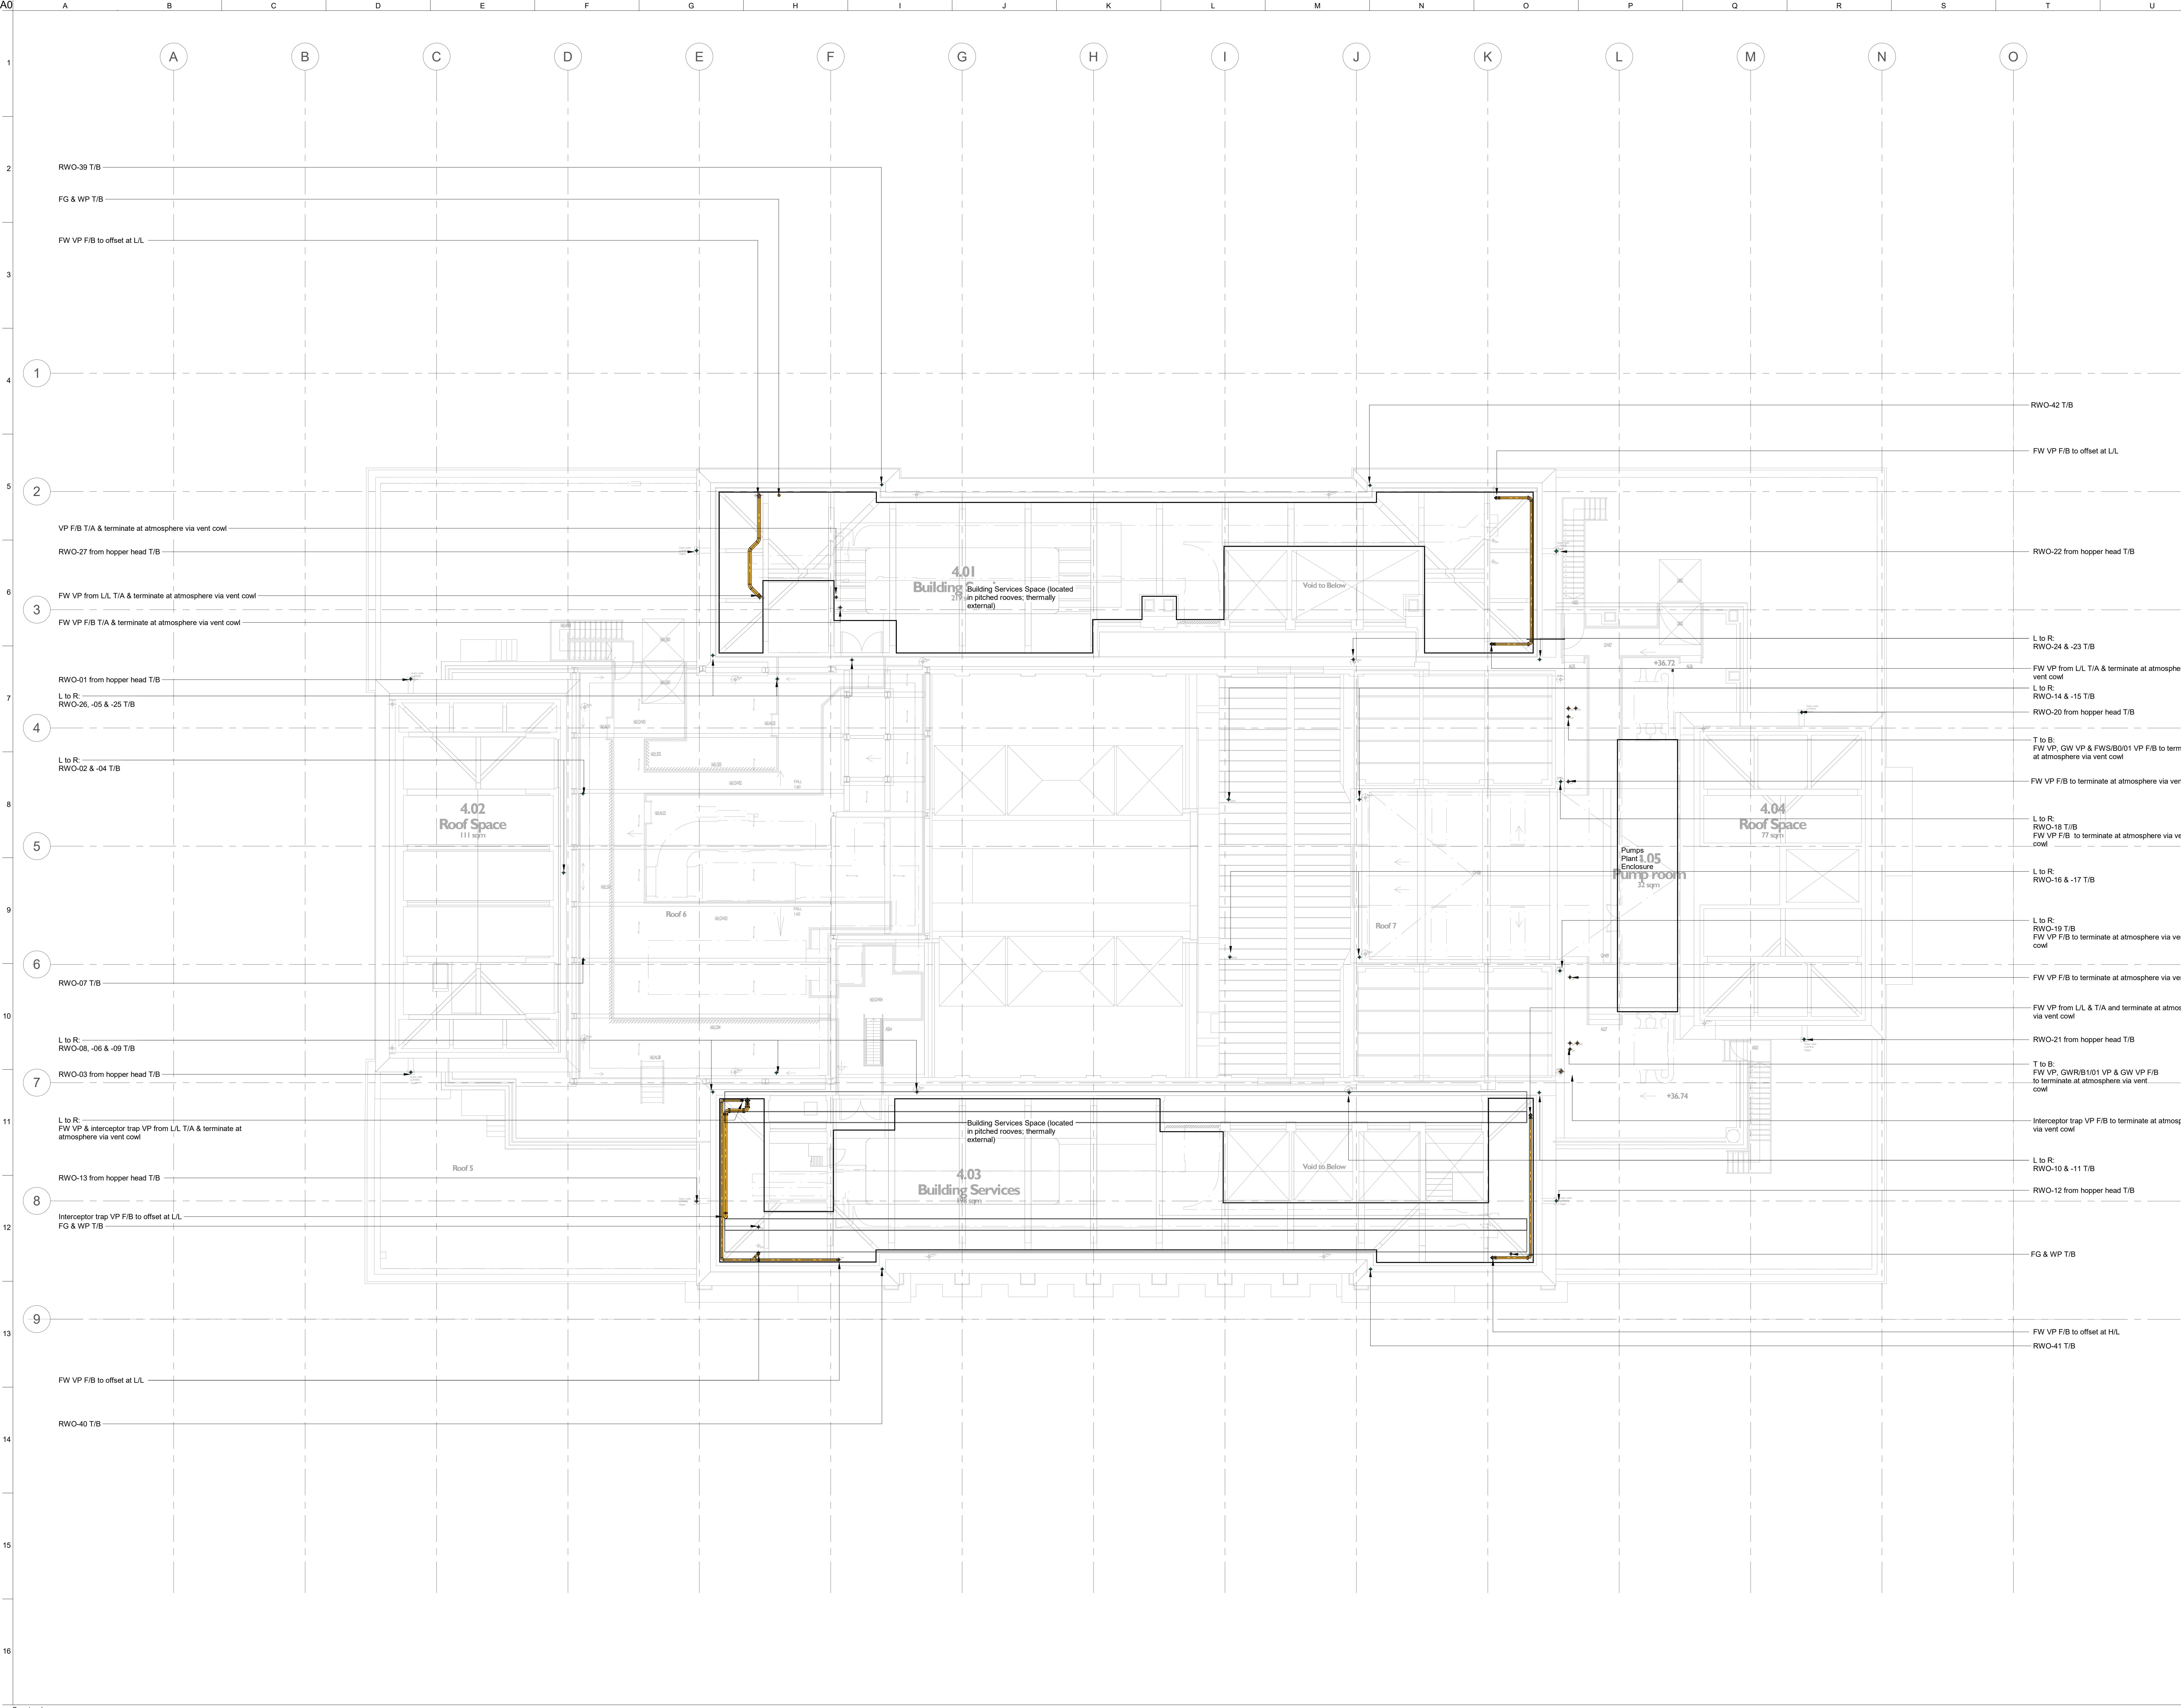

- Notes:
1. This drawing shall be read in conjunction with all relevant Mechanical, Electrical, Public Health, Architectural and Structural drawings and all other schedules and relevant documentation.
 2. The MEP services drawings should not be scaled and all dimensional setting out of furniture fittings and equipment shall be taken from the architectural drawings.
 3. All pipework running through habitable spaces shall be acoustically insulated.
 4. All drainage stacks shall be cast iron.
 5. Rodding eyes shall be provided in every change of direction in the pipework.
 6. Adequate access panels shall be provided to allow for maintenance for the pipework.
 7. All drainage pipework shall be fully roddable with access at all changes in direction. All bends are to be made with 2 no. 45 degree bends.
 8. Contractor to coordinate services running through beam penetrations.

T00	27/09/19	AD	DH	VM
Stage 4 - Tender Issue				
P00	20/03/19	AD	VM	VM
Stage 3 Issue				
Rev	Date	By	Chkd	Appd

ARUP

13 Fenny Street,
London W11 4EQ
Tel +44(0)20 7586 1531 Fax +44(0)20 7586 3524
www.arup.com

Client
Lendlease

Project Title
Camden Town Hall

Drawing Title
Public Health Services
Above Ground Drainage Layout
Roof

Scale at A0
1 : 100

Role
Public Health Services

Suitability
S4 - Suitable For Stage Approval

Arup Job No
261250

Rev
T00

Name
CTH-ARP-L04-DR-52-P-3500