



© Architon LLP 2014

This drawing is the property of Architon LLP and must not be divulged to anyone, copied or reproduced, or used for marketing, advertising or promotional purposes without the express written permission of Architon LLP.


All dimensions are to be checked on site and not scaled from this drawing. Contractors must verify all dimensions on site before setting out, commencing work or preparing shop drawings. Any discrepancies on this drawing with other contract documentation to be reported immediately for clarification.

DRAWINGS ARE BASED ON INFORMATION PROVIDED BY UCL.

DRAWINGS TO BE READ IN CONJUNCTION WITH:

- ARCHITECTURAL SCHEDULES AND SPECIFICATIONS.
- STRUCTURAL DRAWINGS AND SPECIFICATIONS.
- M&E DRAWINGS AND SPECIFICATIONS.
- ACOUSTIC REPORTS.
- FIRE STRATEGY.

WORKS AREAS NOT SURVEYED.

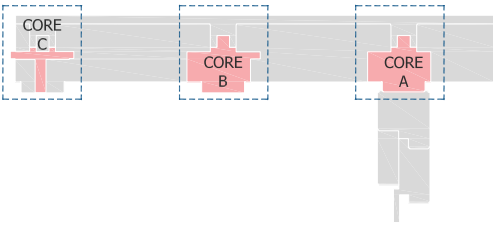

1 LEVEL 9 - KEY PLAN
FOR REFERENCE NTS

PLANNING ISSUE

C	RISER DOORS SHOWN	19.12.2019
B	MINOR AMENDMENTS TO SUIT COMMENTS	18.12.2019
A	APPLICATION FOR LISTED CONSENT	06.12.2019
-	PRELIMINARY - FOR COMMENT	22.11.2019

Rev	Description	Date
-----	-------------	------



Client
Job title
University College London
Institute of Education
Phase 2
20 Bedford Way, WC1H 0AL

Drawing title
Level 9
Proposed Plan


Scale	Date	Drawn
1:100 @ A1	Nov 19	CM

ARCHITON LLP
CHARTERED ARCHITECTS - DESIGN
PLANNING CONSULTANTS - DEVELOPMENT
BUILDING COST MANAGEMENT

REGENCY HOUSE
17 WEST STREET
EPSOM KT18 7RL

TEL:01372 745600
FAX:01372 745016
Email:info@architon.com

Drawing No 3147-P1-2903 C	ARCHITON LLP certified to: BS EN ISO 9001 BS EN ISO 14001 ITP Accreditation
------------------------------	---

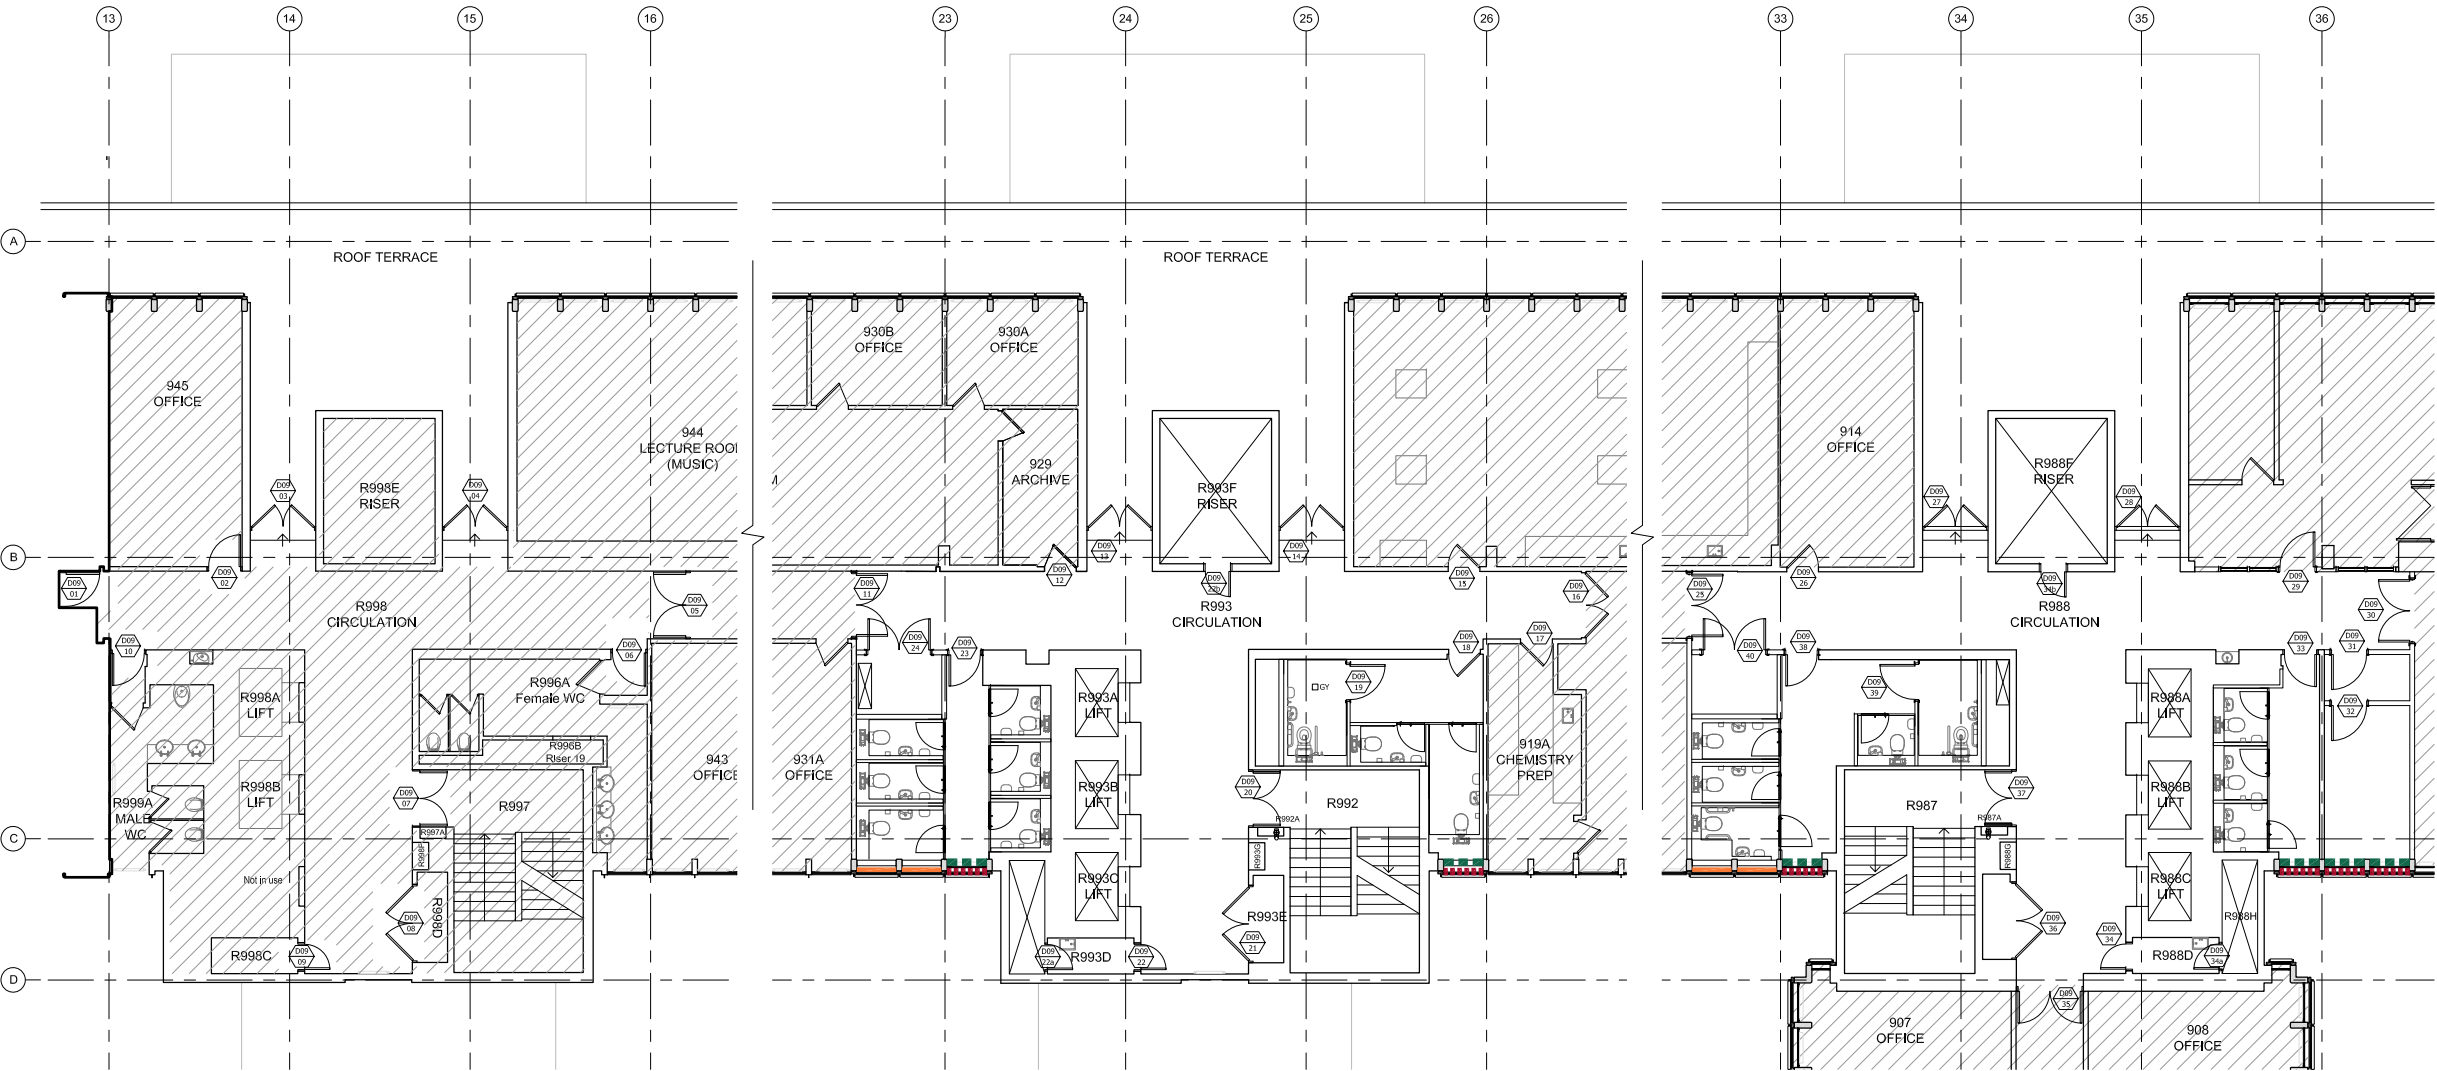

2 LEVEL 9 - CORE C
PROPOSED PLAN 1:100

3 LEVEL 9 - CORE B
PROPOSED PLAN 1:100

4 LEVEL 9 - CORE A
PROPOSED PLAN 1:100

LEGEND

- AREA OUTSIDE SCOPE OF WORKS, EXCEPT FOR MAKING GOOD WHERE DISTURBED
- NEW SECONDARY GLAZING
- NEW WINDOW TREATMENT BLD-01 - GLARE BLINDS (MANUAL)
- WINDOW TREATMENT GS-01 - OPAQUE WINDOW FILM -
- NEW DOORSET
- NEW RISER ACCESS DOOR - LOCATION TO BE CONFIRMED TO SUIT LOCATION OF NEW AND EXISTING SERVICES





© Architon LLP 2014

This drawing is the property of Architon LLP and must not be divulged to anyone, copied or reproduced, or used for marketing, advertising or promotional purposes without the express written permission of Architon LLP.


All dimensions are to be checked on site and not scaled from this drawing. Contractors must verify all dimensions on site before setting out, commencing work or preparing shop drawings. Any discrepancies on this drawing with other contract documentation to be reported immediately for clarification.

DRAWINGS ARE BASED ON INFORMATION PROVIDED BY UCL.


DRAWINGS TO BE READ IN CONJUNCTION WITH:

- ARCHITECTURAL SCHEDULES AND SPECIFICATIONS.
- STRUCTURAL DRAWINGS AND SPECIFICATIONS.
- M&E DRAWINGS AND SPECIFICATIONS.
- ACOUSTIC REPORTS.
- FIRE STRATEGY.

WORKS AREAS NOT SURVEYED.

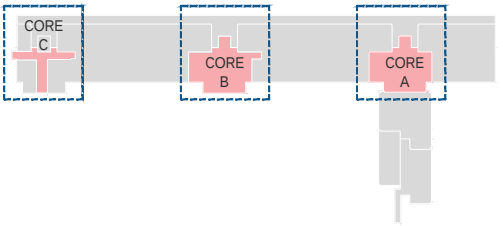

1 LEVEL 9 - KEY PLAN
FOR REFERENCE NTS

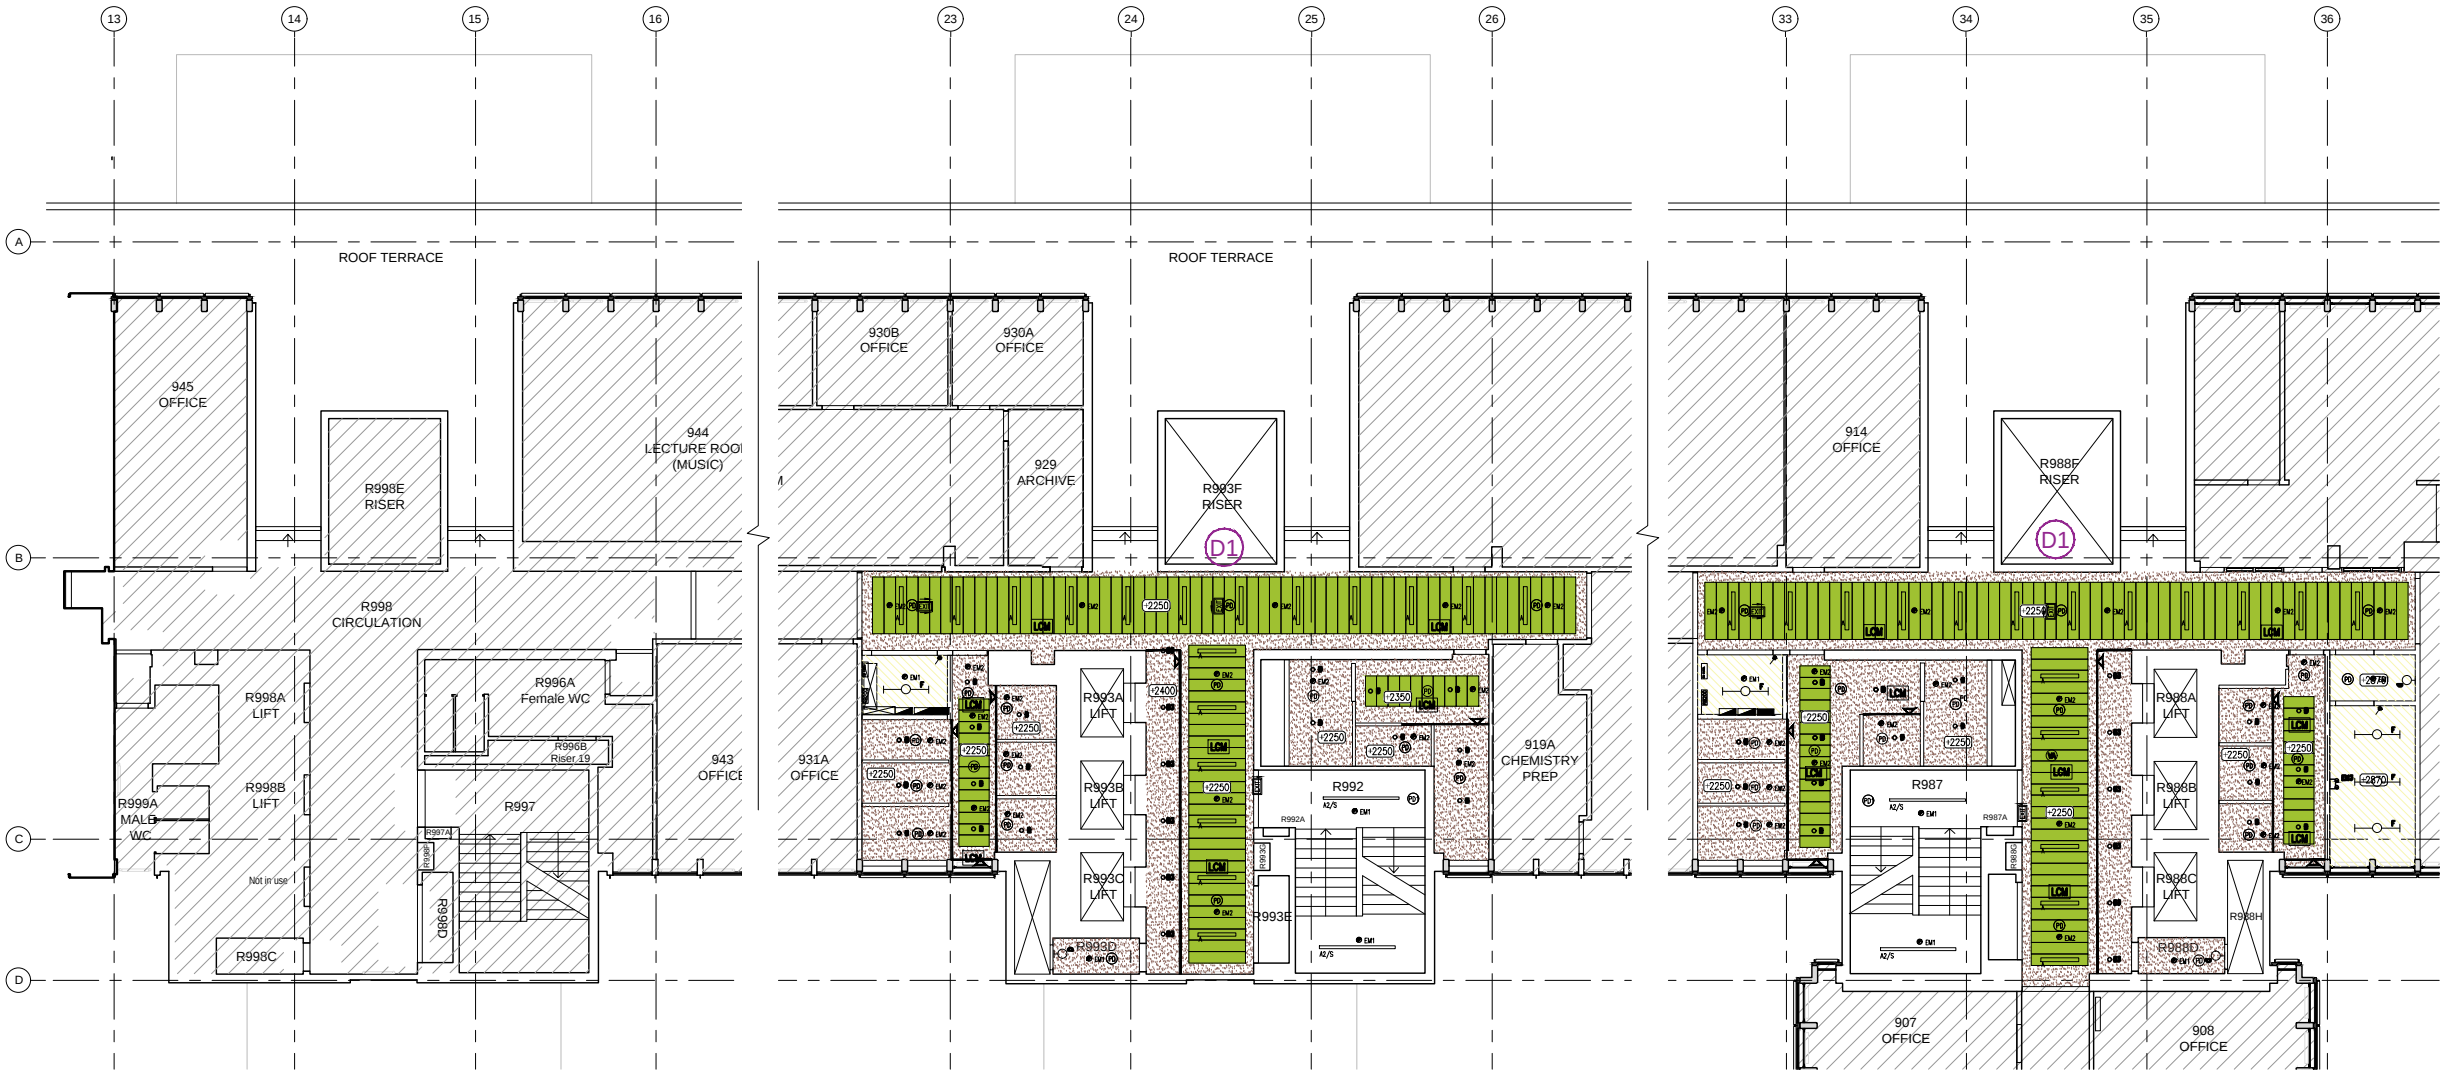

2 LEVEL 9 - CORE C
REFLECTED CEILING FINISHES 1:100

3 LEVEL 9 - CORE B
REFLECTED CEILING FINISHES 1:100

4 LEVEL 9 - CORE A
REFLECTED CEILING FINISHES 1:100

LEGEND

AREA OUTSIDE SCOPE OF WORKS, EXCEPT FOR MAKING GOOD WHERE DISTURBED

NOTE: APPLY PAINT FINISH TO ALL EXPOSED INTERNAL SOFFITS, TO INCLUDE ABOVE ALL M&E SERVICES AND ACOUSTIC PANELS.

PAINT FINISH TO EXPOSED SOFFITS, COLOUR - 'LINEN' TO MATCH PHASE 1

PLASTERBOARD SUSPENDED CEILING SYSTEM, PAINT FINISH, COLOUR WHITE

METAL SUSPENDED CEILING - PLANKS, COLOUR WHITE PPC

ACOUSTIC RAFT WITH INTEGRATED SERVICES

LINE / FACE OF BULKHEAD / LOWERED SOFFIT

DUST SEAL TO SOFFIT ONLY

CEILING TYPE

NOTIONAL CEILING HEIGHT

NEW RISER ACCESS DOOR - LOCATION TO BE CONFIRMED TO SUIT LOCATION OF NEW AND EXISTING SERVICES

NOTE:

FOR ALL CEILING FINISH REFERENCES REFER TO FINISHES SCHEDULE 3147-SCH04 AND NBS SPECIFICATIONS.

CONTRACTOR TO CHECK LIGHT SETTING OUT ON SITE TO CONFIRM ANY FURTHER WALL CLASHES PRIOR TO CONSTRUCTION.

REFER TO M&E CONSULTANT'S DRAWINGS AND SCHEDULES FOR ALL M&E LAYOUTS, SYMBOLS & LIGHTING REFERENCES. ALL LEVELS SHOWN NOMINAL AND TO BE CHECKED AGAINST EXISTING LEVELS ON SITE.

REFER TO COORDINATED REFLECTED CEILING PLAN FOR SETTING-OUT OF ALL CEILING-LEVEL ARCHITECTURAL, MECHANICAL, ELECTRICAL AND AV ITEMS.

NOTES

- ALL DIMENSIONS SHALL BE READ IN CONJUNCTION WITH LONG & PARTNERS DRAWINGS, SCHEDULES & SPECIFICATIONS.
- FOR DETAILS, ELEVATIONS & EXACT SETTING OUT OF WALL MOUNTED ACCESSORIES, REFER TO THE ARCHITECT'S LAYOUT.
- THE ELECTRICAL SERVICES WORKS SHALL BE CARRIED OUT IN ACCORDANCE WITH THE LONG & PARTNERS SPECIFICATION.

LEGEND

1000mm LINEAR RECESSED LED LUMINAIRE

1000mm LINEAR RECESSED LED LUMINAIRE

1000mm SUSPENDED LINEAR LED LUMINAIRE

LINEAR SURFACE MOUNTED LED LUMINAIRE

RECESSED CIRCULAR LED DOWNLIGHT

RECESSED CIRCULAR LED DOWNLIGHT

RECESSED CIRCULAR LED DOWNLIGHT

RECESSED CIRCULAR LED DOWNLIGHT

RECESSED CIRCULAR LED DOWNLIGHT

IP65 RATED WALL MOUNTED LUMINAIRE

SURFACE MOUNTED NON MAINTAINED EMERGENCY DOWNLIGHT

RECESSED CIRCULAR NON MAINTAINED EMERGENCY DOWNLIGHT

WALL MOUNTED NON MAINTAINED TWIN SPOTLIGHT EMERGENCY LUMINAIRE

MAINTAINED ILLUMINATED LED EMERGENCY EXIT SIGN C/P RUNNING WITH PICTOGRAM

IP65 RATED SURFACE MOUNTED LINEAR LED LUMINAIRE

PENDANT LUMINAIRE

LINEAR RECESSED LED LUMINAIRE

IP65 EXTERNAL WALL MOUNTED LUMINAIRE

IP65 EXTERNAL WALL MOUNTED LUMINAIRE

ABSENCE DETECTOR

RECESSED MOUNTED PRESENCE DETECTOR

SURFACE MOUNTED PRESENCE DETECTOR

COMBINED DAYLIGHT SENSOR/PRESENCE DETECTOR

WALL MOUNTED MICROPHONE

WALL MOUNTED MICROPHONE

PLUGGABLE DALI LIGHTING CONTROL MODULE

HARDWIRED DALI LIGHTING CONTROL MODULE

LIGHT SWITCH

RETRACTABLE LIGHT SWITCH (X) DENOTES NO. OF SWITCHES

DENOTES ITEM LOCATED WITHIN CEILING VOID

DENOTES WEATHERPROOF ITEMS

PLANNING ISSUE

B	MINOR AMENDMENTS TO SUIT COMMENTS	18.12.2019
A	APPLICATION FOR LISTED CONSENT	17.12.2019
Rev	Description	Date

Client

Job title

University College London
Institute of Education
Phase 2
20 Bedford Way, WC1H 0AL

Drawing title

Level 9
Reflected Ceiling Finishes

Scale

1:100 @ A1

Date

Dec 19

Drawn

CM

ARCHITON LLP

CHARTERED ARCHITECTS . DESIGN .
PLANNING CONSULTANTS . DEVELOPMENT .
BUILDING COST MANAGEMENT

REGENCY HOUSE
17 WEST STREET
EPSOM KT18 7RL

TEL:01372 745600
FAX:01372 745016
Email:info@architon.com

Drawing No

3147-P1-2904 B

ARCHITON LLP
certified to:
BS EN ISO 9001
BS EN ISO 14001
IIP Accreditation

