

 



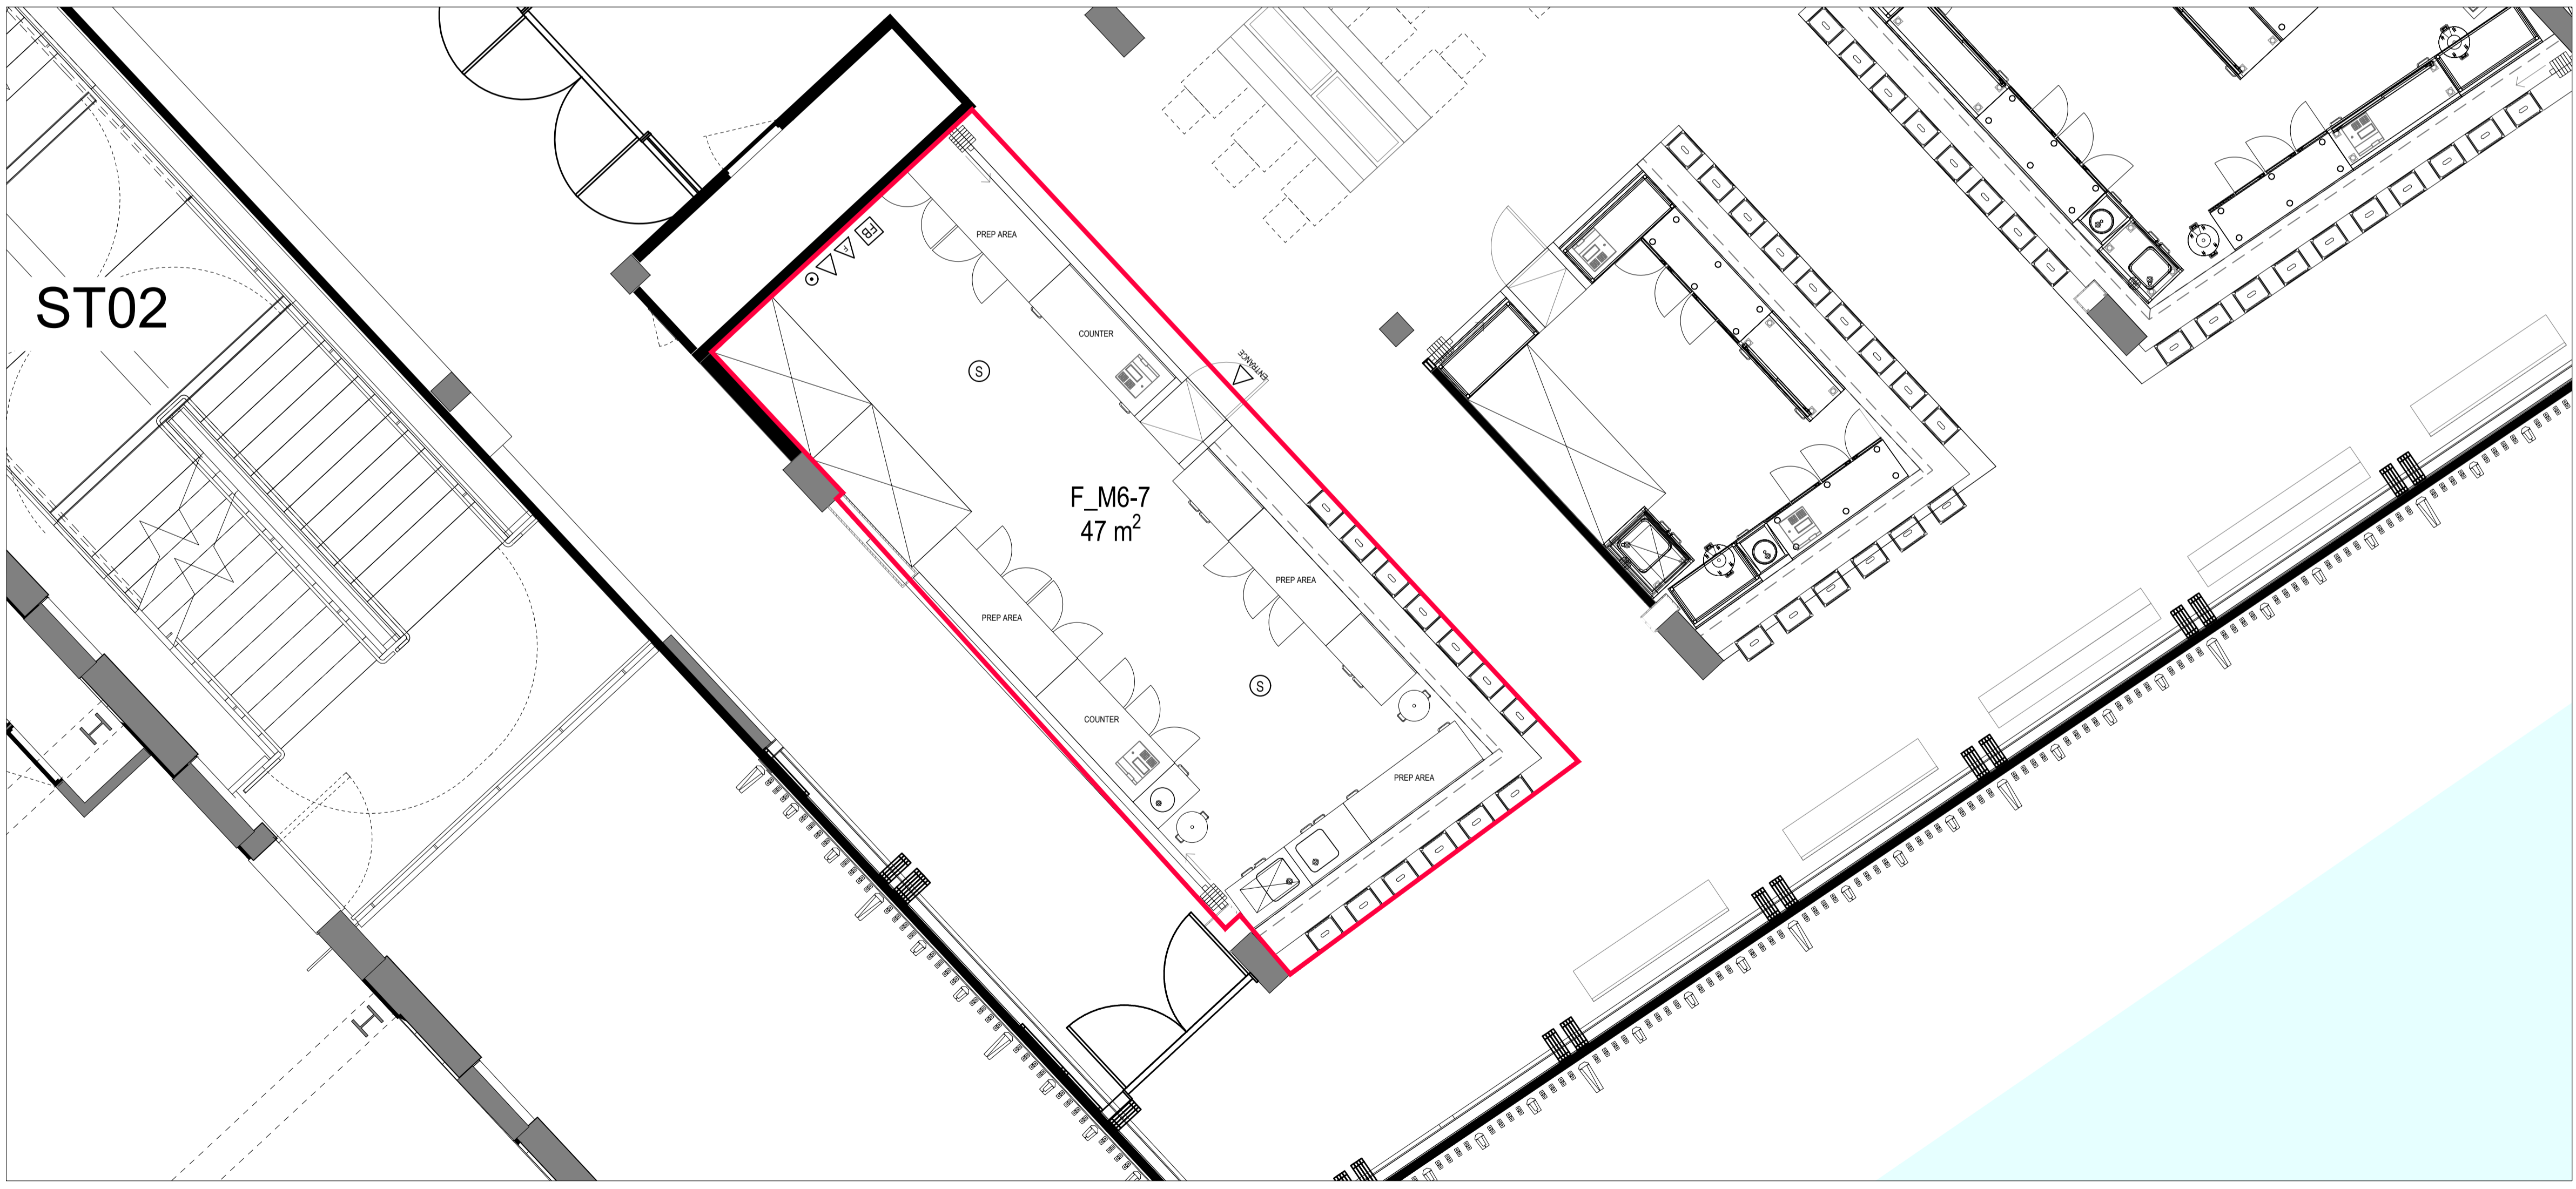


UPPER LOCK _ FIRST FLOOR PLAN
SCALE 1:500

FIRE EQUIPMENT IS INDICATIVE AND SUBJECT TO USE CONFIRMATION

- KEY**
-  FIRE EXTINGUISHER
 -  FIRE EXTINGUISHER FOAM
 -  CALL POINT
 -  FIRE BLANKET
 -  SMOKE DETECTOR
 -  HEAT RATE RISE DETECTOR
 -  8 WATT MAINTAINED LUMINAIRE
 -  NON MAINTAINED 8 WATT LUMINAIRE
 -  SOUNDER
 -  LICENSED PREMISES



L A B S

JOB	HAWLEY WHARF CAMDEN	
TITLE	F&B UNITS Unit F_M6-7, Upper Lock, Units 1-14, Water Lane, London, NW1 8JZ	
SCALE	1:50 @ A1 1:100 @ A3	DWG. NO. FB-F_M6-7