 



EXTERIOR CHAIRS & TABLES LAYOUT
COVERS 16 (CHAIRS 10 / CHAIRS WITH ARMS 6)
LOW TABLES 8



EXISTING
PHONE BOX TO BE REMOVED BY BT

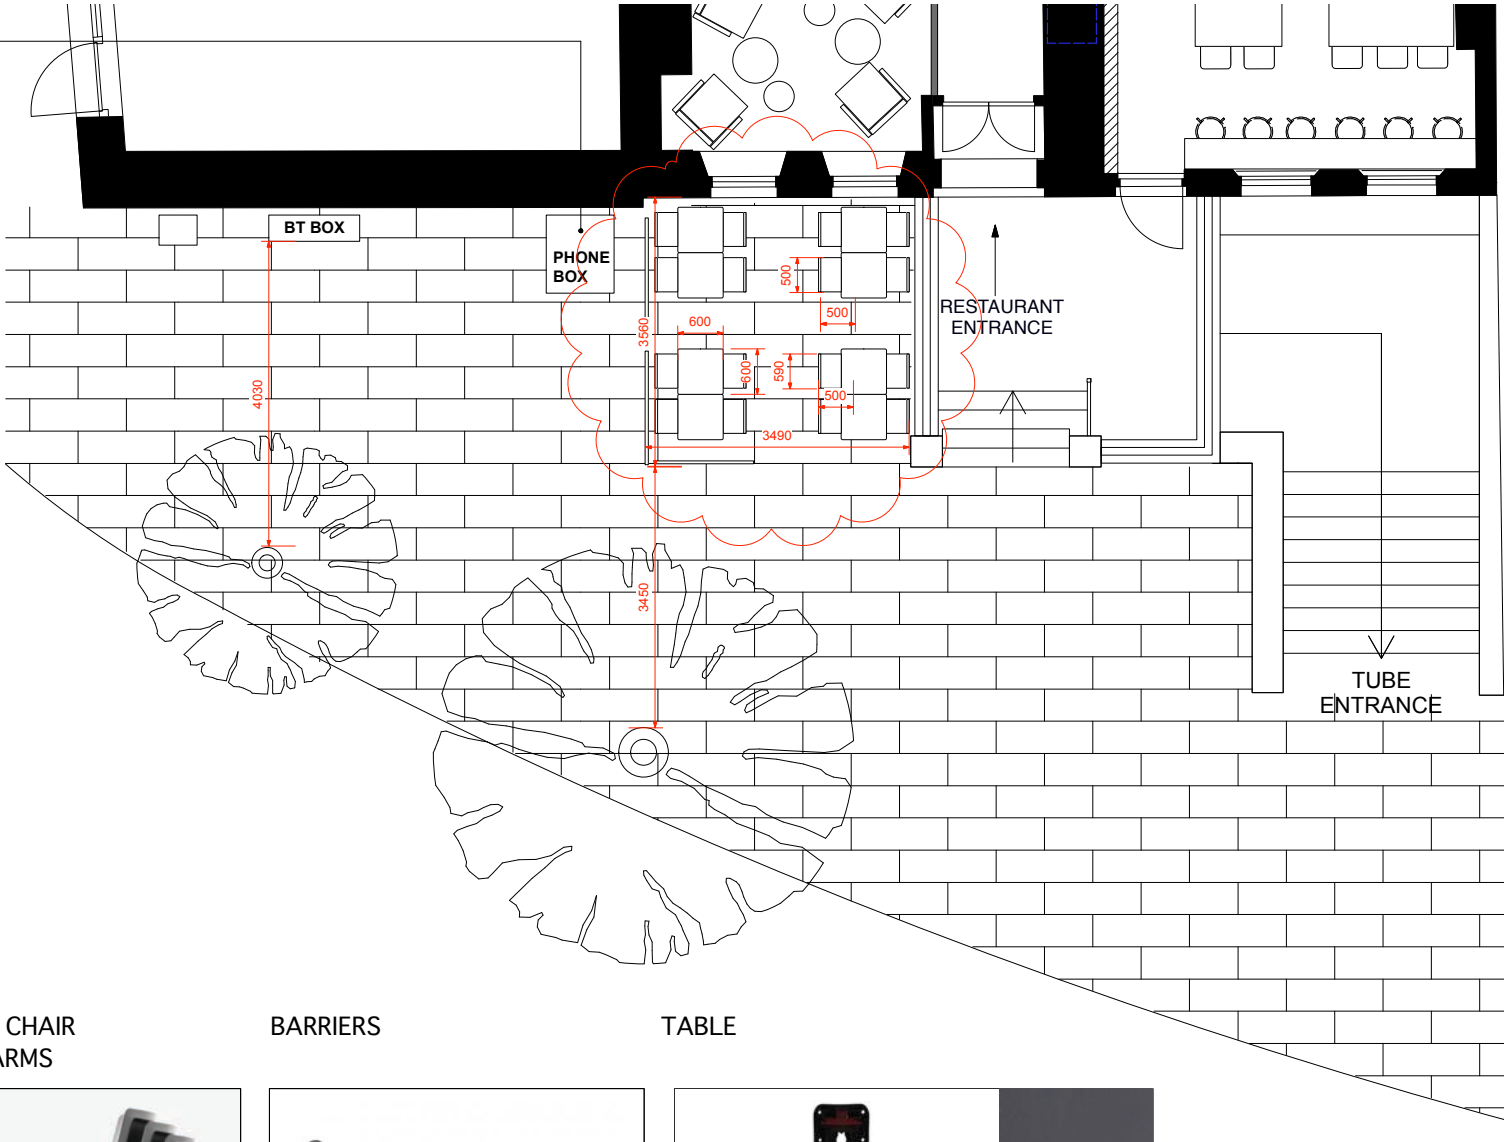

DINING CHAIR



DESCRIPTION: OUTSIDE DINING
CHAIR WITH ARMS
REF: KRISTALIA LP STACKABLE
CHAIR
FINISH: BLACK
SIZE: 500mm x 500mm

DINING CHAIR
WITH ARMS



DESCRIPTION: OUTSIDE DINING
CHAIR WITH ARMS
REF: KRISTALIA LP STACKABLE
CHAIR
FINISH: BLACK
SIZE: 590mm x 500mm

BARRIERS


 


DESCRIPTION: BARRIERS
FINISH: BLACK
SIZE: 1200mm x 860mm

TABLE



DESCRIPTION: OUTSIDE DINING
TABLE
TOP: BLACK
REF: STABLE TABLE FLIP TOP
FINISH: BLACK
SIZE: 600MM X 600MM

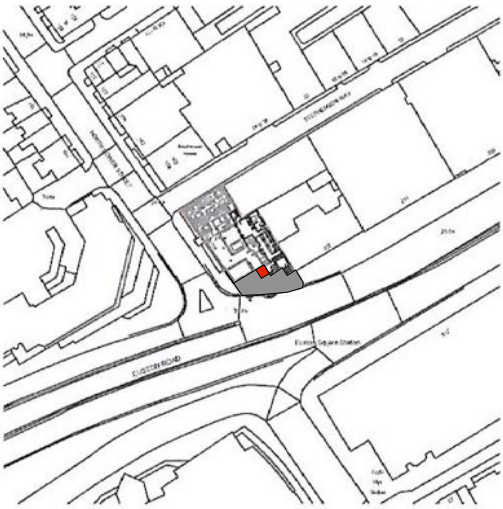

LOCATION PLAN

CONTRACTOR TO ALLOW FOR CONFORMING WITH THE FOLLOWING REGULATIONS AS NECESSARY				
WALL FINISHES TO BE CLASS 1 GENERALLY WITH CLASS 0 FINISHES TO CORRIDORS AND CIRCULATION AREAS				
CAVITY BARRIERS TO BE PROVIDED IN CEILING VOIDS AT MAXIMUM 20M CENTRES. EXCEPT WHEN THE CEILING VOID IS OVER A SINGLE ENCLOSED ROOM WHERE THEY WILL BE PROVIDED AT A MAXIMUM 40 M CENTRES				
LIGHTING DIFFUSERS (IF SPECIFIED) METAL LIGHTING DIFFUSERS WILL BE USED IN THE SUSPENDED CEILING SYSTEM				
CEILING FINISHES TO BE CLASS 0 GENERALLY THROUGHOUT INCLUDING CORRIDOR AND CIRCULATION AREAS				
SPRINKLERS TO BE PROVIDED IN ACCORDANCE WITH BRITISH STANDARD 5306 PART 2, HAZARD CLASS: ORDINARY HAZARD GROUP II				
FIRE ALARM TO BS5839 PART 1 : 1988. A TYPE 'M' BREAK GLASS FIRE ALARM SYSTEM WILL BE PROVIDED, DESIGNED AND INSTALLED IN ACCORDANCE WITH BRITISH STANDARD 5839 PART 1				
A SMOKE DETECTION SYSTEM WILL BE PROVIDED, DESIGNED AND INSTALLED IN ACCORDANCE WITH BRITISH STANDARD 5839 PART 1.				
FIRE EXTINGUISHERS INSTALLED TO BS5036 PART 3 1983 WATER TYPE FIRE EXTINGUISHERS WILL BE PROVIDED AT THE RATE OF ONE FOR EVERY 200M SQ OF FLOOR AREA. SPECIALIST EXTINGUISHER WILL BE PROVIDED TO SUIT THE INDIVIDUAL RISKS WHEN IDENTIFIED				
NOTICES TO BS5499 PART 1 1990 SUFFICIENT FIRE NOTICES WILL BE PROVIDED TO ENABLE THE OCCUPANTS OF THE BUILDING TO IDENTIFY ALL THE FIRE EXIT ROUTES NOT IN EVERYDAY USE.				
ALL FIRE RESISTING DOORS WILL BE PROVIDED WITH EITHER A FIRE DOOR KEEP SHUT NOTICE OR A FIRE DOOR KEEP LOCKED SHUT WHEN NOT IN USE				
3 HOUR NON - MAINTAINED EMERGENCY LIGHTING SYSTEM WILL BE PROVIDED DESIGNED AND INSTALLED IN ACCORDANCE WITH BRITISH STANDARDS266 PART 1				
STUD PARTITIONING LEGEND				
NEW STUD PARTITIONING CONSISTING OF 70MM STUDS AT MAXIMUM 600MM CENTRES FACING BOTH SIDES WITH ONE LAYER OF 12.5MM PLASTERBOARD SCRIMMED AND TAPED JOINTS TO RECEIVE DECORATION PROVIDING MINIMUM 1/2 HOUR FIRE RESISTANCE AND MINIMUM CLASS 1 SPREAD OF FLAME				
EXISTING WALLS/PARTITIONS				
DEMOLITION				
NOTES				
DESIGN INTENT DRAWING ONLY - BASED ON DIMENSIONS SUPPLIED.				
BUSBYWEBB RECOMMEND FULL MEASURED SURVEY BY CONTRACTOR PRIOR TO FINALISATION OF DETAIL DRAWINGS AND MANUFACTURING.				
CROSS REFERENCE WITH OTHER DRAWINGS & CHECK ALL DIMENSIONS.				
DO NOT SCALE FROM THIS DRAWING .				
ANY CHANGES ON SPECIFICATION TO BE AGREED WITH BUSBYWEBB				
ALL WORKS TO COMPLY WITH LOCAL AUTHORITY AND SITE REGULATIONS.				
COPYRIGHT BUSBYWEBB 2018				
REV	DATE	DESCRIPTION		
A	14.10.18	REVISED NOTES.		
DWG STATUS		Design Intent		
		3RD FLOOR 32 GREAT SUTTON STREET LONDON EC1V 0NB		
CLIENT		VQ		
PROJECT		VQ EUSTON SQUARE		
SITE ADDRESS		Euston Square Hotel, 152-156 North Gower Street, London. NW1 2LU		
TITLE		Pavement plan		
SCALE		1.50 @ A1		
DATE		01.10.18		
DRAWN BY		JC	CHECKED BY	JSC
DWG NO.		BW67_112	REVISION	A