


DO NOT SCALE FOR CONSTRUCTION PURPOSES.
 THE CONTRACTOR IS TO CHECK AND VERIFY ALL BUILDING AND SITE DIMENSIONS, LEVELS AND SEWER INVERT LEVELS AT CONNECTION POINTS BEFORE WORK STARTS.
 THIS DRAWING IS TO BE READ AND CHECKED IN CONJUNCTION WITH ENGINEERS AND OTHER SPECIALIST DRAWINGS.
 THE DRAWING AND THE WORKS DEPICTED ARE THE COPYRIGHT OF PHILIP MEADOWCROFT ARCHITECTS LTD AND MAY NOT BE REPRODUCED EXCEPT BY WRITTEN PERMISSION.

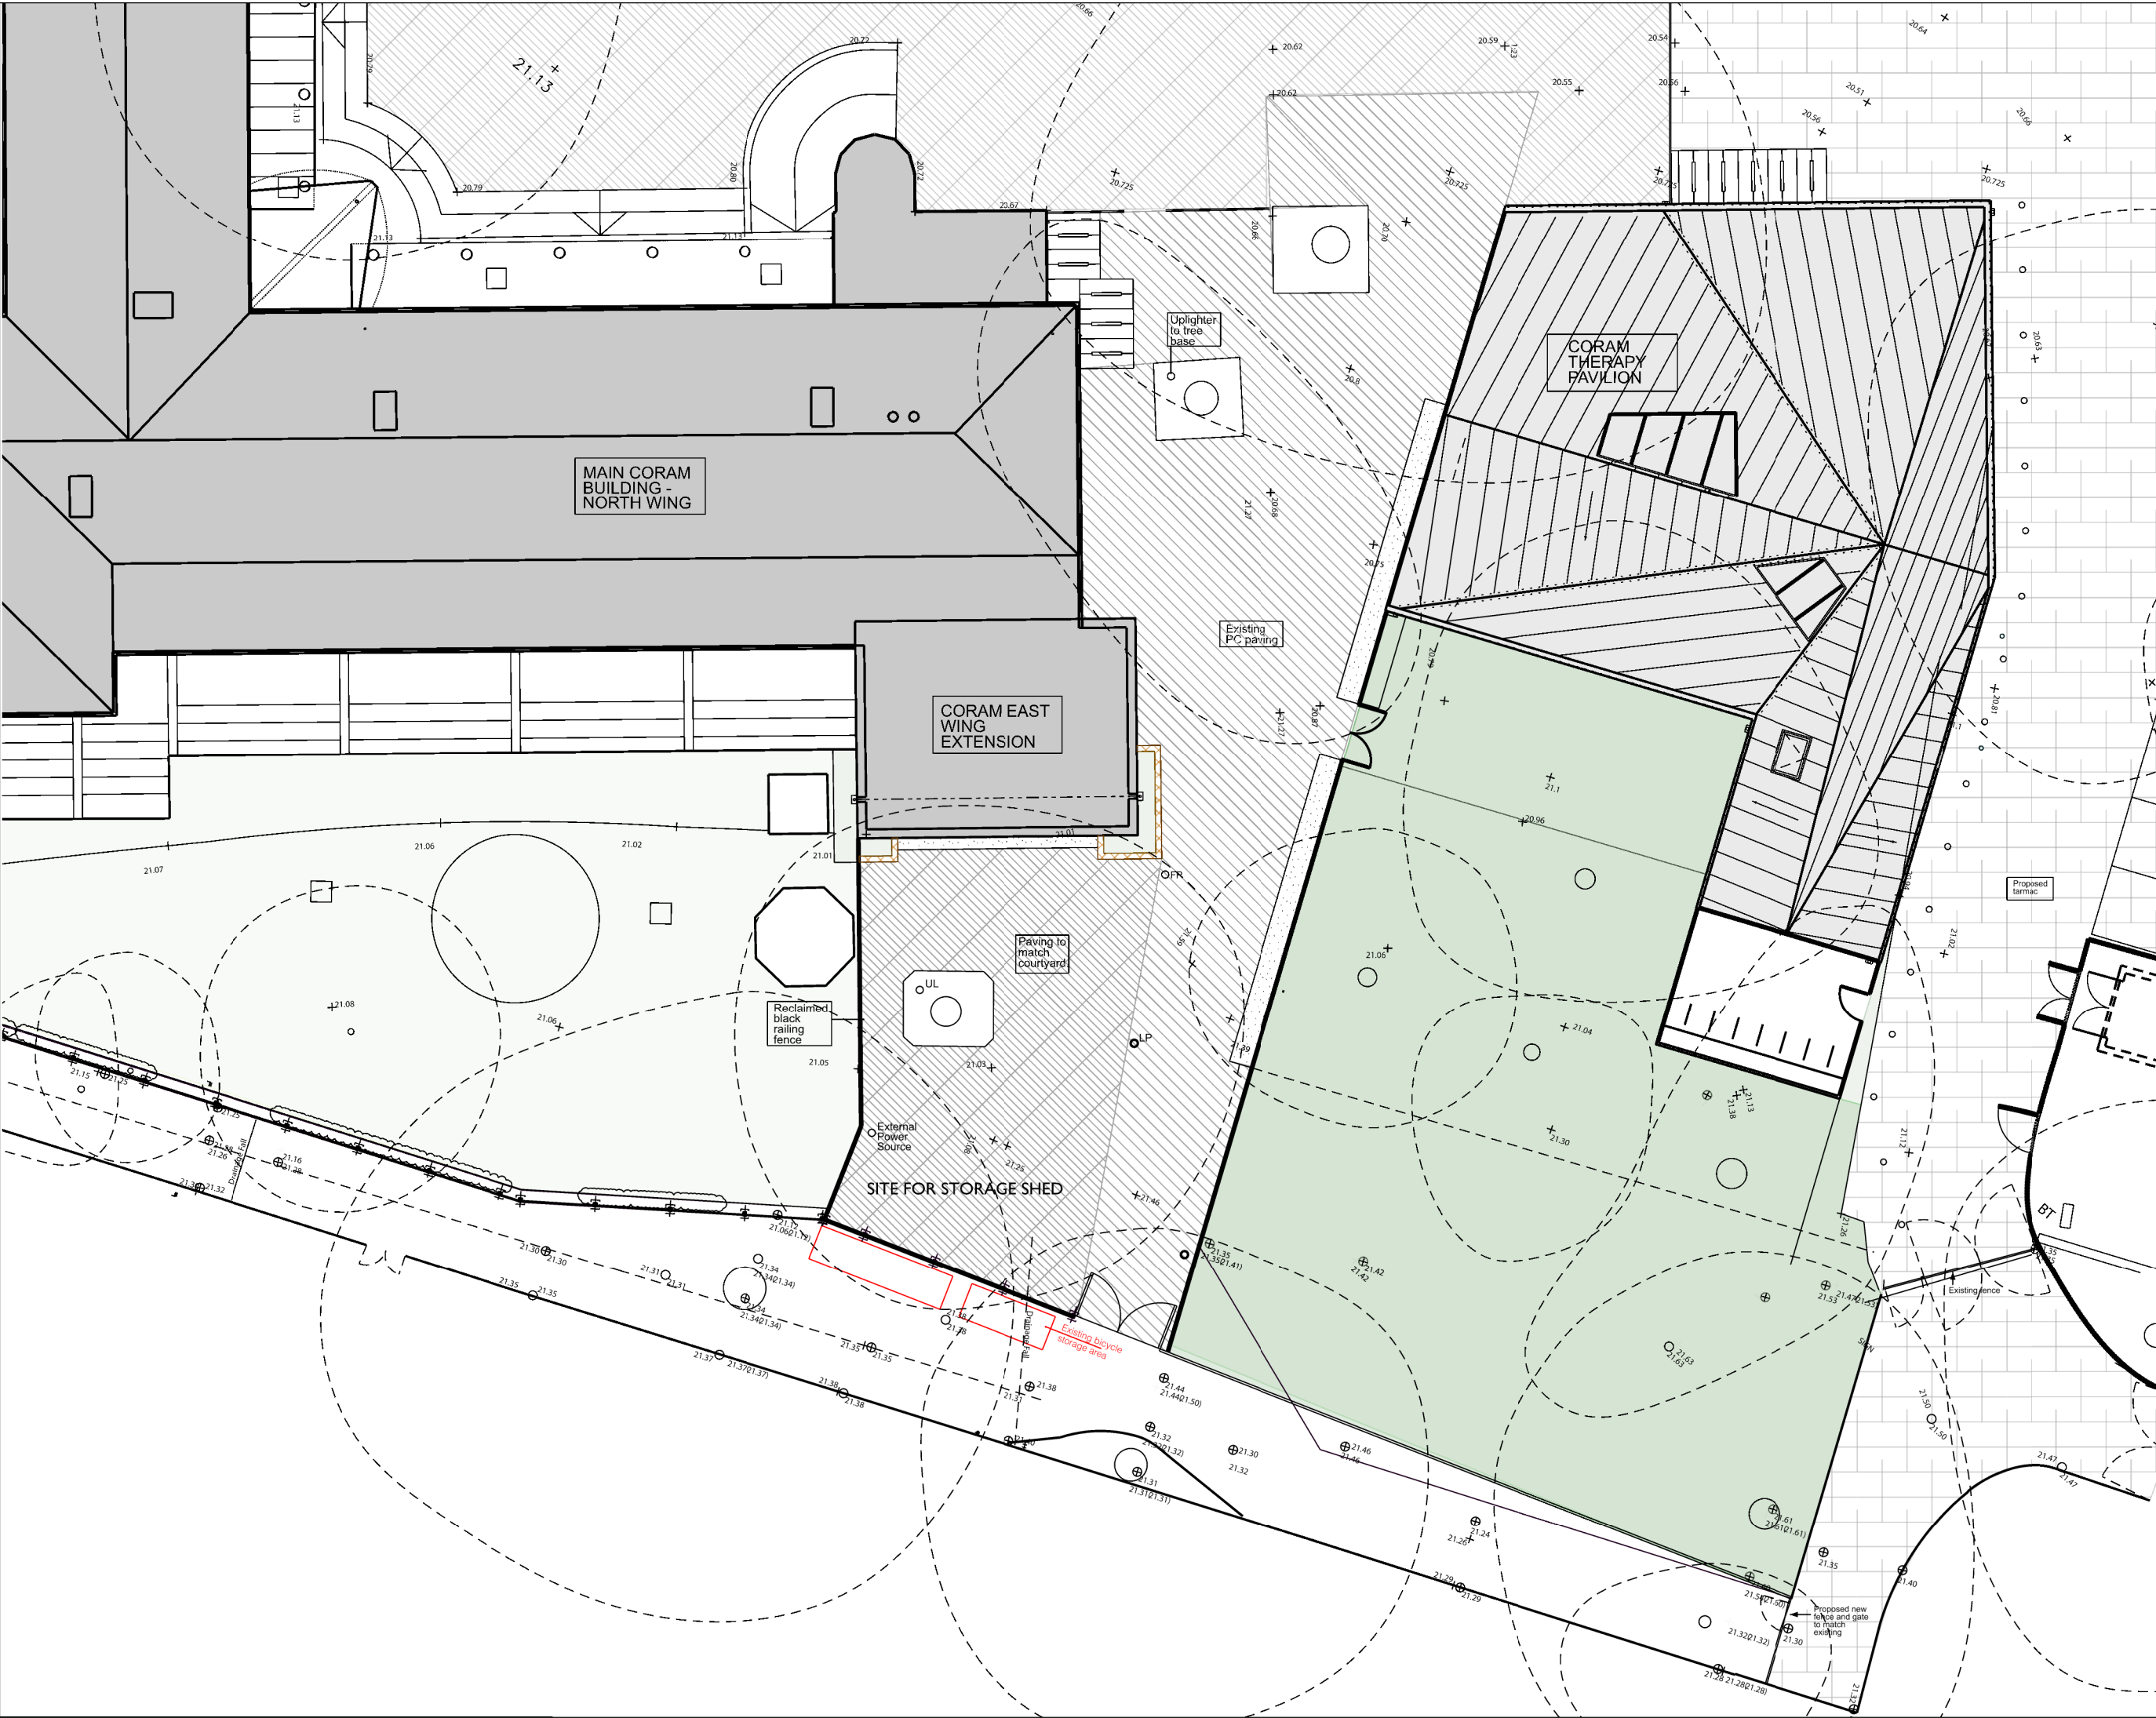

NORTH
 SCALE BAR IN METERS

- LP: Light Post
- FP: Finger Post
- UL: Uplights

REV	DATE	DESCRIPTION

PHILIP MEADOWCROFT ARCHITECTS
 33 GREENWOOD PLACE
 LONDON, NW5 1LB
 +44 (0)207 693 8514
 www.philipmeadowcroftarchitects.co.uk

JOB
Coram East Wing STORAGE SHED

DRG
Existing Site Plan

SCALE
 1:100 @ A1
 1:200 @ A3

DATE
 13/01/2020

DRAWN BY
 DR

CHECKED BY
 PM

STATUS
PLANNING

DRG NO
1804-152

REV
 -