




CONDENSER SCHEDULE - OUTDOOR UNITS									
UNIT No.	TYPE	FLOOR SERVING	COOLING (kW)	HEATING (kW)	WEIGHT (kg)	UNIT SIZE (HxWxD)	NOISE LEVELS (dBA) NOM	RUNNING CURRENT (A)	FUSE RATING (A)
CONDENSER 1	REYQ12T	GROUND	33.5	33.5	218	1685x930x765	81	15.3	25.0
CONDENSER 2	REYQ14T	GROUND	40.0	40.0	304	1685x930x765	81	17.4	32.0
CONDENSER 3	REYQ12T	BASEMENT	33.5	33.5	218	1685x930x765	81	15.3	25.0
CONDENSER 4	REYQ16T	BASEMENT	45.0	45.0	305	1685x930x765	86	21.1	40.0
CONDENSER 5	RXYSCQ4TMV1B	BASEMENT	12.1	12.1	89	823x940x460	68	19.0	32.0

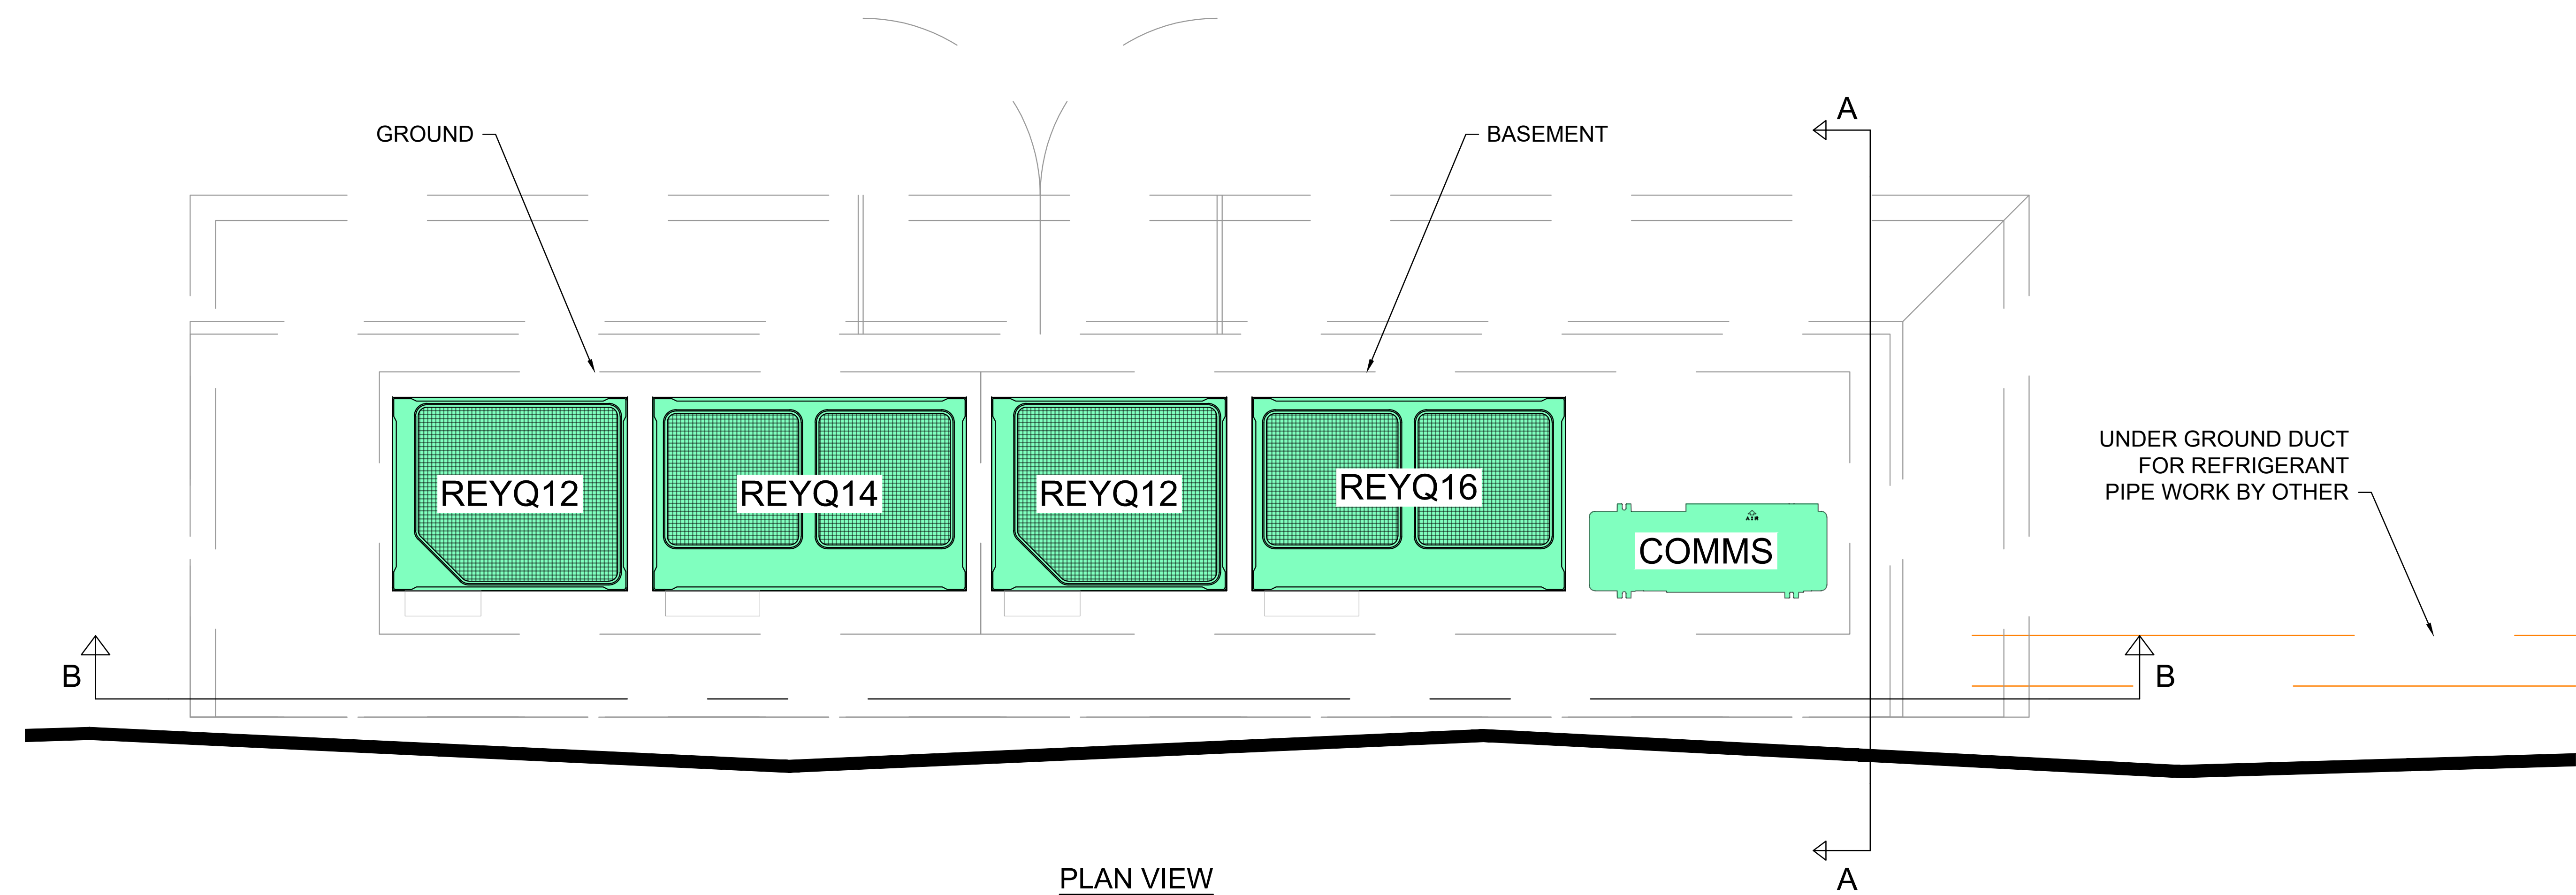

PLAN VIEW

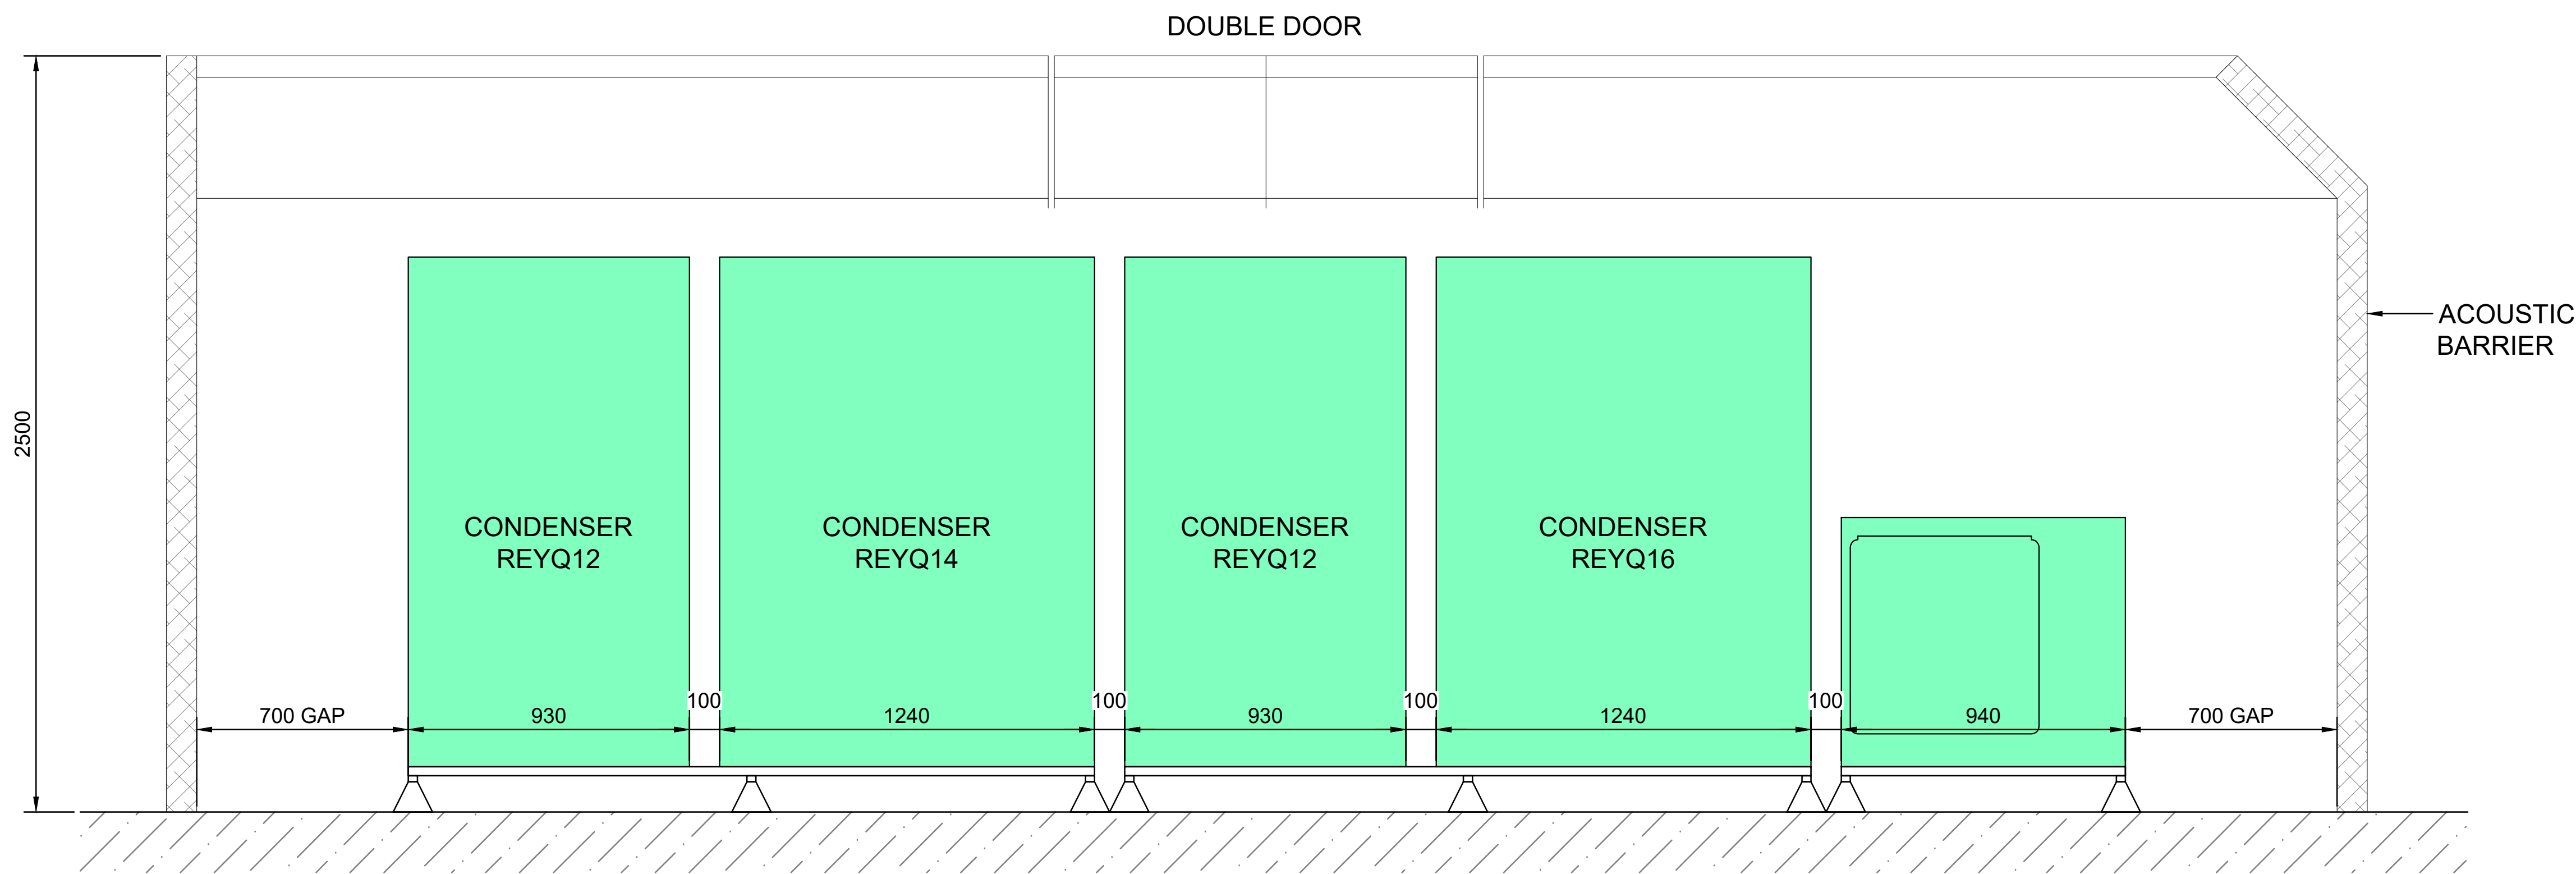

CONDENSER ELEVATION B-B

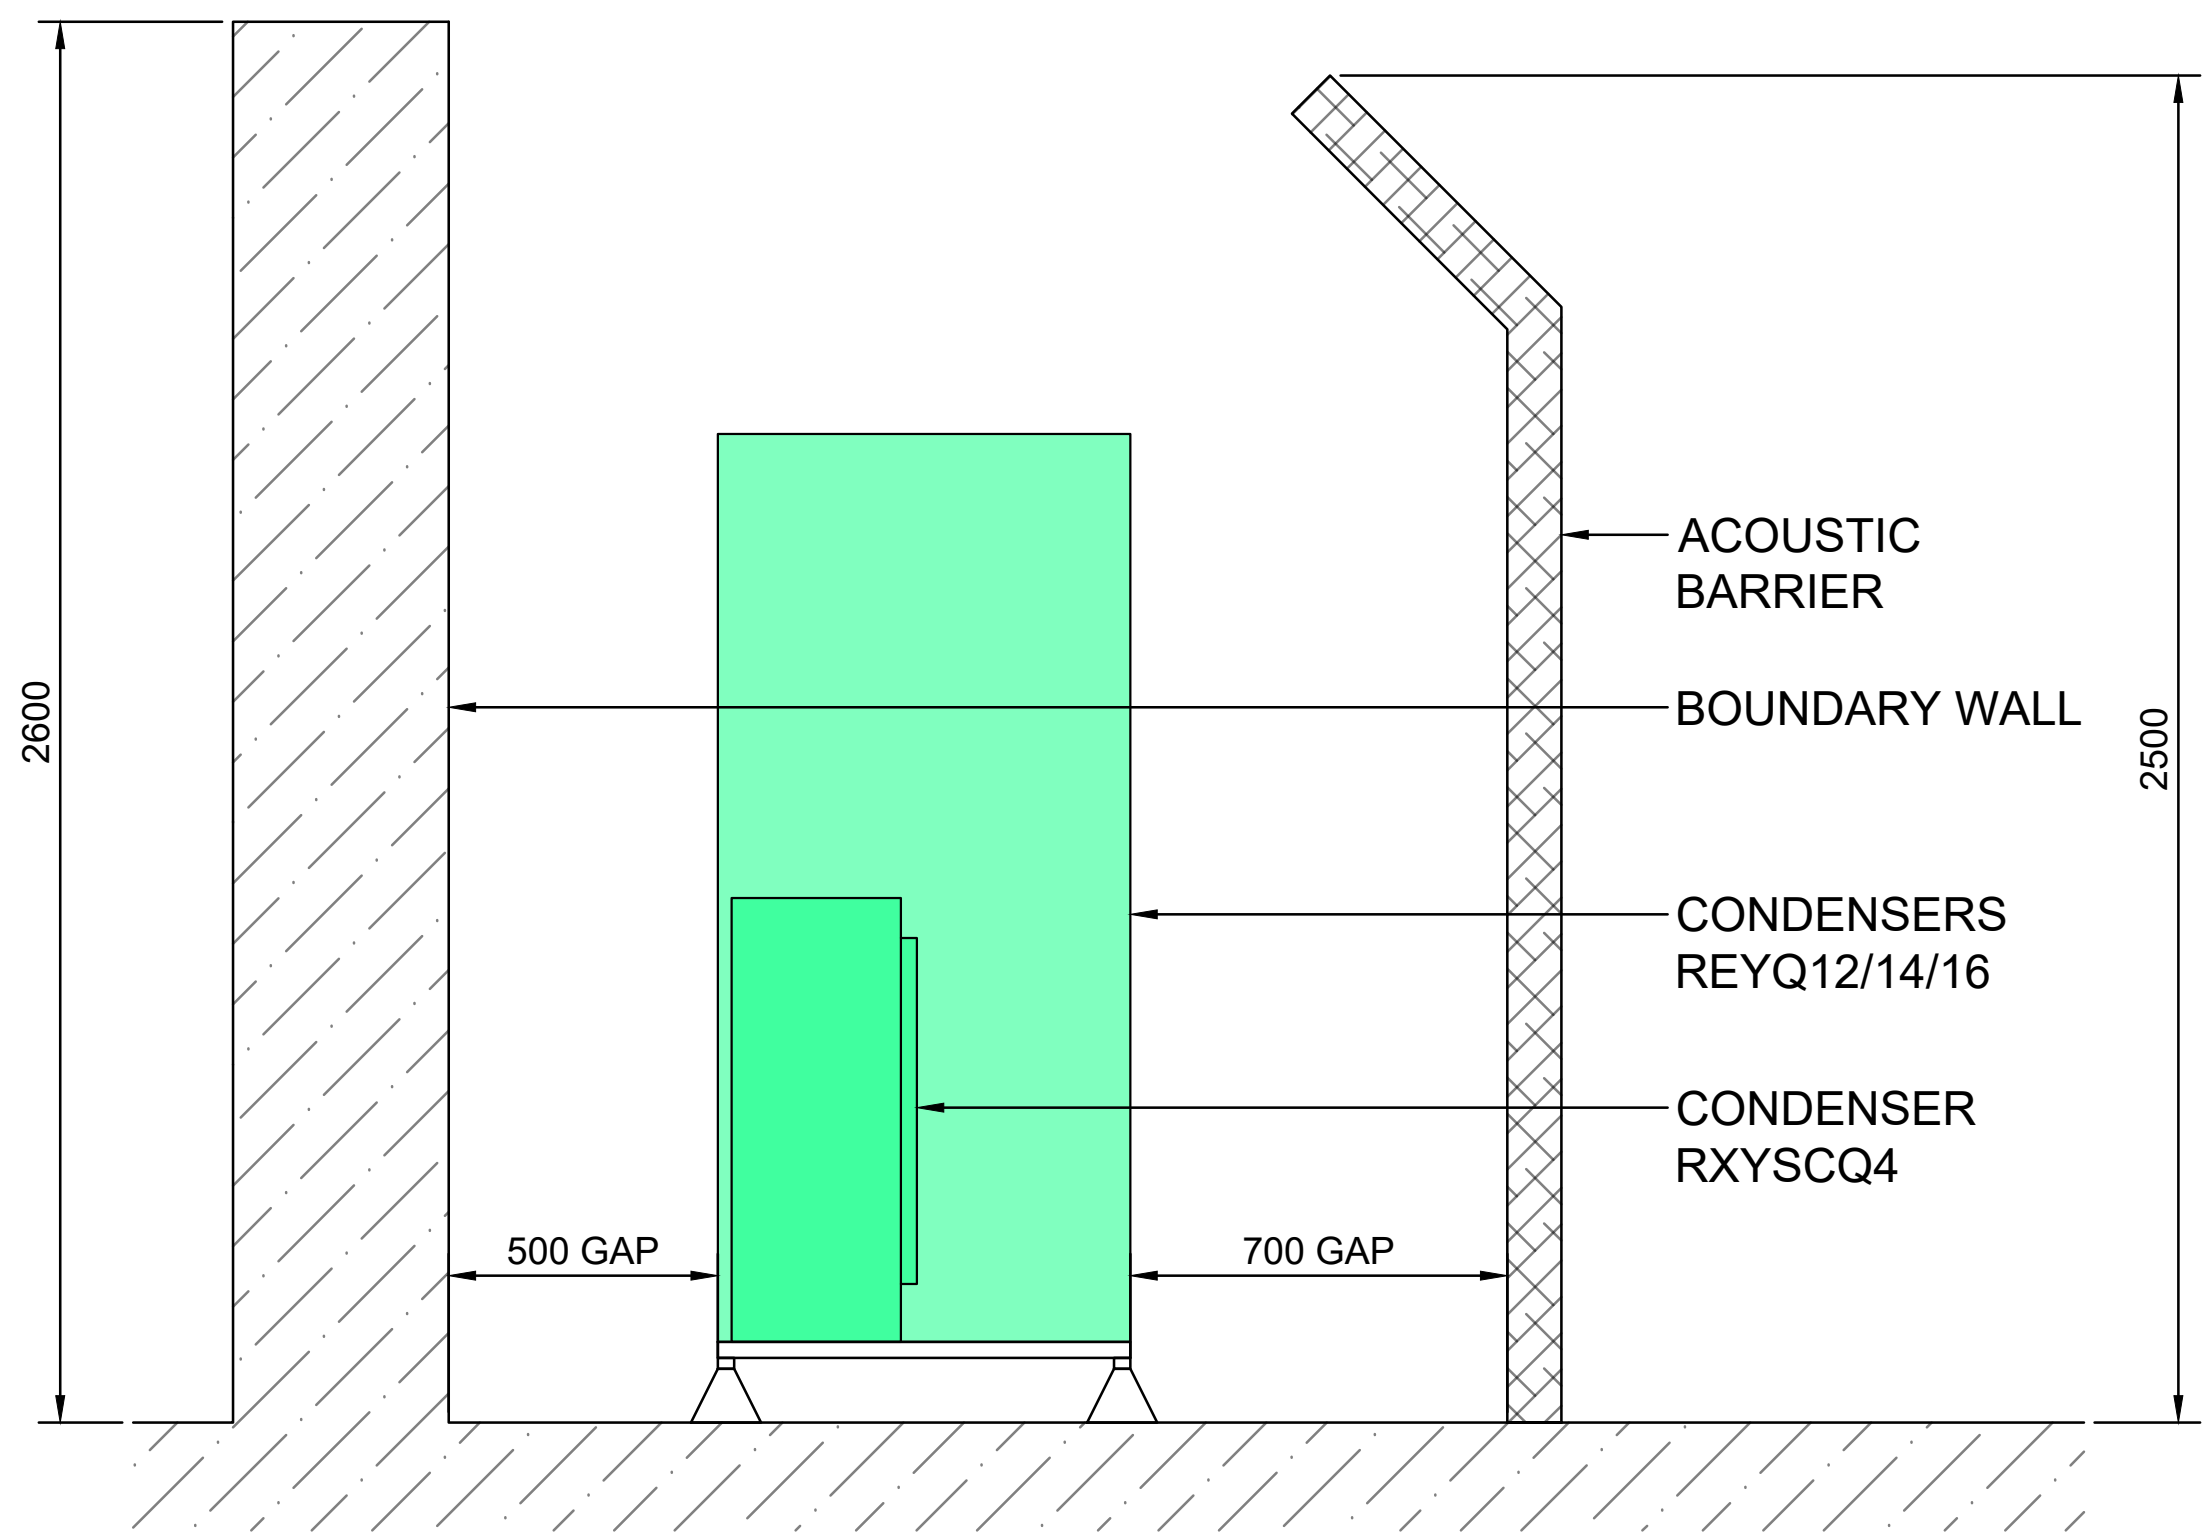

CONDENSER ELEVATION A-A

HVAC LEGEND

- VAM UNIT - HEAT EXCHANGER
- DUCTED FAN COIL UNIT
- CASSETTE TYPE FCU
- WALL MOUNTED FCU
- CONDENSER UNIT
- EXTRACTION FAN
- DUCT WORK (SUPPLY)
- DUCT WORK (EXTRACT)
- CROSS TALK ATTENUATORS
- REMOTE CONTROLLERS
- REFRIGERANT (FLOW & RETURN)
- CONDENSATE

MECHANICAL LEGEND

- EXISTING
- REMOVE
- INSTALL / RE-INSTALL

PUBLIC HEALTH LEGEND

- CWS - COLD WATER SUPPLY
- HWS - HOT WATER SUPPLY
- WASTE WATER

B	CONDENSER ELEVATION UPDATED	09.01.2020
A	ISSUED FOR APPROVAL	07.01.2020

Rev.	Description	Date
------	-------------	------

Drawing Status:
ISSUED FOR APPROVAL

Unit 2, Apsley House,
Apsley Road, New Malden,
Surrey, KT3 3NJ
Tel:- 020 8605 1370 Fax:- 0208 605 1375
Email: info@atmosair.co.uk

Air Conditioning Heating, Plumbing,
Design, Installation and Maintenance

Client:

Project:

425 CENTRIC CLOSE
CAMDEN
NW1 7EP

Title:

BASEMENT & GROUND FLOOR
MECHANICAL SERVICES
CONDENSER DETAILS

Drawn	DPM	Chd	CP	Date	07.01.2020
Cad File:	QAL5496-57-M02			Scale:	1:20 @ A1
Drawing Number	QAL5496-57-M02			Revision	B