


LEGEND	
	WC AREA
	FRIDGES
	AMBIT OF LICENSED PREMISES
	SAFETY LIGHTS
	SMOKE DETECTOR
	FIRE ESCAPE KEEP CLEAR
	INTERNALLY ILLUMINATED FIRE ESCAPE SIGN (BS 5266)
	CARBON DIOXIDE FIRE EXTINGUISHER
	9 LT. WATER FIRE EXTINGUISHER
	FAN



1. ESP refer to technical sheet
2. CARBON FILTER refer to technical sheet
3. SILENCER refer to technical sheet
4. FAN DETAILS refer to technical sheet

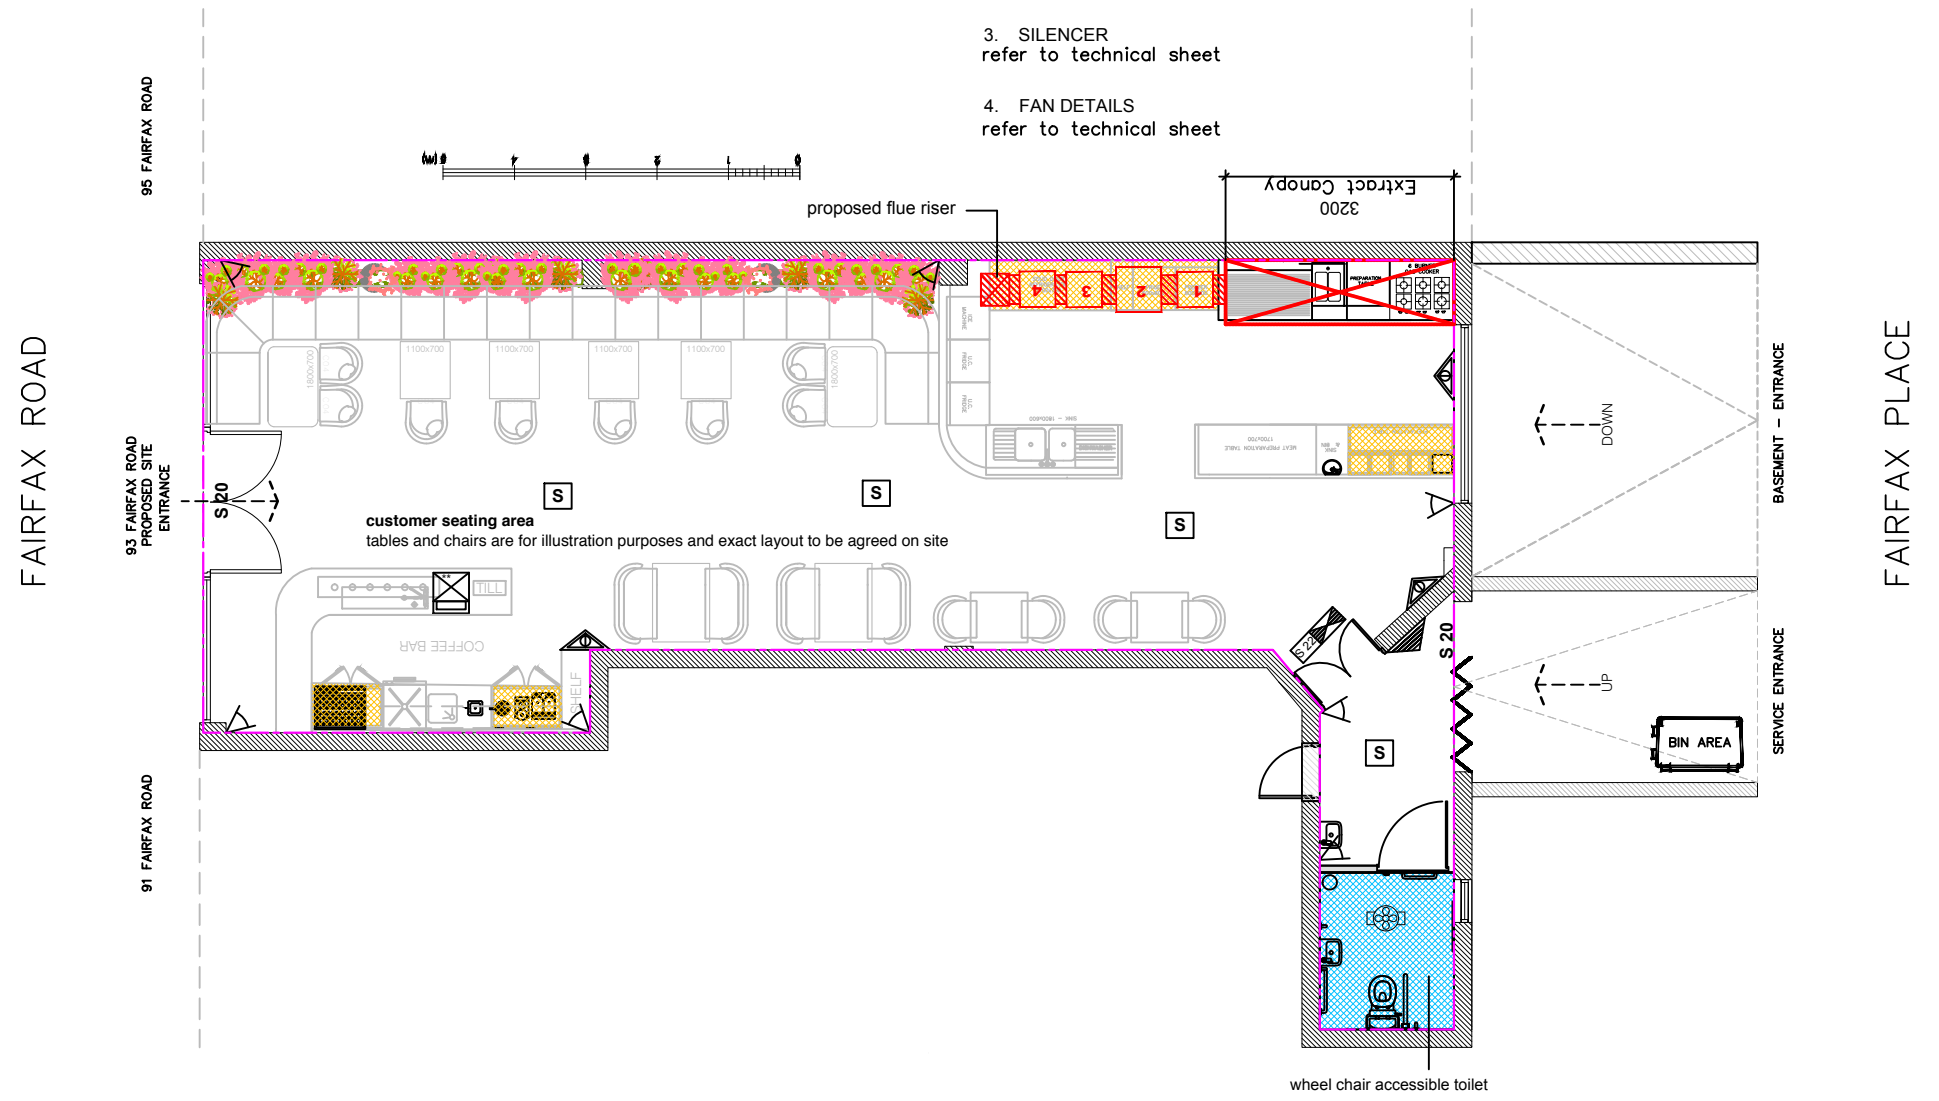

**EXTRACT CANOPY**  
 S/S (304 grade) canopy above cooking units with removable and washable grease filters 495x495x50mm. (FILTERS MUST BE WASHED 2 - 3 TIMES A WEEK).

**02 PROPOSED FLOOR PLAN**  
 Scale: 1:100 @ A3

<b>PARALLAX</b> Tottenham Green Enterprise Centre Town Hall Approach Road London   N15 4RX  Tel: 07848 1949 73 Email: hello@parallaxgroup.co.uk <small>All materials copyright to Parallax Design Ltd. Not to be reproduced or circulated without prior consent. Do not scale from the drawing.</small>	Drawing Status	Rev	Date	Description	Drawing Ref:		Scale	Date
	Layout Plan	001	14/01	LAYOUT DRAWING	PROPOSED GF PLAN		1:200 @ A1	15/01/29
	Drawing Title				Total Area		Section No.	Drawing No.
	93 Fairfax Rd London NW6 4DY				97sqm			93FFR002
					Drawn by	Checked by		
				ABD	ABD			