


LEGEND	
	WC AREA
	FRIDGES
	AMBIT OF LICENSED PREMISES
	SAFETY LIGHTS
	SMOKE DETECTOR
	CCTV
	FIRE ESCAPE KEEP CLEAR
	INTERNALLY ILLUMINATED FIRE ESCAPE SIGN (BS 5266)
	CARBON DIOXIDE FIRE EXTINGUISHER
	9 LT. WATER FIRE EXTINGUISHER
	FAN



1. ESP refer to technical sheet
2. CARBON FILTER refer to technical sheet
3. SILENCER refer to technical sheet
4. FAN DETAILS refer to technical sheet

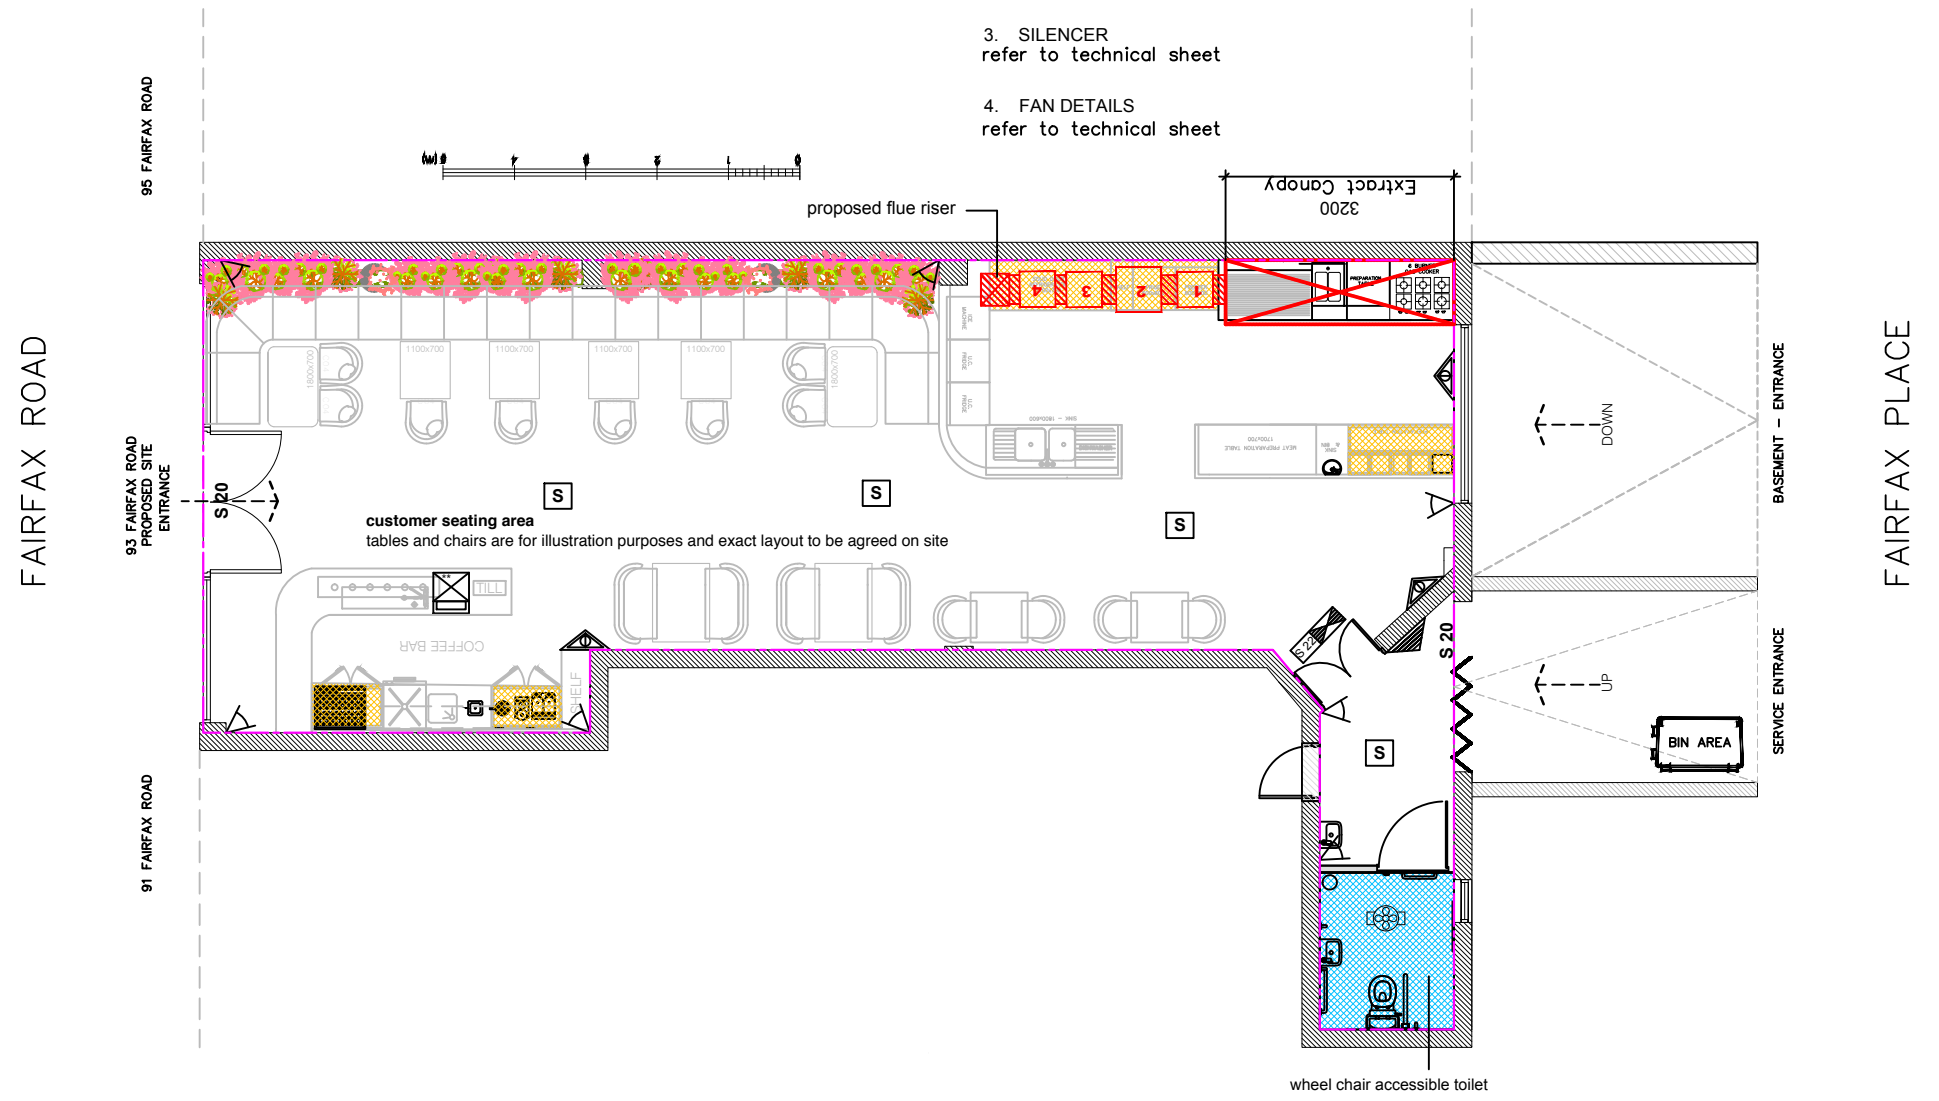

EXTRACT CANOPY
 S/S (304 grade) canopy above cooking units with removable and washable grease filters 495x495x50mm. (FILTERS MUST BE WASHED 2 - 3 TIMES A WEEK).

02 PROPOSED FLOOR PLAN
 Scale: 1:100 @ A3

PARALLAX Tottenham Green Enterprise Centre Town Hall Approach Road London N15 4RX Tel: 07848 1949 73 Email: hello@parallaxgroup.co.uk <small>All materials copyright to Parallax Design Ltd. Not to be reproduced or circulated without prior consent. Do not scale from the drawing.</small>	Drawing Status	Rev	Date	Description	Drawing Ref:		Scale	Date
	Layout Plan	001	14/01	LAYOUT DRAWING	PROPOSED GF PLAN		1:100 @ A1	15/01/29
	Drawing Title				Total Area		Section No.	Drawing No.
	93 Fairfax Rd London NW6 4DY				97sqm			93FFR001
					Drawn by	Checked by		
				ABD	ABD			