

This drawing has been produced based on the following drawings		
Source	Drawing Number	Rev
Saunders Boston Architects	PS01001-SBA-XX-61-DR-4-0021_RevC1_GA Plans_Basement	C1
Saunders Boston Architects	PS01001-SBA-XX-00-DR-4-0024_RevC1_GA Plans_Ground	C1
Saunders Boston Architects	PS01001-SBA-XX-ZZ-DR-4-0025_RevC1_GA Plans_First & Second	C1
Saunders Boston Architects	PS01001-SBA-XX-ZZ-DR-4-0026_RevC1_GA Plans_Third & Roof	C1






Indicates A Residual Risk As A Warning



The design team have highlighted unusual and significant risks that may not be obvious to a competent contractor. They are to assist with risk reduction only and are not necessarily comprehensive. It is assumed that all works will be carried out by a competent contractor working, where appropriate, to an approved method statement.

FIRE ALARMS

- SMOKE DETECTOR
- SMOKE DETECTOR WITH SOUNDER
- SMOKE DETECTOR WITH SOUNDER AND BEACON
- HEAT DETECTOR
- HEAT DETECTOR WITH SOUNDER
- HEAT DETECTOR WITH SOUNDER & BEACON
- MULTI-FUNCTIONAL DETECTOR
- MULTI-FUNCTIONAL DETECTOR WITH SOUNDER
- MULTI-FUNCTIONAL DETECTOR WITH SOUNDER & BEACON
- MANUAL CALL POINT
- WALL MOUNTED FIRE BEACON
- FIRE ALARM PANEL
- FIRE ALARM REPEATER PANEL
- FIRE ALARM INTERFACE

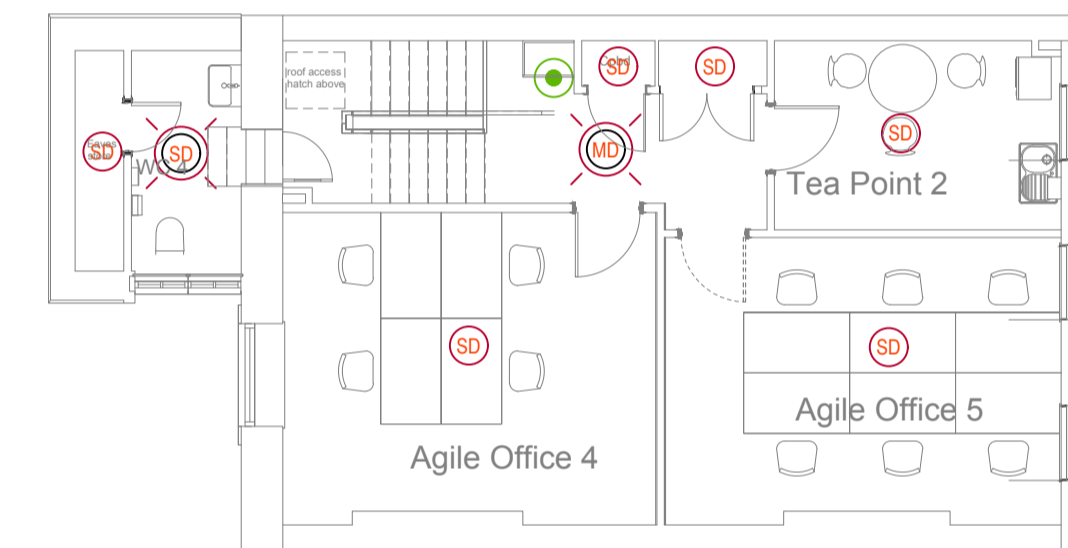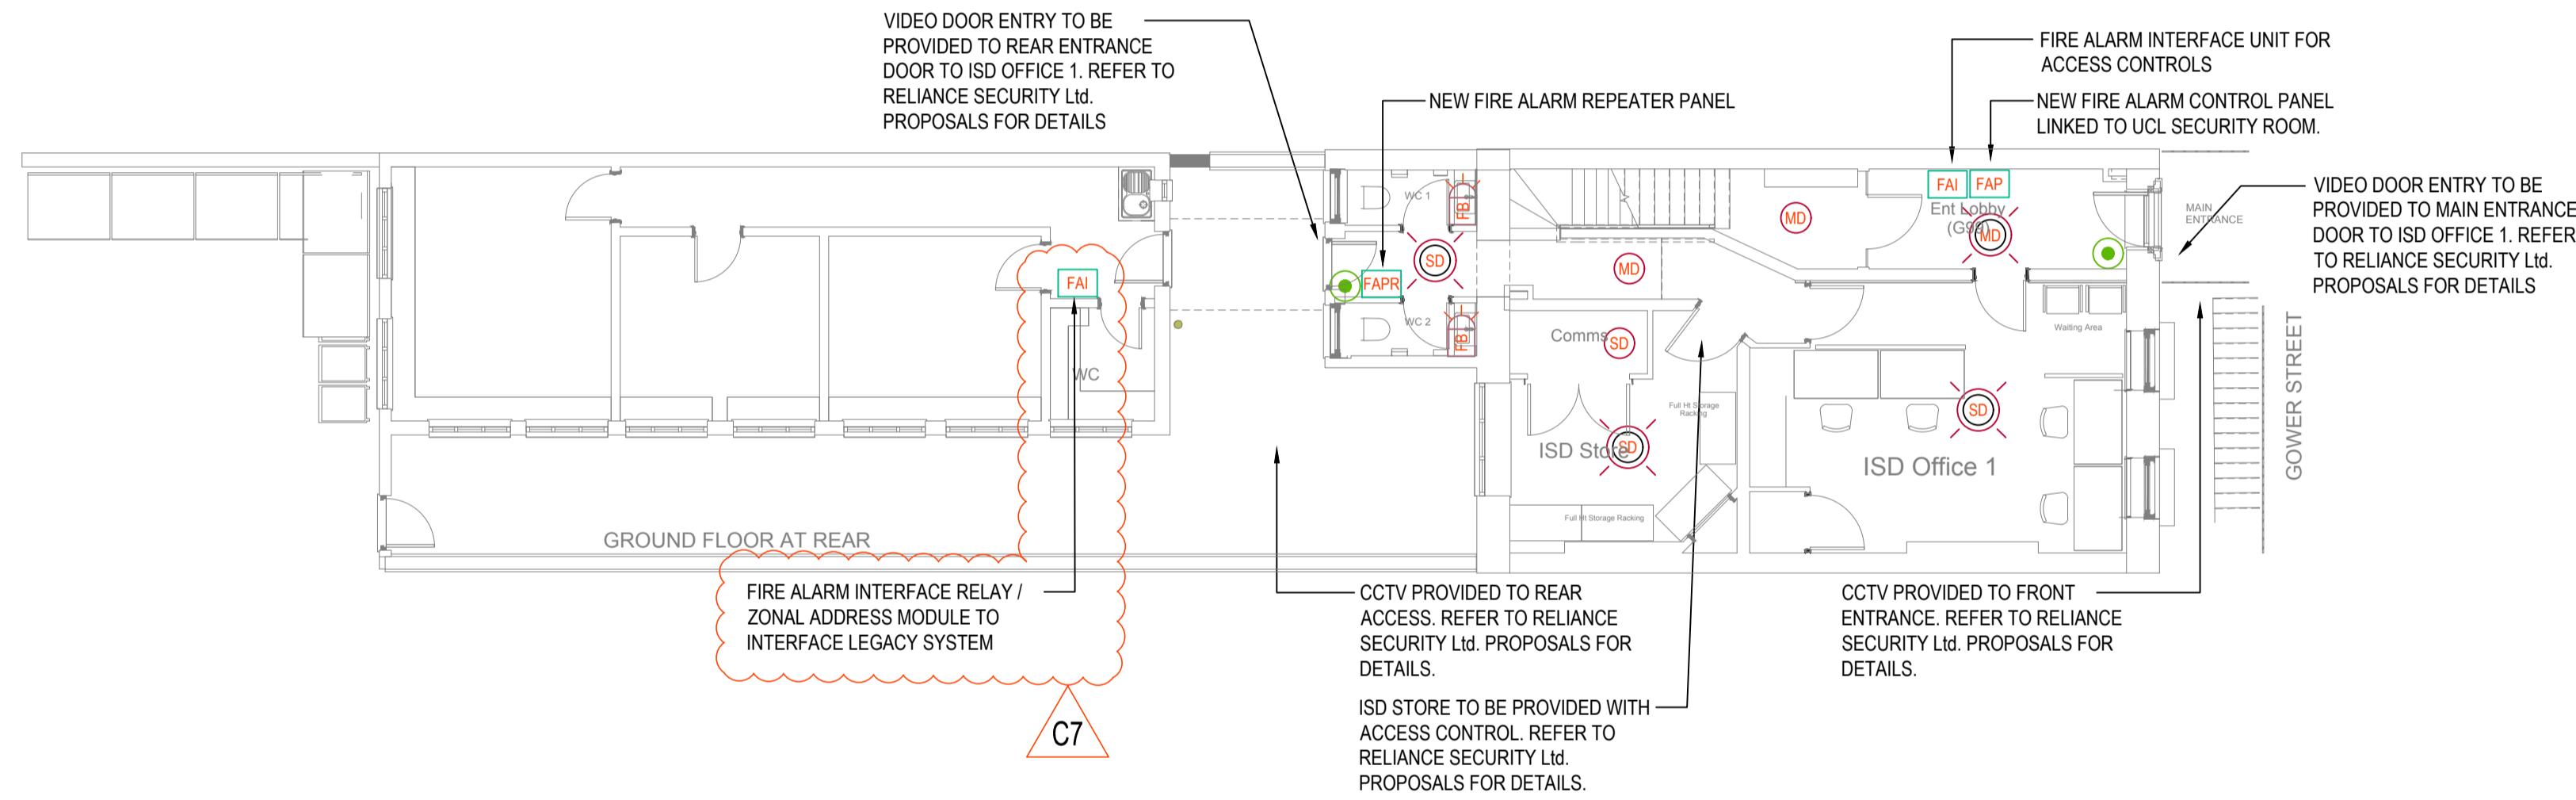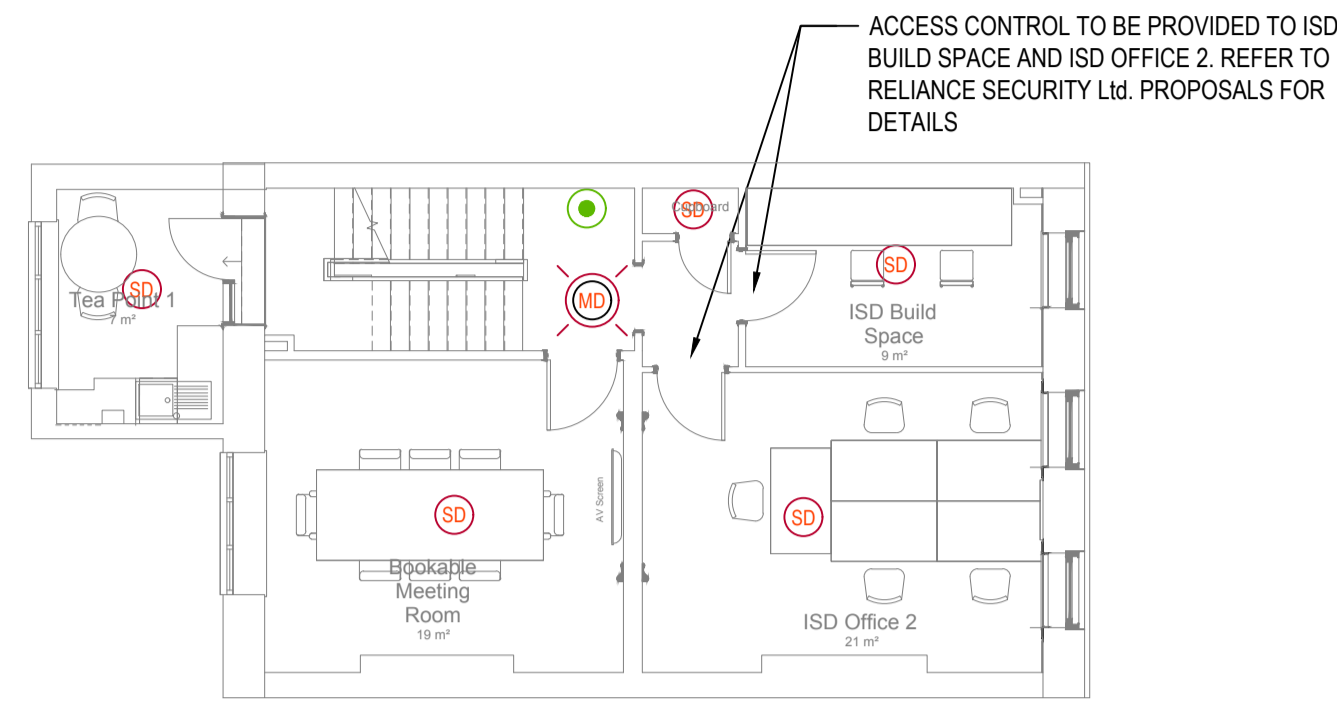

rev.	description	drawn	chkd.	date
C7	Mods As Shown	NB	GD	21-11-19
C6	BGJ's relocated, detection removed from vaults	AB	GD	18-11-19
C5	Detection added to cupboard	AB	GD	12-11-19
C4	Updated to Fix Comments	AB	GD	25-10-19
C3	Updated to Fire Strategy	NB	GD	21-10-19
C2	Construction Issue	NB	GD	04-09-19
C1	Construction Issue	JB	GD	19-08-19

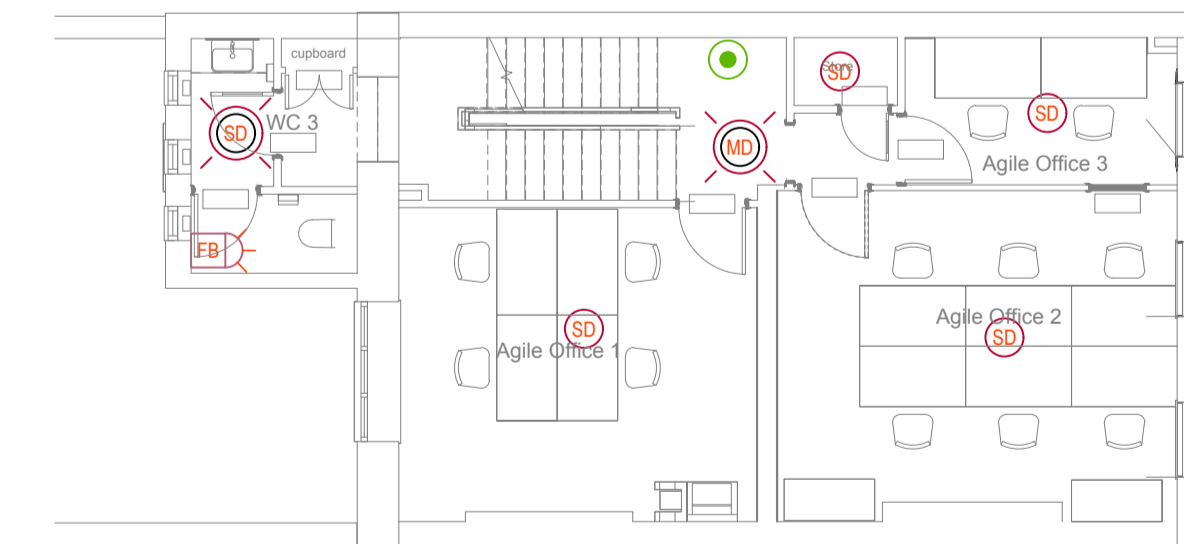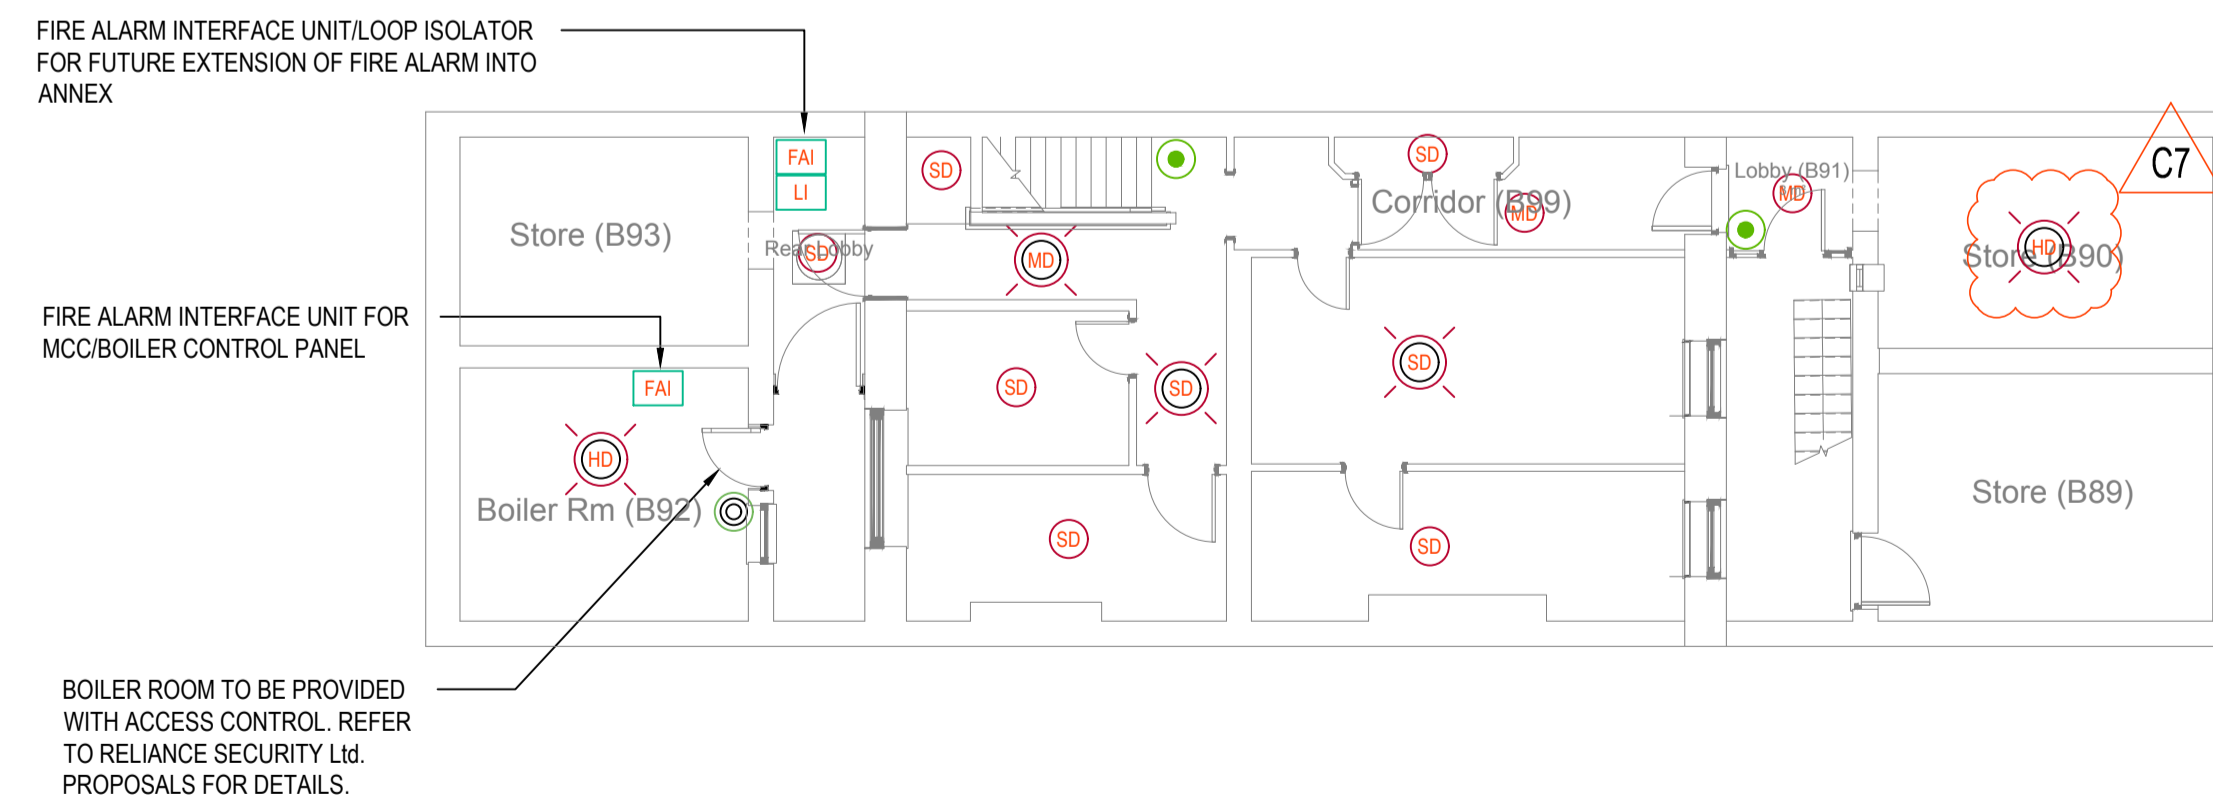

Carmel (UK) Limited
 Midland House, Midland Place, Barborough, Chesterfield, Derbyshire, S43 4FR
 Unit A, Benthem House, 1 Benthem Road, Epsom, Surrey, KT19 9BE
 Tel: +44 (0) 1246 575 600
 Fax: +44 (0) 1246 575 501
 e-mail: chesterfield@carmel-uk.com
 e-mail: epsom@carmel-uk.com

Client
University College London

 
Address
91 Gower Street

Title
Fire Alarm Systems All Floors Stage 4

Drawing No.
6000 - DRG - ZZZ - ZZ - DR - E - 6700

Project No. 1790 Scale 1:100@A1 Revision C7

Final Check For Issue (uncontrolled copy unless signed) Initials Signature Date



CONSTRUCTION

COPYRIGHT: This drawing is copyright and may not be altered, reproduced or used other than for the Contract Works for which it is issued without the written permission of CARMEL (UK) Ltd. WARNING: Do not trade this drawing. Verify all dimensions and structural details on site. For more information contact: info@carmel-uk.com