



Section A
Mechanical Plant Room: Hot Water Cylinders, Secondary Pumps and Ground Source Heat Pumps

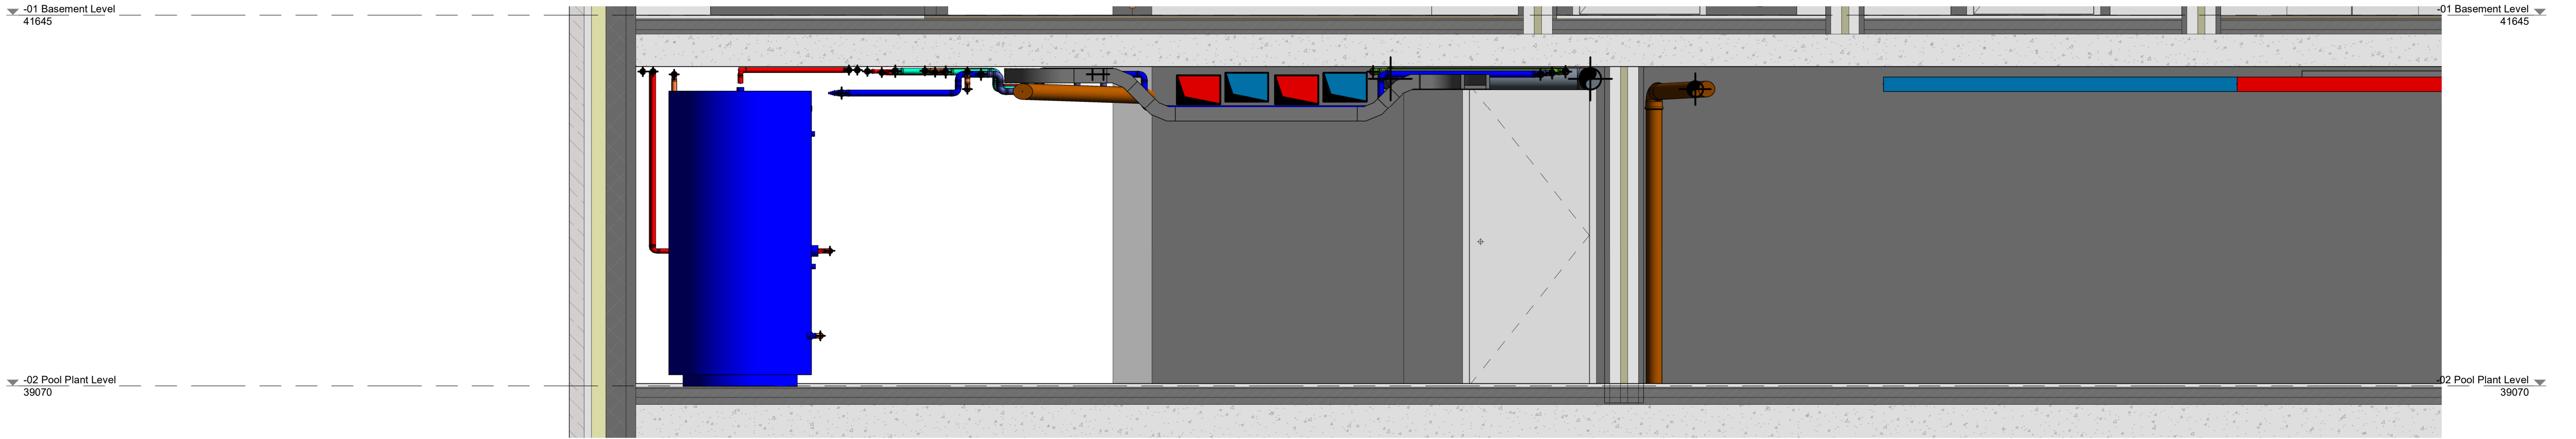

Section B
Mechanical Plant Room Section: Services Running Outside Mechanical Riser

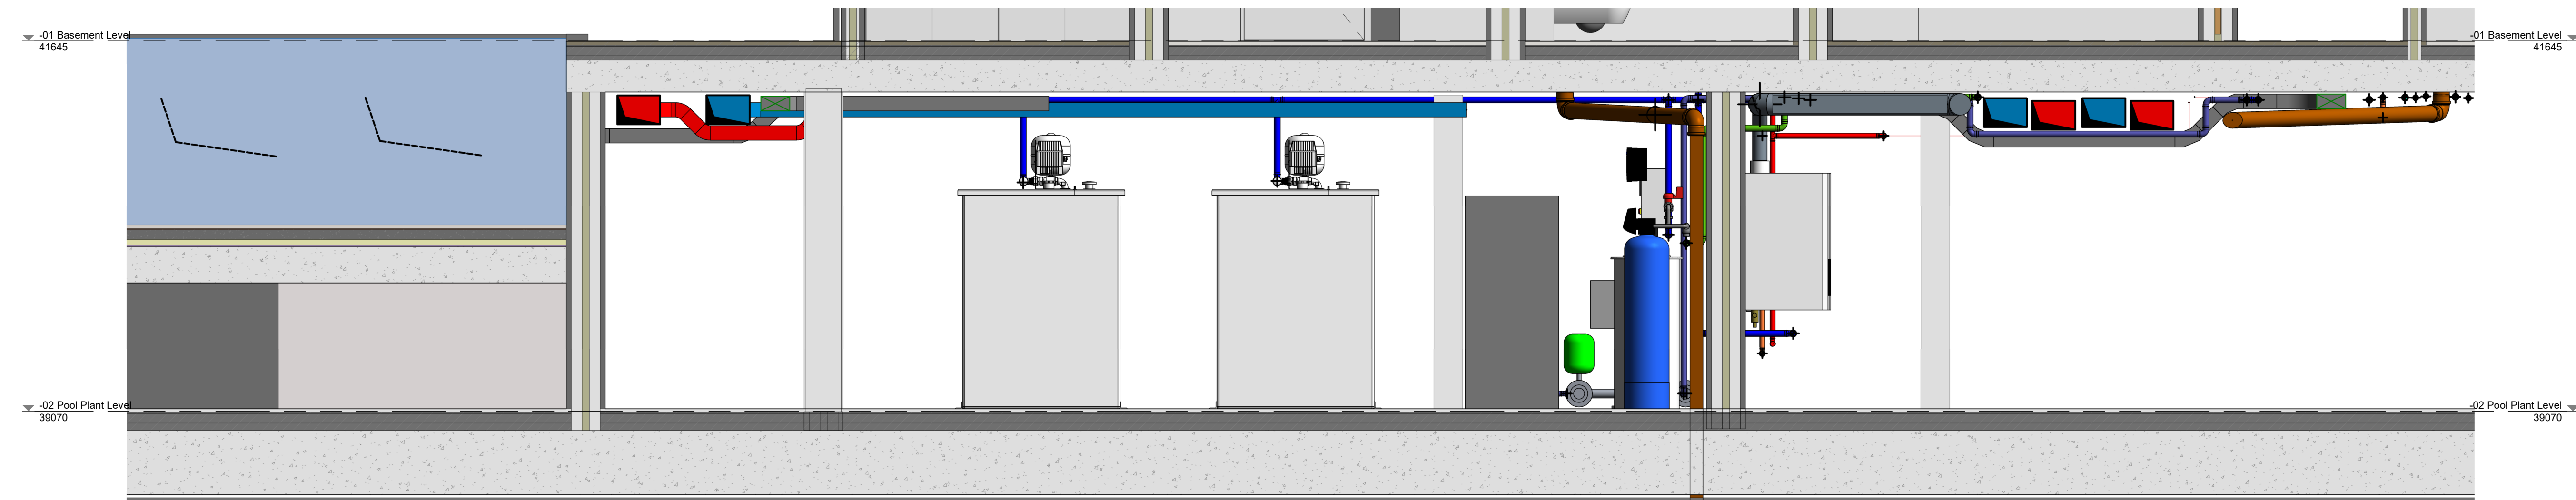

Section C
Mechanical Plant Room Section: Cold Water Tank Room

- NOTES**
1. Do not scale this drawing.
 2. Drawing only to be used for the status indicated.
 3. Drawing to be read in conjunction with relevant architectural and structural drawings and specifications.
 4. Refer to architectural drawings for setting out of all plant & equipment.

P1	Preliminary	31/01/20
NO.	REVISION	DATE
	DRAWING STATUS	
	PRELIMINARY	

INTEGRATION

3 - 5 SPAFIELD STREET
LONDON EC1R 4QB
+44 (0) 20 7183 8610
INTEGRATIONUK.COM

CLIENT
DEVELOPMENT ADVISOR
MIRA A-Architecture & Engineering Ltd
33 Cavendish Square
London, W1G 0PW

ARCHITECT
KSR ARCHITECTS LLP
14 Greenland Street
London, NW1 0ND

PROJECT
79 AVENUE ROAD
London
NW8 6JD

TITLE
MEP SERVICES
Mechanical Services Plant Room
Sections

DATE	SCALE	SIZE
January 2020		A1
DRAWING NO.	REV.	
581-INT-XX-B2-DR-MEP-6004	P1	