







No 11 Ground Floor

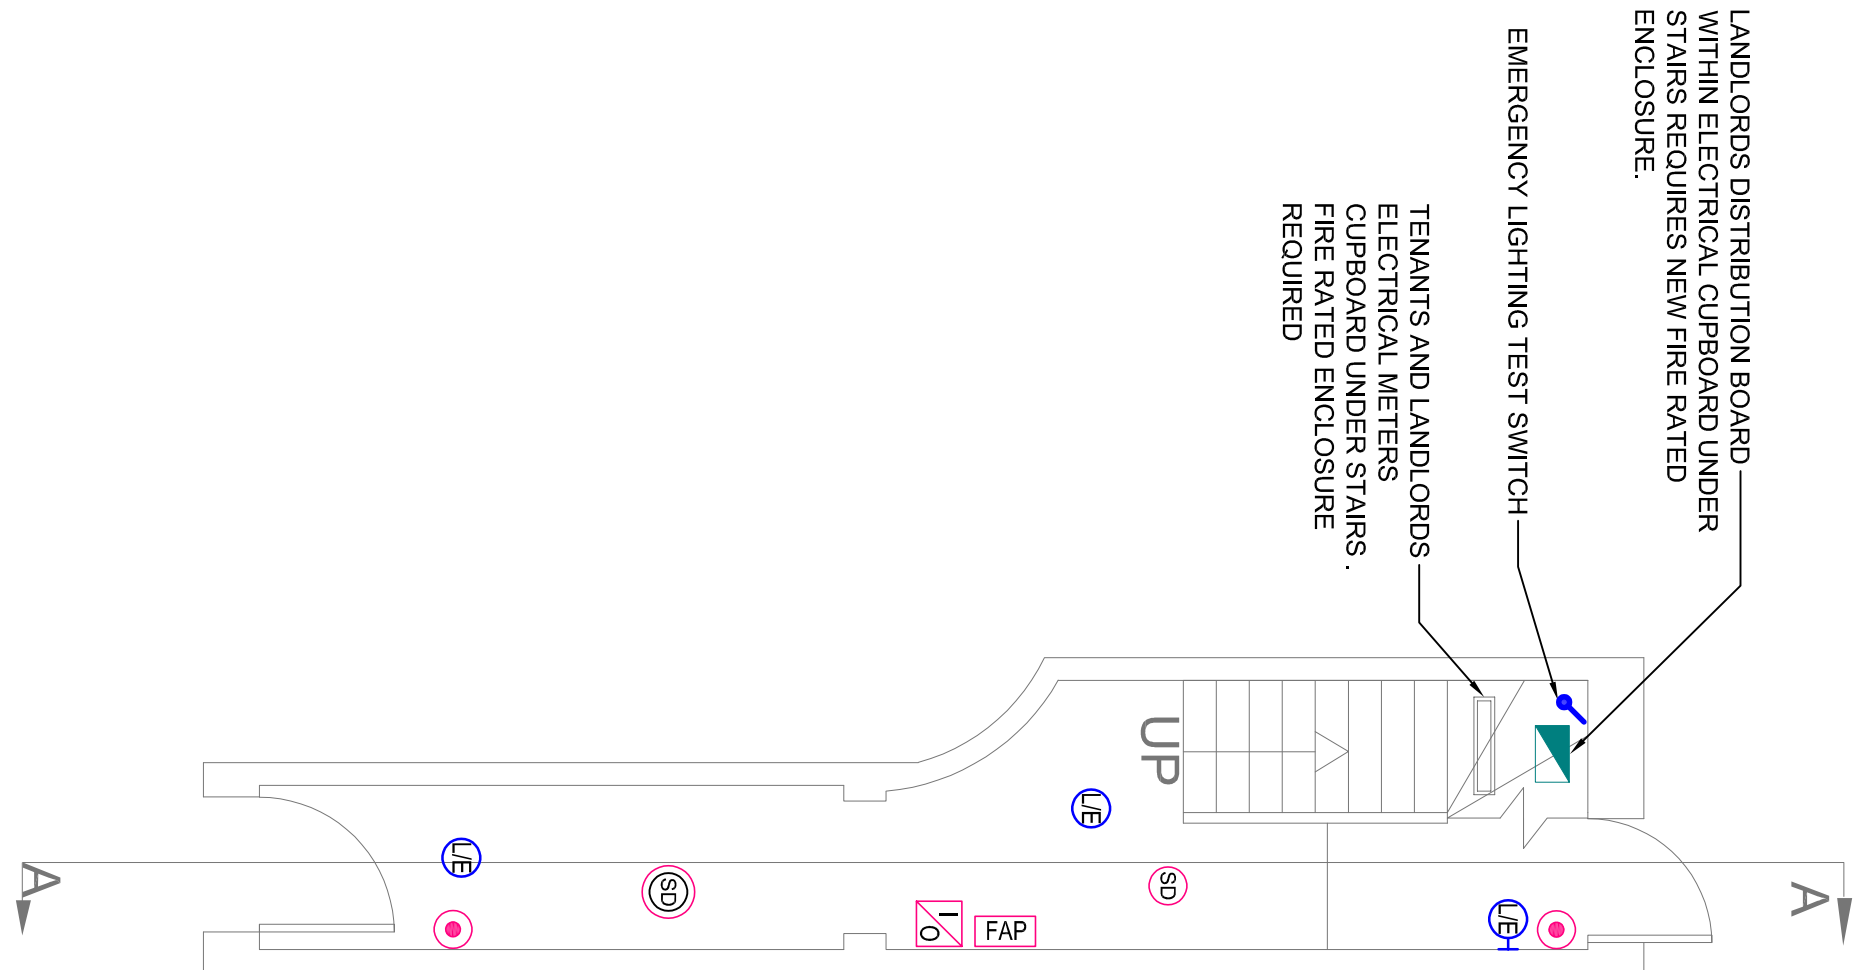

No 11 First Floor

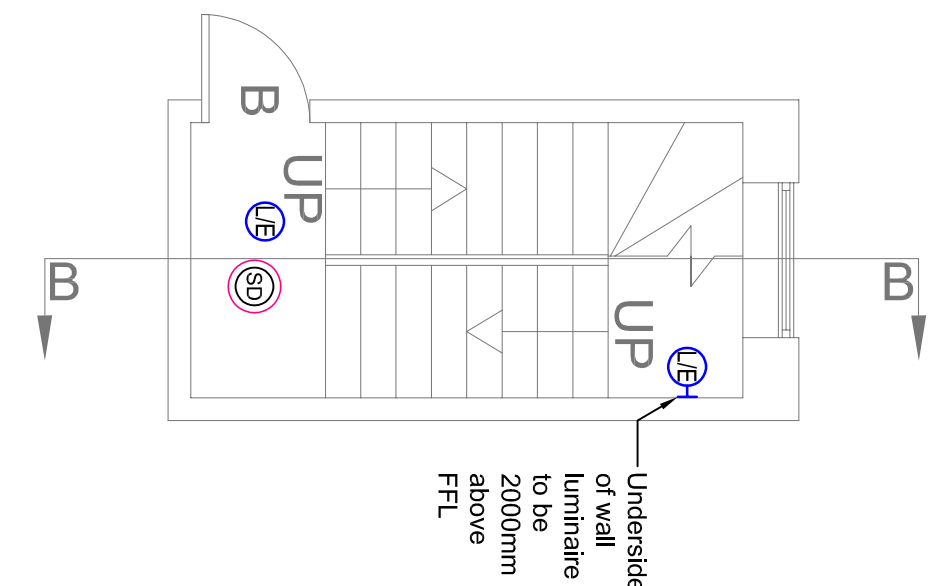

No 11 Second Floor

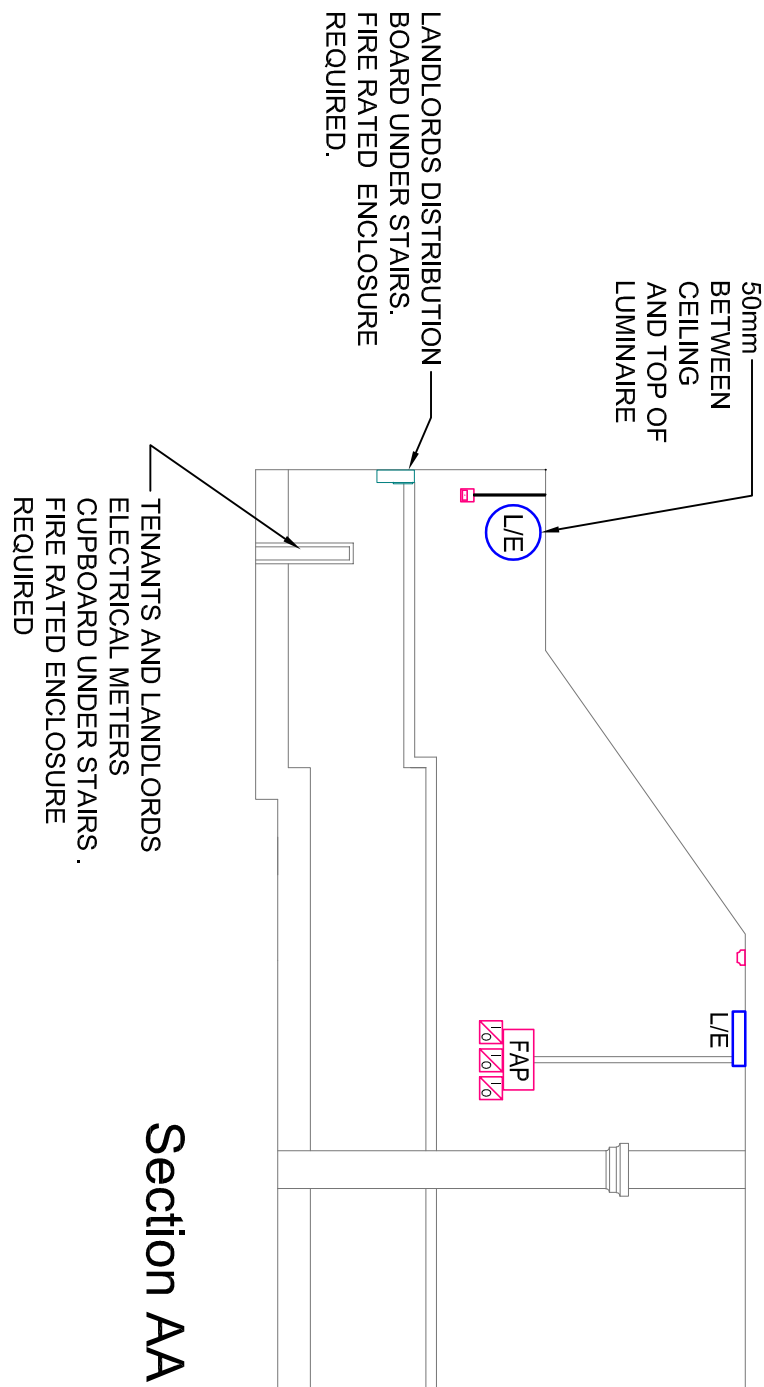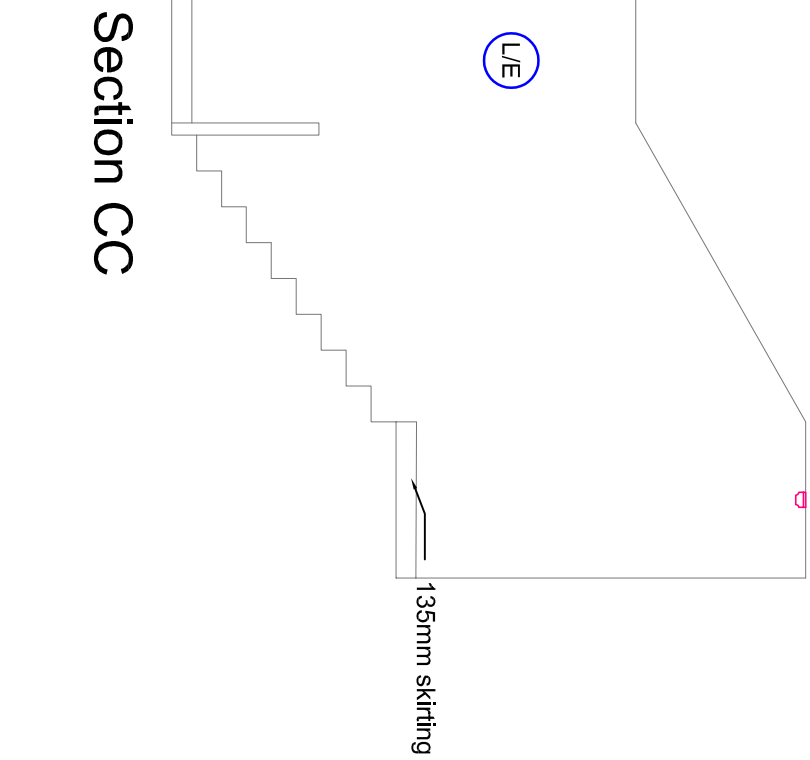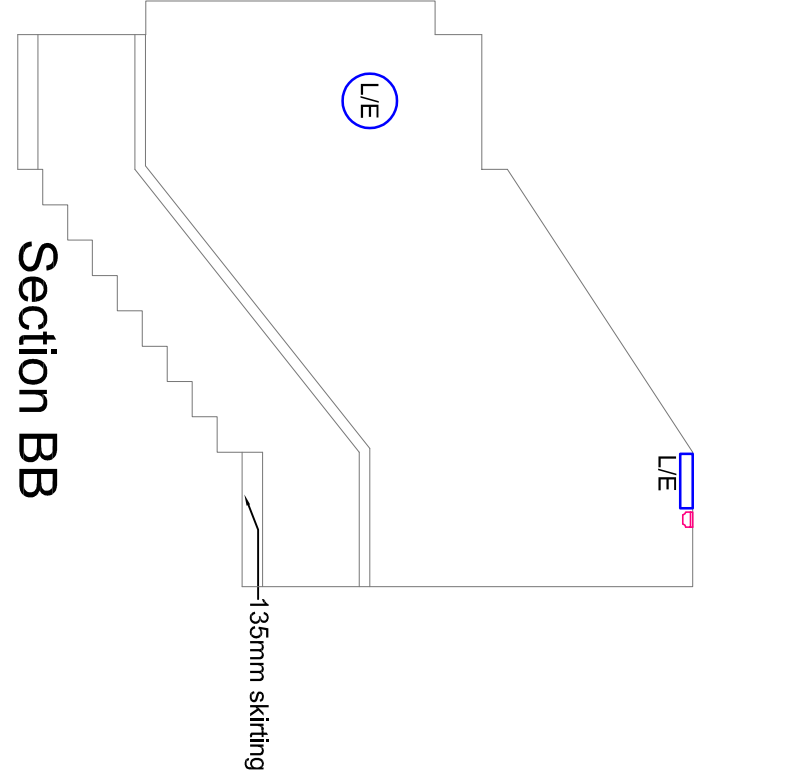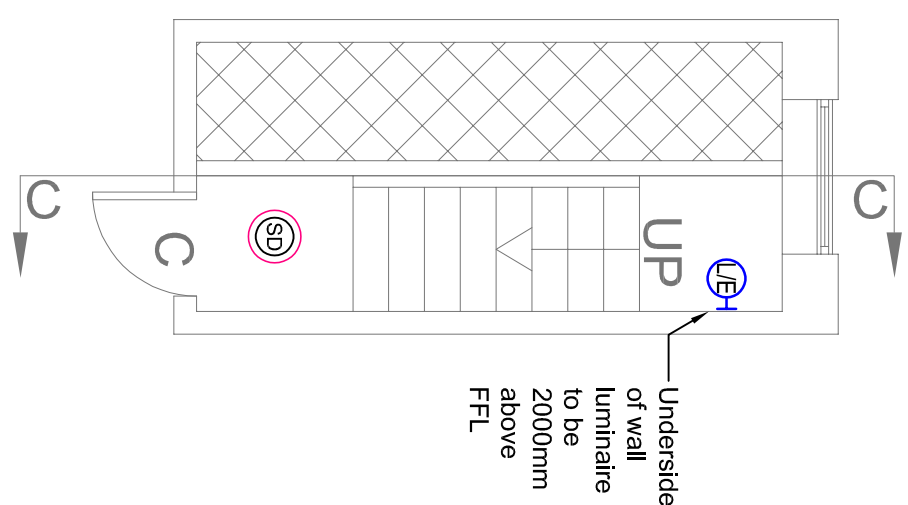

LEGEND	
	LANDLORDS DISTRIBUTION BOARD
	WALL MOUNTED CIRCULAR HIGH EFFICIENCY 18W, 1900 LUMEN OUTPUT COLOUR 940 LED LUMINAIRE, ACHIEVING 106 L/W, L90/0950,000HRS, WHITE SELF COOLED POLYCARBONATE BODY WITH SATIN ACRYLIC DIFFUSER, IP65 RATED, MAINTAINED WITH 3 HOURS INTEGRAL EMERGENCY FAULTY PROTECTION WITH INTEGRAL MICROWAVE PIR WITH CONRIDOR FUNCTION, SIZE 360D X 62mm DEPTH
	FIRE ALARM PANEL, ANALOGUE ADDRESSABLE, GRADE A, CATEGORY LD1 TO BS5839-6:2019
	OPTICAL SMOKE DETECTORS
	MANUAL CALL POINT (BREAKGLASS)
	INTERFACE UNIT FOR CONNECTION TO APARTMENT'S GRADE D CATEGORY LD1 TO BS5839-6:2019
	EMERGENCY LIGHTING TEST SWITCH

DISCLAIMER NOTES:

- THIS DOCUMENT IS COPYRIGHT OF THE ORIGINATOR AND MUST BE TREATED AS CONFIDENTIAL. IT MUST NOT BE ALTERED, REPRODUCED OR DISTRIBUTED WITHOUT THE WRITTEN CONSENT OF THE ORIGINATOR.
- THIS DOCUMENT MUST NOT BE ALTERED. THE ORIGINATOR ACCEPTS NO RESPONSIBILITY FOR ANY DISCREPANCIES ARISING AS A RESULT OF THE ORIGINATOR'S INFORMATION.
- ANY DISCREPANCY MUST BE REPORTED TO THE ORIGINATOR.
- DO NOT SCALE THIS DOCUMENT. USE FIGURED DIMENSIONS ONLY.
- ALL DIMENSIONS MUST BE CHECKED ON SITE PRIOR TO COMMENCEMENT OF ANY RELATED WORK.
- THIS DOCUMENT MUST BE READ IN CONJUNCTION WITH ALL SUPPORTING DOCUMENTS PRODUCED BY THE ORIGINATOR AND OTHER PROJECT DISCREPANCIES.
- THE ORIGINATOR ACCEPTS NO RESPONSIBILITY FOR THE ACCURACY OF BACKGROUND INFORMATION PROVIDED BY THIRD PARTIES. THIS MUST BE TREATED AS INDICATIVE ONLY.
- USERS OF THIS DOCUMENT ARE RESPONSIBLE FOR CHECKING WHICH REVISIONS CURRENTLY APPLY.
- THE ORIGINATOR'S STATUS INFORMATION OR PRELIMINARY NOTICES THAT THIS DRAWING IS FOR REFERENCE PURPOSES ONLY. THE ORIGINATOR WILL ACCEPT NO RESPONSIBILITY FOR THE COMPLETENESS OF INFORMATION UNDER THIS STATUS.
- THE DOCUMENT STATUS 'RECORD' OR 'AS BUILT' HAS BEEN REVERSED IN PART BASED ON THE ORIGINATOR'S ASSUMES NO RESPONSIBILITY FOR THE ACCURACY OF THIS 'RECORD' OR 'AS BUILT' DOCUMENT FOR ANY ERRORS OR OMISSIONS THAT MAY HAVE BEEN INCORPORATED INTO IT AS A RESULT OF INFORMATION PROVIDED TO THE ORIGINATOR.
- ADVISORY TO OBTAIN INDEPENDENT VERIFICATION OF ITS ACCURACY.

DRAWING NOTES:

COM REGULATIONS 2015
SIGNIFICANT INFORMATION HAS BEEN REMOVED FROM THIS DOCUMENT TO MAINTAIN THE RIGHT WITH BRIEF ACCOMPANYING TEXT FOR FURTHER DETAILS OF THE RISKS IDENTIFIED BY DESIGNERS. REFERENCE SHOULD BE MADE TO COM HAZARD RESISTANCE.



REV	DESCRIPTION	DATE	BY	CHKD
-				

ORIGINATOR:

RIDGE
PROPERTY & CONSTRUCTION CONSULTANTS

PARTNERSHIP HOUSE
11 DOMBNEY STREET
WINCHESTER
SO23 7BX
TEL: 01962 834400
WWW.RIDGE.CO.UK

CLIENT:



IN ASSOCIATION WITH:

PROJECT
9-22 DOMBNEY STREET

TITLE
11 DOMBNEY STREET
PROPOSED LANDLORDS LIGHTING
AND FIRE ALARM LAYOUT

DRAWN BY: DB SCALE: 1:50 @ A1
CHECKED BY: TN DATE: 18/02/2020

STATUS
PLANNING

DRAWING NO.	PROJECT	ZONE	LEVEL	TYPE	ROLE	NUMBER	REV
5010339	RDG	XX	XX	PL	E	11	-

0.5 0 0.5 1 1.5 2 2.5
SCALE 1:50
m