
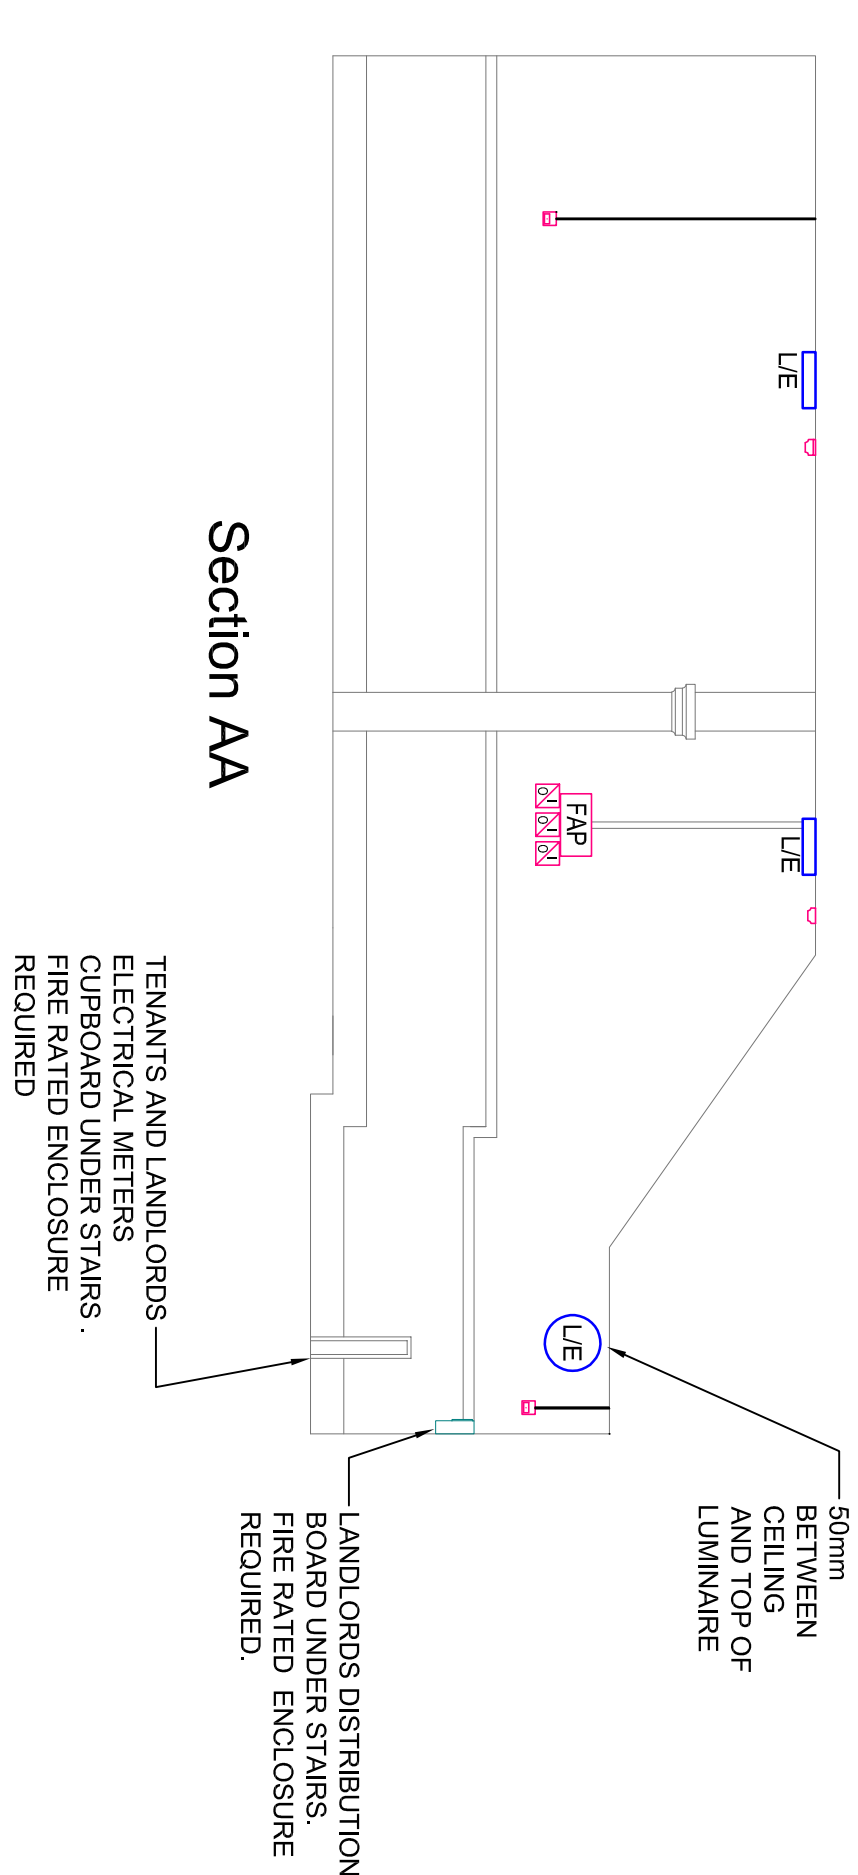
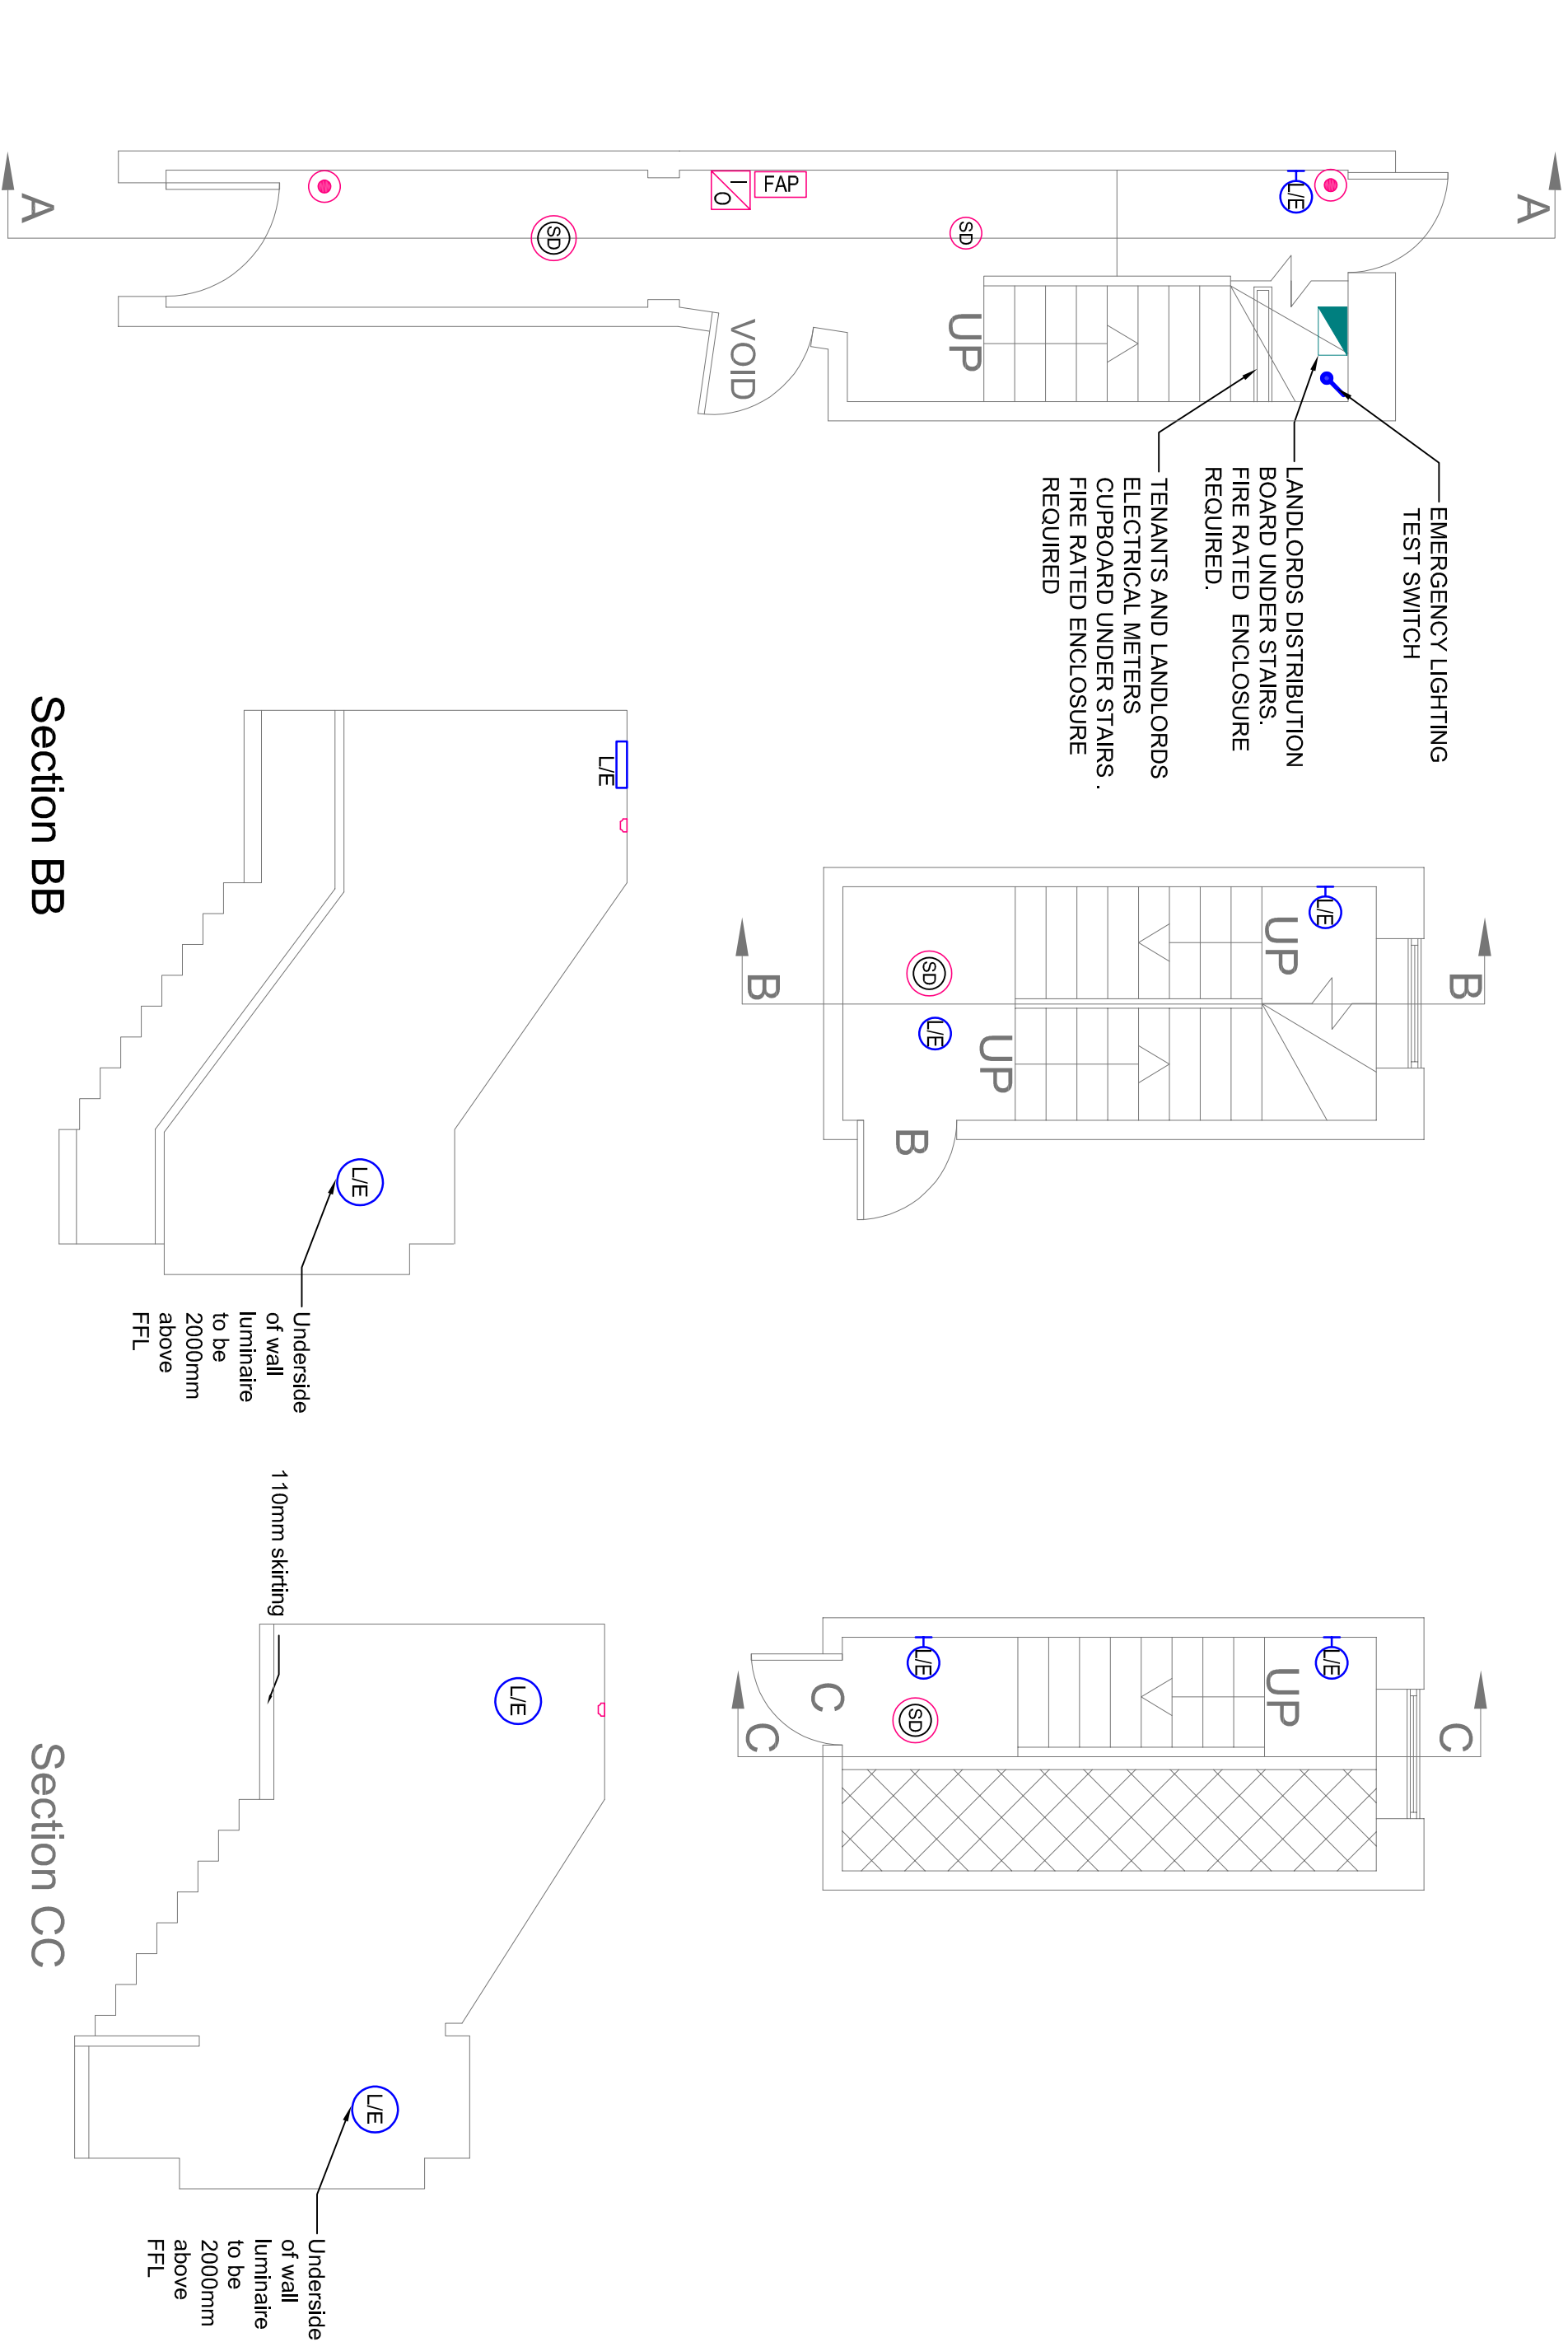


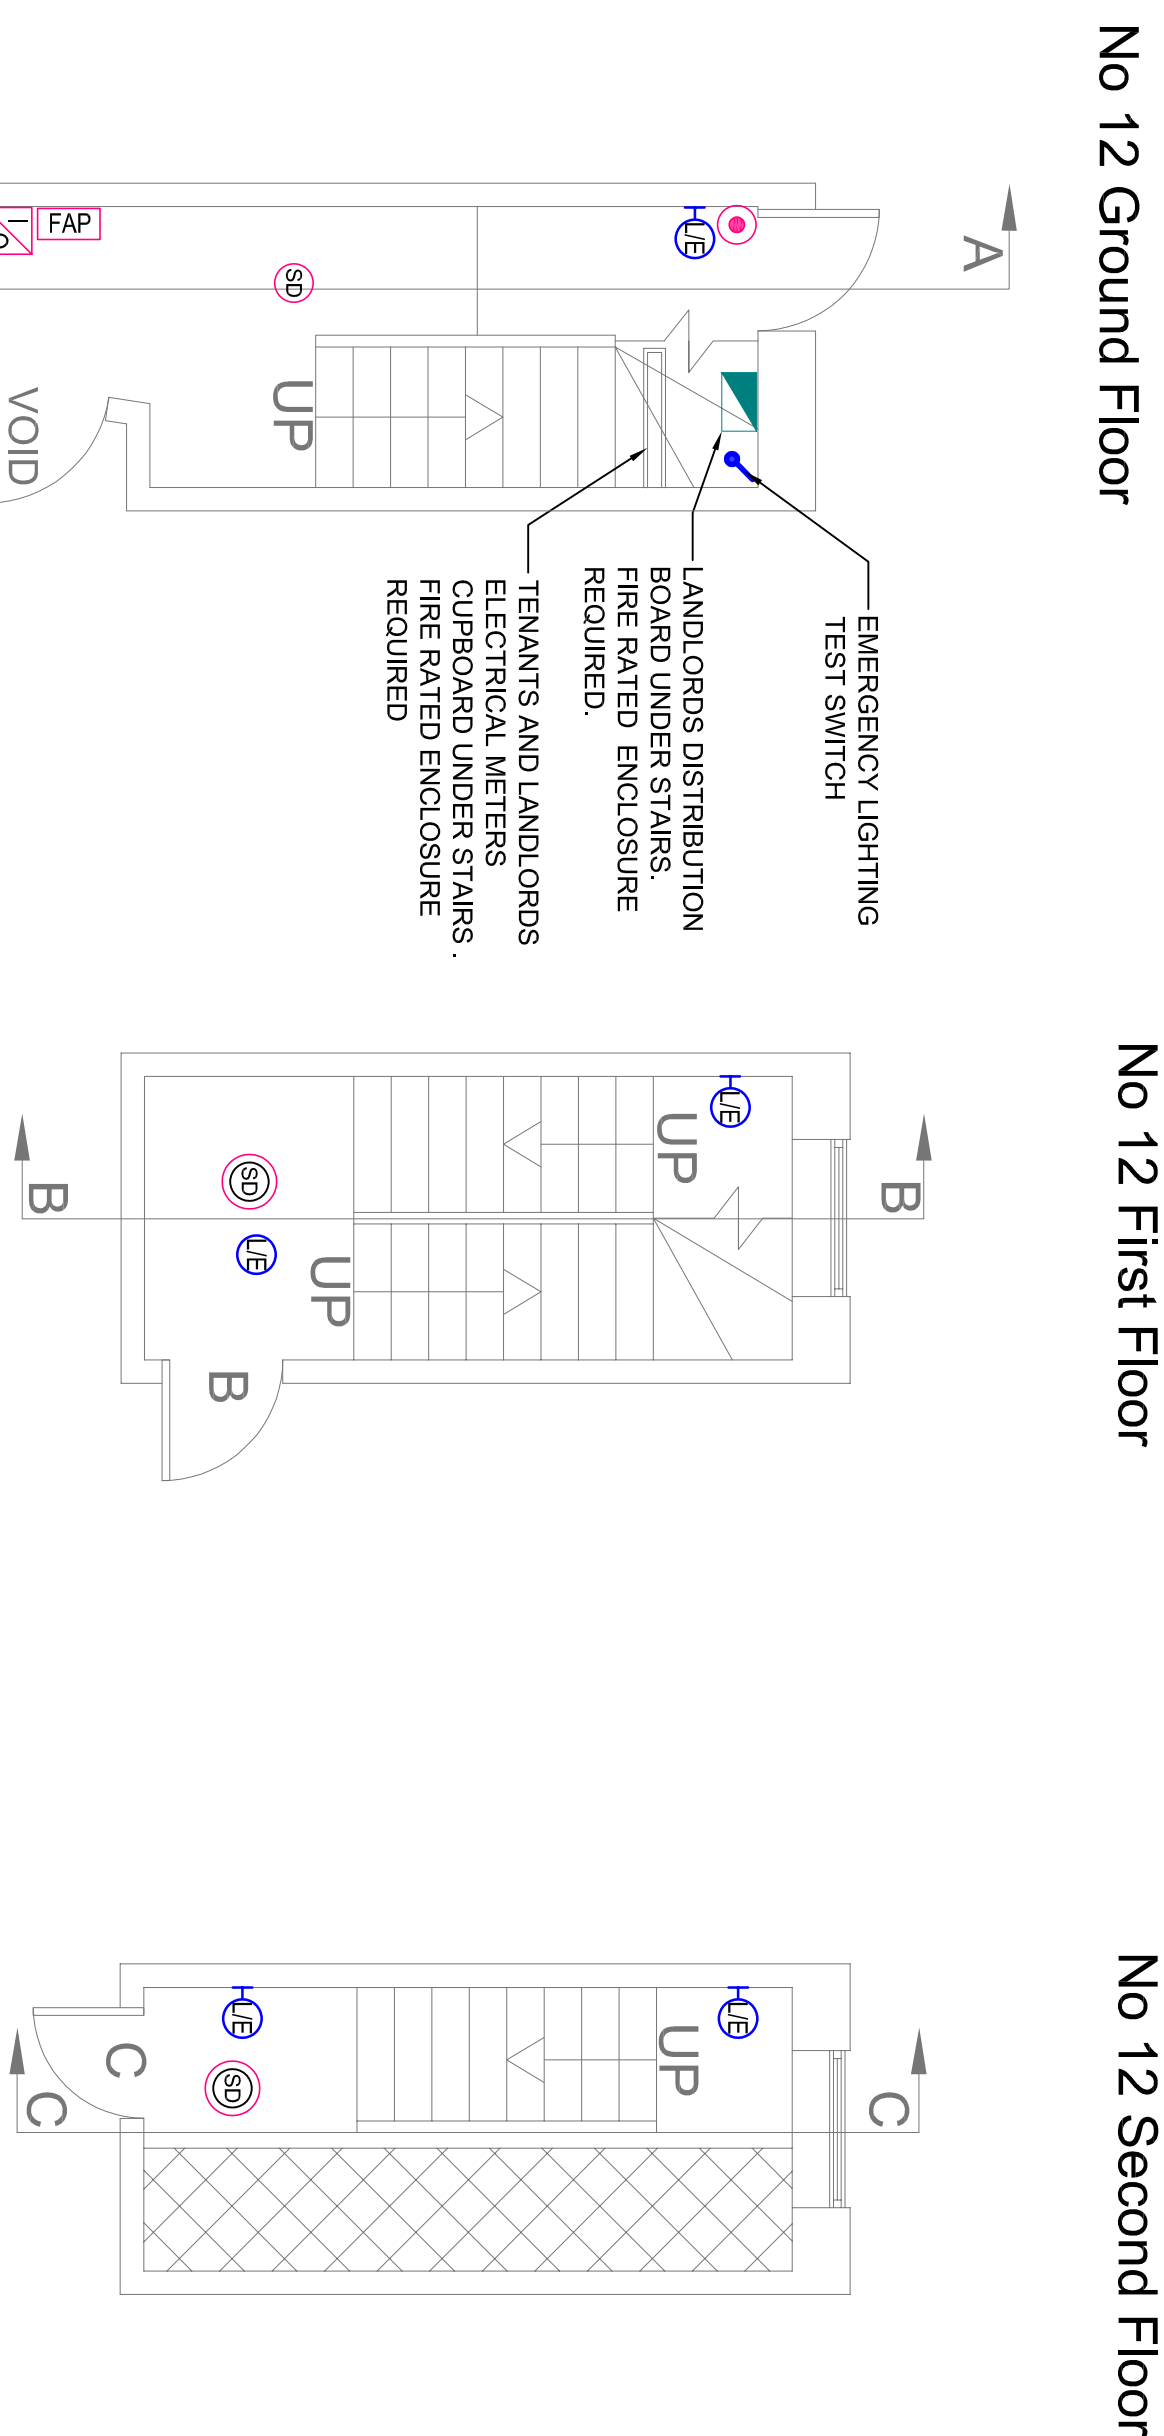

LEGEND	
	LANDLORDS DISTRIBUTION BOARD
	WALL MOUNTED CIRCULAR HIGH EFFICIENCY 14W, 1800 LUMEN OUTPUT COLOUR 8400 LED LUMINAIRE, RECHARGING 106 LUM, 1200050/00019, WHITE
	SELF COLOURED POLYCARBONATE BODY WITH SATIN ACRYLIC DIFFUSER, IP65 RATED, MAINTAINED WITH 3 HOURS INTEGRAL EMERGENCY FACILITY COMPLETE WITH INTEGRAL MICROVAPE PIR WITH CORRIDOR FUNCTION, SIZE 380Ø x 82mm DEPTH
	FIRE ALARM PANEL ANALOGUE ADDRESSABLE, GRADE A, CATEGORY L01 TO BS5839-6-2019
	OPTICAL SMOKE DETECTORS
	OPTICAL SMOKE DETECTOR WITH SOUNDER
	MANUAL CALL POINT (BREAKGLASS)
	INTERFACE UNIT FOR CONNECTION TO APARTMENTS GRADE D CATEGORY L01 TO BS5839-6-2019
	EMERGENCY LIGHTING TEST SWITCH

[illegible]

REV	DESCRIPTION	DATE	BY	CHK
-				


RIDGE
PROPERTY & CONSTRUCTION CONSULTANTS

PARTNERSHIP HOUSE
1000 WILSON ROAD
WINCHESTER
SO23 7RX

TEL: 01962 834400
WWW.RIDGE.CO.UK

CLIENT:	
IN ASSOCIATION WITH:	
PROJECT:	9-22 DOMBEY STREET

TITLE:		12 DOMBEY STREET	
		PROPOSED LANDLORDS LIGHTING	
		AND FIRE ALARM LAYOUT	
DRAWN BY:	DB	SCALE:	1:50 @ A1
CHECKED BY:	TN	DATE:	18/02/2020
STATUS:		PLANNING	

 

DRAWING No:							
PROJECT:	ORG:	ZONE:	LEVEL:	TYPE:	ROLE:	NUMBER:	REVISION:
5010339	RDG	XX	XX	PL	E	12	-