

General Notes



This drawing must not be scaled. All dimensions to be checked.

This drawing is to be read in conjunction with all relevant structural engineer's drawing and details, the specification for the works, the relevant architects drawings and any other specialists drawings.


Note that 'As Installed Drawings' should be used for co-ordination of MEP Systems. This drawing is for Design intent only.

Mechanical Legend


	Existing Units Unmodified
	Additional Units Added
	Existing Units Relocated
	Existing Services Unmodified
	CHW Services Modified
	LTHW Services Modified
	Refrigerant Services Modified
	Condensate Services Modified
	Primary Fresh Air Modified
	Secondary Supply Air Modified
	Return Air / Extract Modified
	Existing Supply / Fresh Air Modified
	Existing Return Air / Extract Modified
	Additional Extract Fan Added
	Volume Control Damper (VCD)
	Non Return Damper (NRD)
	Motorised Control Damper (MCD)
	Fire Damper (FD)
	Smoke Damper (SD)
	Fire Smoke Damper (FSD)
	AC Controller
	Temperature Sensor
	CO2 Sensor
	Heater Battery
	Attenuator / Silencer
	Access Panel

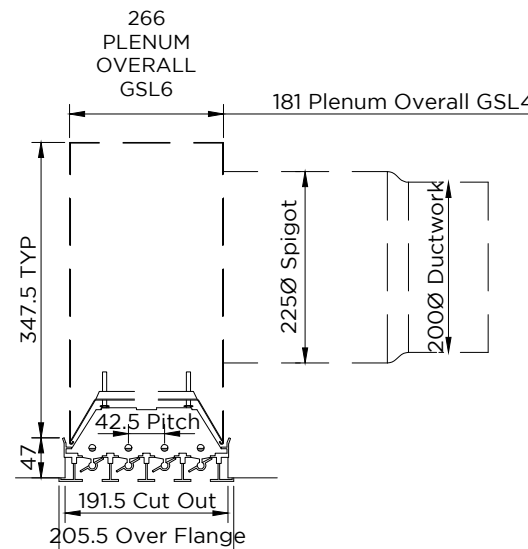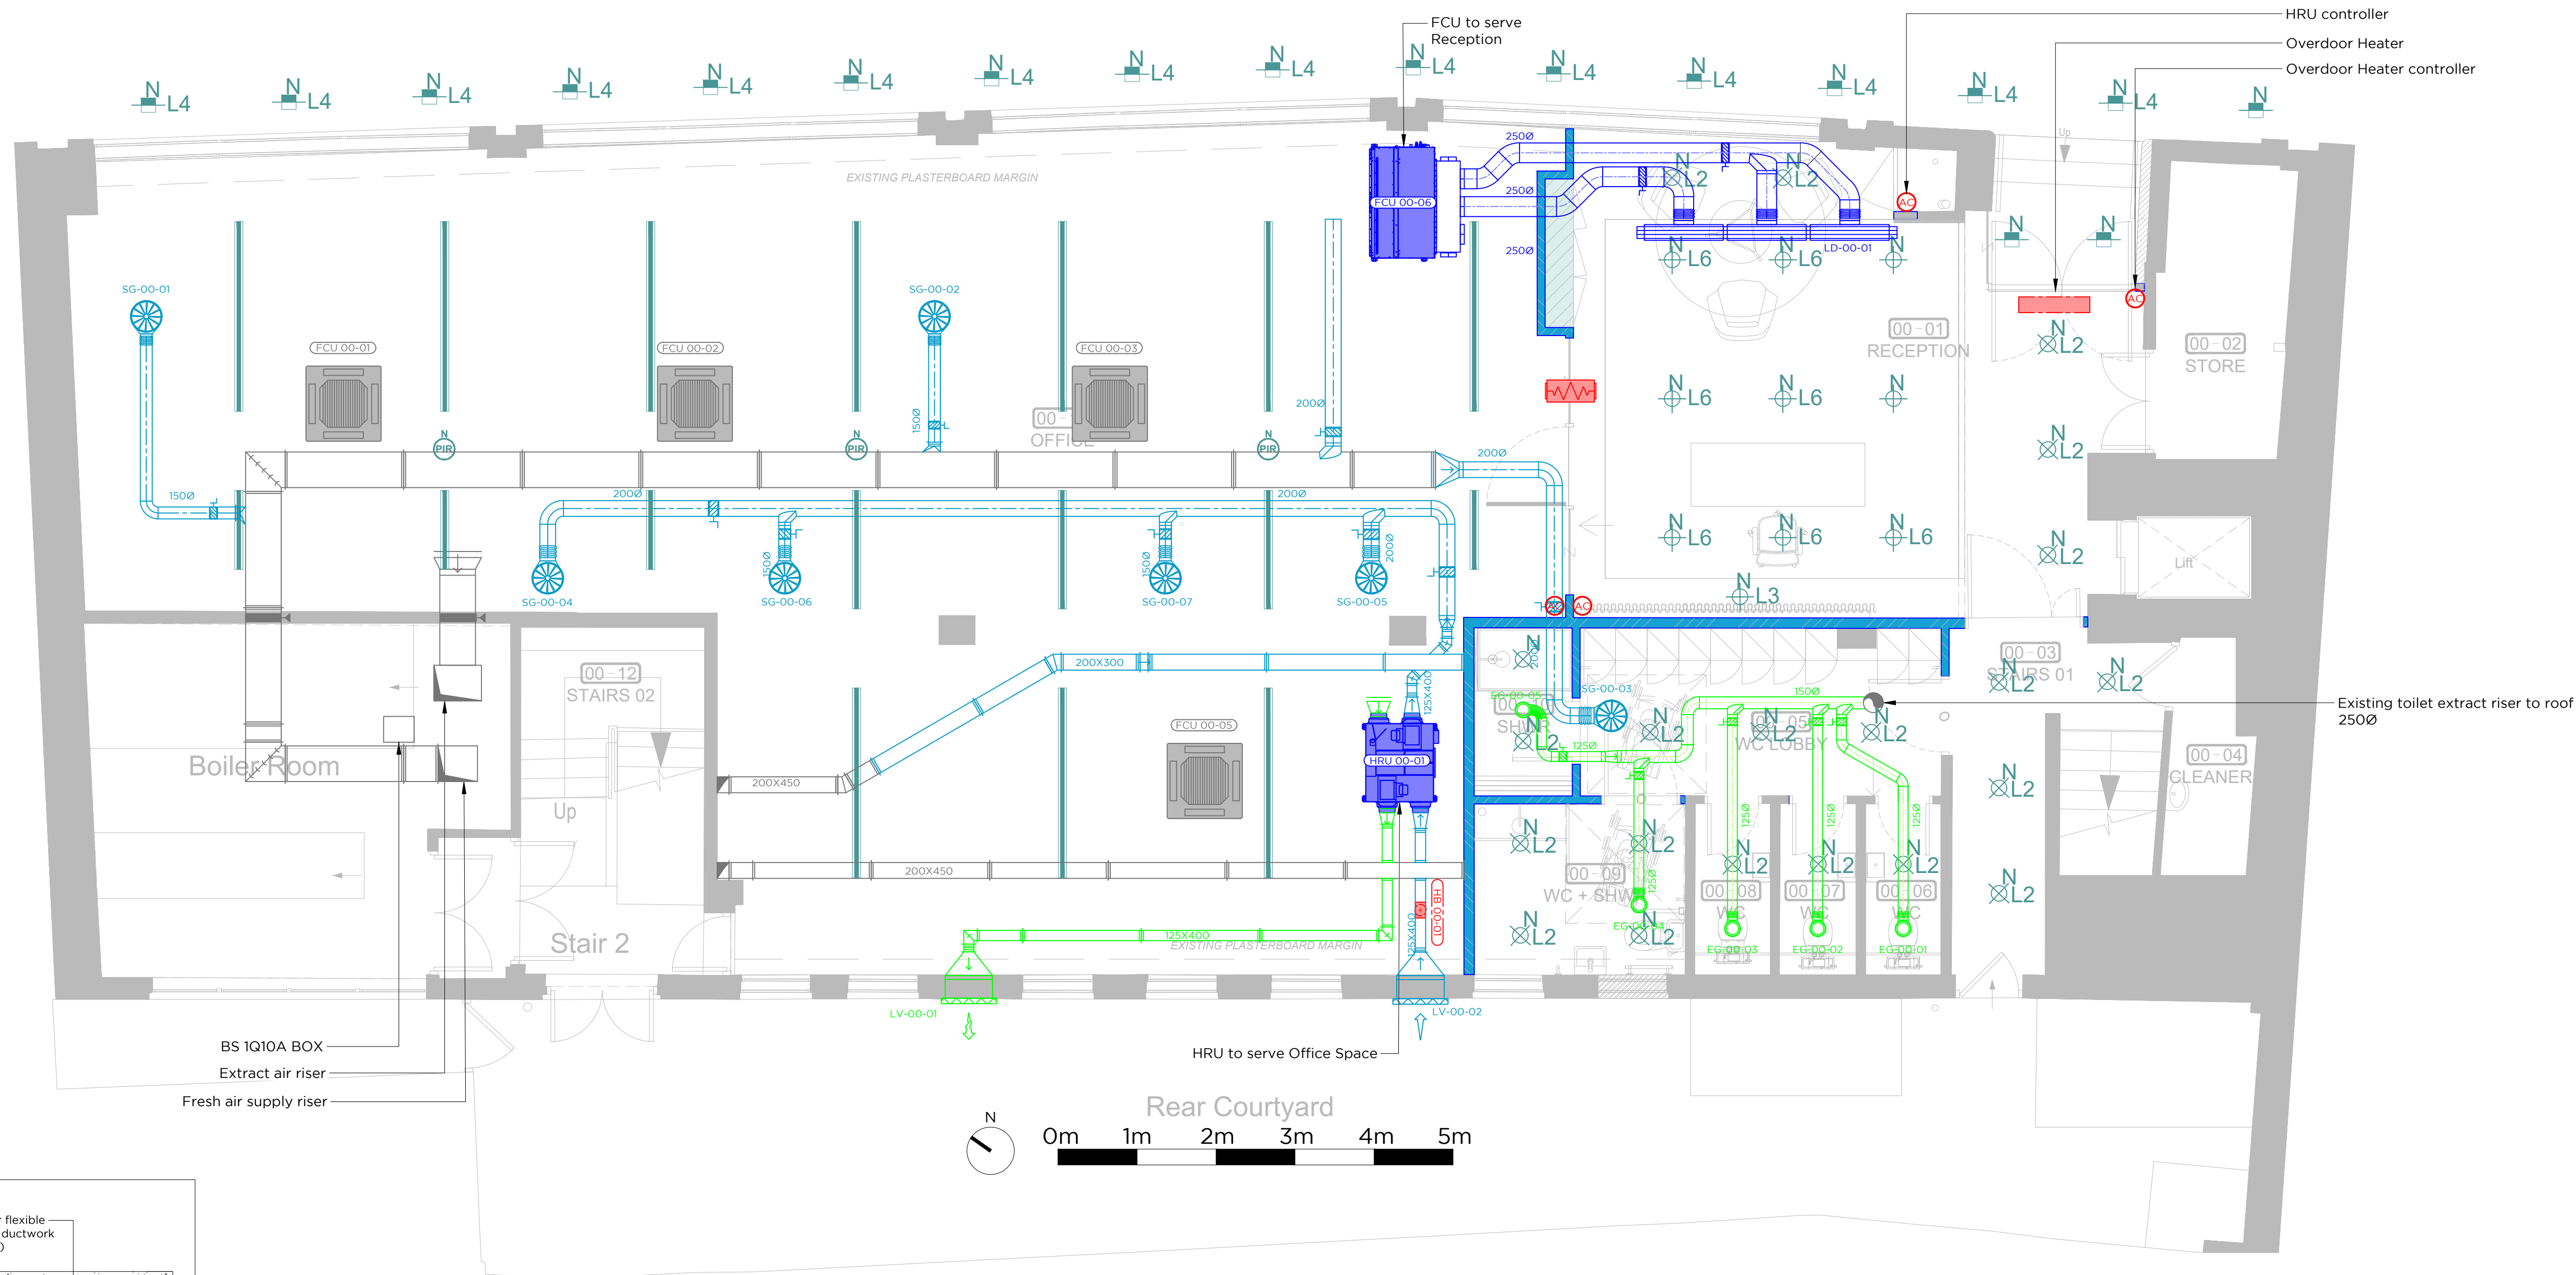

Linear Diffuser Section

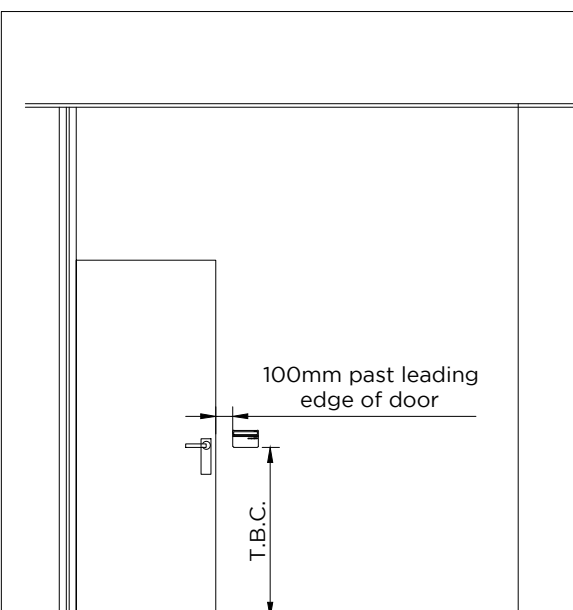

Typical AC Controller Location

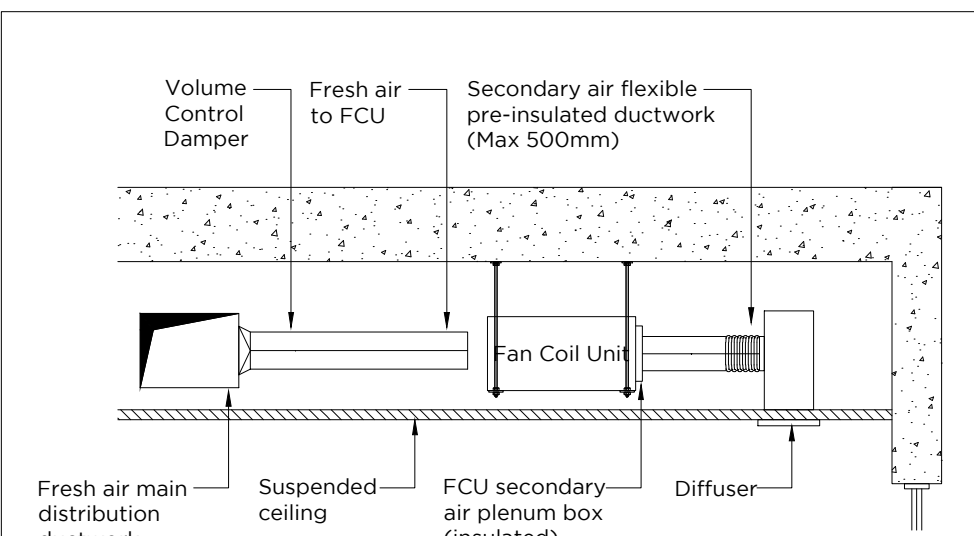

Typical Ceiling Mounted FCU Arrangement

Rev	Description	Drn	Chk	Date
-	First Issue	AT	J.G.	21-02-20



Conditioned Environment
(Mechanical Services) Ltd
245 Acton Lane, Park Royal
London NW10 7NR
T 020 8453 1010
F 020 8965 8469
E enquiries@c-env.co.uk
www.c-env.co.uk



Client

Oktra

Project

107 Gray's Inn Road
London

Drawing Title

00 Floor Mechanical
Services Layout

Drawing Status

RECORD DRAWING

Designed By	Drawn By	Checked By
J.G.	M.S.	J.G.

1st Issue Date	Scale @ A1
21-02-20	1:50

Project	Serv	Floor	Ref	Sheet	Rev
P5106	M	00	MEC	01	RD