
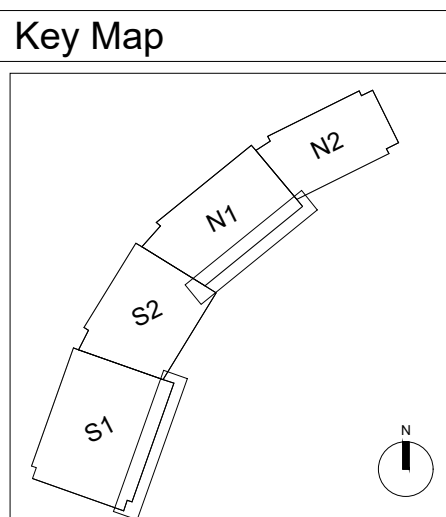
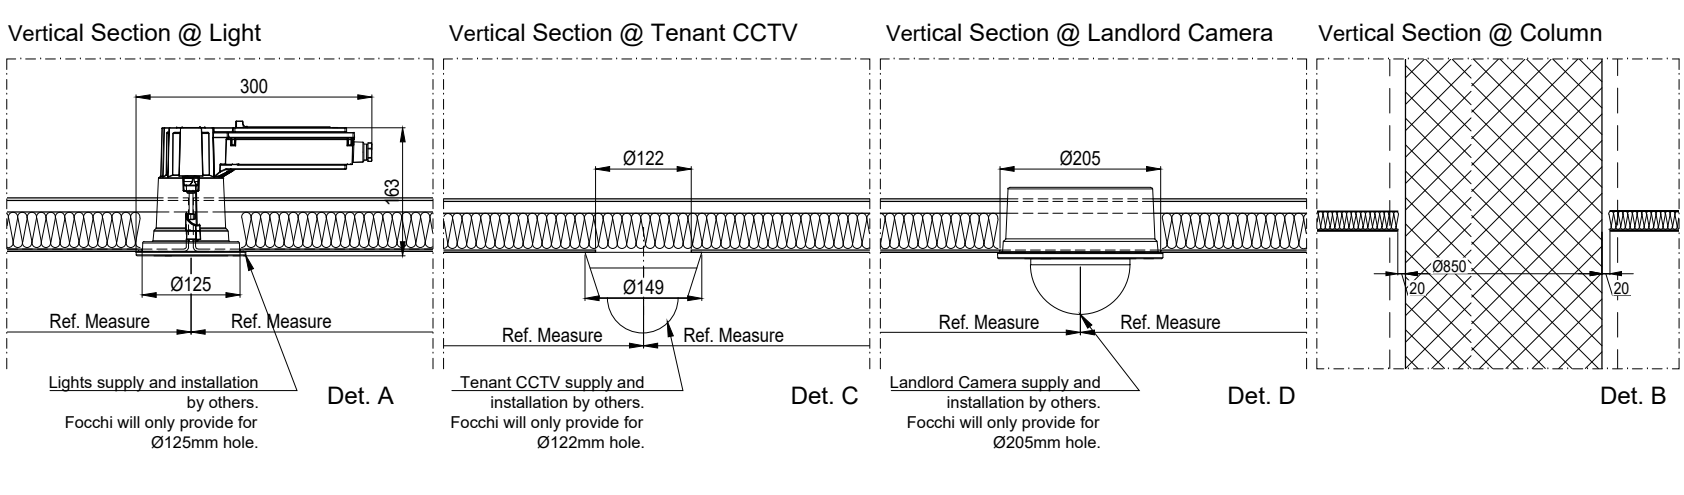
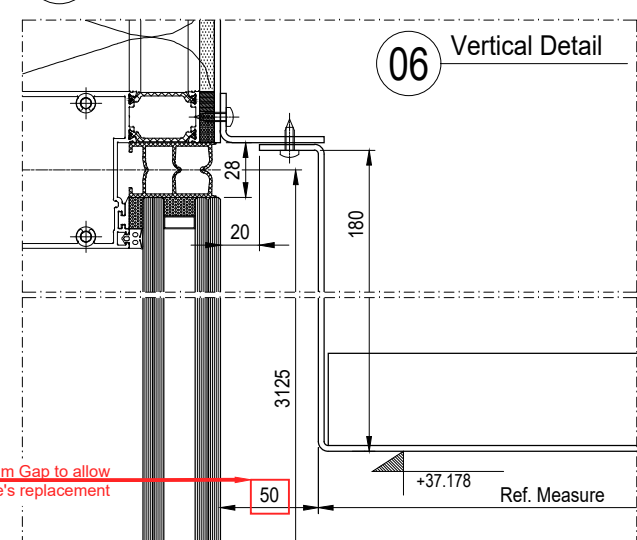
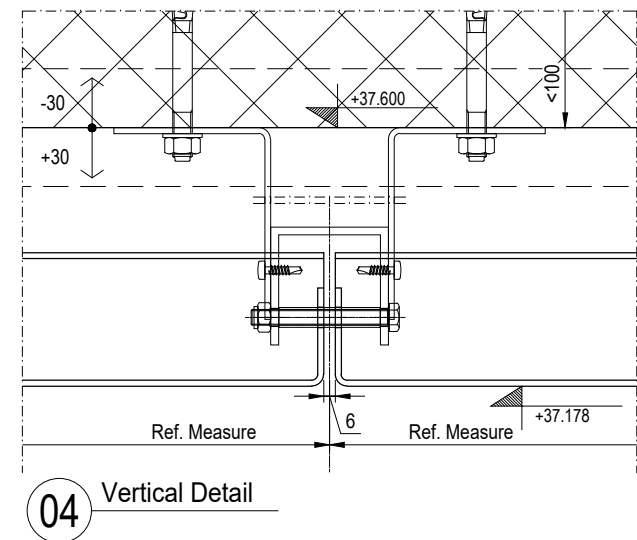
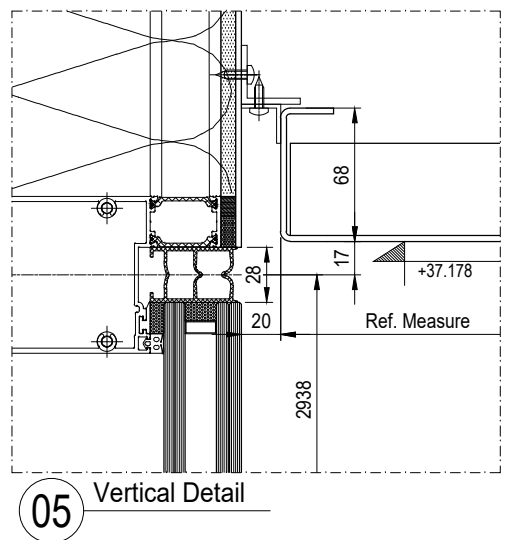
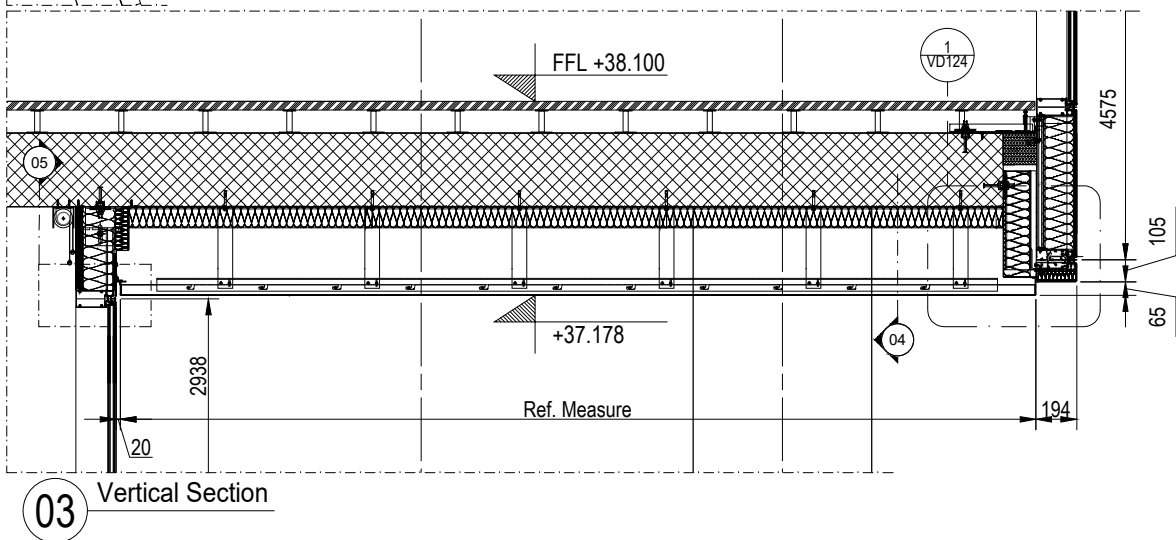
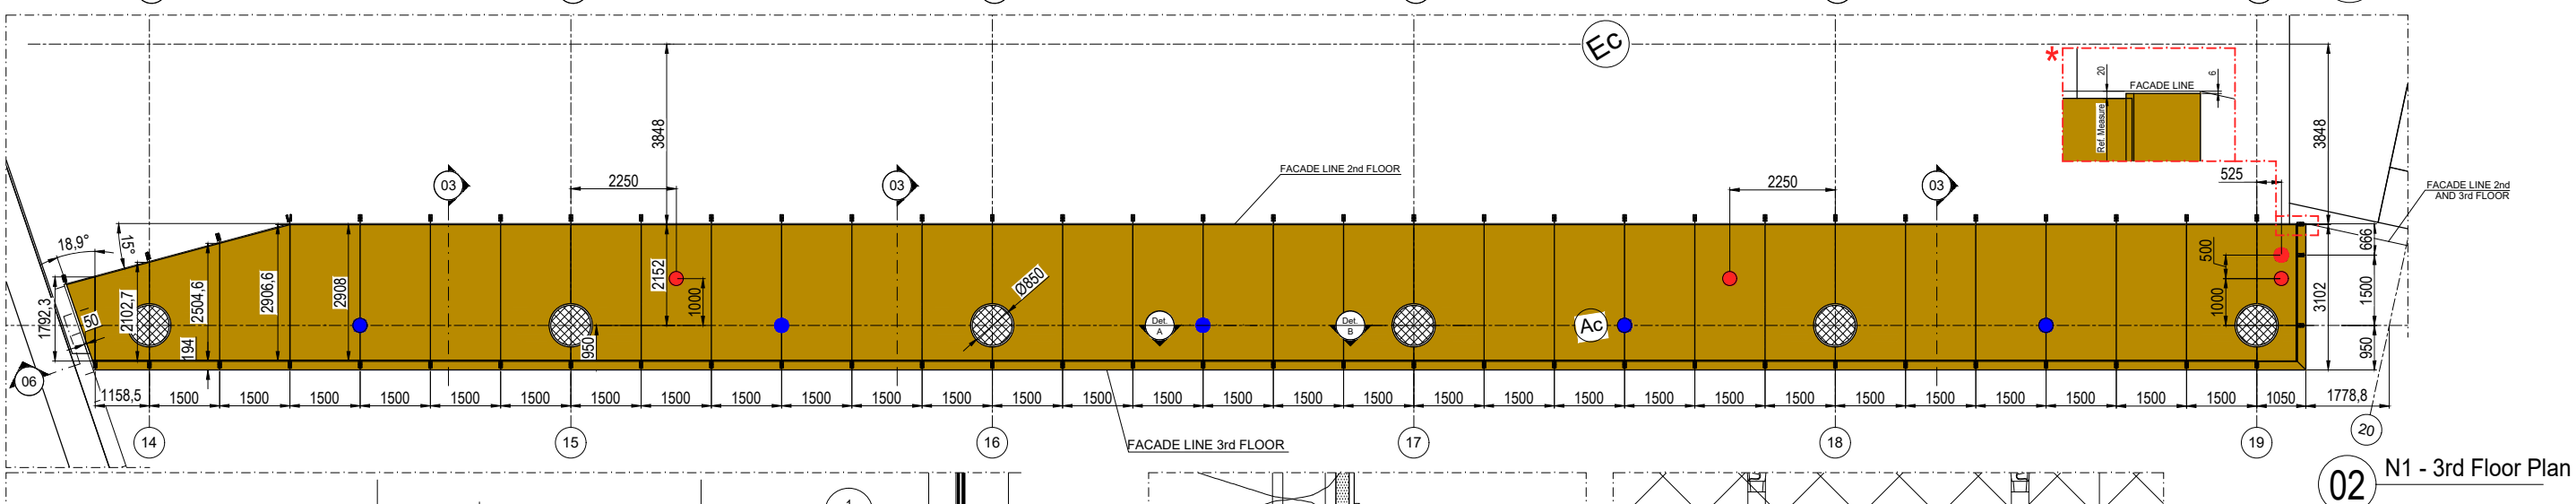


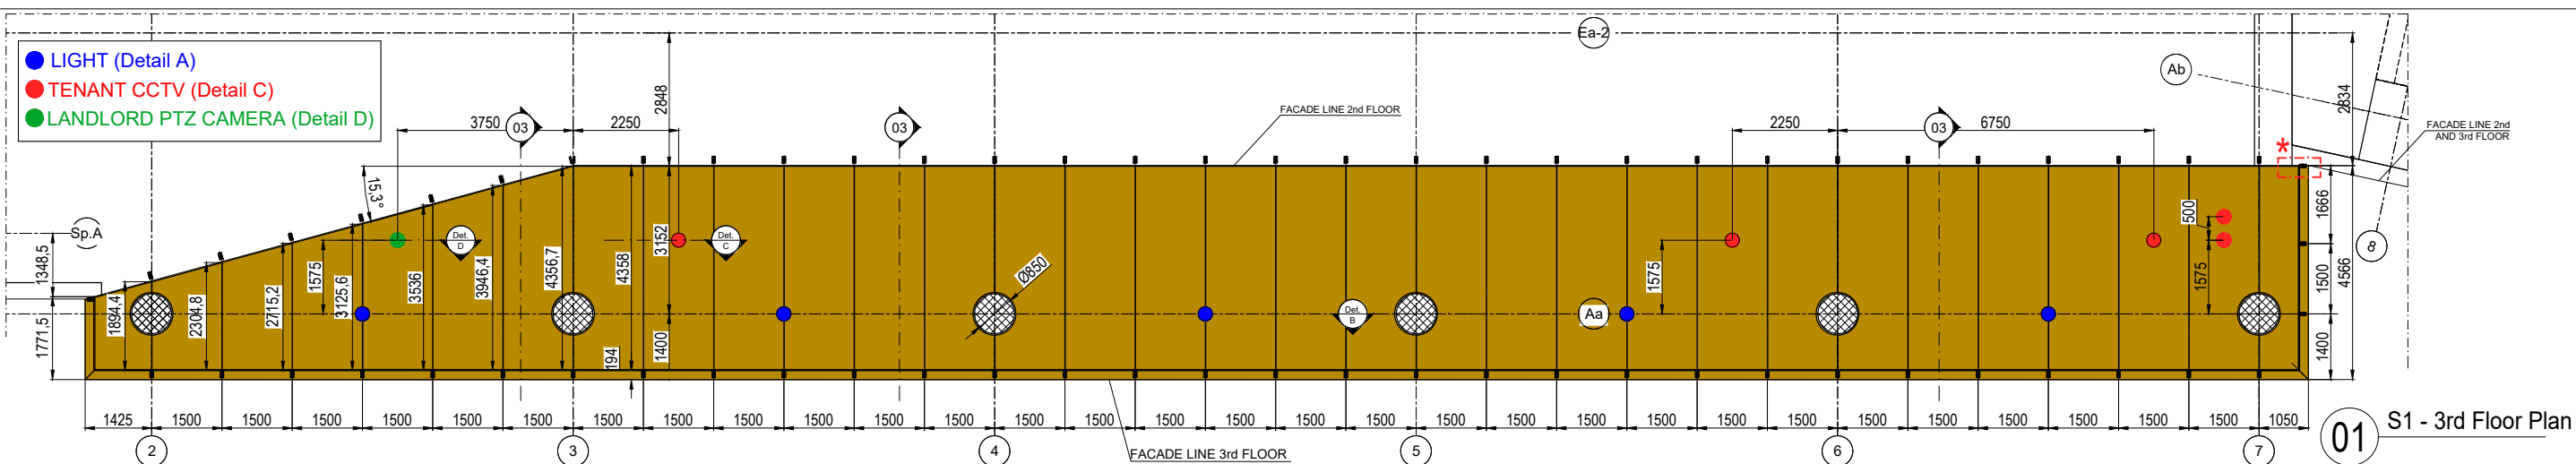

Title :	REFLECTED CEILING PLAN			
	BLOCK S1-N1 - 3rd FLOOR			
	FOCCHI			
Project :	King's Cross - T2/T3	London	Architect :	Bennetts Associates
Client :	BAMC	Package :	FOCCHI	
Rev	00	01		
Date	16-04-2019	24-02-2020	Drawn by:	PFE
Approved by:	L. CENNI	L. CENNI	Description	Ceiling Layout
Issue:	140	160070	Issued for:	INFORMATION
Job :	1:150 @ A3	PSN05	Drw.:	PSN05
Rev.:	01			