


GROUND FLOOR

Gas pipe 28mm dia to be fixed on to the portico wall

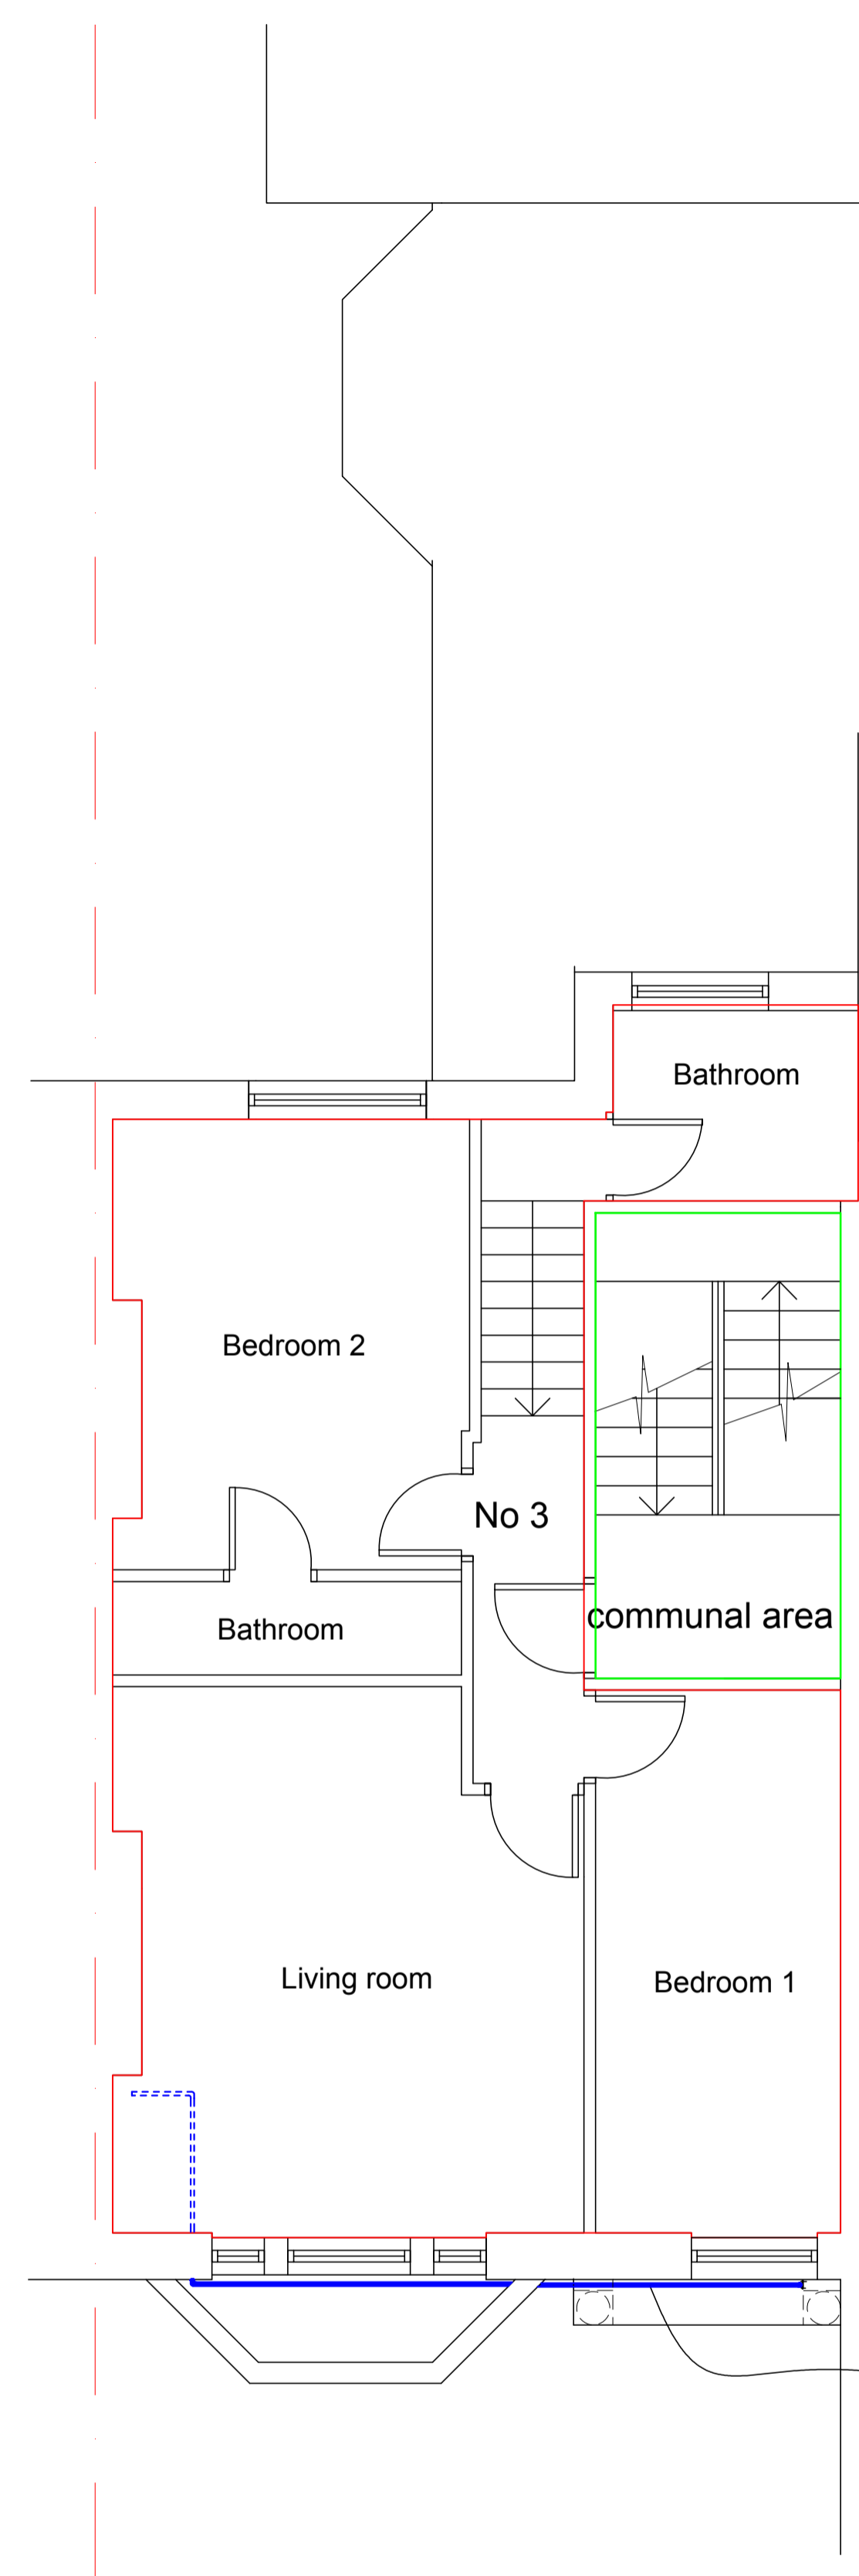


FIRST FLOOR

Gas pipe 28mm dia

FLOOR PLANS

6 Belsize Crescent, NW3 5QU

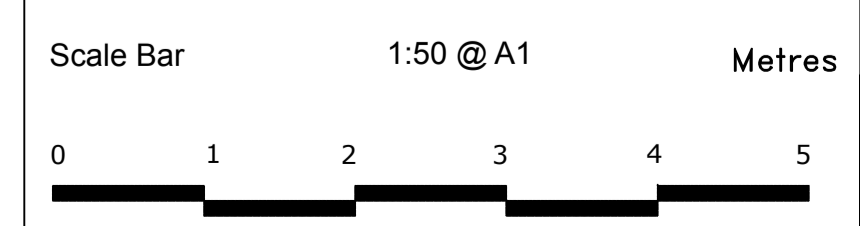

THE GILLETT MACLEOD PARTNERSHIP  
Chartered Architects & Town Planning Consultants  
1 High Road Old Eastcote Pinner Middlesex HA5 2EW tel. 0208 868 1333

Drg. No. 20/3332/21  
Scale 1:50  
Date 16/03/20  
Drawn by VK

REVISION
(C) drawer