
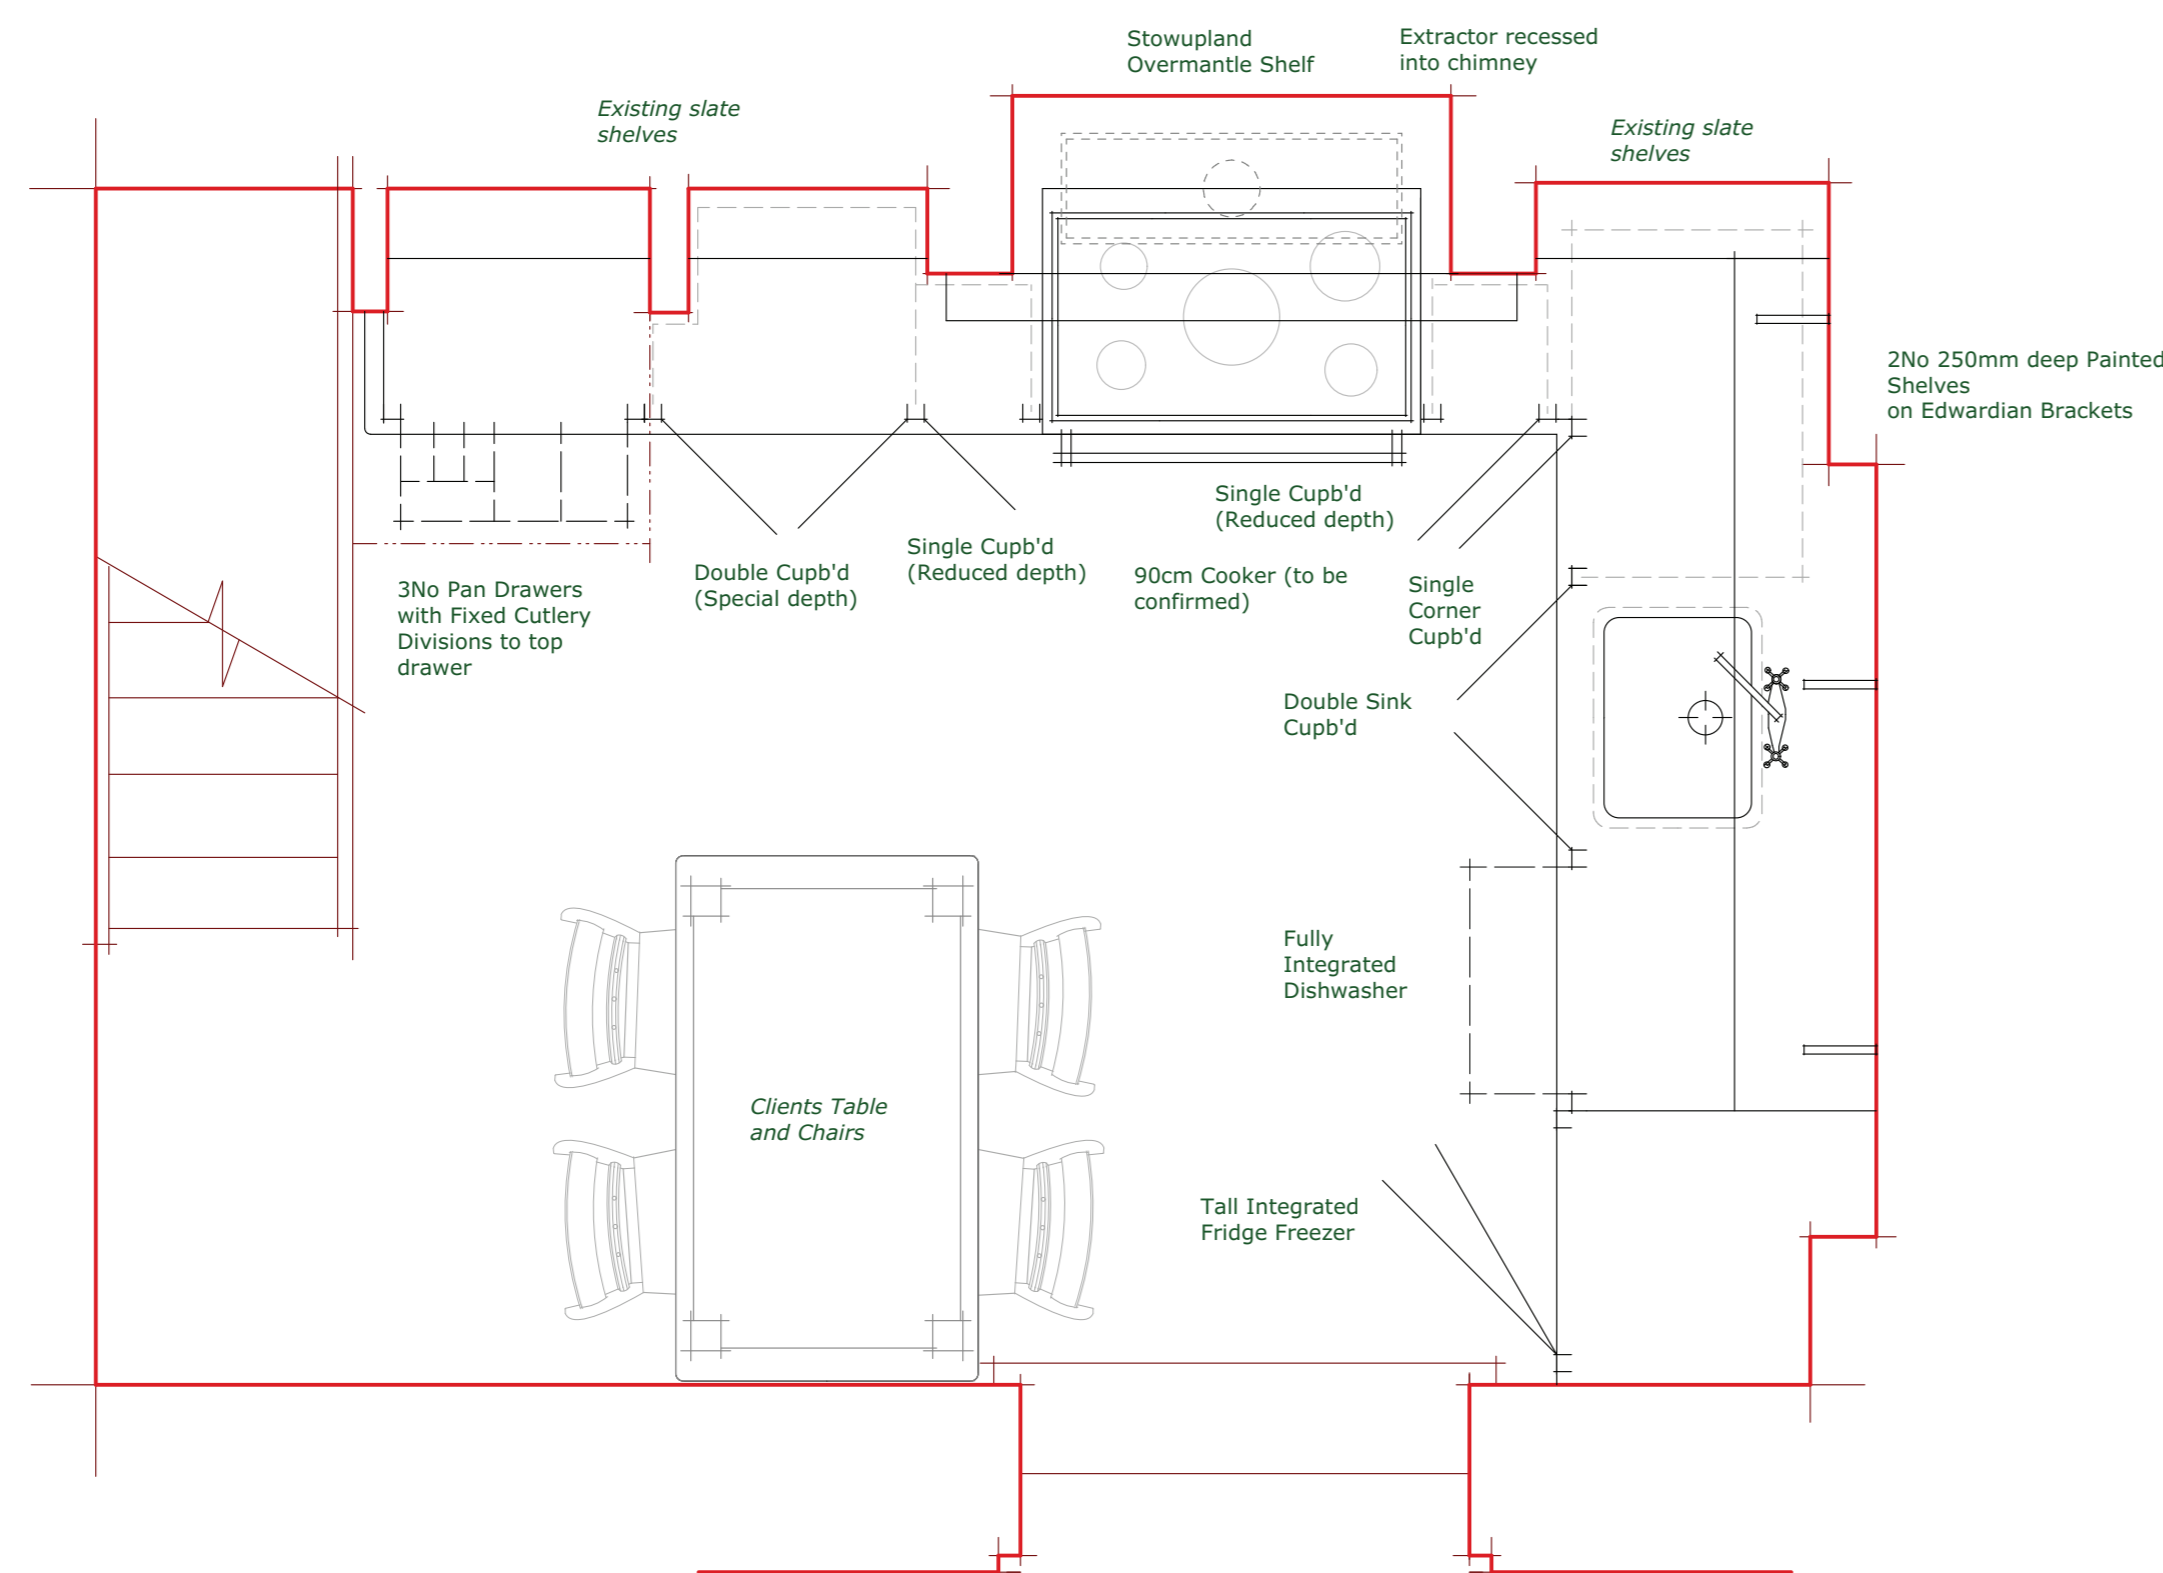
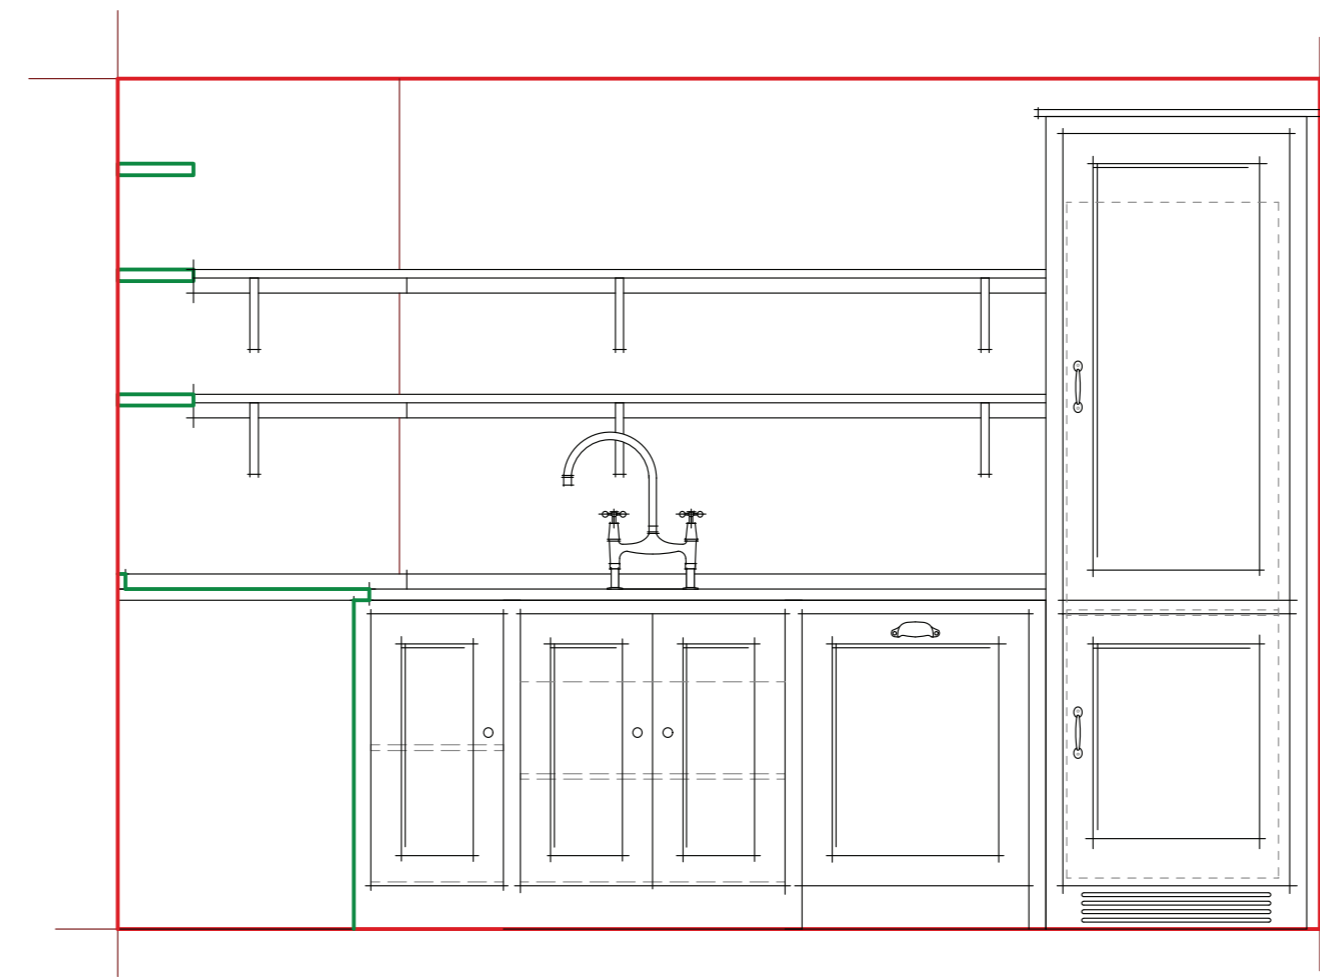


SPECIFICATION

FLOOR CUPBOARDS	
RANGE	Spitalfields
DOORS	Wilkes
INTERIOR	Lacquered Oak Veneer
INTERNAL DETAILS	Classic in Lacquered Oak
TALL CUPBOARDS	
RANGE	Spitalfields
DOORS	Wilkes
INTERIOR	Lacquered Oak Veneer
INTERNAL DETAILS	Classic in Lacquered Oak
IRONMONGERY	To be confirmed by client
END PANELS	Panelled/Plain
GLAZING	N/a
HINGES	Brass
RUNNERS	Metal Soft Close (unless otherwise stated)
RUBBER BASES	N/a
BAIZE LINING	N/a

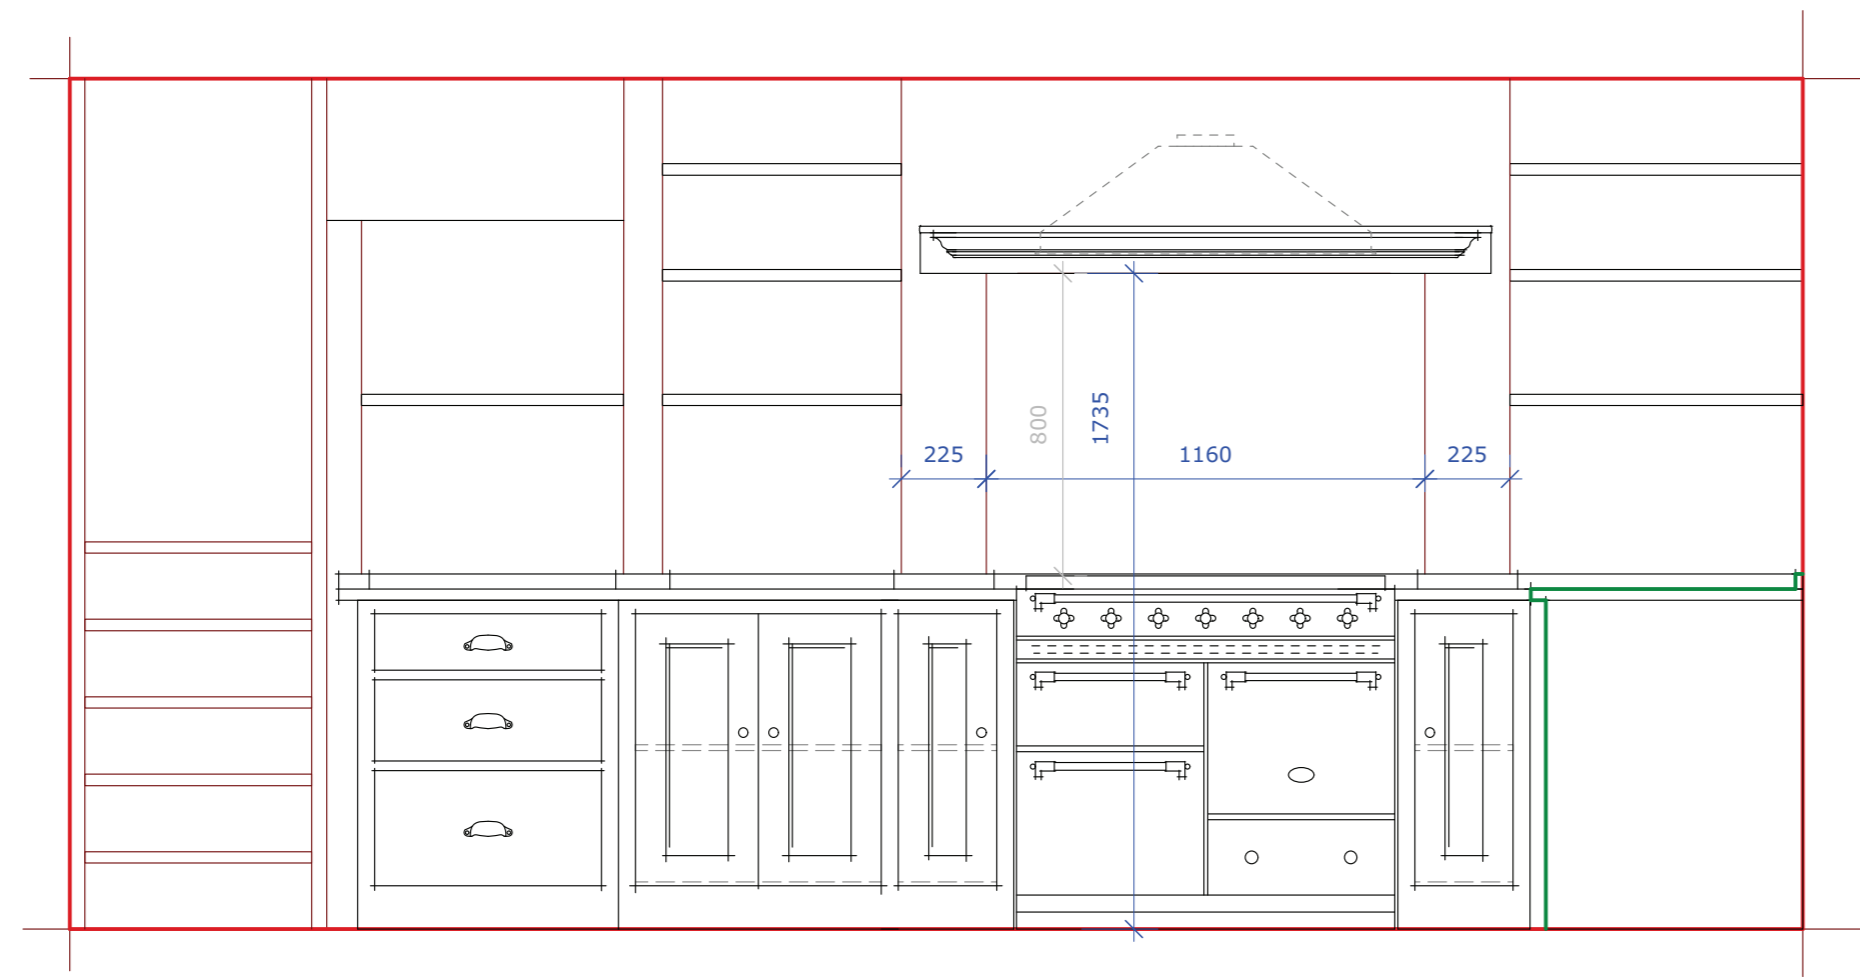

NOTES

- ALL DIMENSIONS ARE SUBJECT TO FINAL SITE SURVEY AND SITE TOLERANCES
- PLUMBING AND ELECTRICAL DETAILS ARE INDICATIVE ONLY AND SHOULD BE READ IN CONJUNCTION WITH THE GENERAL SERVICE NOTES - FINAL POSITIONS TO BE CONFIRMED ONCE LAYOUT HAS BEEN AGREED
- UNDERFLOOR HEATING SHOULD NOT BE FITTED BENEATH P.E JOINERY OR APPLIANCES, A CLEAR 150mm PERIMETER SHOULD BE MAINTAINED
- STONE WORKTOP JOINTS SUBJECT TO TEMPLATING SURVEY
- GENERAL SERVICE SOCKET POSITIONS TO BE AGREED BETWEEN CLIENT AND ELECTRICIAN
- FLOOR STRUCTURE SHOULD BE OF SUITABLE CONSTRUCTION TO SUPPORT WEIGHT OF JOINERY, APPLIANCES AND WORKTOPS

Plain English
CUPBOARDMAKERS

CLIENT	Mr and Mrs Hyams
PROJECT	8 Benhams Place Hampstead London NW3 6QZ
DRAWING TITLE	Kitchen Plan and Elevations
DATE	2 April 2020
SCALE	1:20 at A1
DESIGNER	SP
DRAWN BY	PJD

