




KEY

- Remove redundant riser and/or vending machine enclosure with associated pipework and power / data
- Form new double doorset opening for proposed fire rated access doors to riser cupboard
- Proposed internal pipework route
- Proposed fresh air and extract ducts
- Replace existing ceiling and install new fresh air and extract ductwork within ceiling void
- Proposed plasterboard casing around proposed air ducts

PROPOSED THIRD FLOOR PLAN
(1:50 @ A0)

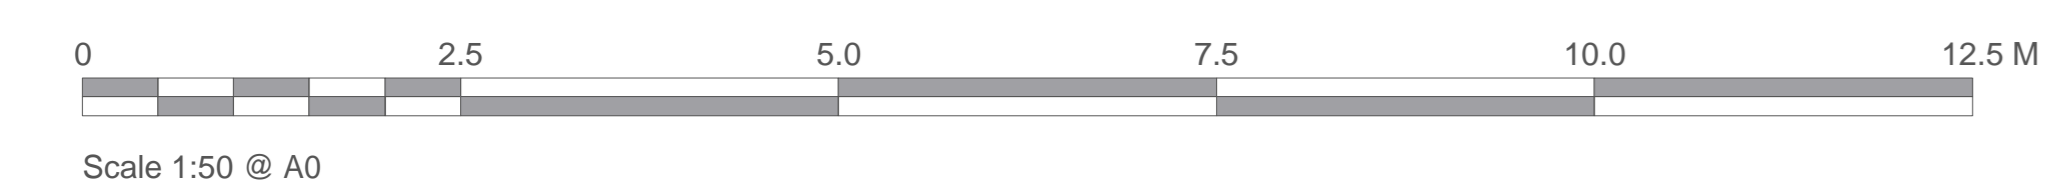

Chartered Architects Chartered Building Surveyors Interior Designers CDM Services		Project Research Block Ventilation	Rev. Date By Ap Note Drawing Title Proposed Third Floor Plan
Client SOAS University of London		Project Number 200171-1406	Drawing Number MM
3 GP Centre, Yeoman Road, Ringwood, Hampshire, BH24 3FF +44 (0)1425 472 833 www.kendallkingscott.co.uk		Date 23/03/20	Status PLANNING
Scale 1:100		Paper Size A0	Filename 200171-LVWX
© Copyright Kendall Kingscott Ltd. Do not scale this drawing. Check all dimensions and levels on site.			

Only to be used on the site for which designed. The electronic transmission of design information contained in this drawing is carried out entirely at the User's risk and Kendall Kingscott Ltd. will have no liability for any errors or inaccuracies arising therefrom. The production of amended or altered information from this drawing is entirely the responsibility of the User and Kendall Kingscott Ltd. shall have no responsibility to inspect third party work.