






Luminaire Schedule		
Layout	Luminaire Description	Image
	Holophane Denver Elite LED Bollard 12W 815lm 4000K DEB.NAJP.L014.PAY.DO.H75.C7.C.MCB.X132.X133 750mm Bollard	

C01	17/08/18	For AFC Submission	FR	PR	SM
P04	27/08/18	TQ Circuit Alterations Road 2	FR	SM	SM
P05	21/12/18	For AFC Submission	FR	SM	SM
C02	21/12/18	For AFC Submission	FR	SM	SM
Rev	Date	Description of Revisions	Drawn	Check	Appr

Status
Fit for Construction

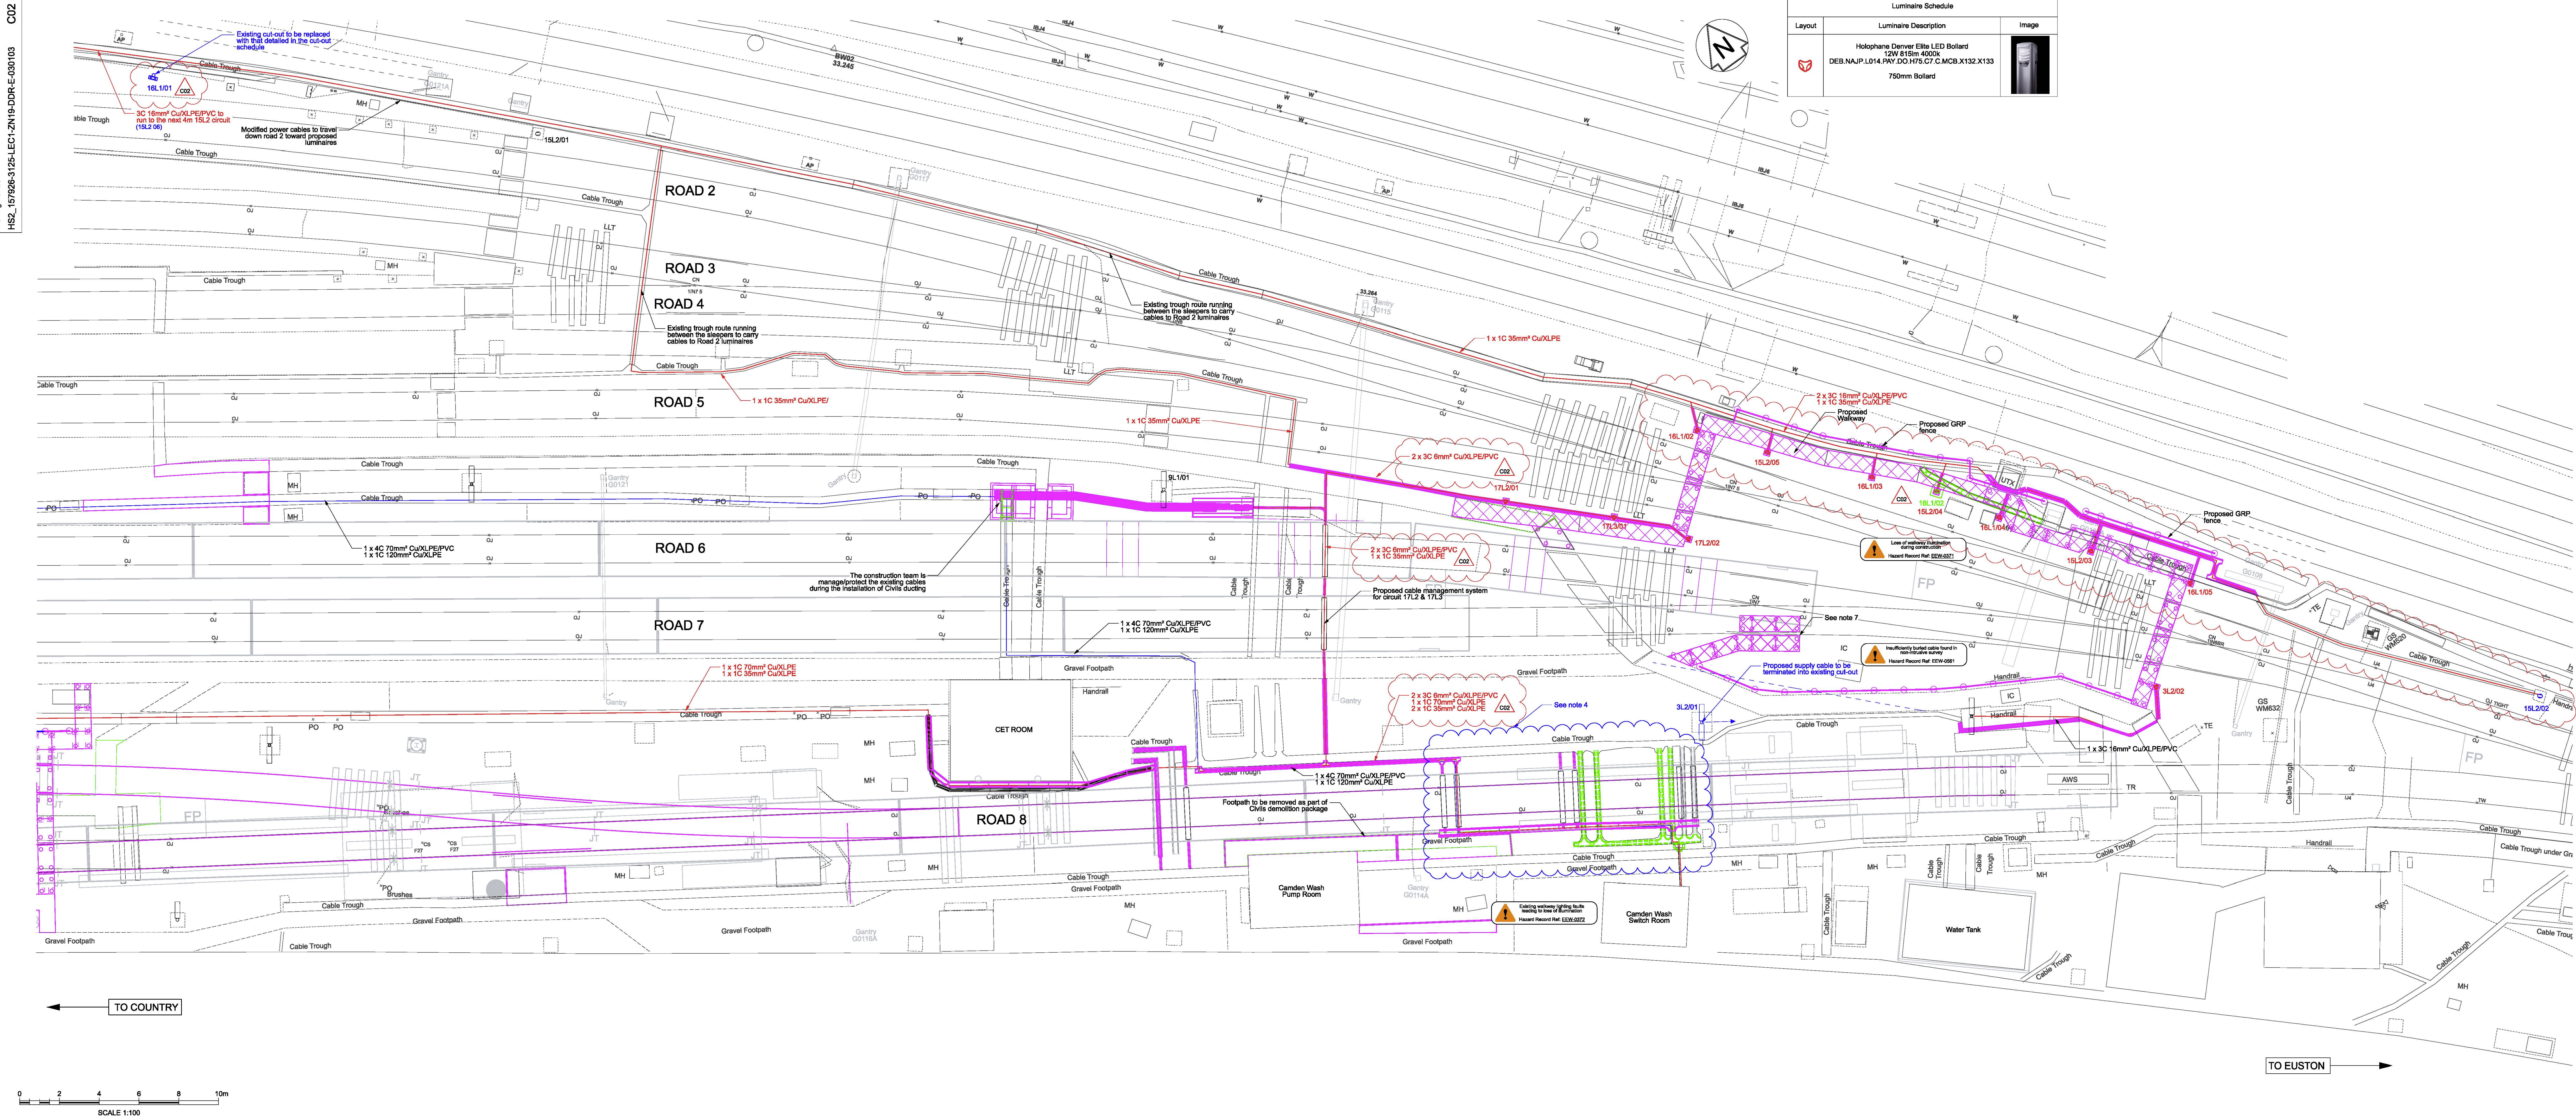

Authorised	C.Pannell	Signed	Electronically Signed	Date	21/12/18
Contract No.	157926				
Contract Title	Camden Carriage Extension				
Drawing Title	Camden Carriage Sidings Final Stage Works Plan E&P LV & Lighting				
Designed	F. Roberts	Signed	Electronically Signed	Date	20/01/18
Drawn	F. Roberts	Signed	Electronically Signed	Date	21/12/18
Checked	S.Mulakala	Signed	Electronically Signed	Date	21/12/18
Approved	S.Mulakala	Signed	Electronically Signed	Date	21/12/18
Scale(s)	1:100	ELR & Misage	LEC1	From	-0.0068
Alternative Reference	HS2_139278-3125-LEC1-ZN19-DDR-E-030103				
Drawing Number	HS2_157926-3125-LEC1-ZN19-DDR-E-030103				
Sheet	3 of 3				
Revision	C02				

 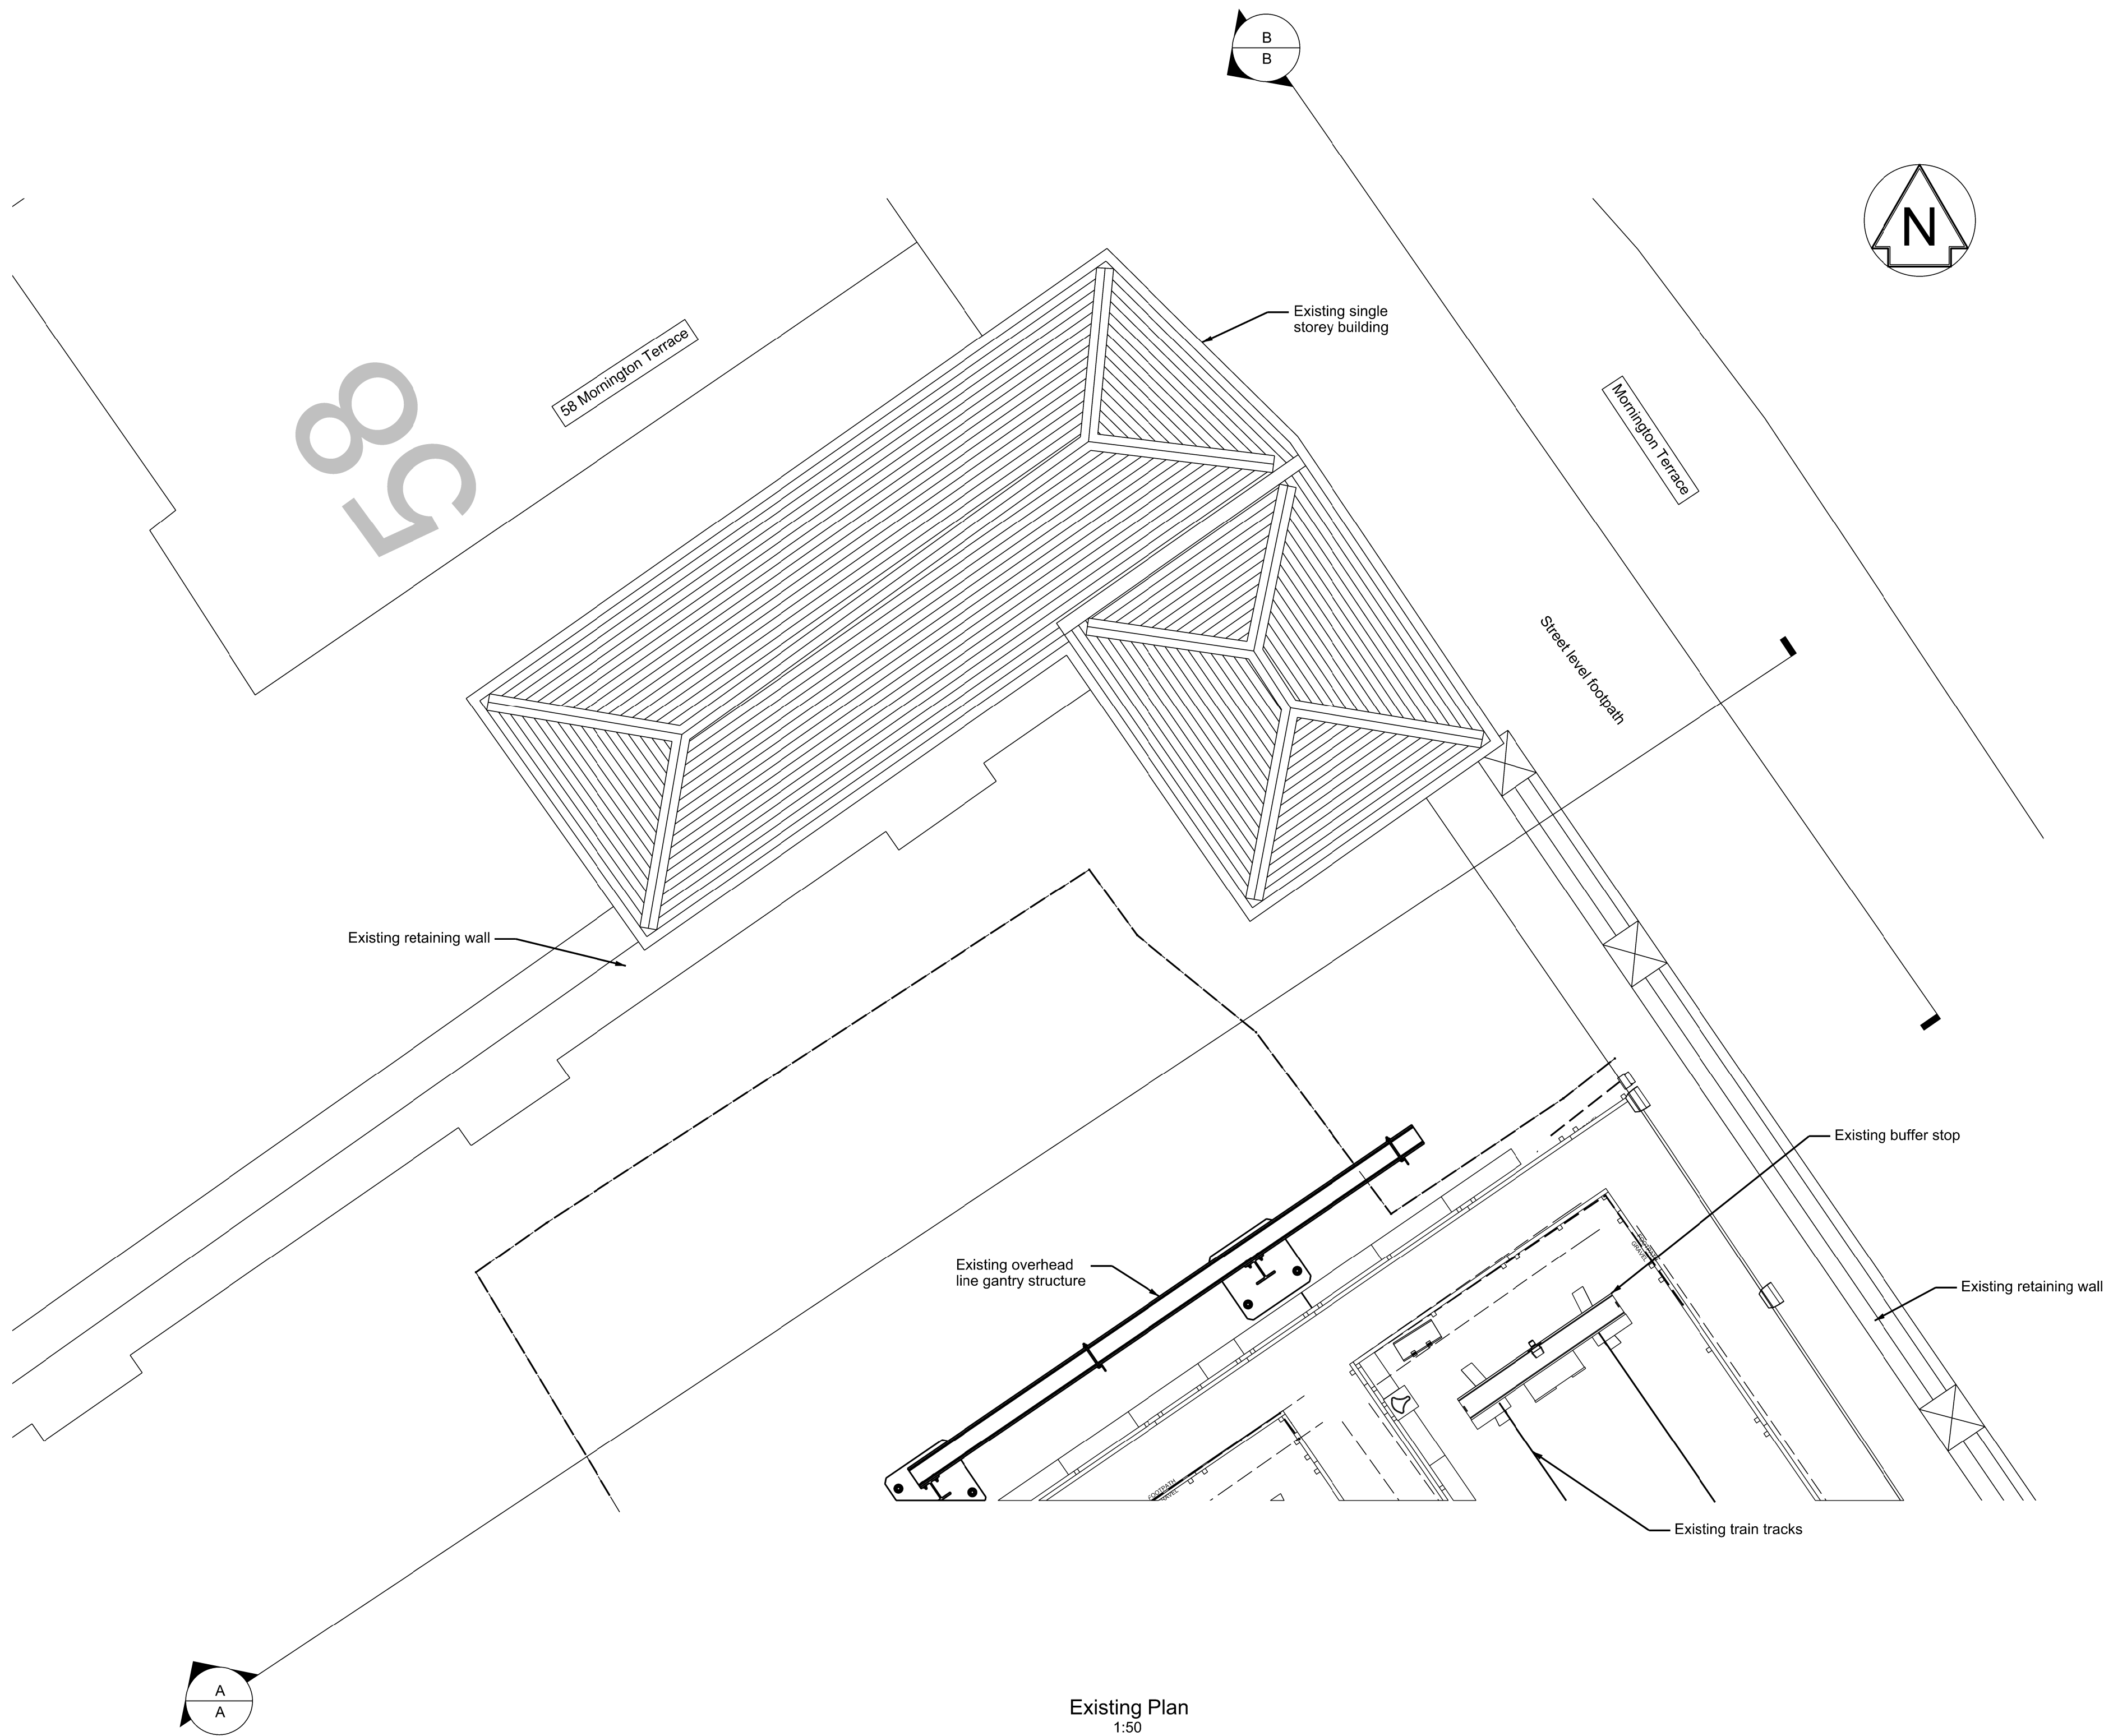

OS map data reproduced by permission of Ordnance Survey on behalf of HMSO. © Crown copyright 2016. All rights reserved. Ordnance Survey licence number 0100040692

Legend/Notes

1. Do not scale from this drawing.

2. All dimensions are in millimetres unless stated otherwise.

P01	05/11/18	For Planning Approval		NT	PP	CC
Rev	Date	Description of Revisions	Drawn	Chkd	Appr	
Status						Suitability
Fit for Information					S2	
NetworkRail						
Authorised			Signed	Electronically Signed		Date
Contractor(s) AECOM Ltd						
Asset Location Location						
Sub-Asset						
Type	CAD Drawing			Sub-Type	Plan	
Role	Civil Engineer			Sub-Role	General	
Location Zone LONDON EUSTON - RUGBY TRENT VALLEY JCN						
Passing	Existing	Grip Stage	4	Withdrawn		
Project HS2 On-Network Works						
Contract No. 158085						
Contract Title Euston Existing Assets Model						
Drawing Title Track Access Point Adjacent to 58 Mornington Terrace Existing Plan						
Designed	C. Chong		Signed	Electronically Signed		Date 01/11/18
Drawn	N.Thompson		Signed	Electronically Signed		Date 05/11/18
Checked	P.Paymani		Signed	Electronically Signed		Date 05/11/18
Approved	C.Chong		Signed	Electronically Signed		Date 05/11/18
Scale(s)	To		ELR & Mileage		To	From
As Shown		LEC1		83.0495		-0.0066
Alternative Reference					Sheet	
Drawing Number HS2_158085-3125-LEC1-ZN18-DDR-C-150005					of Revision P01	

Sheet Size A1 594 x 841