



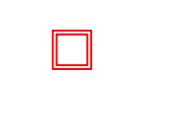
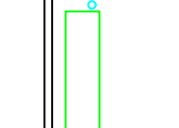
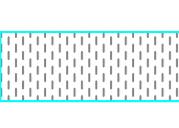
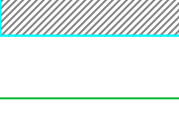
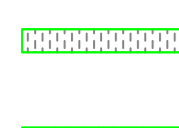

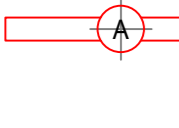


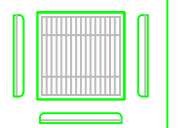


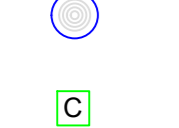




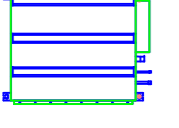








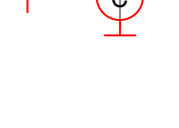

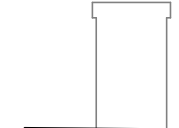
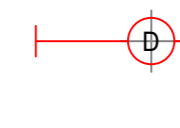
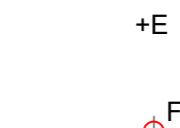
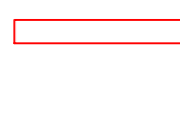


LEGEND

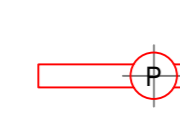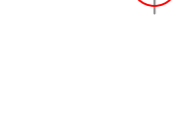-  CEILING MOUNTED AC CASSETTE UNIT
-  GRILLE
-  WALL MOUNTED CONTROLLER
-  CEILING MOUNTED DUCTED FCU
-  VOLUME CONTROL DAMPER
-  ACCESS PANEL
-  CEILING MOUNTED EXTRACT FAN CW NON RETURN DAMPER
-  FLOOR MOUNTED CONCEALED FCU WITH BOXING
-  HIGH LEVEL REFRIGERANT (DX) TRAY WORK
-  LOW LEVEL REFRIGERANT (DX) TRAY WORK
-  CONDENSATE PIPEWORK
-  ELECTRIC PANEL HEATER
-  CABLE TRAY - SIZE AS NOTED SUSPENDED 280mm AFFL UNLESS SHOWN OTHERWISE
-  25mm STEEL CONDUIT FIXED TO CEILING SLAB WITH PROPRIETARY SADDLES MAX 1 METRE INTERVALS
-  50mm CABLE TRAY FOR FUTURE DOOR ENTRY SYSTEM
-  50mm FIRE ALARM CABLE TRAY
-  SUSPENDED 1482 LONG 4000mm 3000K LINEAR UP/DOWNLIGHT LUMINAIRE FINISHED IN BLACK AND FITTED WITH DALI DRIVER - MICROPRISMATIC + OPAL DIFFUSER - REF: KB LIGHTING SWAN 23844331-UDMPO3K/DALI/ISK
-  SURFACE-MOUNTED LINEAR LUMINAIRE FIXED TO BEAM, BRACKETS TO ALLOW SIDEWAYS FIXING OF LUMINAIRE. LUMINAIRE TO BE 3000K COLOUR TEMPERATURE, APPROX 1000mm OUTPUT, FINISHED IN BLACK AND BE FITTED WITH MPO DIFFUSER - REF: KB LIGHTING SWAN 4062-S-MPO3K/DALI
-  IMPACT-RESISTANT IP65 RATED 1100mm LINEAR LUMINAIRE WITH INTEGRAL SENSOR, 4000K COLOUR TEMPERATURE 2900lm LED LIGHT SOURCE MOUNTED ON WALL AT BASE OF CURVED VAULT ROOF - REF: THORN AQUAFORCE PRO LED 2900 - 840PC MB MWCF 96630986
-  SURFACE-MOUNTED 1482mm LONG 3000K LINEAR LUMINAIRE WITH DOWNLIGHT COMPONENT ONLY, FINISHED IN BLACK WITH DALI DRIVER AND MICROPRISMATIC & OPAL DIFFUSER - REF: KB LIGHTING SWAN 23844331-S-MPO3K/DALI
-  LUMINAIRE WITH 3 HOURS EMERGENCY BATTERY BALLAST 75mm DIAMETER RECESSED CIRCULAR IP44 RATED 559lm 3000K LED DOWNLIGHT WITH BLACK BEZEL AND BAFFLE - REF: KB LIGHTING SWAN 9663410B/K/DALI
-  SUSPENDED CONTINUOUS 3000K BLACK LINEAR LUMINAIRE WITH OPAL DIFFUSER, APPROX 1800mm - REF: KB LIGHTING SWAN 4062/3K/DALI/ISK
-  872mm 2470mm 3000K SUSPENDED LINEAR UP/DOWNLIGHT LUMINAIRE FINISHED IN BLACK AND FITTED WITH DALI DRIVER - MICROPRISMATIC + OPAL DIFFUSER - REF: KB LIGHTING SWAN 23844320-MPO3K/DALI/ISK
-  CEILING-MOUNTED LUMINAIRE, ARCHITECT'S CHOICE
-  285mm DIAMETER 900mm 4000K WALL-MOUNTED CIRCULAR BULKHEAD LUMINAIRE WITH 3 HOURS EMERGENCY BATTERY BACK-UP AND INTEGRAL MOTION SENSOR - REF: THORN LIGHTING EYEKON LED CR MVS E3 S ANT 9666 5877
-  SUSPENDED 872mm 1600mm 3000K BLACK LINEAR DOWNLIGHT LUMINAIRE WITH OPAL DIFFUSER - REF: KB LIGHTING SWAN 23844319-4062/3K/DALI/ISK
-  SUSPENDED 1482mm 2684mm 3000K BLACK LINEAR LUMINAIRE WITH OPAL DIFFUSER - REF: KB LIGHTING SWAN 23844330-4062/3K/DALI/ISK
-  SUSPENDED 1150mm 3000mm 3000K BLACK LINEAR DOWNLIGHT LUMINAIRE WITH MICROPRISMATIC + OPAL DIFFUSER - REF: KB LIGHTING SWAN 23844325-MPO3K/DALI/ISK
-  NON-MAINTAINED ESCAPE SIGN WITH 3 HOURS EMERGENCY BATTERY BACK-UP - REF: THORN VOYAGER ONE MS AND E3D WH IP65 96631598 + 116 MS SM-S 96631604 + ANT HC LENS 96631631
-  SMOKE DETECTOR
-  SMOKE DETECTOR WITH INTEGRAL SOUNDER AND VISUAL ALERT DEVICE
-  SURFACE-MOUNTED PASSIVE INFRA-RED MOTION SENSOR FIXED TO UNDERSIDE OF TRAY OR SLAB
-  SURFACE-MOUNTED PASSIVE INFRA-RED MOTION SENSOR WITH DAYLIGHT-SENSING OVERRIDE FIXED TO UNDERSIDE OF TRAY OR SLAB



First Floor
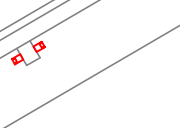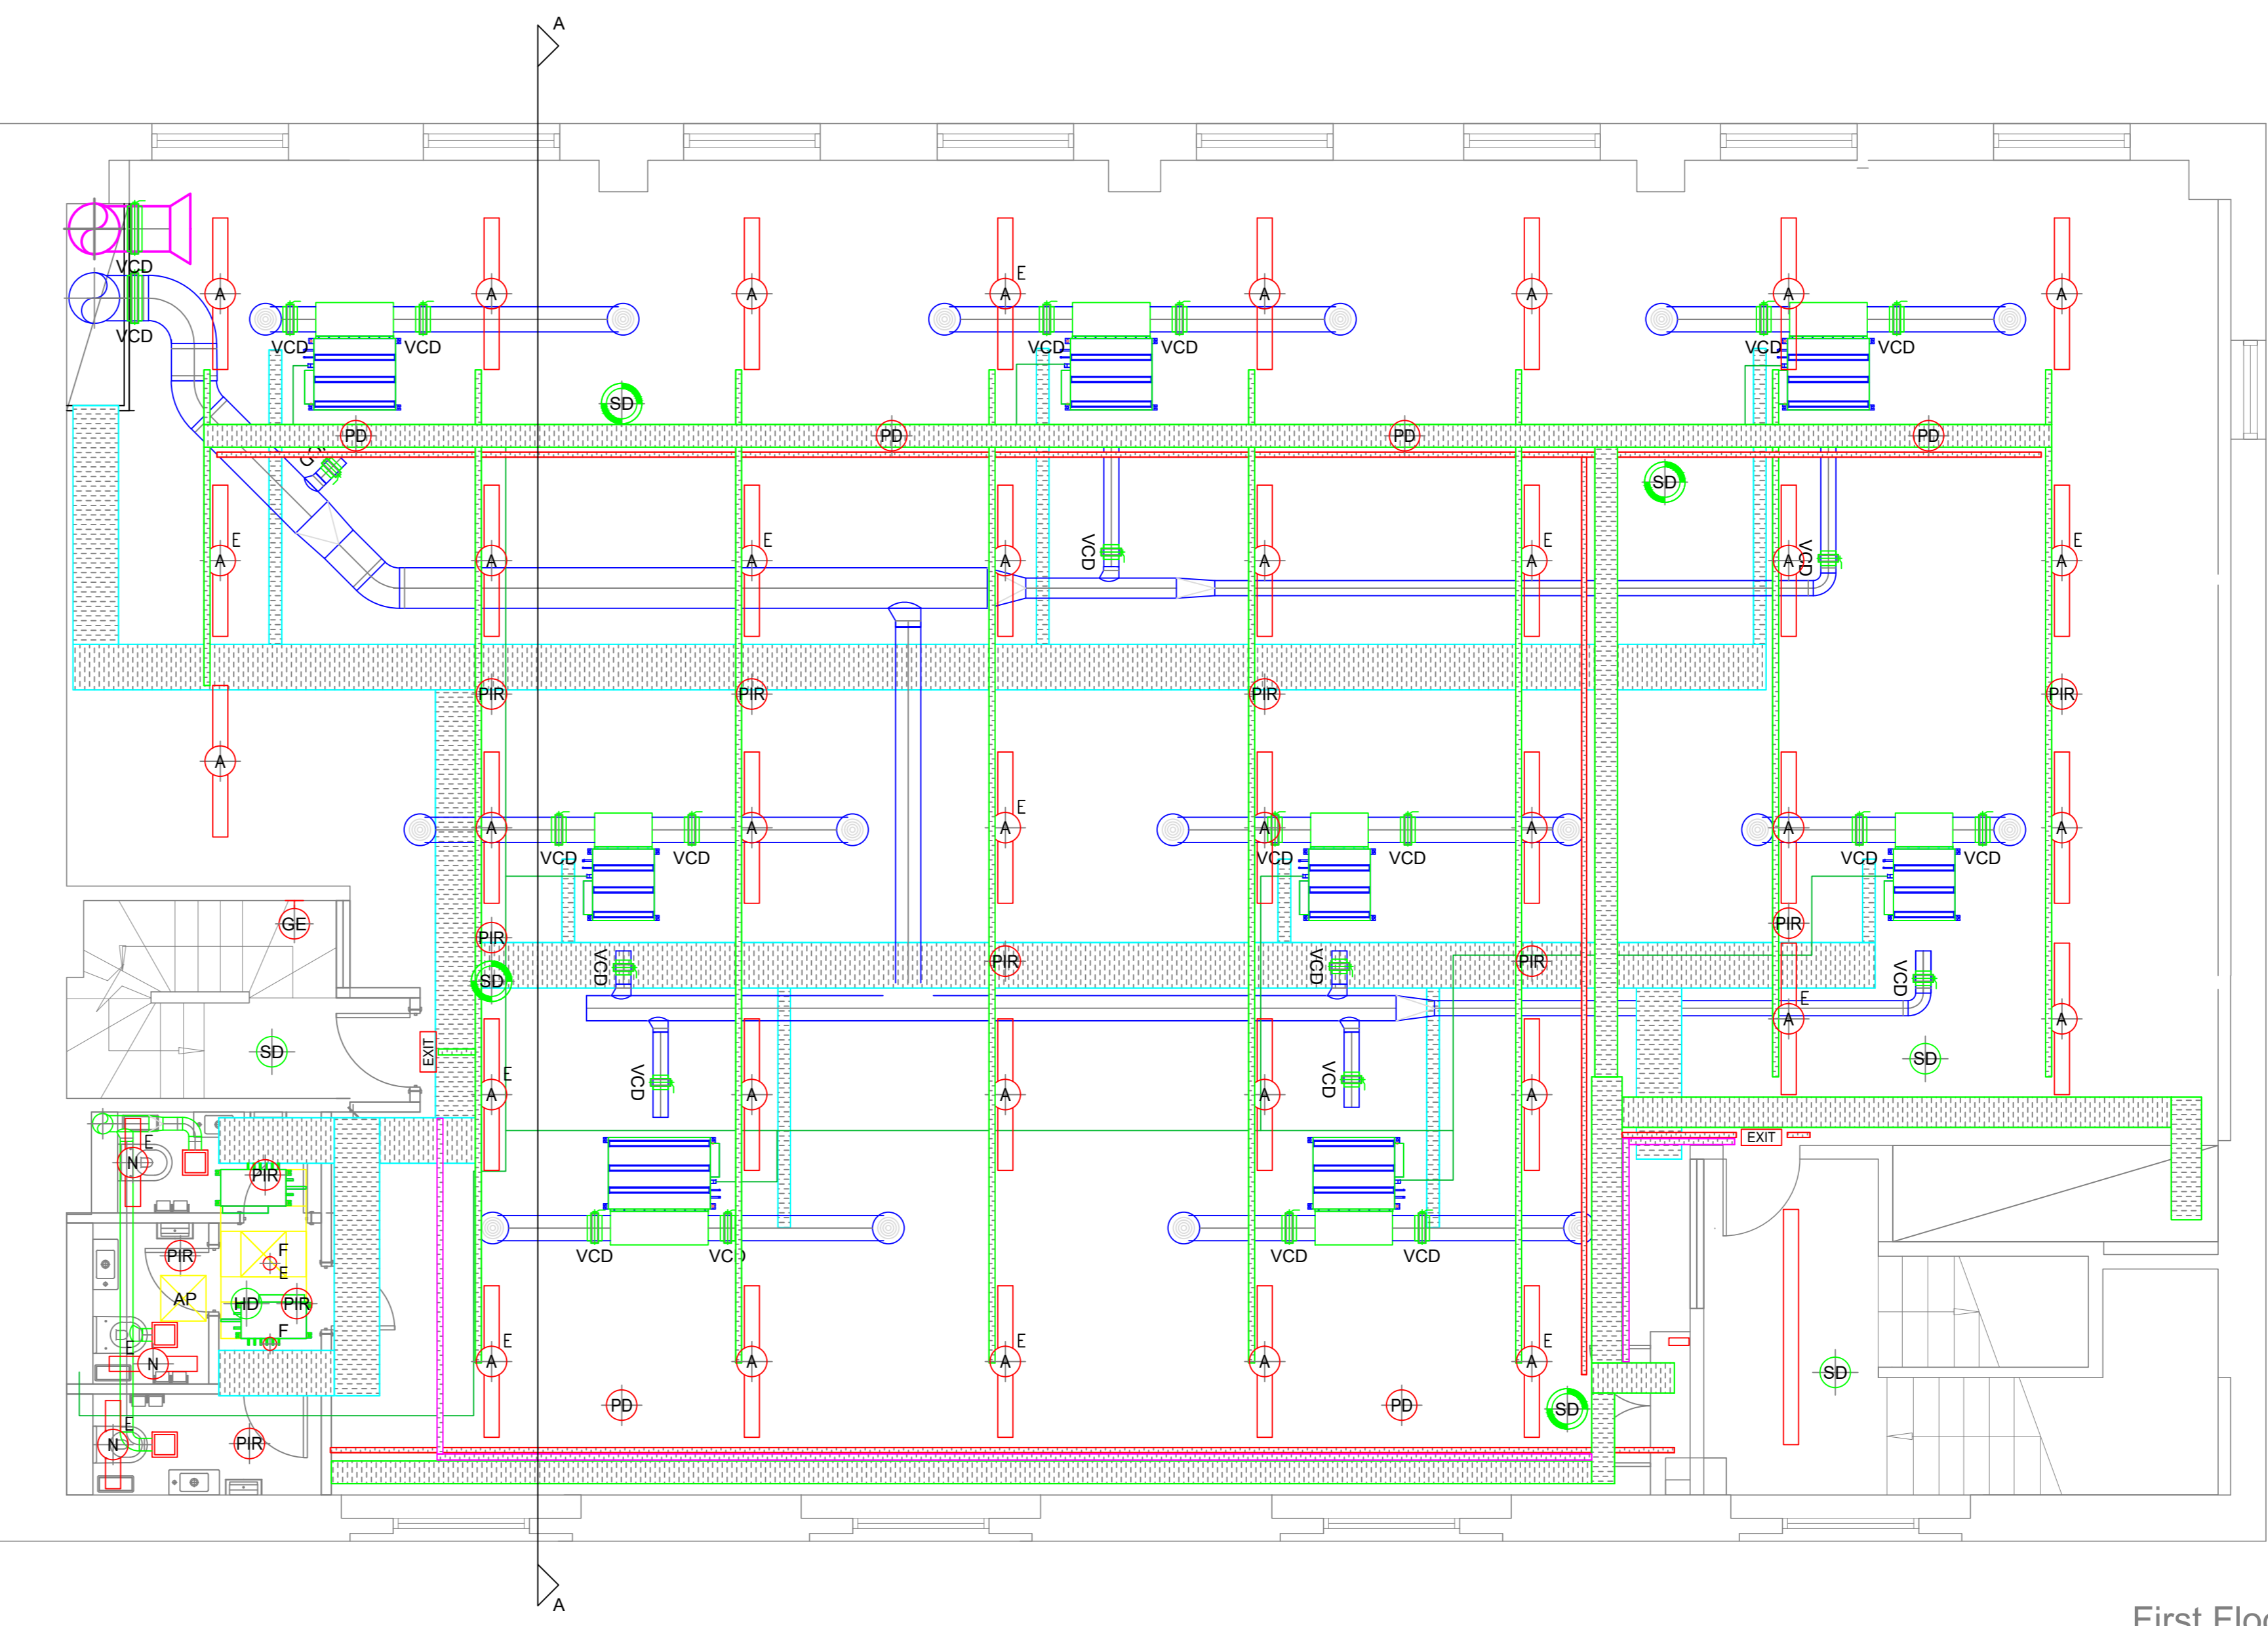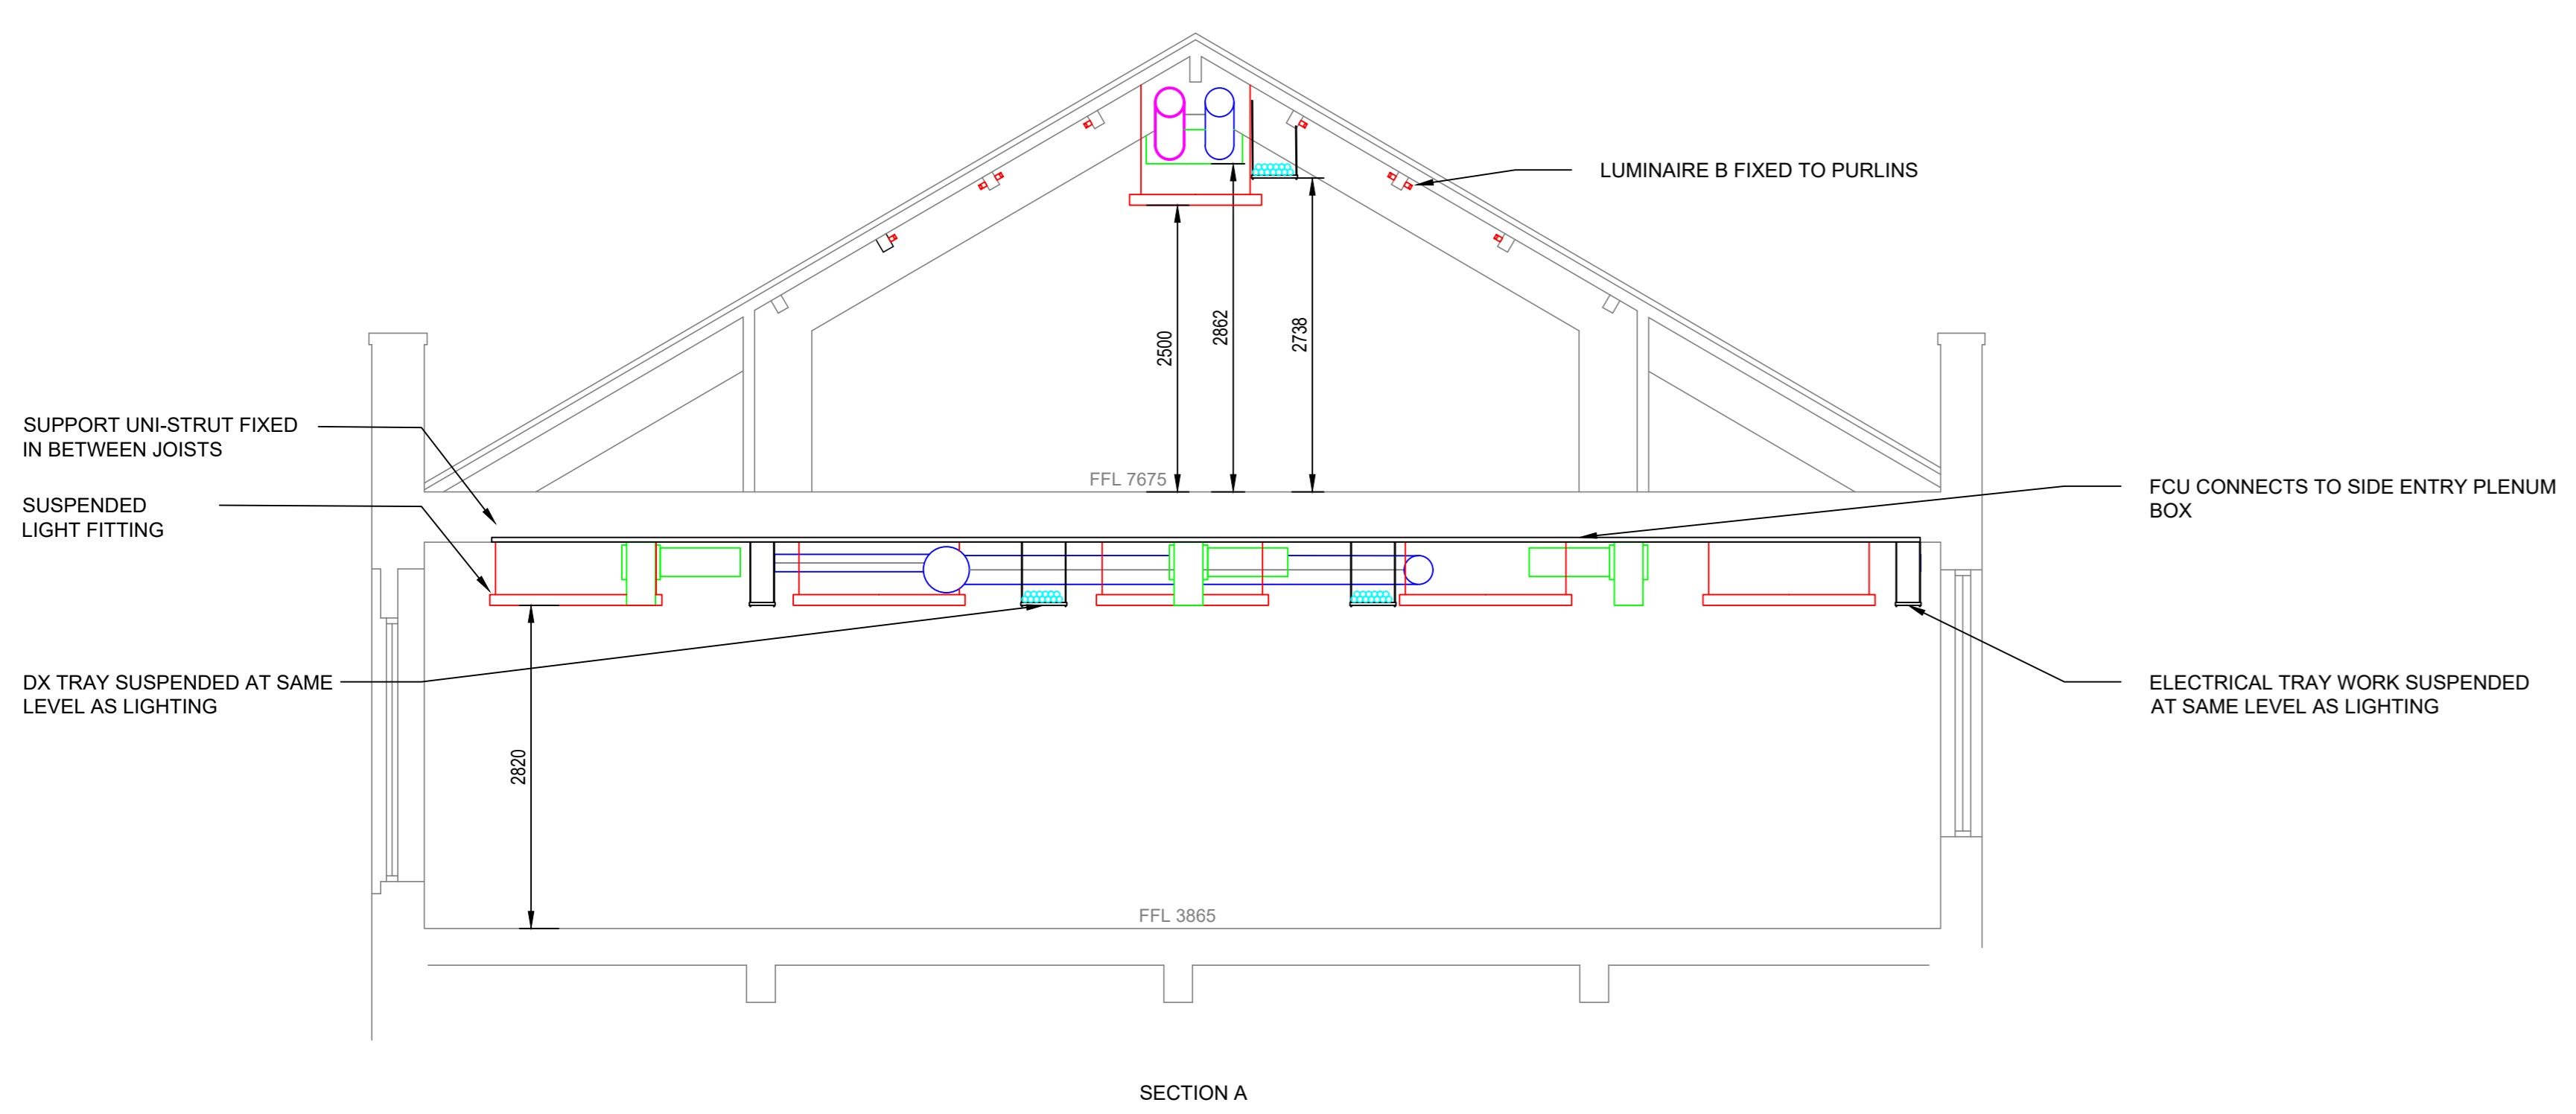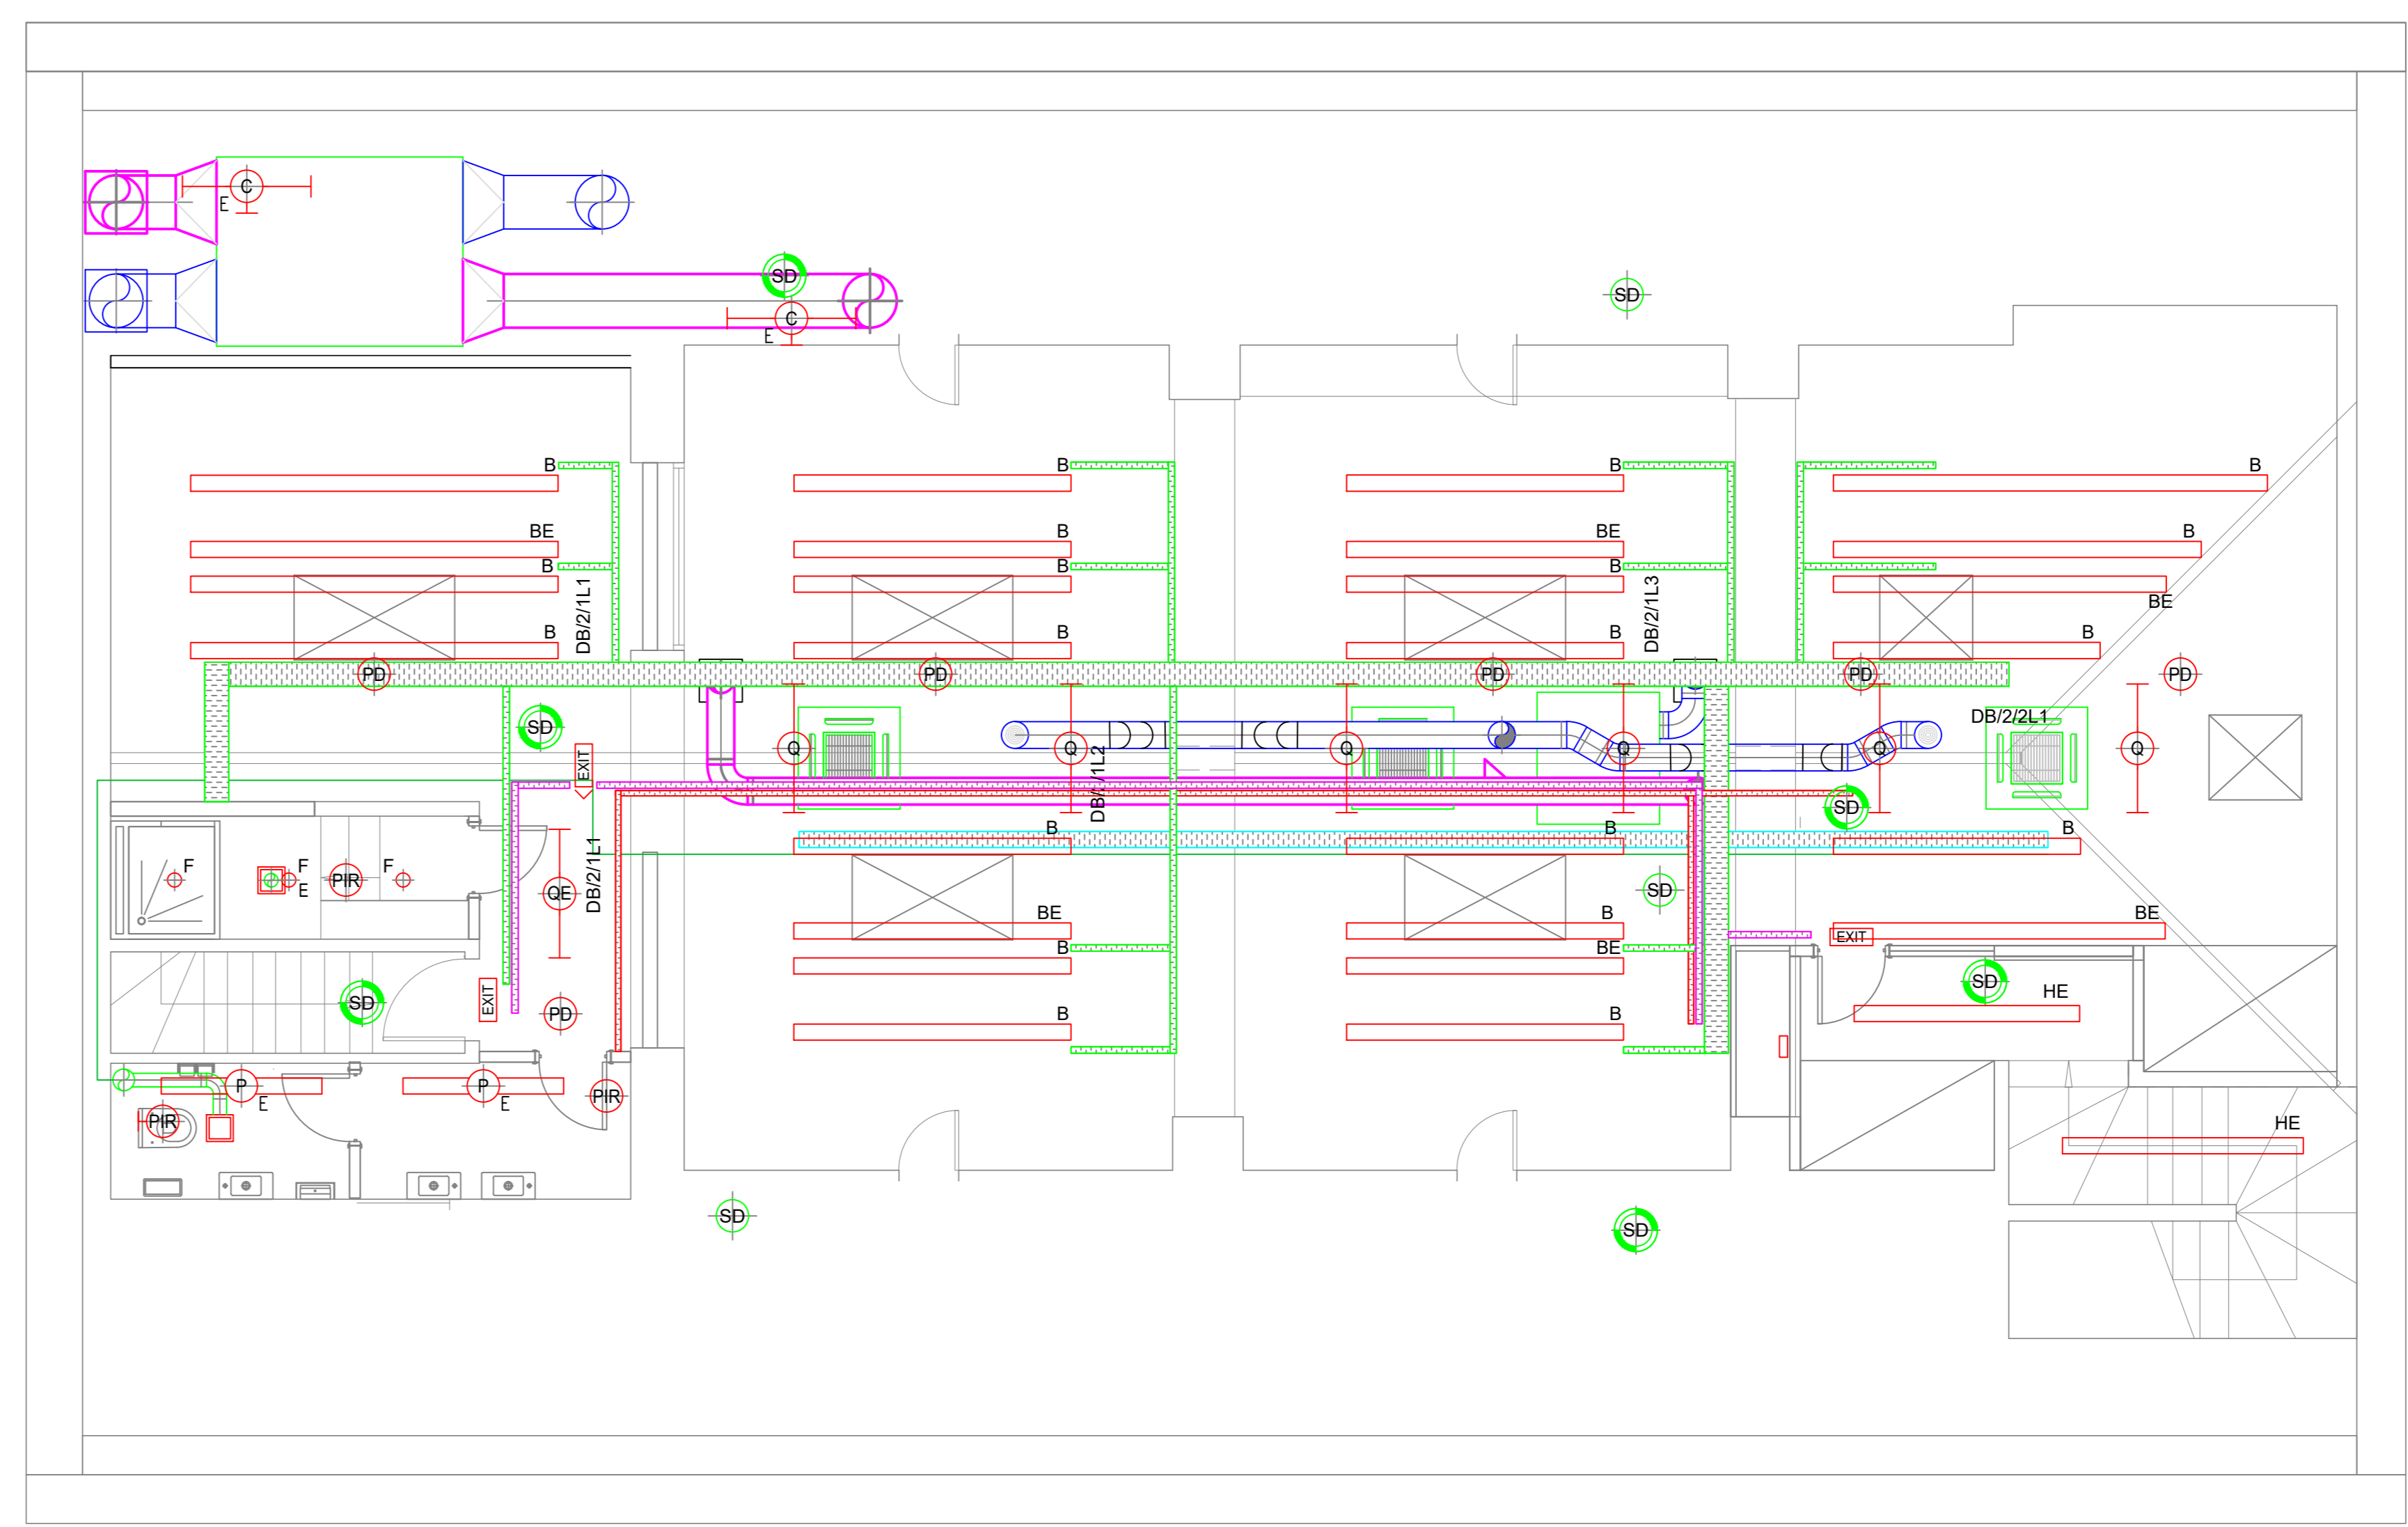
| | | |
|-----|----------|-------------------------|
| T1 | 31/03/20 | FOR TENDER |
| A | 19/03/20 | UPDATED LIGHTING LAYOUT |
| REV | DATE | DESCRIPTION |

GREEN BUILDING DESIGN CONSULTANTS
 Building Services Consulting Engineers
 FOUR RIVERS HOUSE FENTIMAN WALK HERTFORD HERTS SG14 1DB
 TEL: 01992 552111 FAX: 01992 581212 WEB: www.gbuild.co.uk

WEST STREET TRUSTEES LTD
 Client
 Designed/Drawn: JD Scale: 1:50 @ A0
 Checked: HD Date: FEB 2020
 Site Location: 24 - 26 WEST STREET LONDON WC2H 9NA
 Title: FIRST & SECOND FLOORS COORDINATED LAYOUT
 Status: **FOR TENDER**
 Dwg No: **5582-M-302** Rev: **T1**