


NOTES:

DO NOT SCALE FROM THIS DRAWING

- WHERE THE CONTRACTOR UNDERTAKES OR ENGAGES A THIRD PARTY TO UNDERTAKE TEMPORARY WORKS DESIGN, OR VARIES THE PELL FRISCHMANN DESIGN IN ANY WAY, THEN THE CONTRACTOR WILL TAKE FULL RESPONSIBILITY AND LIABILITY FOR ALL DESIGN ASPECTS, INCLUDING A DESIGN RISK ASSESSMENT. THE CONTRACTOR SHALL INFORM PELL FRISCHMANN OF ANY PROPOSED VARIANCES TO THE DESIGN.
- THIS DRAWING SHALL BE READ IN CONJUNCTION WITH ALL OTHER ELECTRICAL, MECHANICAL, PUBLIC HEALTH & ARCHITECTURAL DRAWINGS & THE SPECIFICATION.
- ALL DIMENSIONS ARE IN MILLIMETERS (mm) AND LEVELS IN METERS (m) UNLESS NOTED OTHERWISE.

KEY:

→ SURFACE WATER FLOW DIRECTION

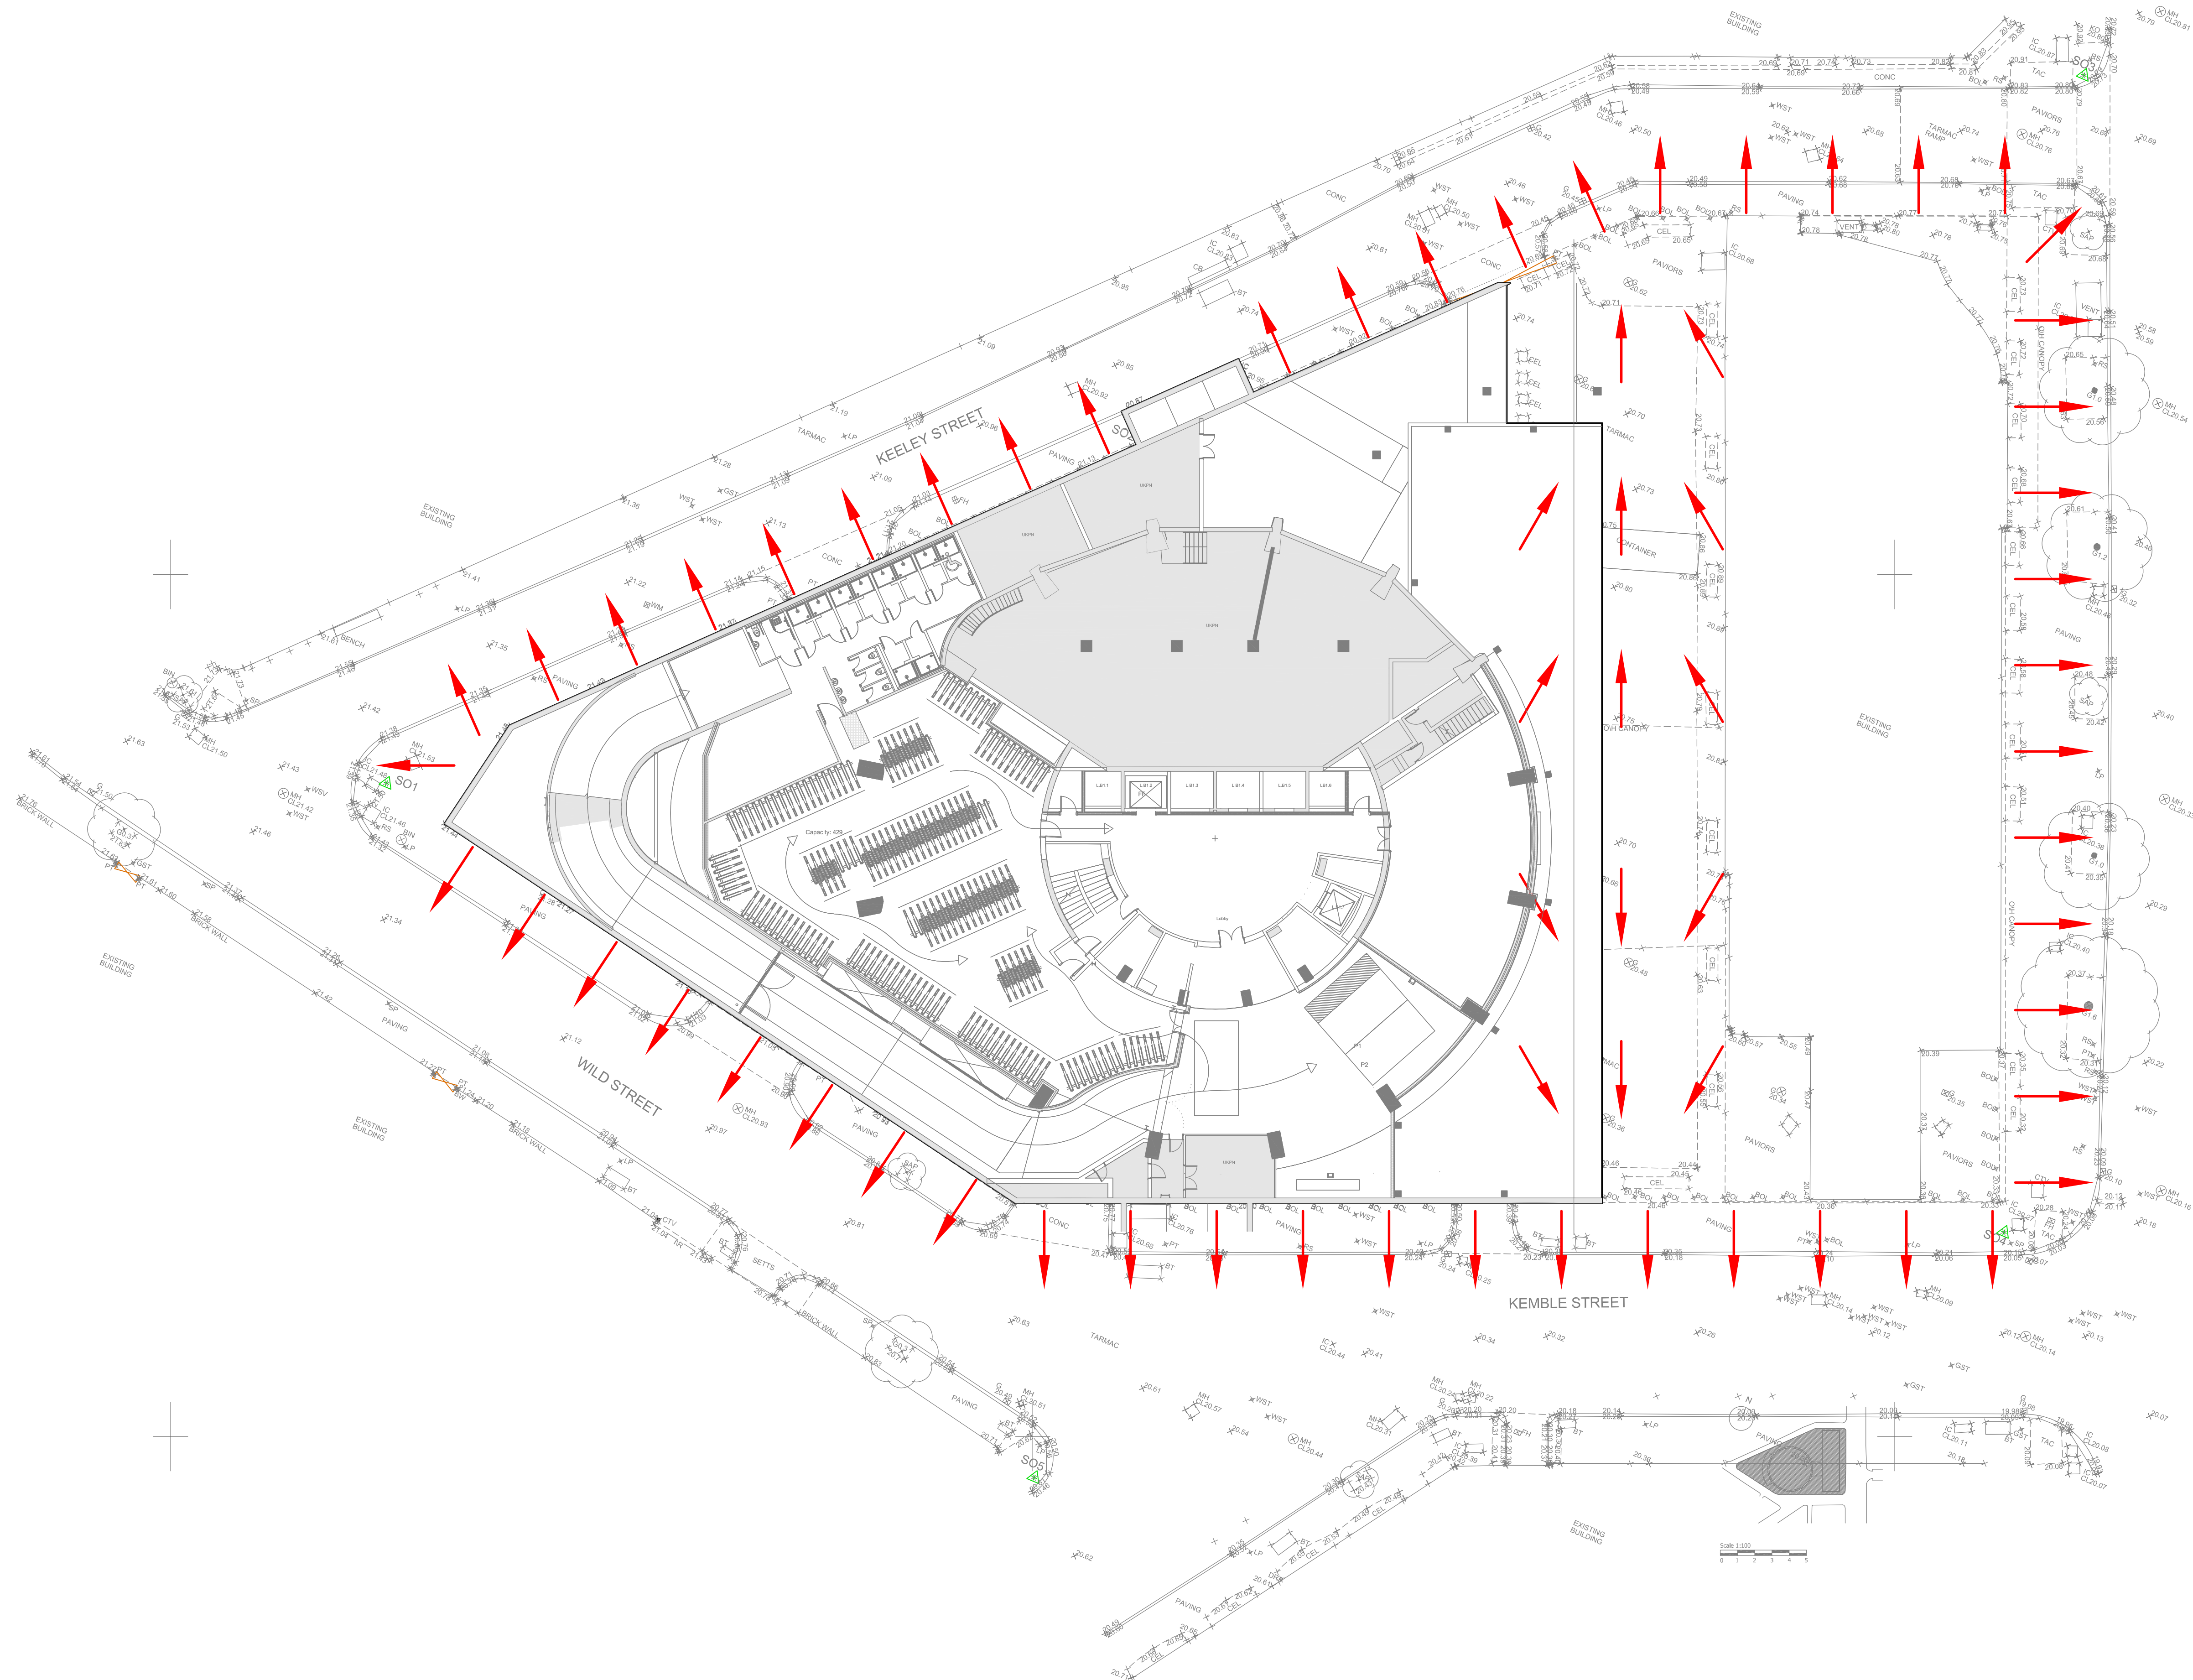

P02	RED LINE BOUNDARY REMOVED	GRH	RW	RW	24.04.20
P01	INITIAL ISSUE	GRH	RW	RW	09.04.20
REV	DESCRIPTION	DRN	CHK	APP	DATE

Pell Frischmann

5 MANCHESTER SQUARE LONDON W1U 3PD

Telephone +44 (0)20 7486 3661
Email: pflondon@pellfrischmann.com
www.pellfrischmann.com

Architect
SQUIRE & PARTNERS

Project
**SPACE HOUSE
SEAFORTH LAND**

Drawing Title
**GROUND FLOOR
DRAINAGE LAYOUT
SURFACE WATER FLOWS**

	Name	Date	Scale	1:200 @ A1
Drawn	GRH	08.04.20		
Designed	GRH	08.04.20	File No.	101478-PF-SH-00-DR-D-0002.dwg
Checked	RW	08.04.20	Drawing Status	
Approved	RW	08.04.20		

Drawing No. **101478-PF-SH-00-DR-D-0002** Revision **P02**