



NOTE:
FOR DETAIL AND SETTING OUT INFORMATION, PLEASE REFER
TO KIER MECHANICAL & ELECTRICAL LOGGIA LIGHTING
CONTAINMENT INFORMATION

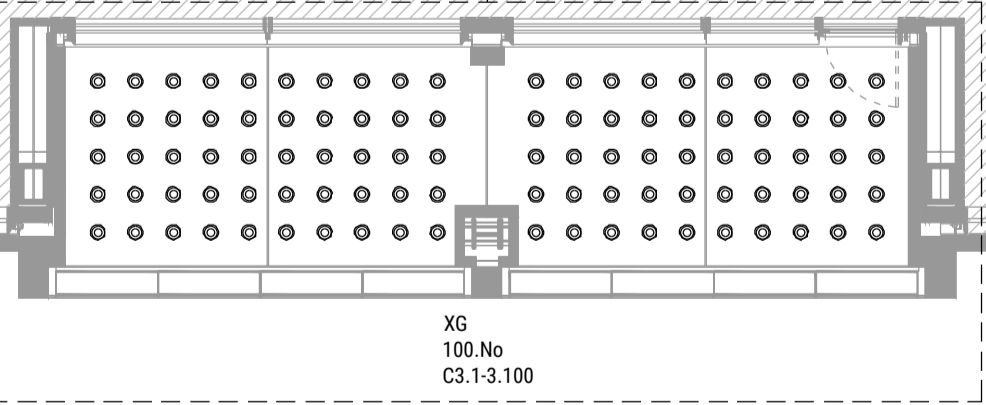

Project Client:
Argent

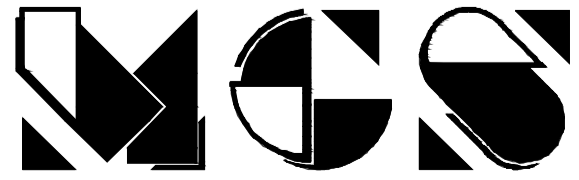

Michael Grubb Studio Ltd
Bryanstone Road, Bournemouth, BH3 7JE
t: +44 (0)1202 511 005
e: info@michaelgrubbstudio.com
www.michaelgrubbstudio.com

Drawing information:

1. Do not scale from this drawing.
2. This drawing should be read in conjunction with the current set of luminaire specification sheets and Schedules.
3. Exact luminaire locations will be confirmed prior to the commencement of works on site.
4. Luminaire lengths and dimensions should not be taken from this plan. Dimensions are for Michael Grubb Studio estimated pricing purposes only. It is the Contractor's responsibility to ensure the correct lengths are measured on site prior to ordering.
5. The 'C?' number located within each reference represents the 'control circuit' only. This may not be the same as the actual wiring circuit.
6. If in doubt, ASK!

Notes:

1. Final lighting details to be agreed with Architect, Client and Contractor.

Revisions:

- 01 - Revisions inline with Loggia Lighting Containment and Fabrication.

Key:

XG - Soffit recessed Downlight Luminaire.

Project:

Building P2 Exterior Lighting, London, UK
Drawing:
Second Floor
High Level Lighting Layout Plan

Purpose of drawing: Stage 4
Scale: 1:50 on A1
1:100 on A3

Drawn: SH
Checked: MW
Date: 17th April 2020

Drawing reference: KXC-P2-001-J-P0944-63-102
Rev: 01