


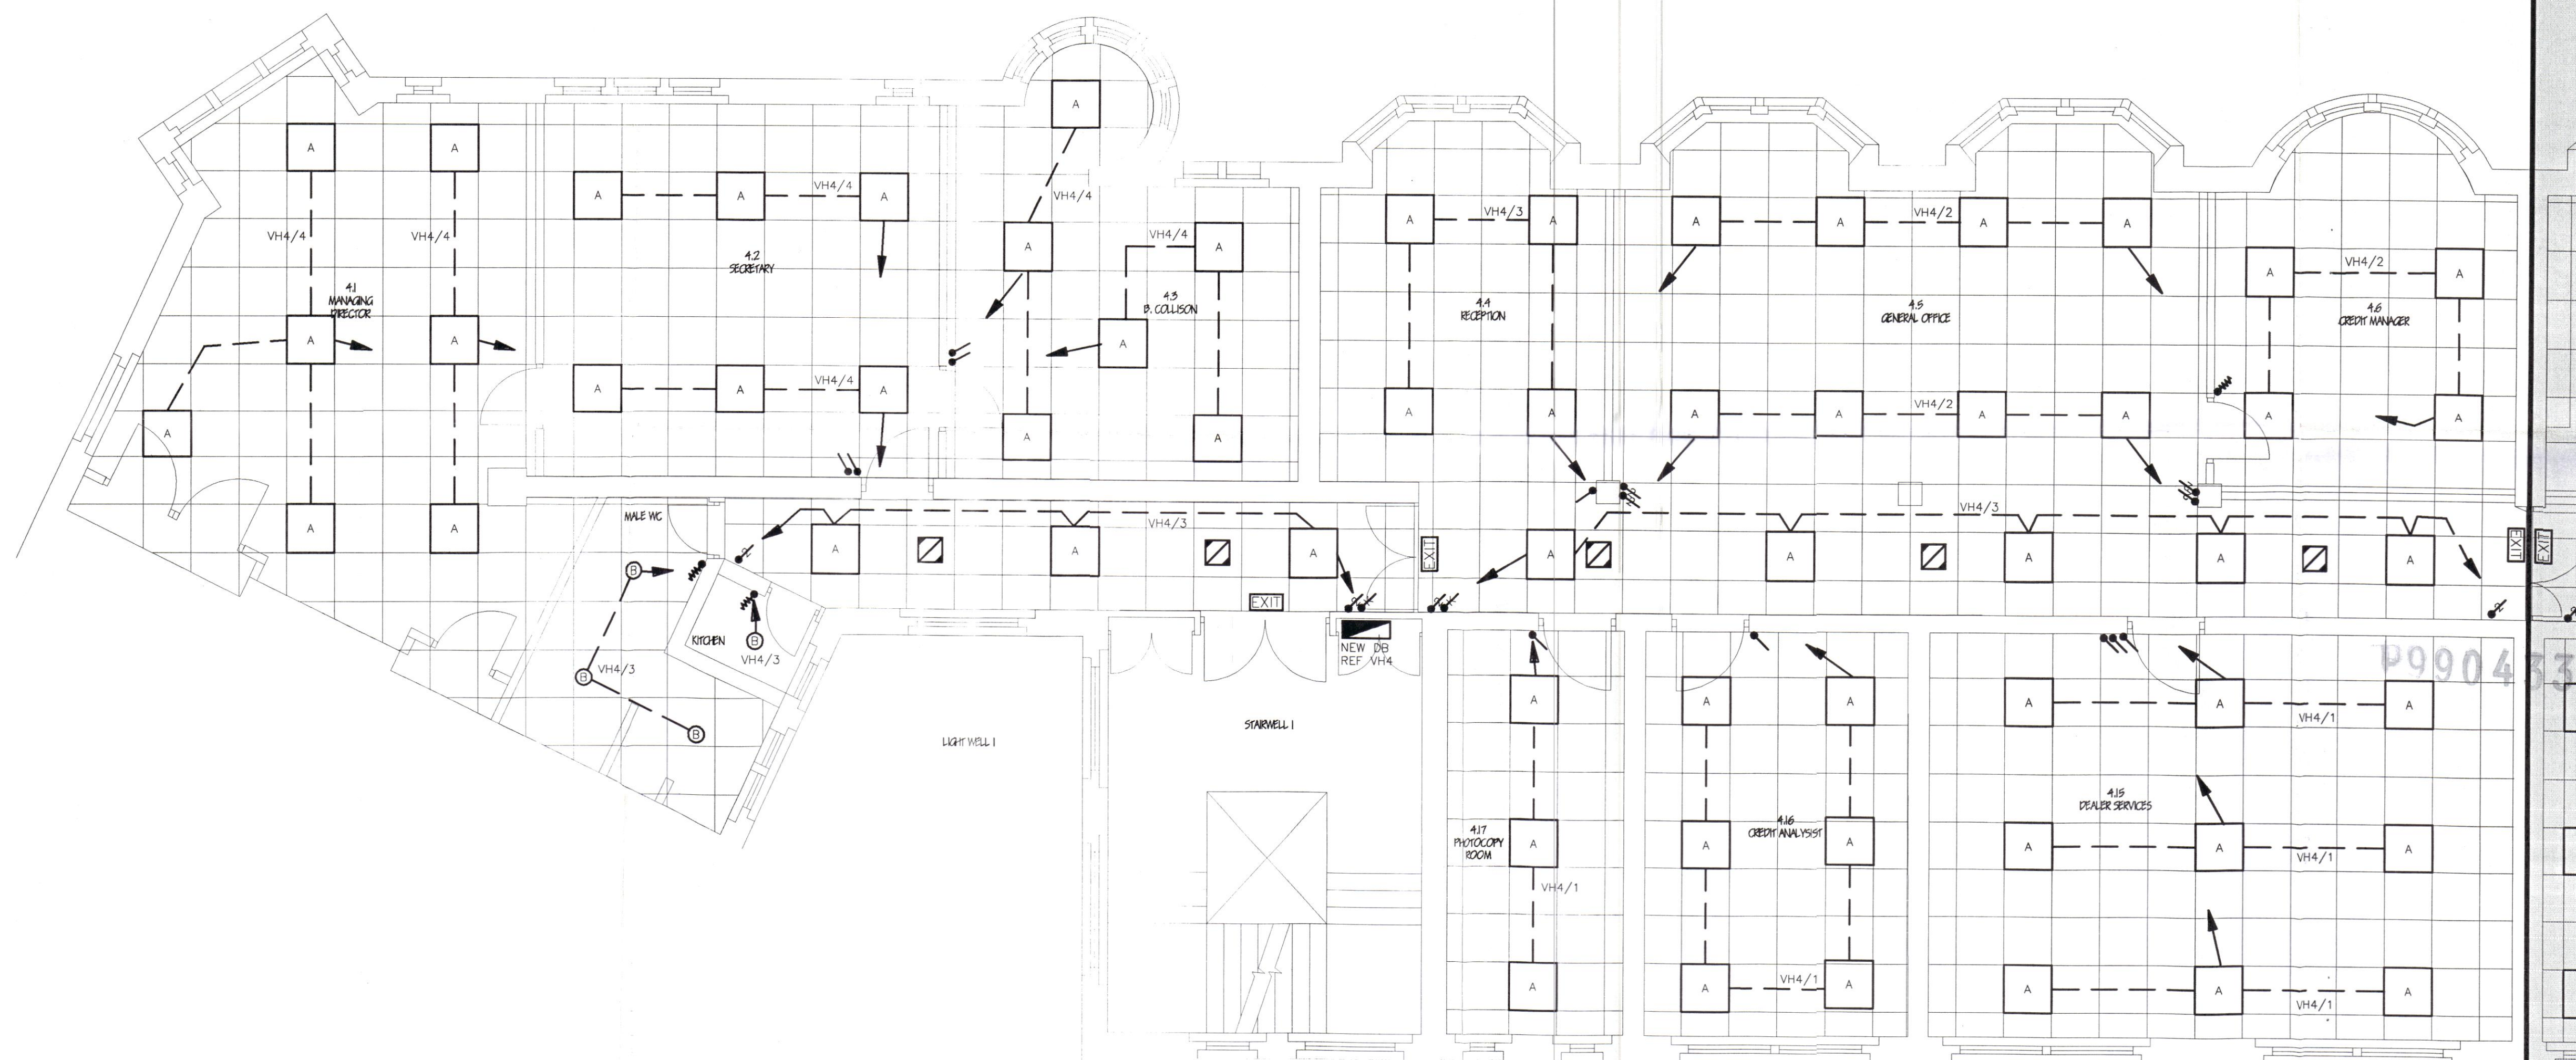

SERVICES SHOWN IN SHADED
AREA FOR INFORMATION ONLY.
REFER TO DRG 4238/06

LEGEND

- A** INDICATES 600x600mm MODULAR FLUORESCENT LUMINAIRE, RECESSED TYPE WITH 4 No. 18W PLUSLUX LINEAR FLUORESCENT LAMPS, HIGH POWER FACTOR SWITCHSTART CONTROL GEAR AND LG3 CAT 2 LOUVRE
WHITCROFT BROADSPREAD COMPLIANCE.
REF: 600/BRCP/T25/W2.200/S/4218/SB/FTB
OR:
THORLUX ALTERLUX
REF: ALT 8138-S
OR:
MARLOW INTEGRATED DESIGNS. MIR60.
REF: MIR60-418 MRL2
- B** INDICATES 450mm DIAMETER CIRCULAR SEMI RECESSED LUMINAIRE WITH OPAL DIFFUSER, WHITE BODY, 38W 2D LAMP, POWER POWER FACTOR SWITCHSTART CONTROL GEAR AND SEMI RECESS KIT.
MARLIN OPALINE
REF: 2045 T383 + 2045 ORK
- EXIT** INDICATES SELF CONTAINED, NON MAINTAINED 3 HOUR EMERGENCY LUMINAIRE, SURFACE FIXED.
MENVIER BRITELITE
REF: BLN
- EXIT** INDICATES SELF CONTAINED, MAINTAINED 3 HOUR EMERGENCY EXIT SIGN, SURFACE FIXED.
MENVIER BRITELITE
REF: BLM + LEXSABL
- ↗** INDICATES ONE WAY FLUSH MOUNTED GRIDSWITCH. MK LOGIC PLUS RANGE.
- ↔** INDICATES TWO WAY FLUSH MOUNTED GRIDSWITCH. MK LOGIC PLUS RANGE.
- ⚡** INDICATES DOUBLE POLE FLUSH MOUNTED EMERGENCY LIGHTING TEST KEYSWITCH. MK LOGIC PLUS RANGE.
- ⚡** INDICATES CEILING MOUNTED PULL CORD SWITCH. MK LOGIC PLUS RANGE.
- INDICATES MEM MEMSHIELD TYPE A DISTRIBUTION BOARD WITH 100A D.P. MAIN ISOLATOR.

NOTES

1. THIS DRAWING SHALL BE READING IN CONJUNCTION WITH THE OTHER ELECTRICAL AND MECHANICAL SERVICES DRAWINGS.

REV.	DATE	DESCRIPTION	ALT	DO	CHK	APP

T. G. ARMSTRONG & PARTNERS CONSULTING ENGINEERS

Durham City Tel: 0191 386 2314
Stevenage Tel: 01438 314422

Title
ELECTRICAL ENGINEERING SERVICES
PROPOSED LIGHTING LAYOUT
FOURTH FLOOR - VERNON HOUSE

Project
PSA WHOLESALE LTD,
SICILIAN HOUSE,
LONDON WC1.

Architect

Client
BULLEN CONSULTANTS.

Drawing Number	Revision	Scale
4238/05		A1 1:50
		A3 1:100
		A4 N.T.S.

Path
G:\GJC\4238\CURRENT\4TH-LTG.DWG

Traced	DO Check	Originator	Approved
PS	WAC	GTC	GTC

Date	Status
JANUARY '99	

This drawing is the copyright of
T. G. ARMSTRONG & PARTNERS
and must not be reproduced without their permission

LONDON BOROUGH OF CAMDEN
PLANS APPROVED BY THE COUNCIL
ON BEHALF OF THE COUNCIL
28 JAN 1999