




PROPOSED HTG PIPE DISTRIBUTION
TO SERVE BLOCKS C2 & C1 (TYPICAL)
PHOTO REF P4

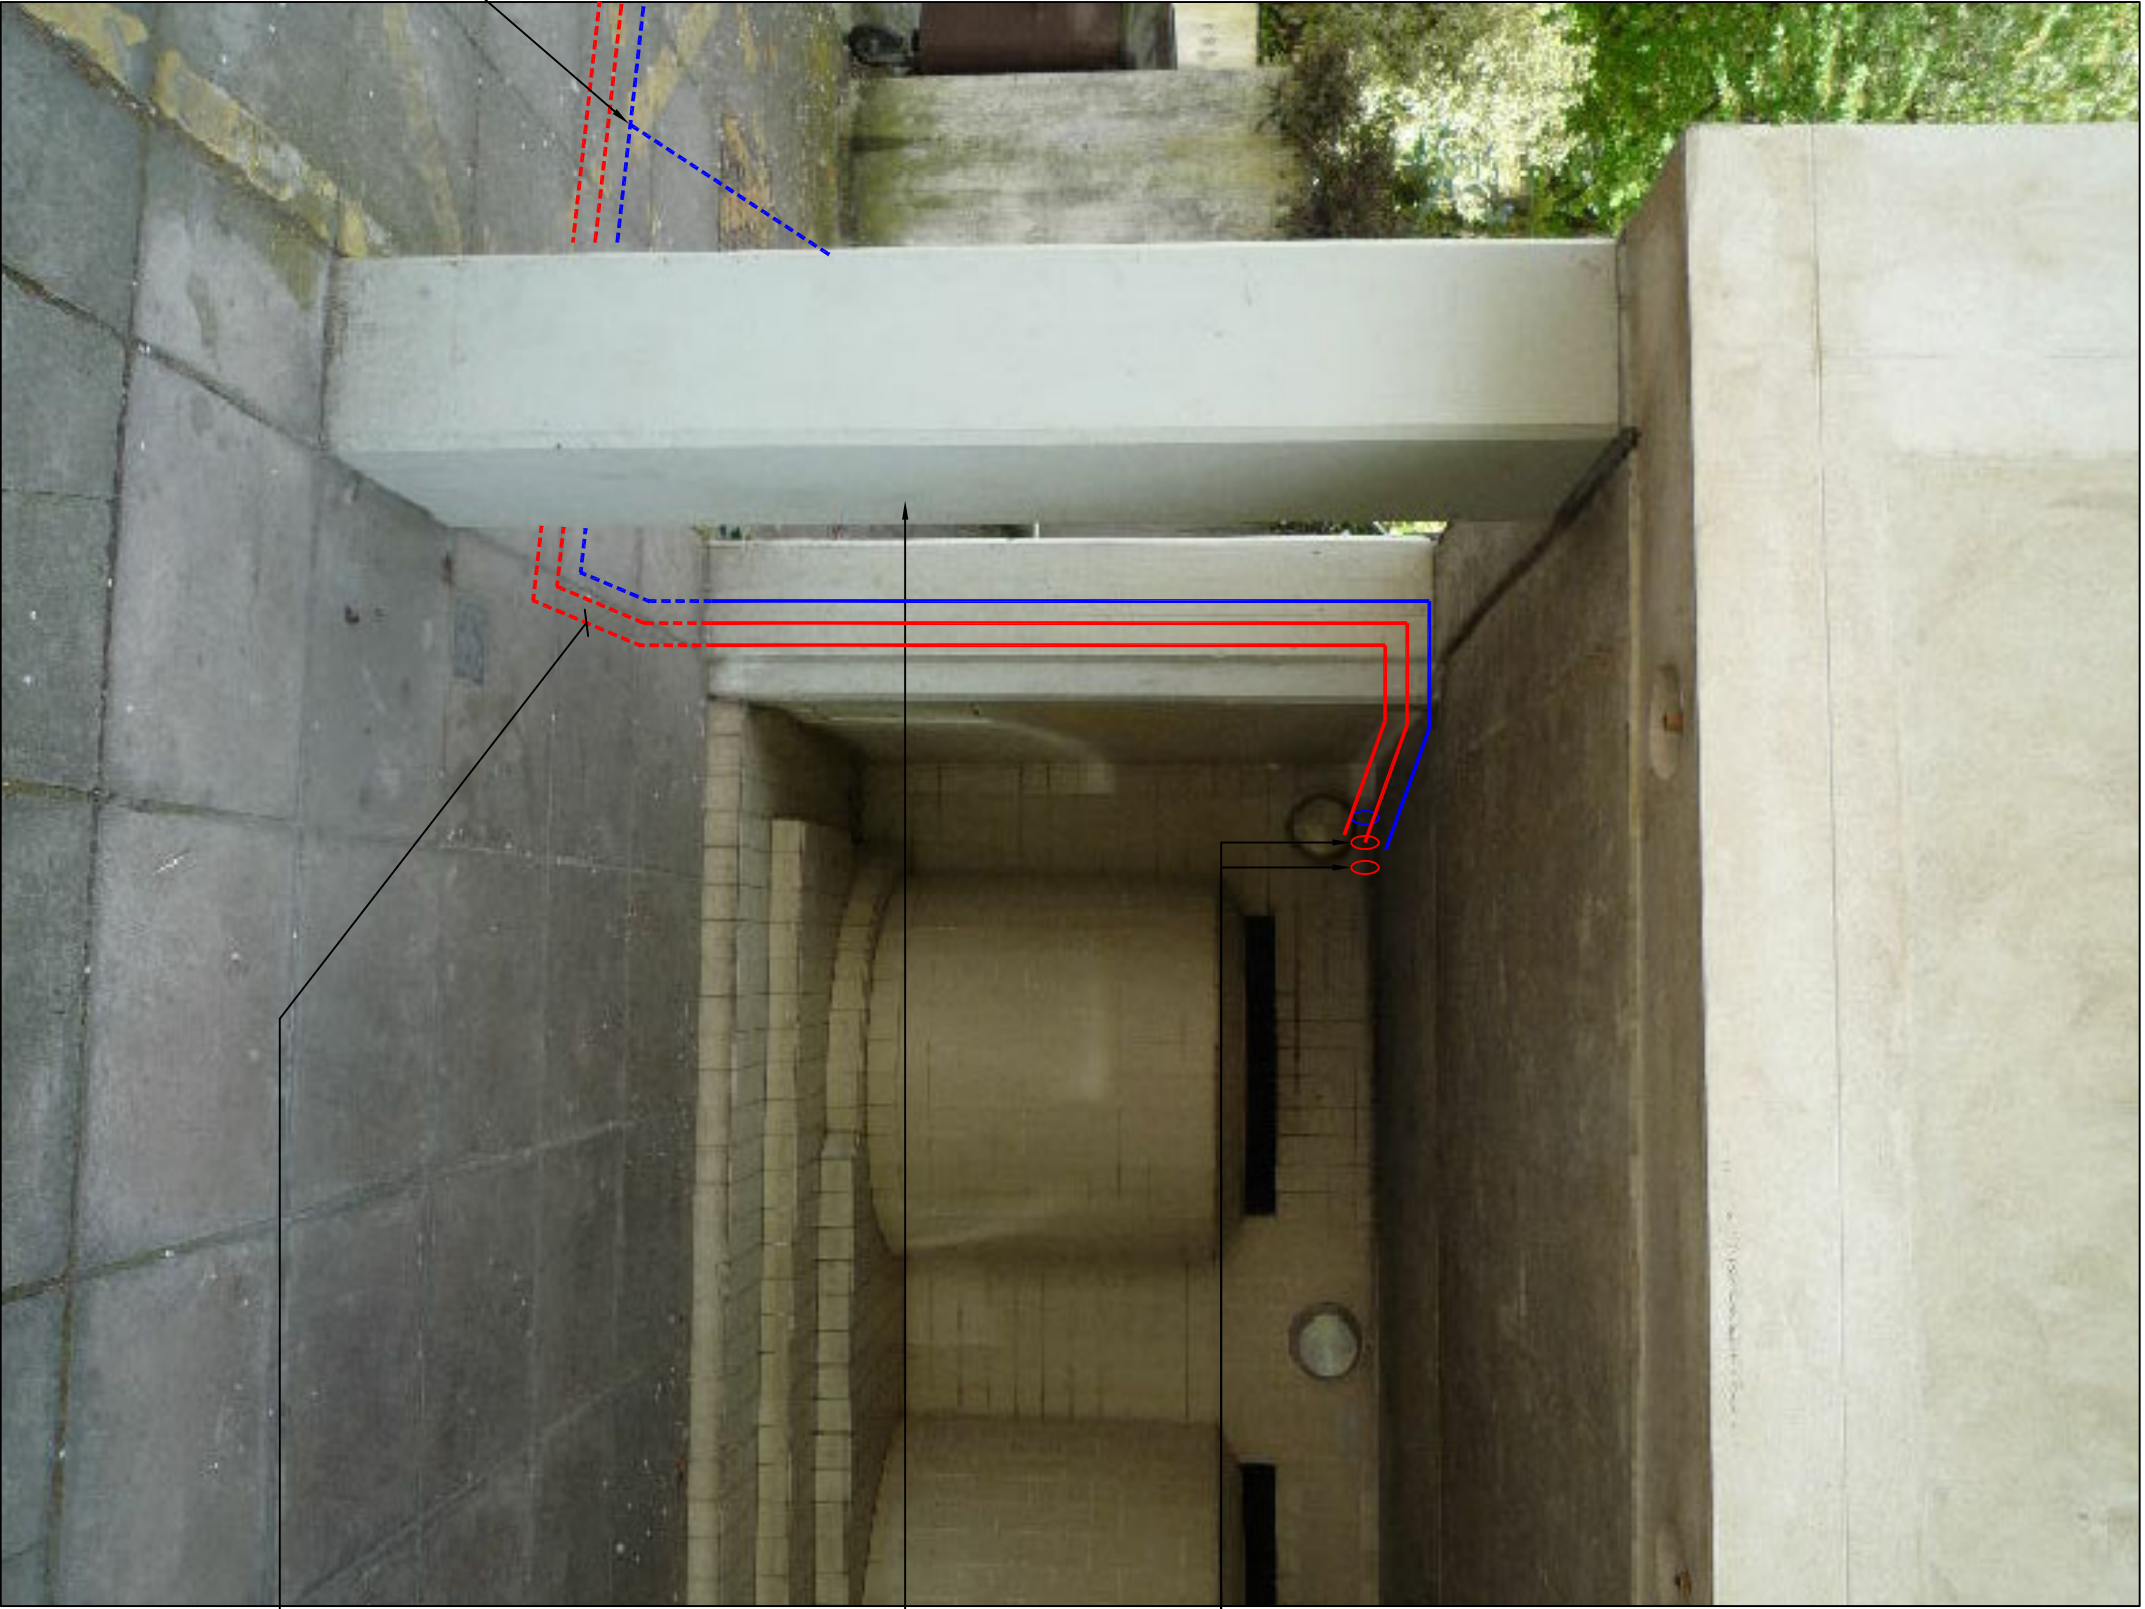

PROPOSED HTG PIPE DISTRIBUTION
TO SERVE BLOCKS C2 & C1 (TYPICAL)
PHOTO REF P5

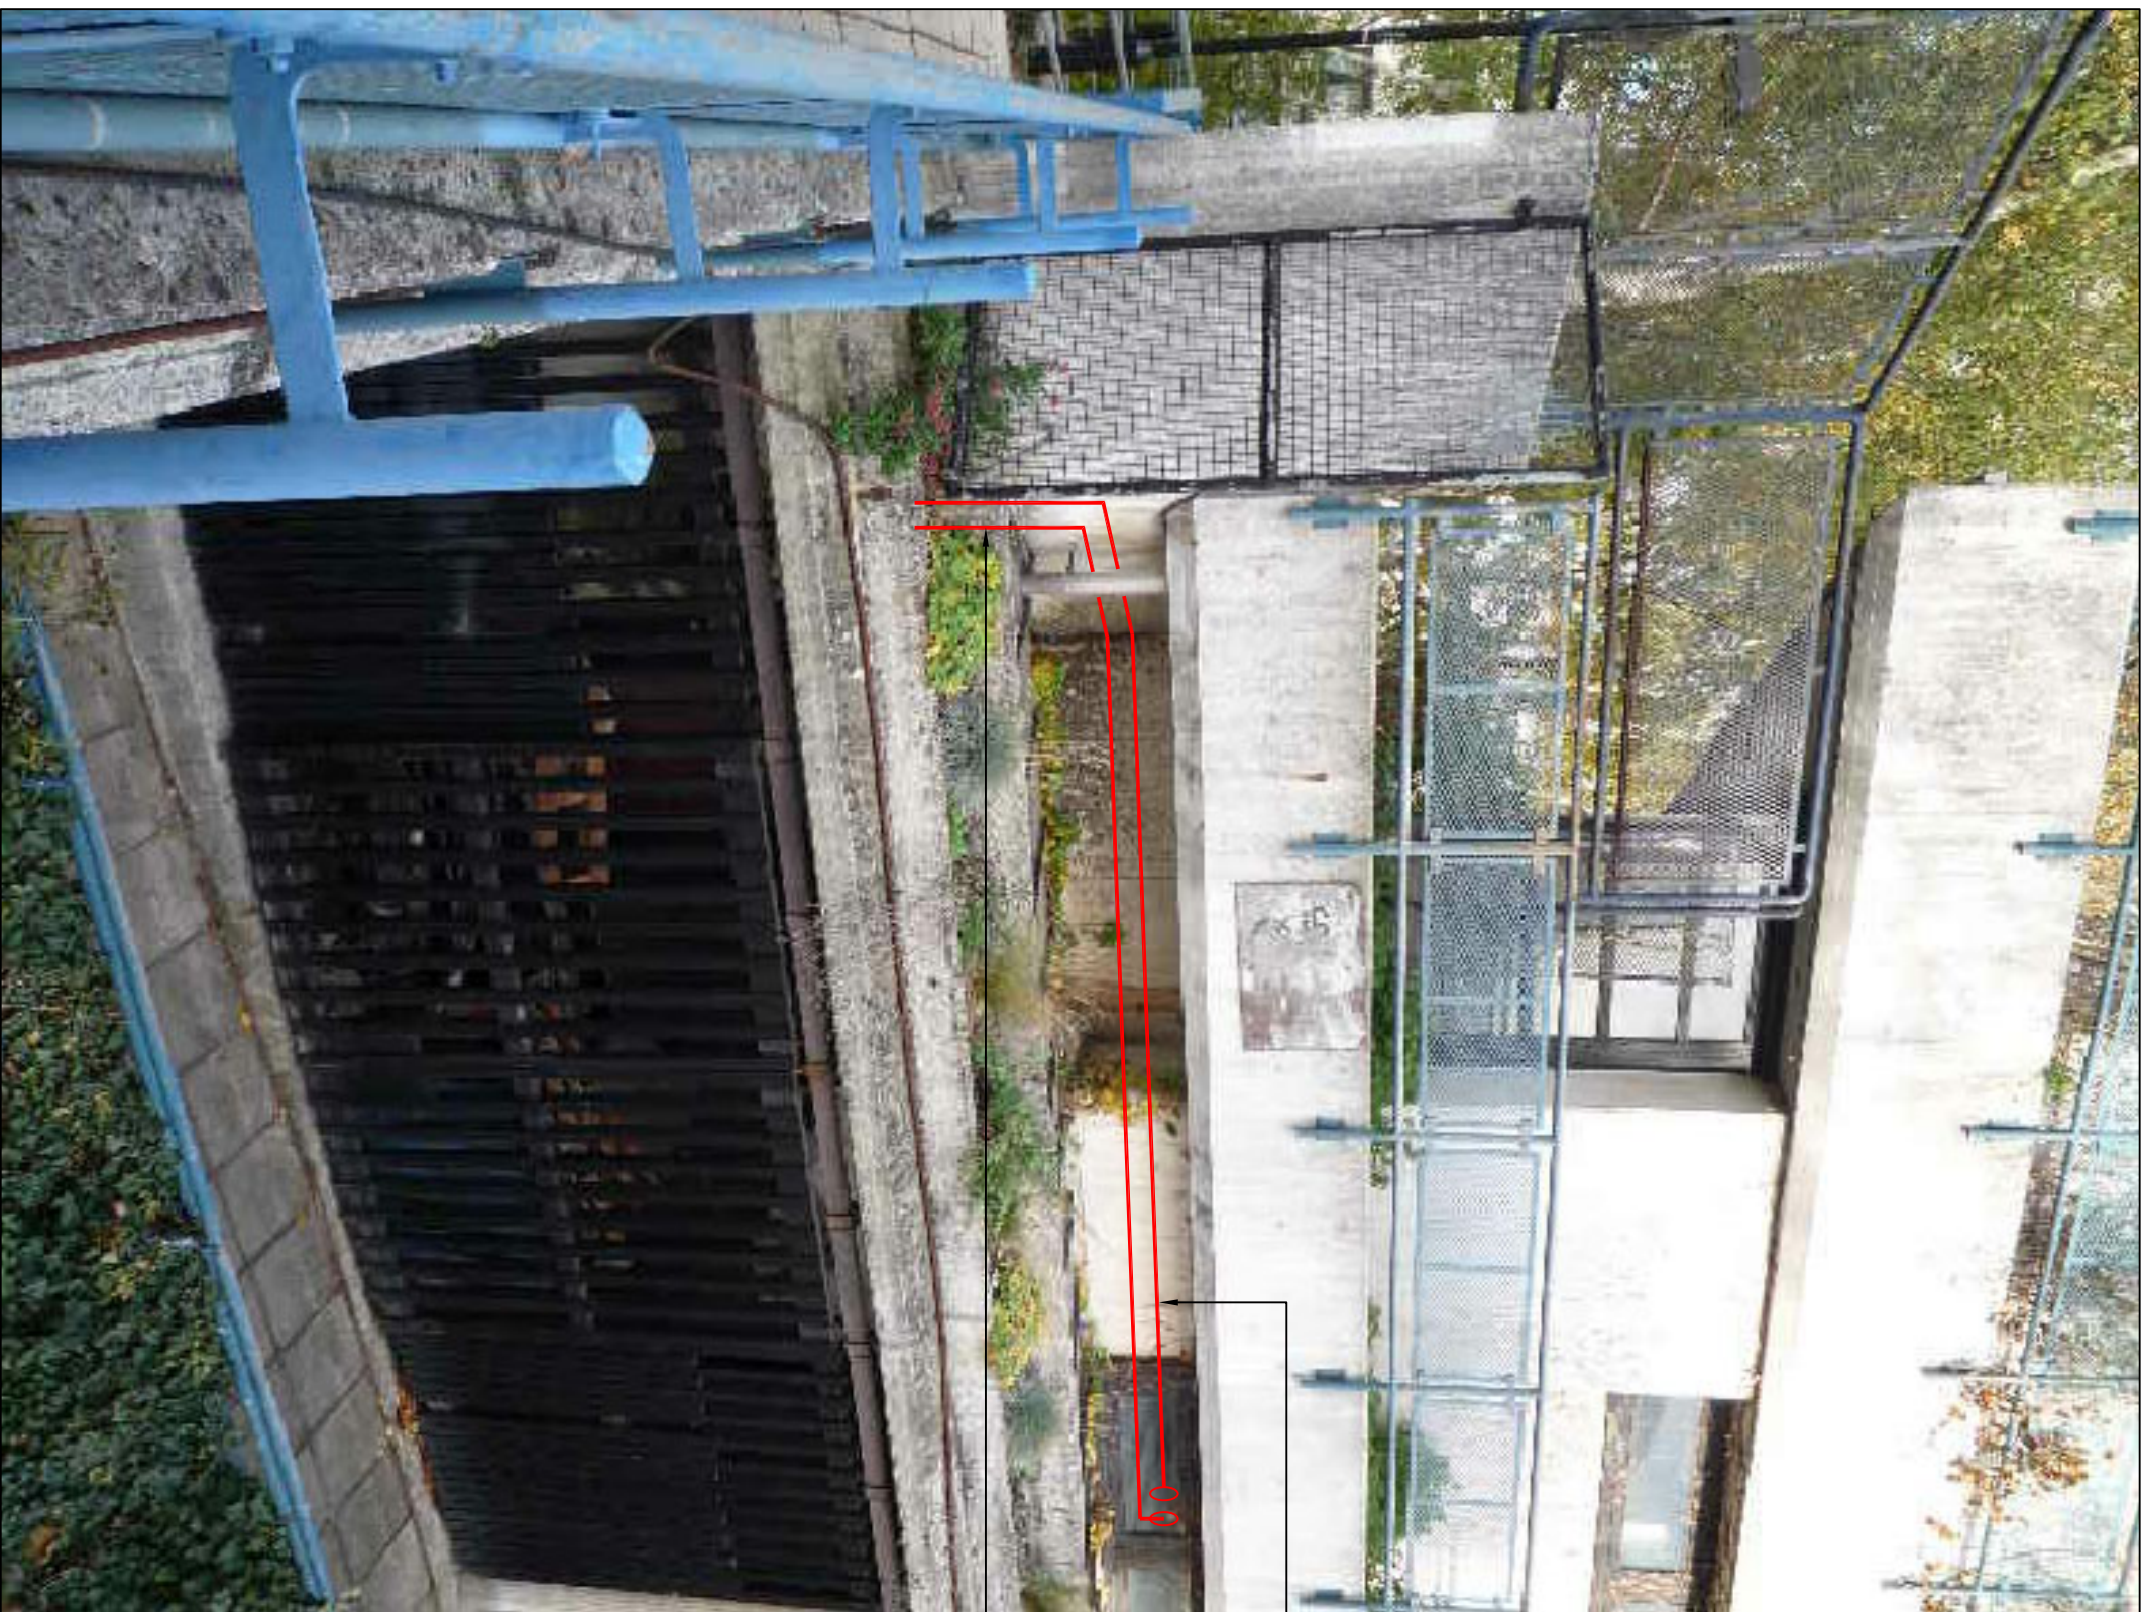

PROPOSED HTG PIPE DISTRIBUTION TO
LINK FROM SOUTH ELEVATION OF
COMMUNITY CENTRE
PHOTO REF P6

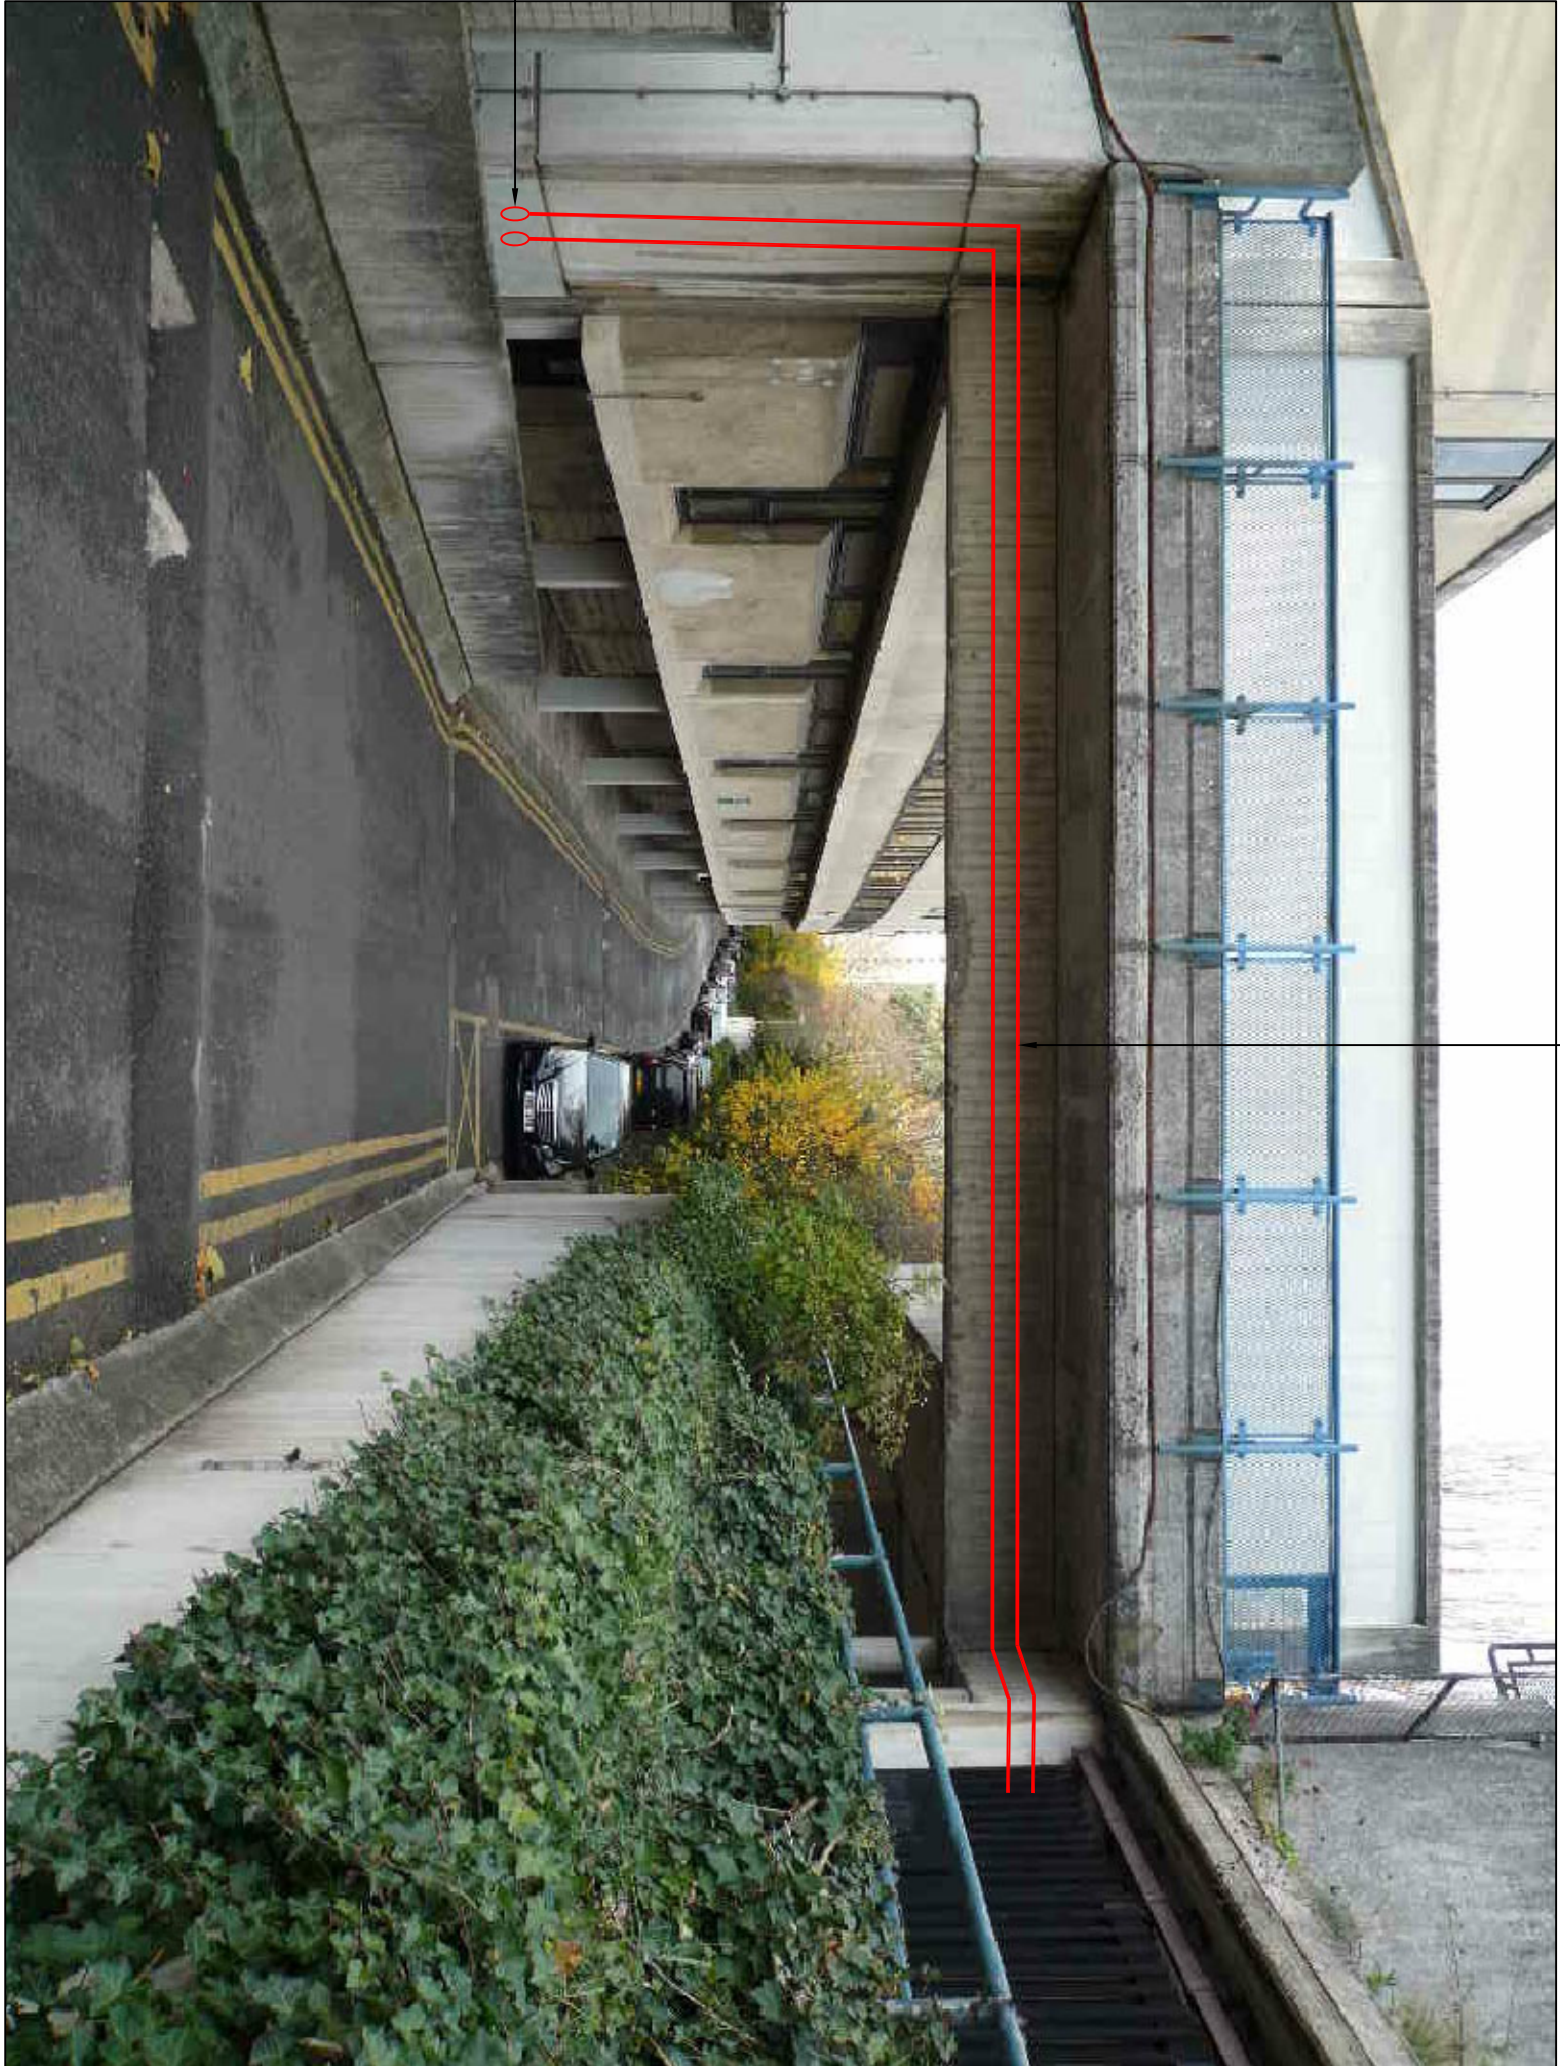

PROPOSED HTG PIPE DISTRIBUTION
TO SERVE BLOCKS C1 - C3 LINK VIA
PEDESTRIAN BRIDGE
PHOTO REF P7



PROPOSED HTG PIPE DISTRIBUTION TO
SERVE BLOCKS C1 - C3 AT EAST END
OF BLOCK C3
PHOTO REF P8

086 ST HTG PEAR ROUTE AT HL ON
L1 & ENTER LOOKED ROOM
AT HL

086 ST HTG PEAR ROUTE AT HL ON
L1 & ENTER LOOKED ROOM
COMM CENTRE EXTERNAL STORAGE AREA

086 ST HTG PEAR ROUTE
FROM EXISTING LOCKED
ROOM ON INTERIOR OF
BLOCK C2 AT EAST END
OF BLOCK C2 TO
GARAGE UNIT HEATING
BRIDGE ROOM

086 ST HTG PEAR ENTER
VACANT GARAGE UNIT AT HL

086 ST HTG PEAR ROUTE
AT HL ON UNDERGIRD OF
COMM CENTRE (086)


086 ST HTG PEAR UP
BALCONY SPLIT TO
BELOW EXTERNAL
STORAGE AREA

086 ST HTG PEAR ROUTE
TO MAIN STORAGE TANK
OF BLOCK C2 AT HL
(TYPICAL)

086 ST HTG PEAR PIPE
UNDERGROUND PIPE
TO MAIN STORAGE TANK
OF BLOCK C2 AT HL
COLLUM

086 ST HTG PEAR ROUTE
BETWEEN BLOCKS C3 & C2
VIA UNDERGROUND PIPE
TRENCH

NOTES:
1. ALL PEPPER FULLY INSULATED AND
WEATHER PROTECTED WITH P.A. AND
STEPS TO AVOID COLLISION.

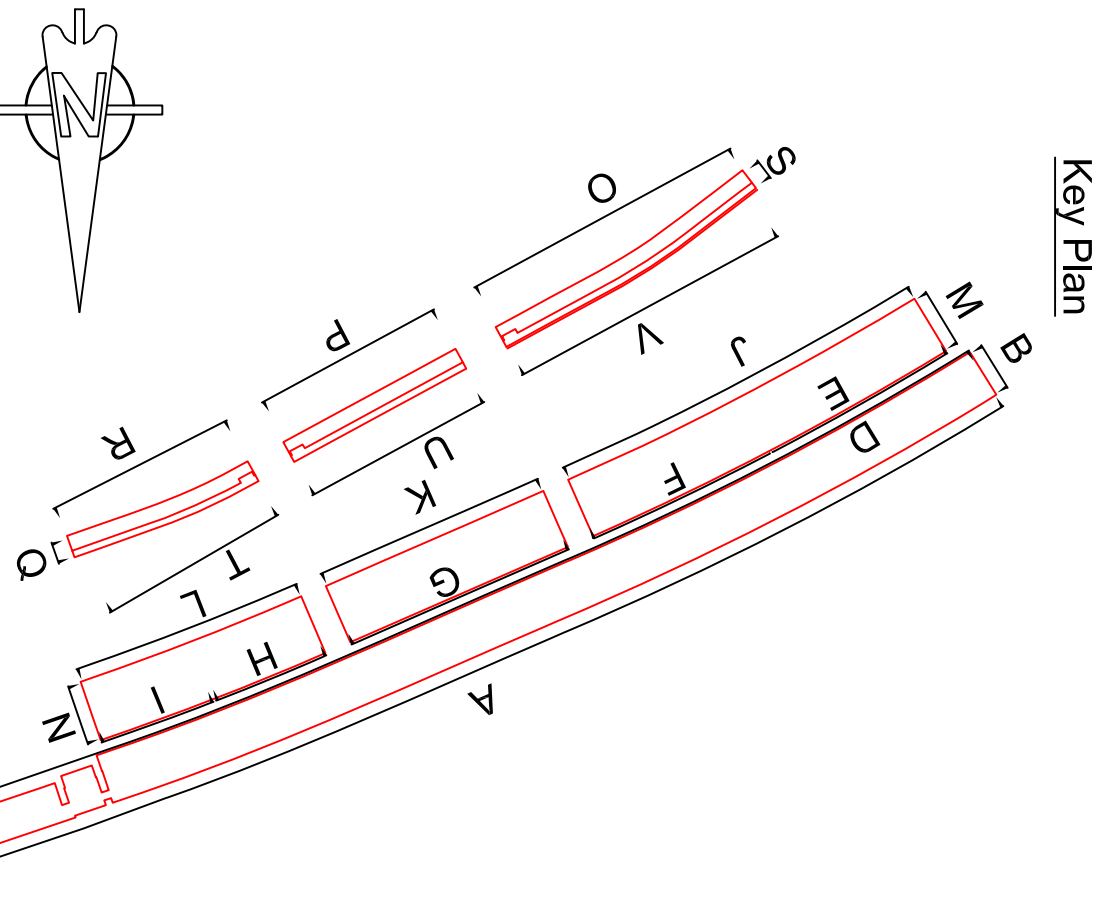

PLANNING DRAWING

Camden ARGYLE STREET LONDON WC1H 8NU				Mechanical and Electrical Consulting Engineers BYA BUTLER & YOUNG ASSOCIATES 1st Floor, 34-42 Seaton Road (aka), Seaford, BN26 6PG Telephone 01323 771772 Fax 01323 771774 Website www.bya.co.uk Email enquiries@bya.co.uk			
Project ALEXANDRA ROAD ESTATE (ROWLEY WAY)				Drawing Title PROPOSED REPLACEMENT HTG & DOM WATER SERVICES PIPE ROUTE TO EXTERNAL ELEVATION OF DWELLINGS (C1-C3) SHEET 2 OF 2			
Scale N.T.S.		Date MAY 18		Drawing Number 2777-RW-M-022		Revision C	
Author NS		Checker JS		Date MAY 18		Revision C	