


DETAIL 1/1 - VRF REFRIGERANT RISER R3
(Scale 1:10)


DETAIL 1/2 - VRF REFRIGERANT RISER R4
(Scale 1:10)

DETAIL 1/3 - VRF REFRIGERANT RISER R5
(Scale 1:10)


DETAIL 1/4 - VRF REFRIGERANT RISER R6
(Scale 1:10)

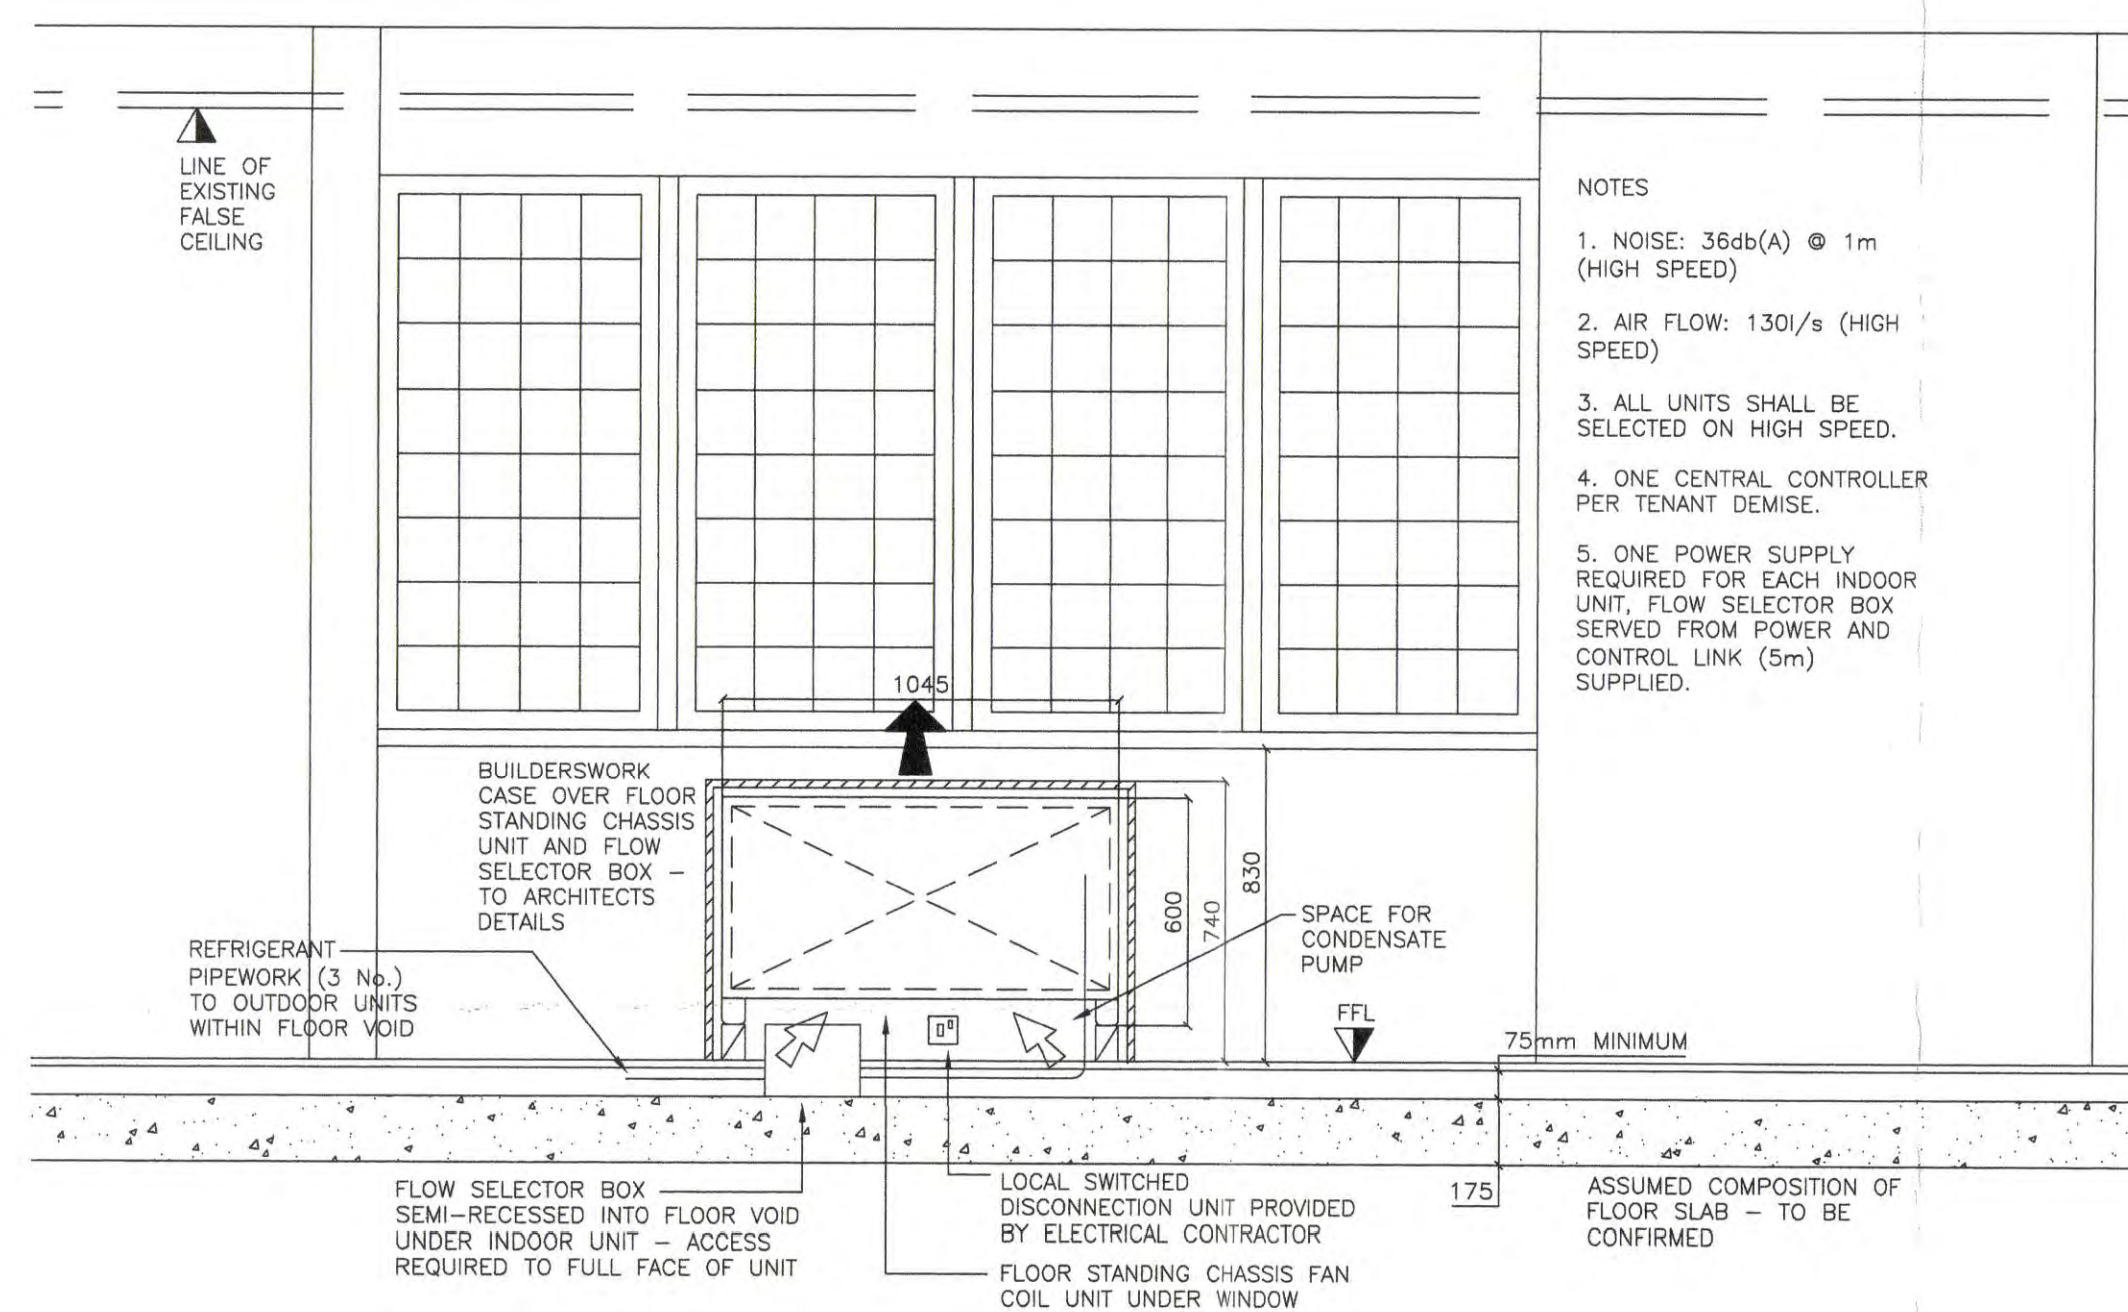

SECTION E-E TYPICAL FIRST FLOOR INTERNAL
UNIT INSTALLATION
(Scale 1:20)

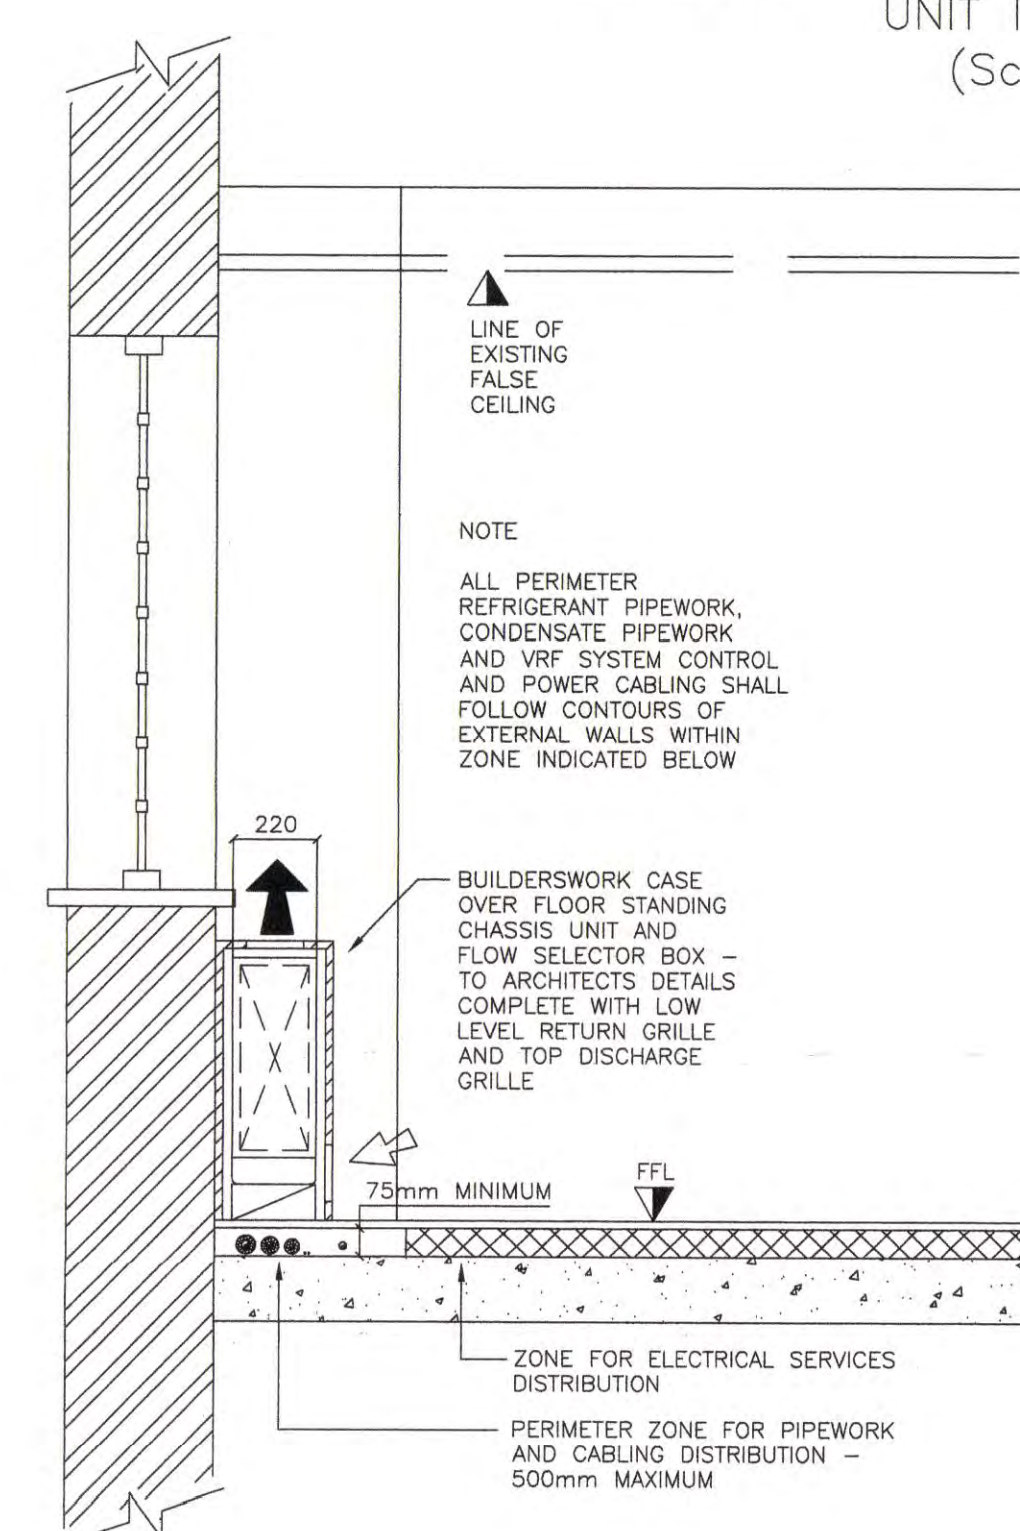

SECTION F-F TYPICAL SECTION
THROUGH PERIMETER
(Scale 1:20)

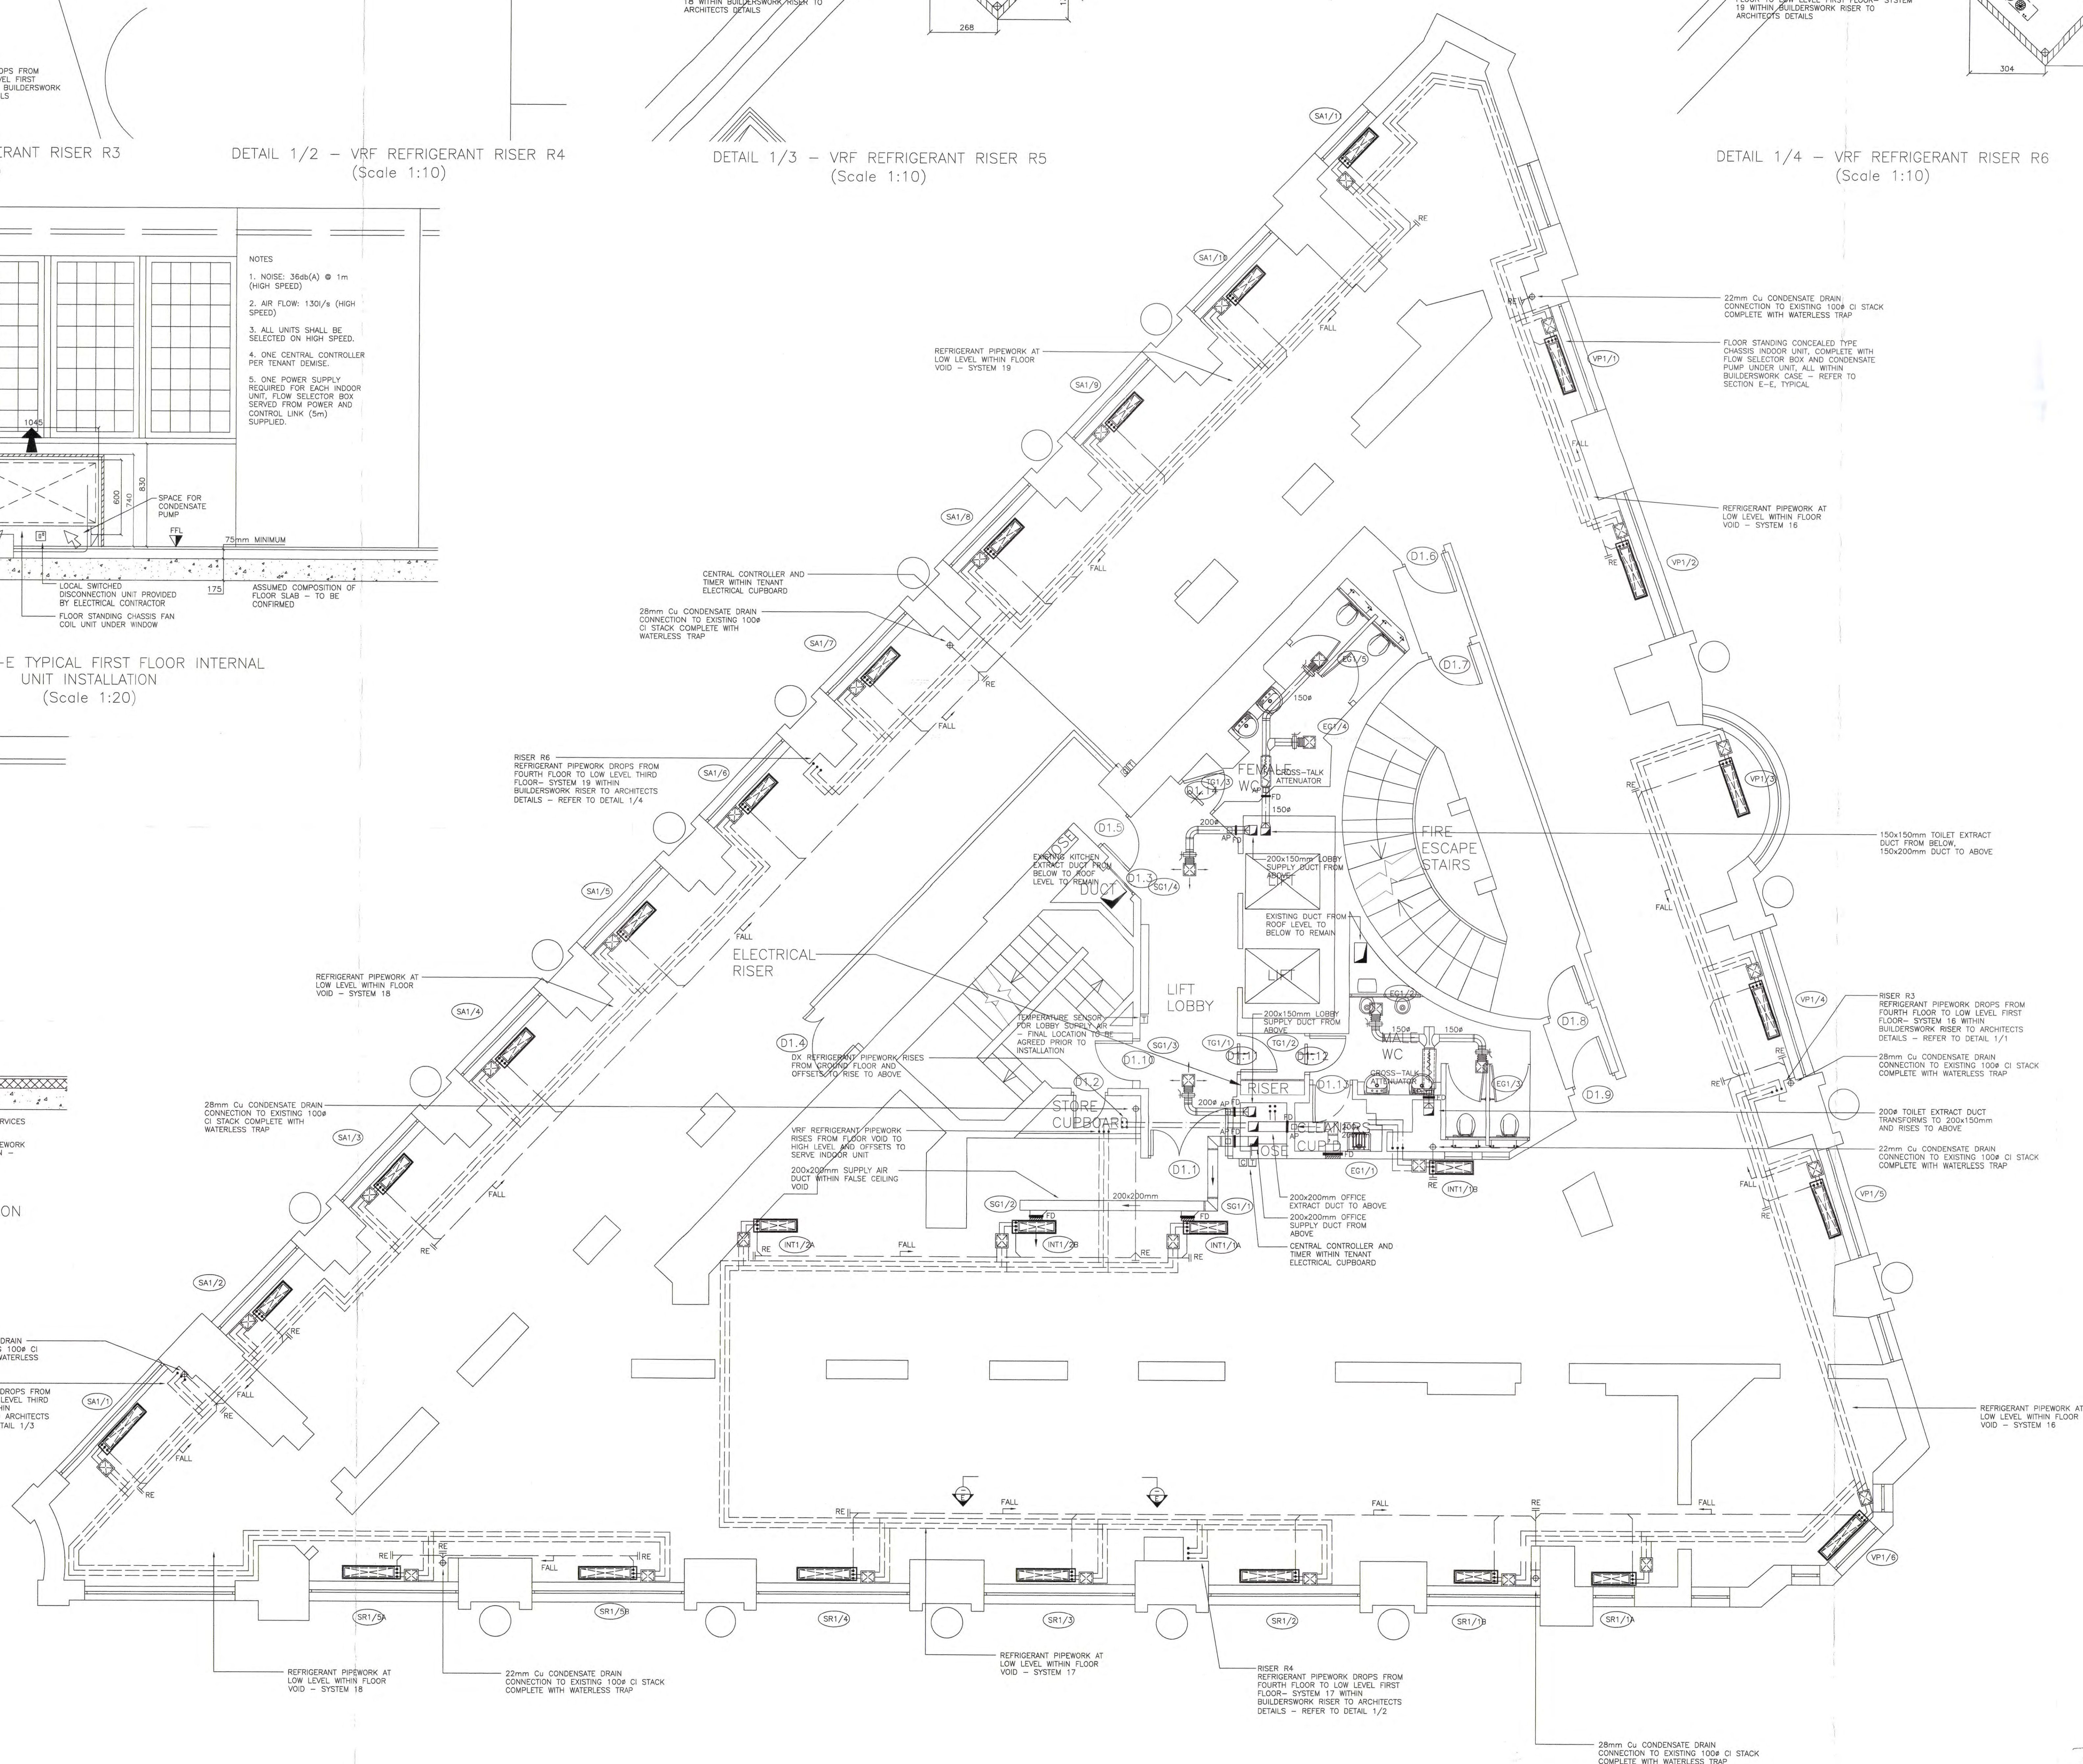

- NOTES**

 1. THIS DRAWING SHALL BE READ IN CONJUNCTION WITH THE LATEST MECHANICAL SERVICES DRAWINGS AND SPECIFICATION AND ALL RELEVANT MECHANICAL, STRUCTURAL, ELECTRICAL AND PLUMBING SERVICES DRAWINGS AND SPECIFICATIONS.
 2. THE CONTRACTOR SHALL CARRY OUT A FULL SURVEY OF THE EXISTING INSTALLATION AND CONFIRM THAT THE SERVICES ARE AS SHOWN AND TO DETERMINE WHETHER THE SERVICES ARE STILL LIVE OR REDUNDANT. ANY DISCREPANCIES ARE TO BE HIGHLIGHTED TO THE ENGINEERS.
 3. ALL REDUNDANT SERVICES ARE TO BE STRIPPED OUT WHERE PRACTICABLE AND PENETRATIONS THROUGH STRUCTURE ARE TO BE RE-MADE TO GOOD UNLESS OTHERWISE STATED.
 4. PIPEWORK ROUTES AND FLOW SELECTOR BOY LOCATIONS ARE SHOWN INDICATIVELY. THE CONTRACTOR SHALL ENSURE THAT THE MECHANICAL SERVICES INSTALLATION IS FULLY CO-ORDINATED WITH THE STRUCTURE AND ALL OTHER SERVICES ROUTES.

REVISION			
T2	FLOOR PLAN AMENDED	AUG 05	
T1	TENDER ISSUE	MAR 05	
REV	DESCRIPTION	DATE	CHK



Brook House
11A West Street,
Reigate, Surrey
RH2 9BL

Telephone: +44 (0)1737 224440
Facsimile: +44 (0)1737 224303

Email:
Mail@hbsconsulting.co.uk
CAD@hbsconsulting.co.uk
www.hbsconsulting.co.uk

CLIENT

HOLBORN LINKS

ARCHITECT
PSK PROUT TILBROOK

PROJECT

31 SOUTHAMPTON ROW

LONDON
WC1

TITLE

PROPOSED FIRST FLOOR

MECHANICAL SERVICES

SCALE	SHEET	DATE	D
1:50	A0	FEB 05	

1:30	AO	FEB 03
------	----	--------

PURPOSE OF ISSUE

PLANNING ISS

DRAWING NUMBER
3784 /M /201

3784/M/201

L:\3784\Mechanical\Current

©HBS Consulting Engineers

CHS Consulting Engineer
