
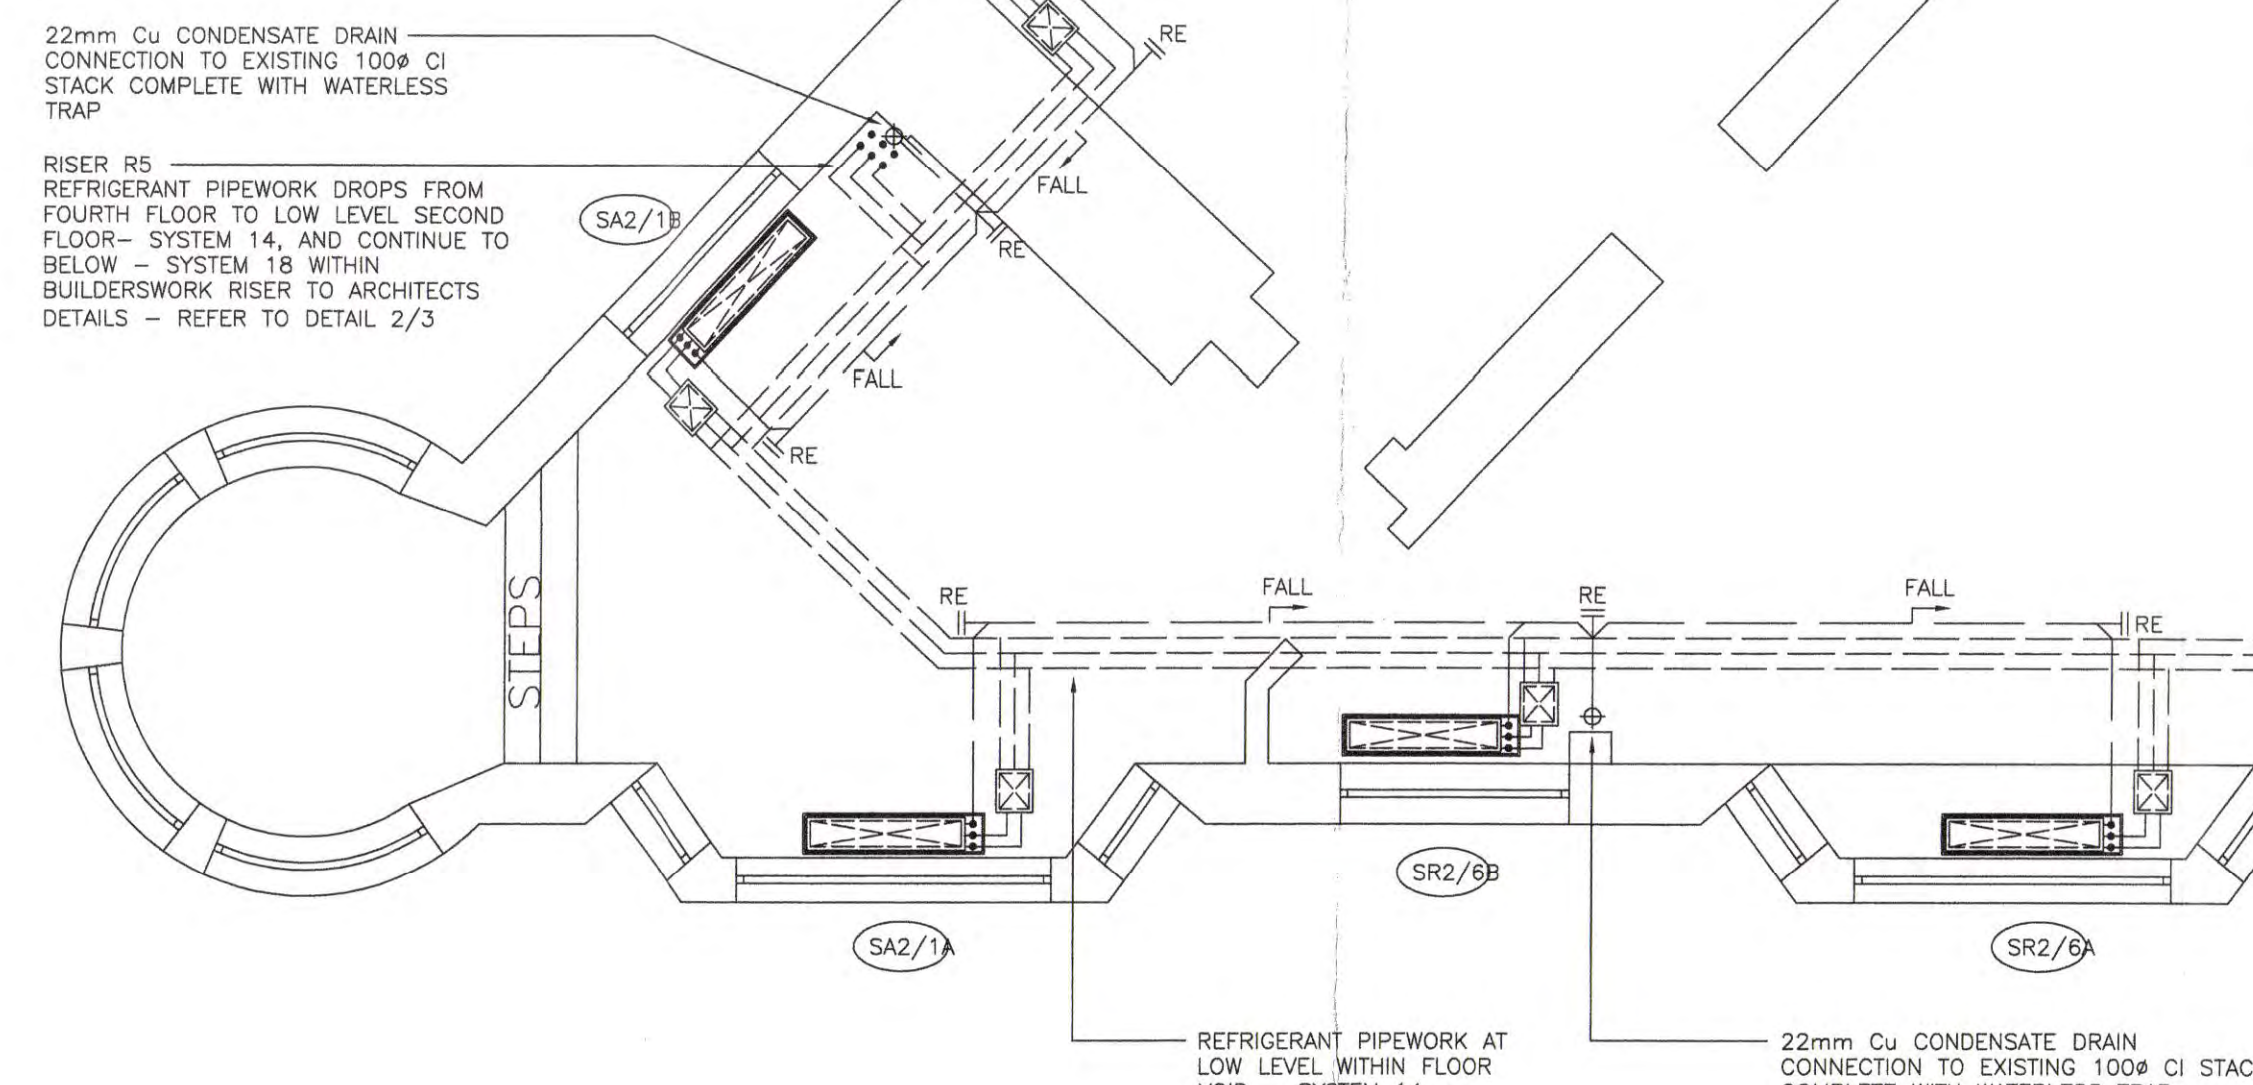


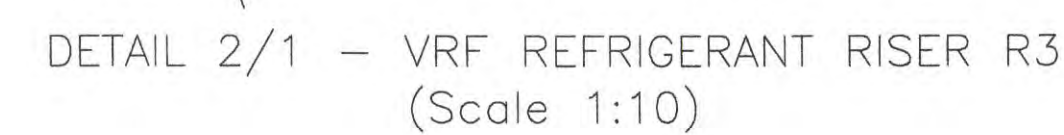

- | NOTES | |
|-------|---|
| 1. | THIS DRAWING SHALL BE READ IN CONJUNCTION WITH THE LATEST MECHANICAL SERVICES DRAWINGS AND SPECIFICATION AND ALL RELEVANT ARCHITECTURAL, STRUCTURAL, ELECTRICAL AND PUBLIC HEALTH SERVICES DRAWINGS AND SPECIFICATIONS. |
| 2. | THE CONTRACTOR SHALL CARRY OUT A FULL SURVEY OF THE EXISTING INSTALLATION AND CONFIRM THAT THE SERVICES ARE AS SHOWN. IF IT IS DETERMINED WHETHER THE SERVICES ARE STILL LIVE OR REDUNDANT, ANY DISCREPANCIES ARE TO BE HIGHLIGHTED TO THE ENGINEERS. |
| 3. | ALL REDUNDANT SERVICES ARE TO BE STRIPPED OUT WHERE NECESSARY AND RE-USED TO DETERMINE WHETHER THE SERVICES ARE STILL LIVE OR REDUNDANT, ANY DISCREPANCIES ARE TO BE HIGHLIGHTED TO THE ENGINEERS. |
| 4. | PIPEWORK ROUTES AND FLOW SELECTOR BOX LOCATIONS ARE TO BE INDIVIDUALLY IDENTIFIED AND MARKED TO BE MADE-GOOD UNLESS THEY ARE TO BE RE-USED. |
| 5. | THE MECHANICAL SERVICES INSTALLATION IS FULLY COORDINATED WITH THE STRUCTURE AND ALL OTHER ROUTES. |

REVISION				
REV	DESCRIPTION	DATE	CHK	
T2	FLOOR PLAN AMENDED	AUG 05		
T1	TENDER ISSUE	MAR 01		

 **HBS**
CONSULTING ENGINEERS

Brook House
11A West Street,
Reigate, Surrey
RH4 9SE

Telephone: +44 (0)1737 224440
Facsimile: +44 (0)1737 224303

Email:
Mail: hbs@hbsconsulting.co.uk
CAD: cad@hbsconsulting.co.uk
www.hbsconsulting.co.uk

CLIENT	HOLBORN LINKS
ARCHITECT	PSK PROUT TILBROOK
PROJECT	31 SOUTHAMPTON ROW LONDON WC1

TITLE				
PROPOSED SECOND FLOOR MECHANICAL SERVICES LAYOUT				
SCALE	SHEET	DATE	DRAWN	CHECKED
1:50	A0	MAR 05	DoS	

PURPOSE OF ISSUE	PLANNING ISSUE
------------------	----------------

DRAWING NUMBER	REVISION
3734 / 1 / 000	

FILE NAME
L:\3784\Mechanical\Current\3784M202

©HBS Consulting Engineers Ltd. 200

2005/3
2005/3
Disc B6
LONDON BOROUGH OF CAMDEN
TOWN AND COUNTRY PLANNING ACTS
1 / OCT 2005
RECOMMENDATION AGREED
ON BEHALF OF THE COUNCIL