





Do not scale dimensions from this drawing except for Local Authority planning purposes.

This drawing is copyright to Callisia and may not be reproduced in any form without prior written consent.

All current drawings and specifications for the project must be read in conjunction with the designers hazard and environment assessment record.




Reference	Model No.	Dimensions
Unit A	PURY-P200YNW-A	1858H x 920W x 740D
Unit B	PURY-P200YNW-A	1858H x 920W x 740D
Unit C	PURY-P200YNW-A	1858H x 920W x 740D
Unit D	PURY-P200YNW-A	1858H x 920W x 740D
Unit E	PURY-P300YNW-A	1858H x 920W x 740D
Unit F	PUZ-ZM100VKA	1338H x 1050W x 330D
Unit G	PUZ-ZM100VKA	1338H x 1050W x 330D
Unit H	PUZ-ZM100VKA	1338H x 1050W x 330D
Unit I	PUZ-ZM100VKA	1338H x 1050W x 330D

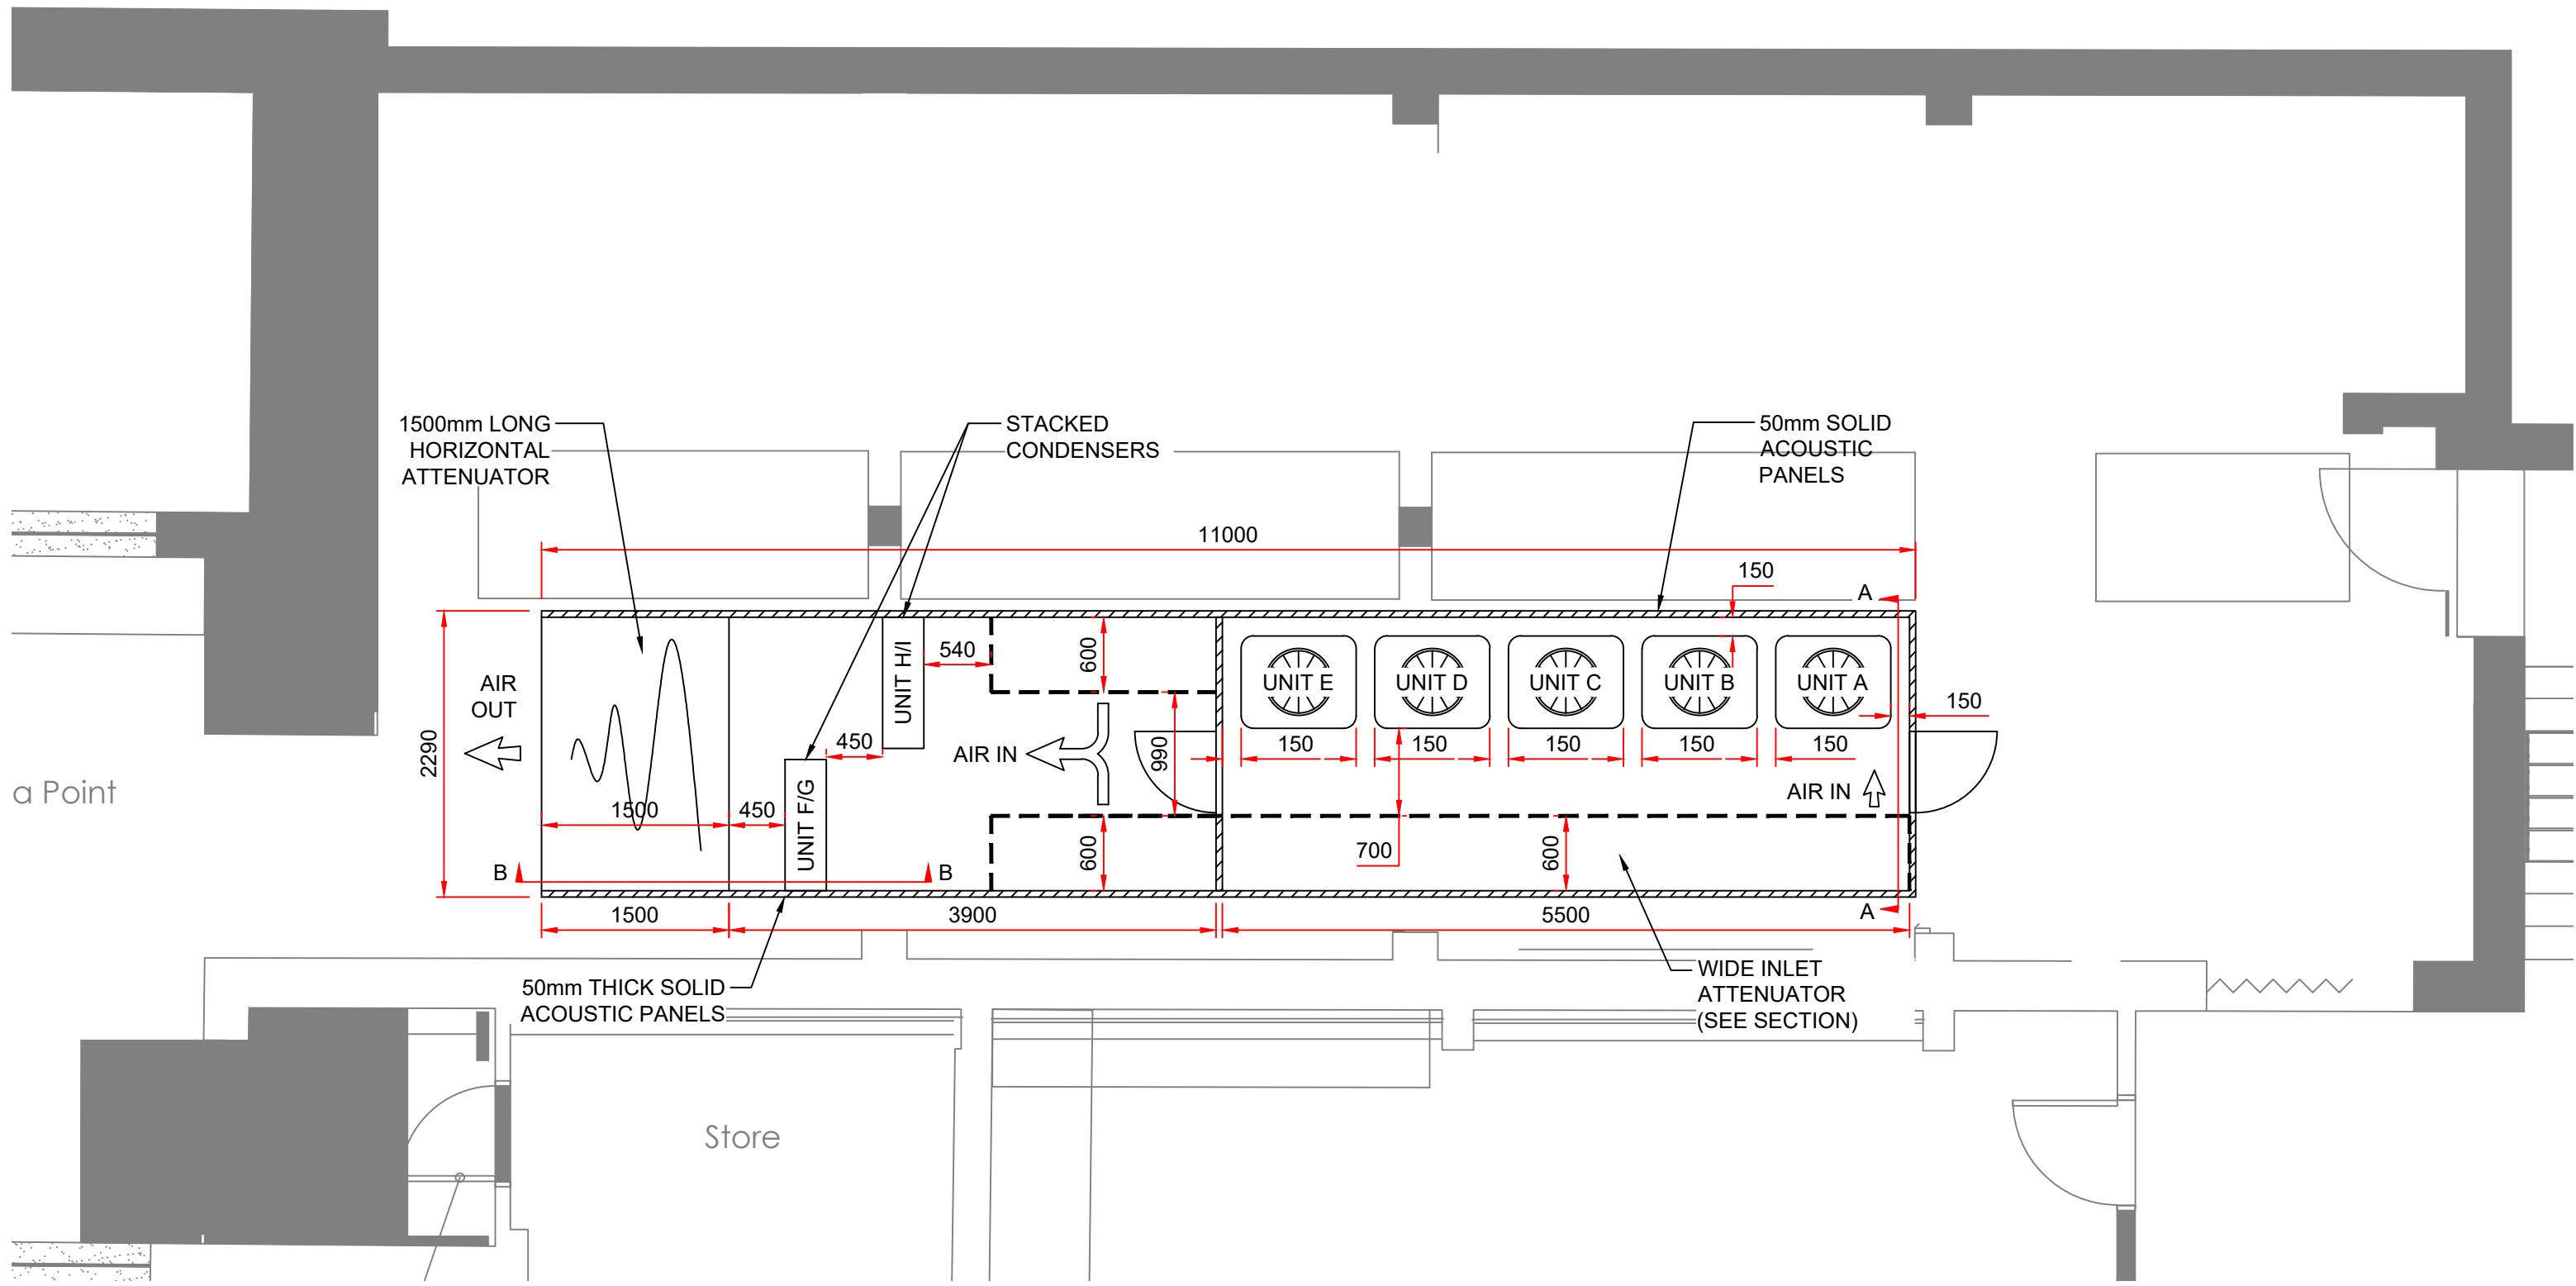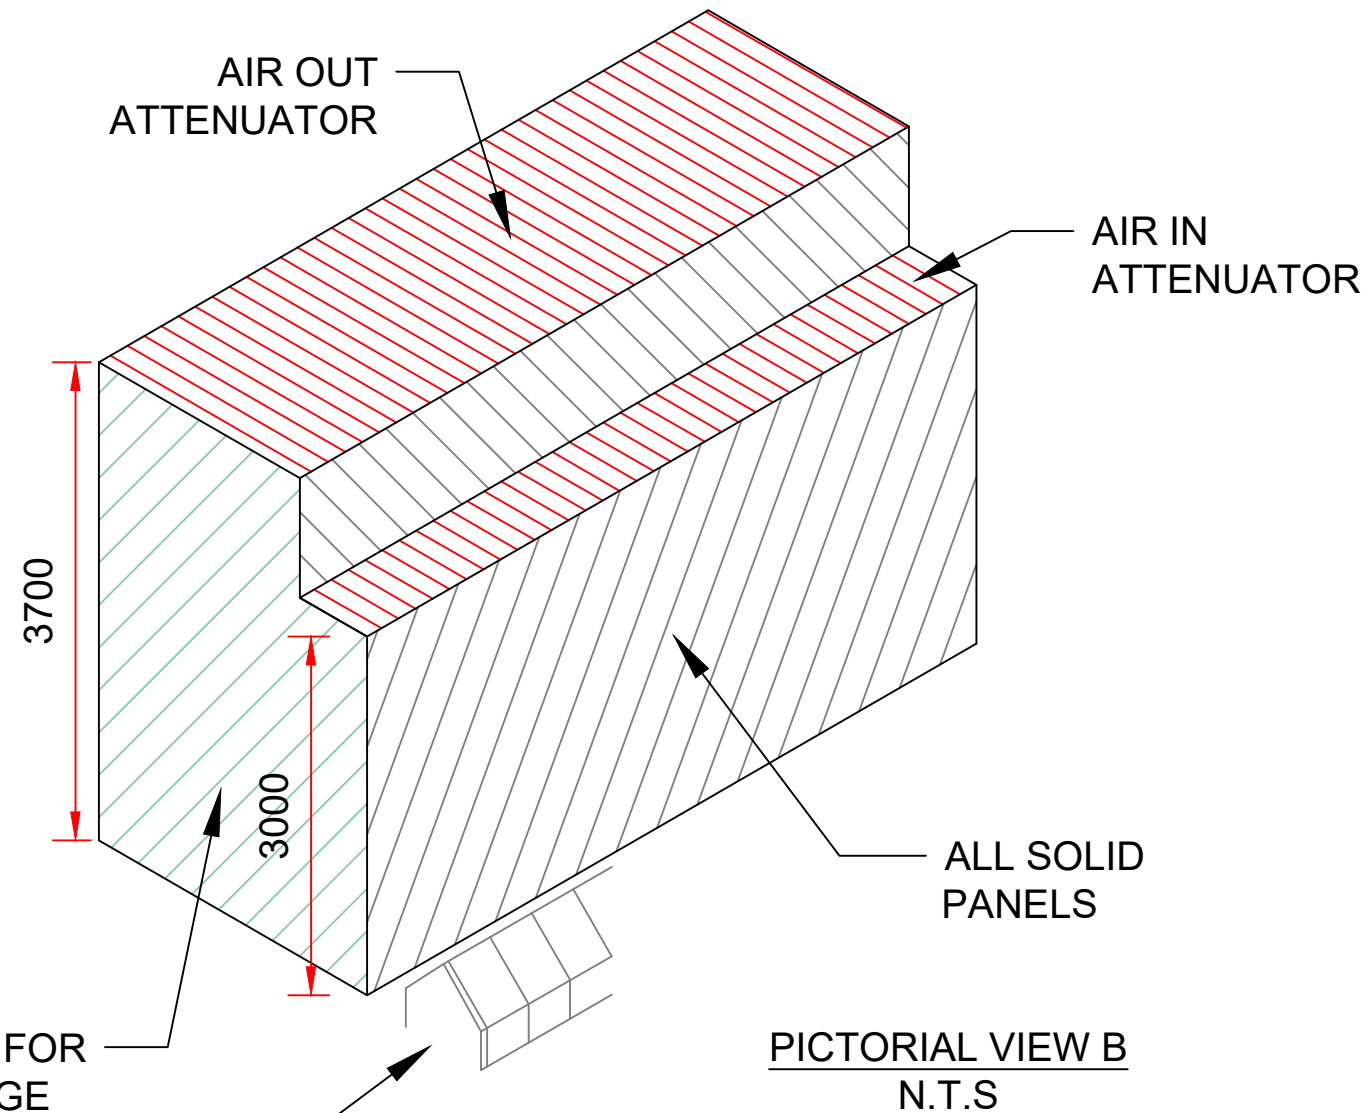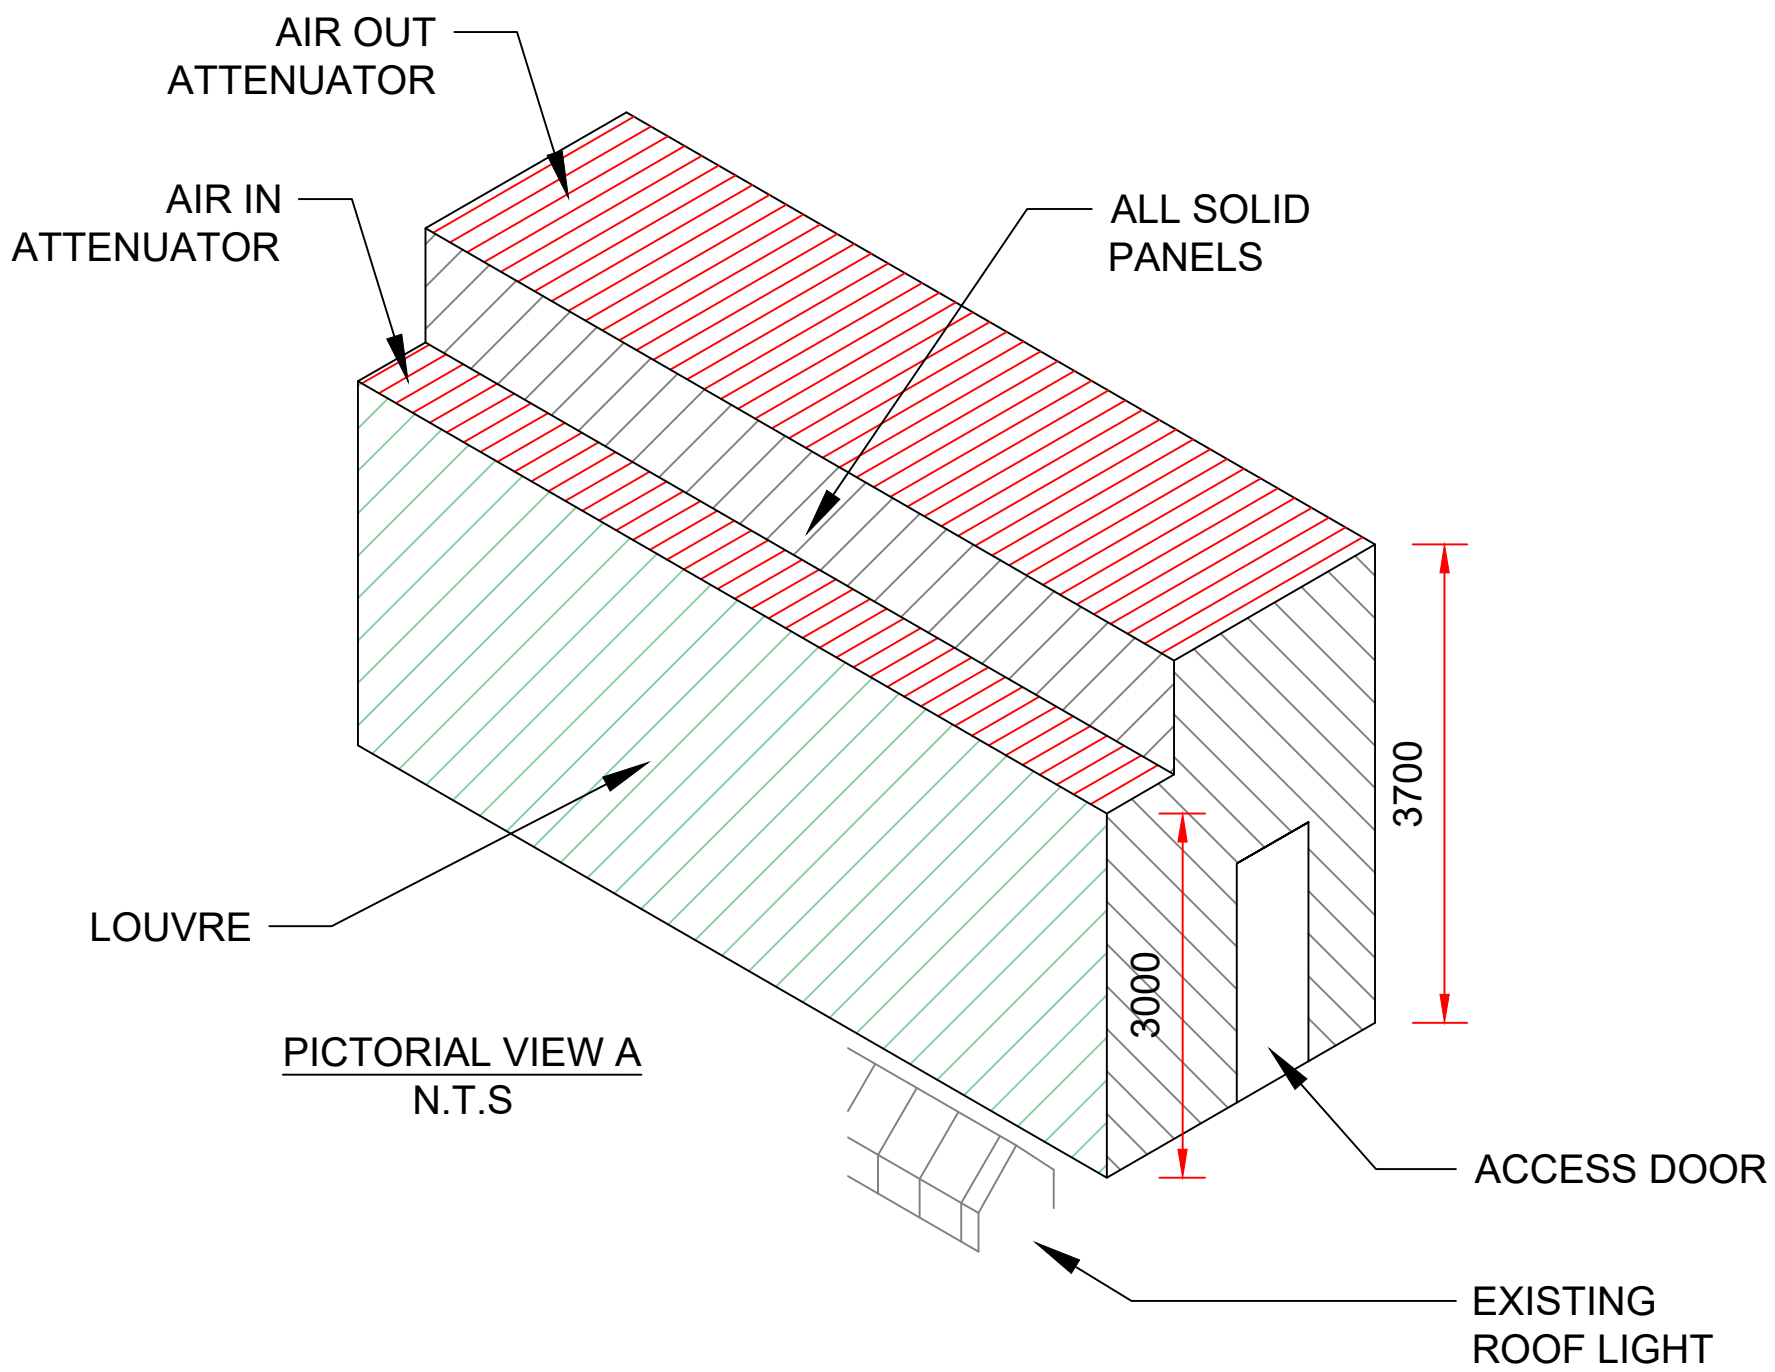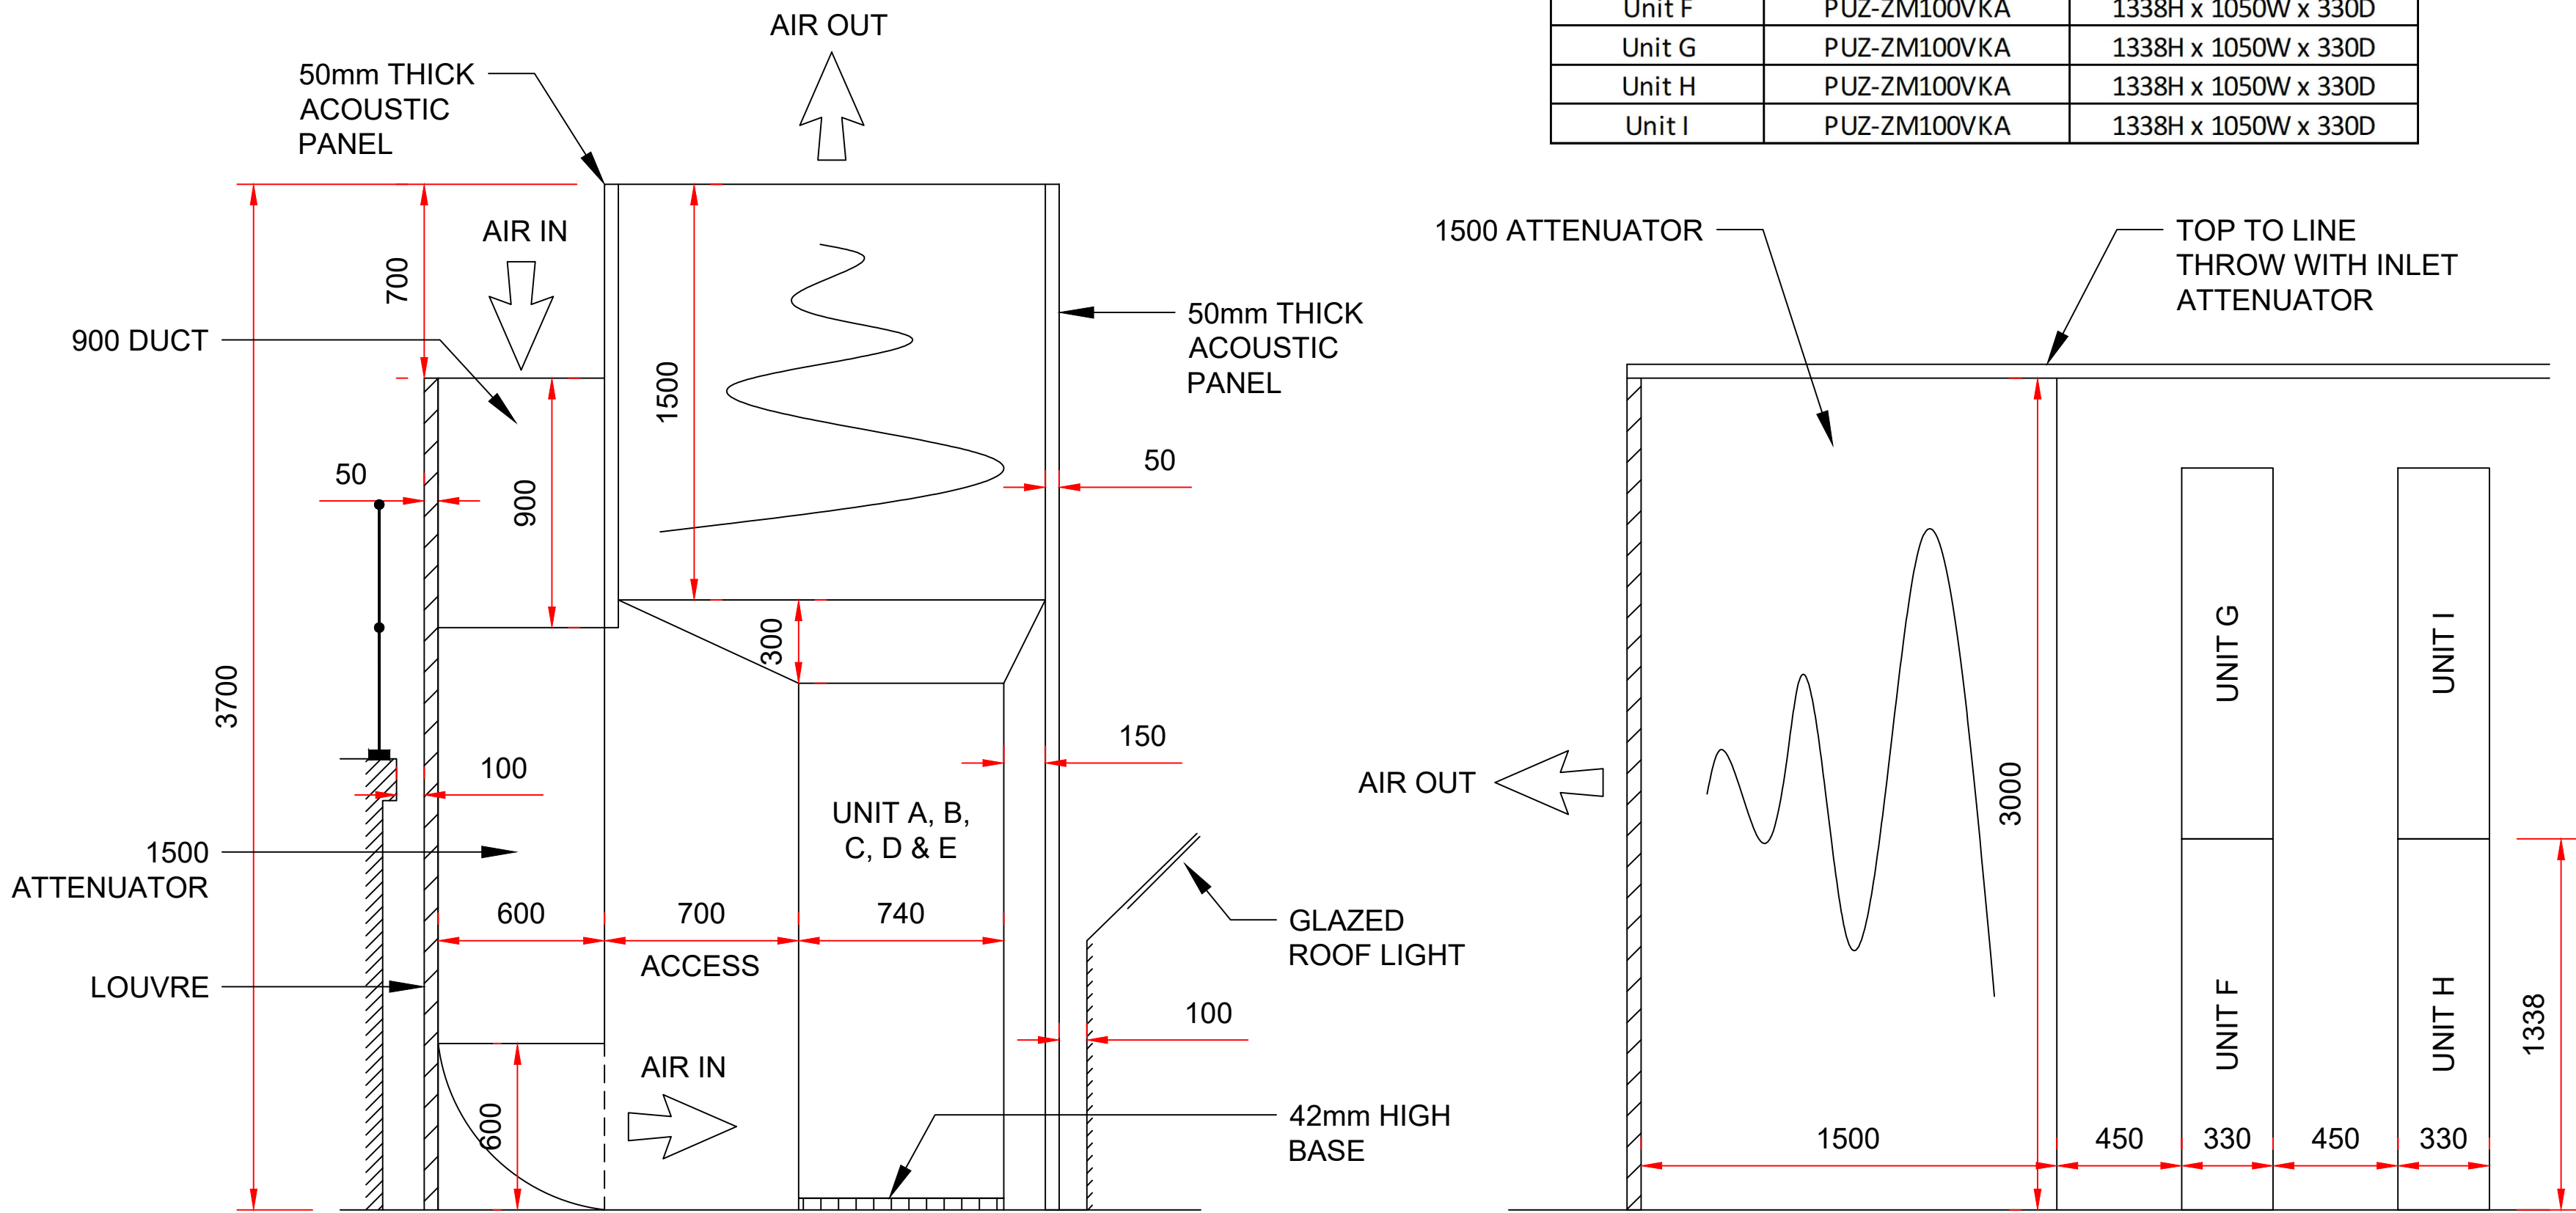

AIR OUT ATTENUATOR FOR HORIZONTAL DISCHARGE CONDENSERS ONLY WITH LOUVRE

EXISTING ROOF LIGHT

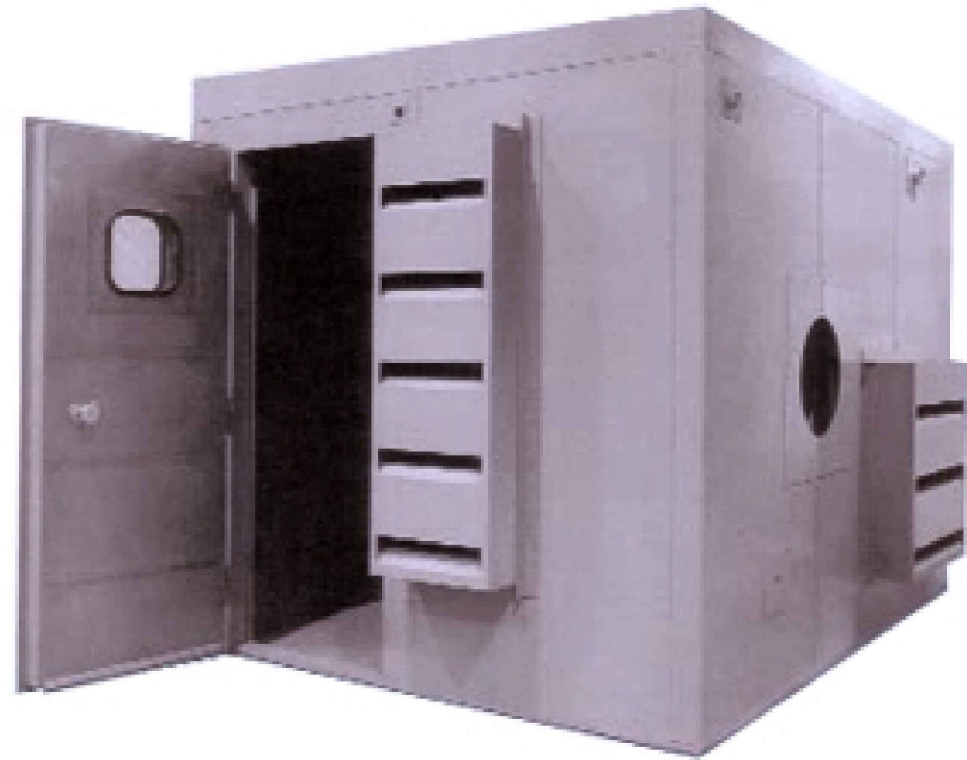

TYPICAL ENCLOSURE FINISH.
COLOUR TO BE DETERMINED.

P2	GENERAL AMMENDMENTS	04.05.20
P1	FIRST ISSUE	28.04.20
Rev.	Description.	Date.



Callisia Limited
Lantern House,
Chertsey
Surrey,
KT16 9AP

T: 01932 848900
E: info@callisia.co.uk
W: www.callisia.co.uk

Job Title.

**UTOPIA VILLAGE
LONDON**

Drawing Title.

**ROOF
MECHANICAL SERVICES**

ROOF PLANT ACOUSTIC ENCLOSURE
PROPOSED LAYOUT

Scale. ©A1	1:50	Date.	FEB 2020
Drawn.	JT	Checked	MT

Drawing Number.	Rev.
1520/M/RF/01	P2