


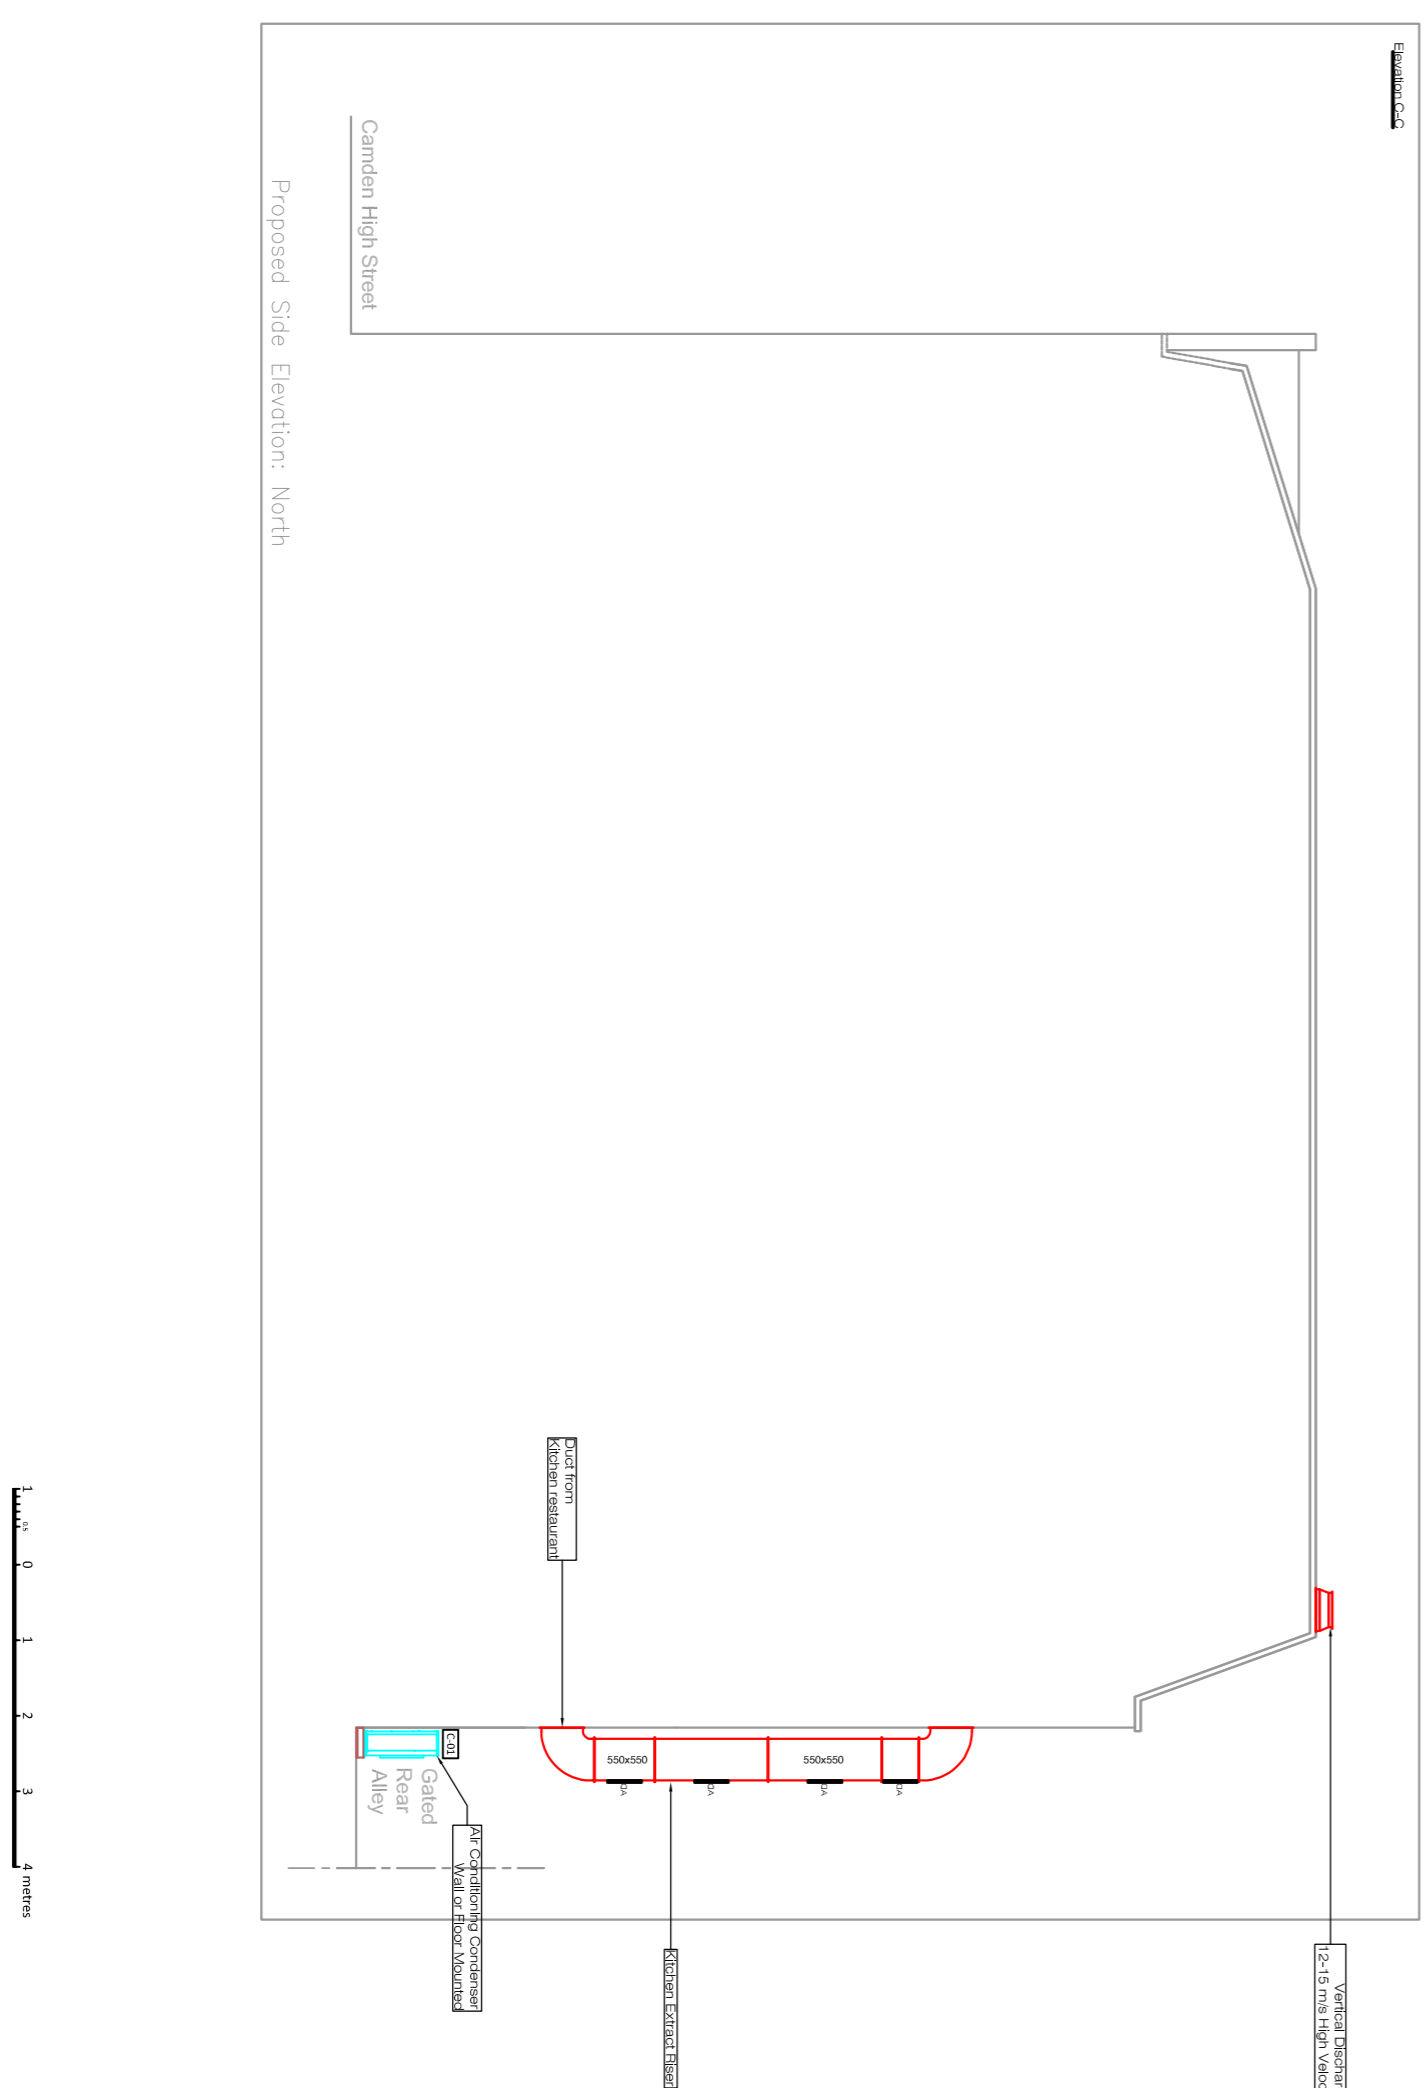


Proposed	External	Duct	Elevations	and duct	route
----------	----------	------	------------	----------	-------

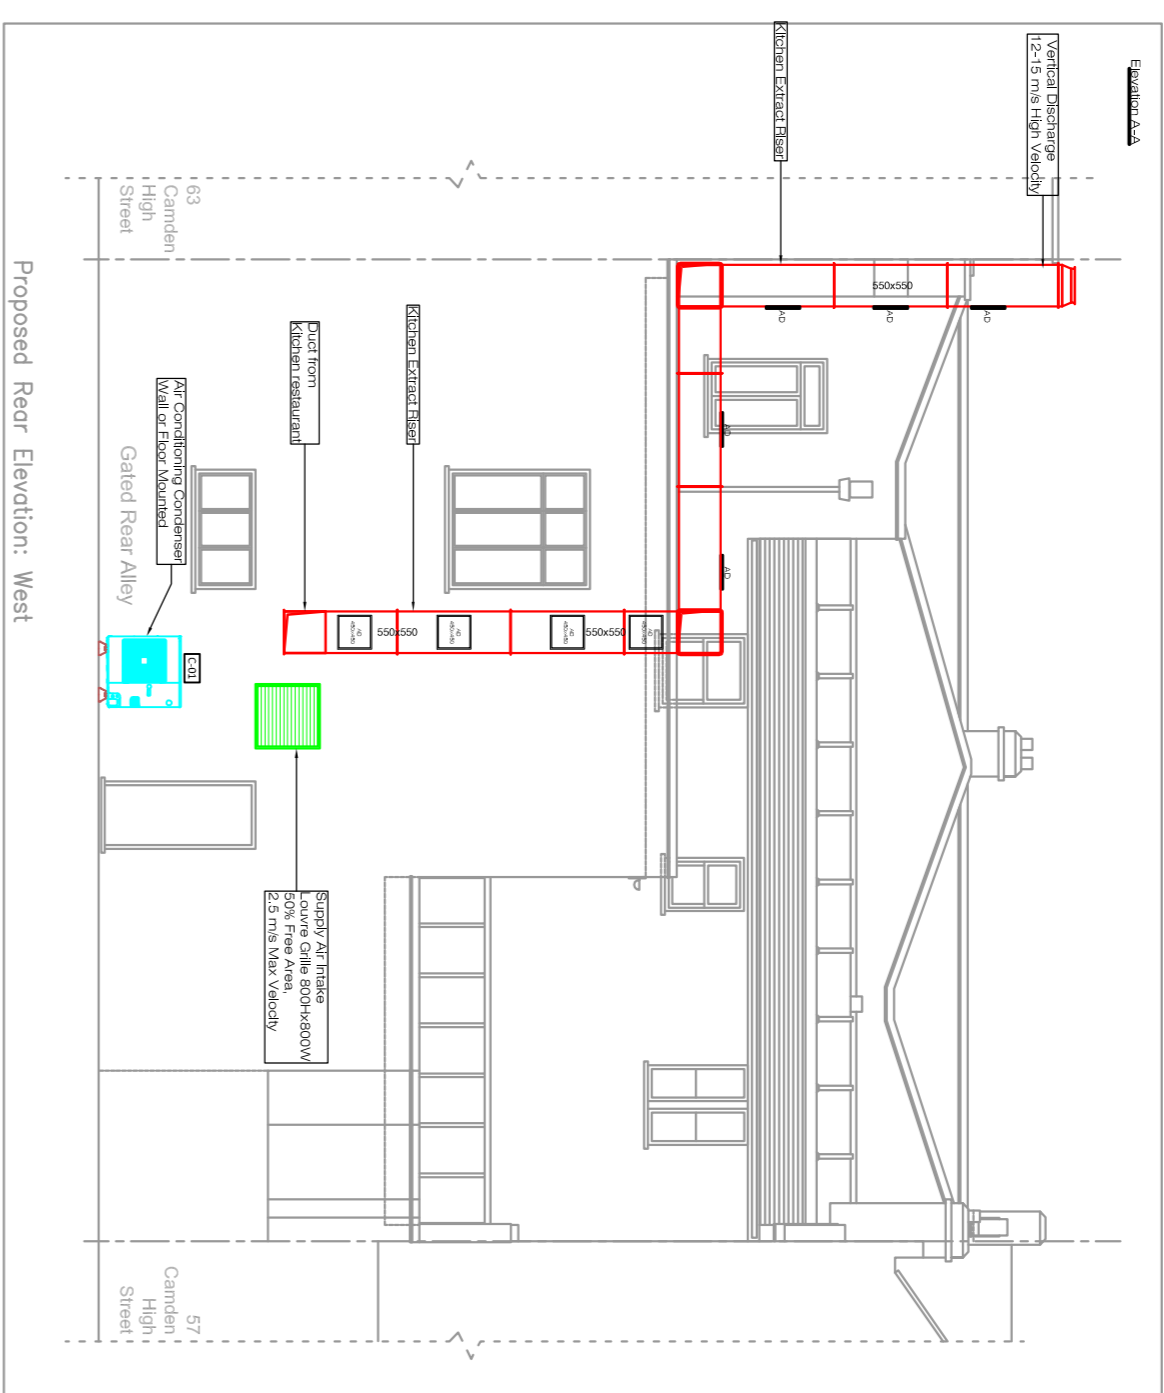

**Existing Site Location Plan**

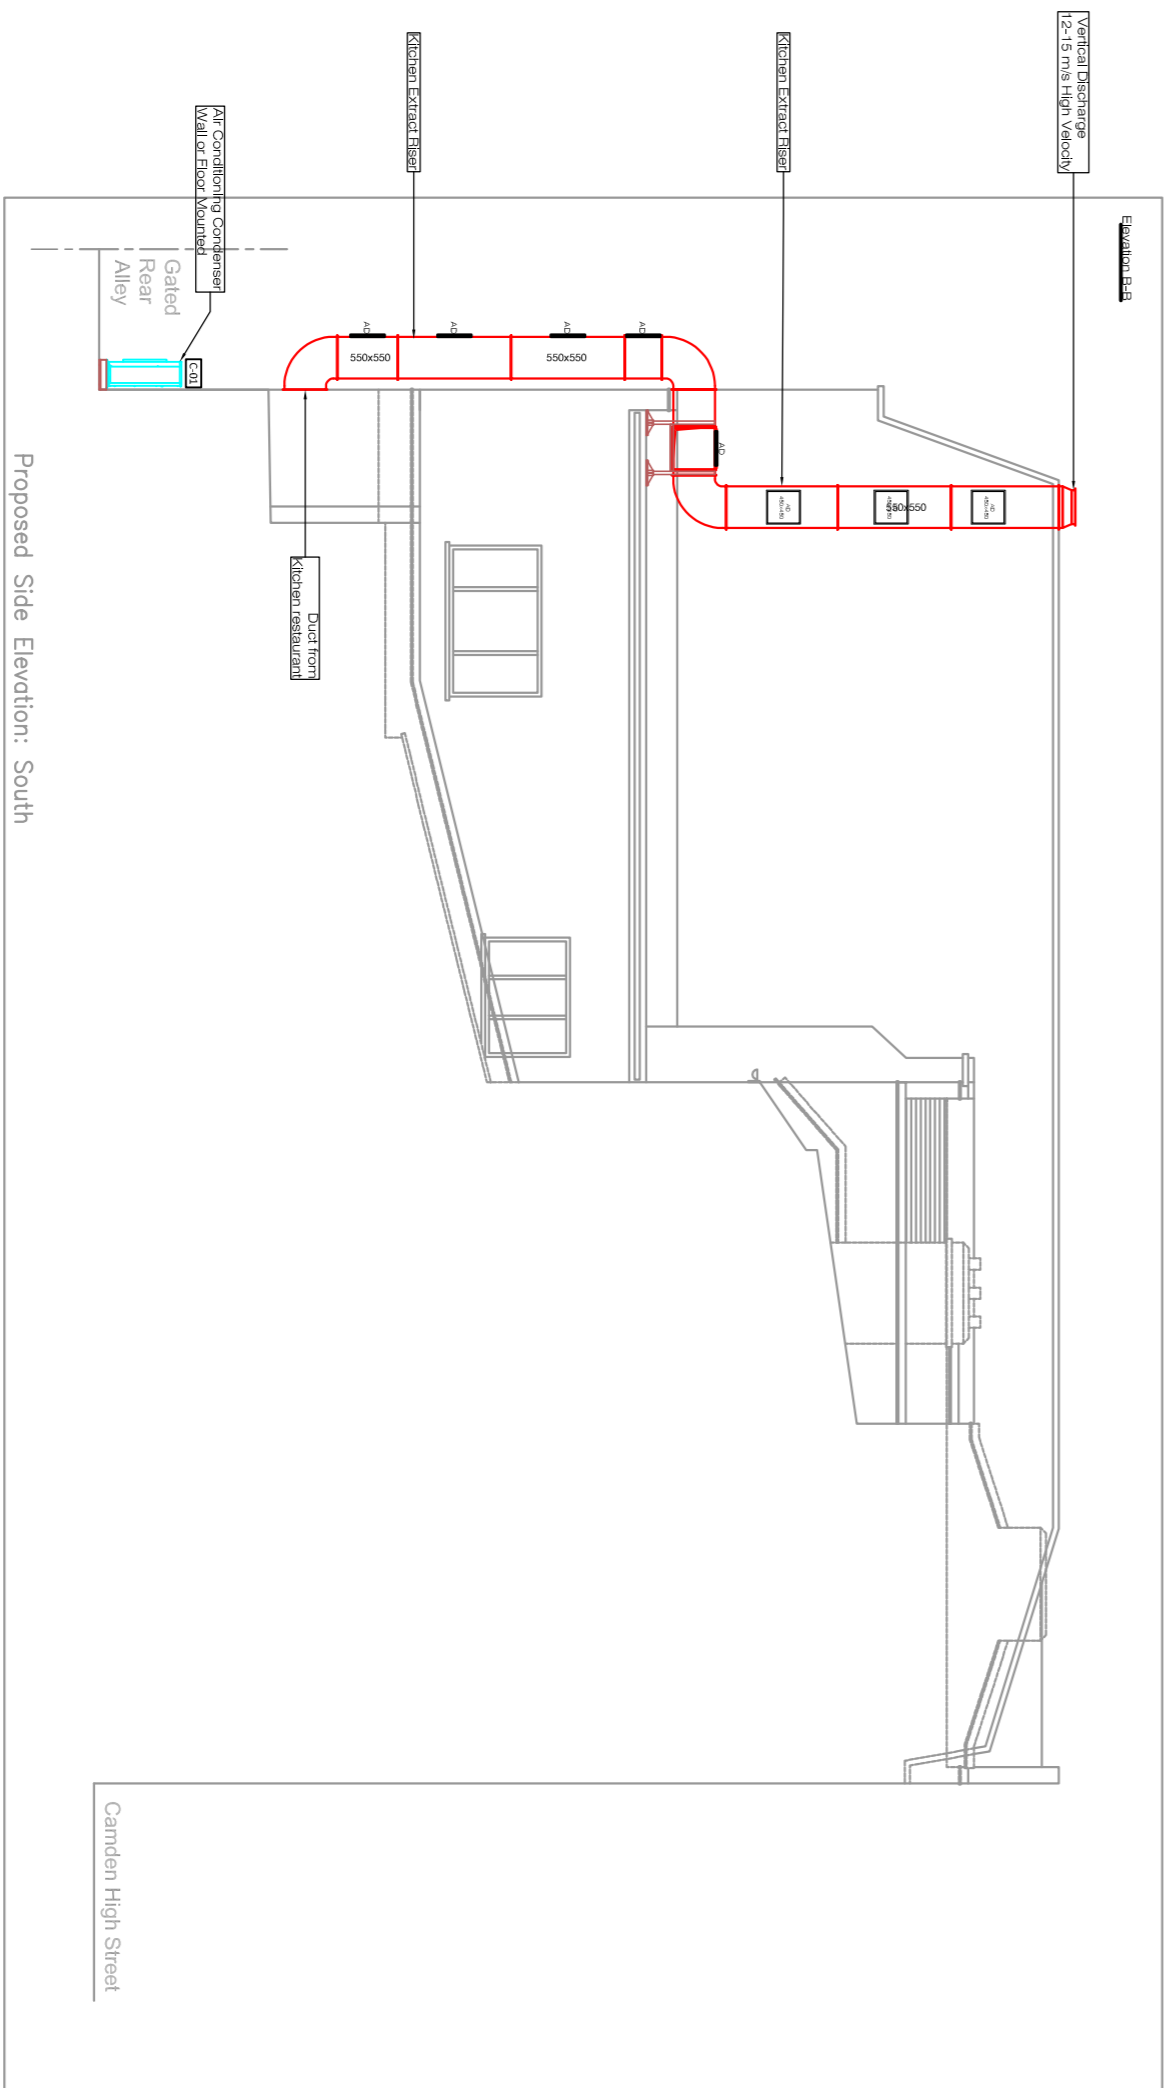

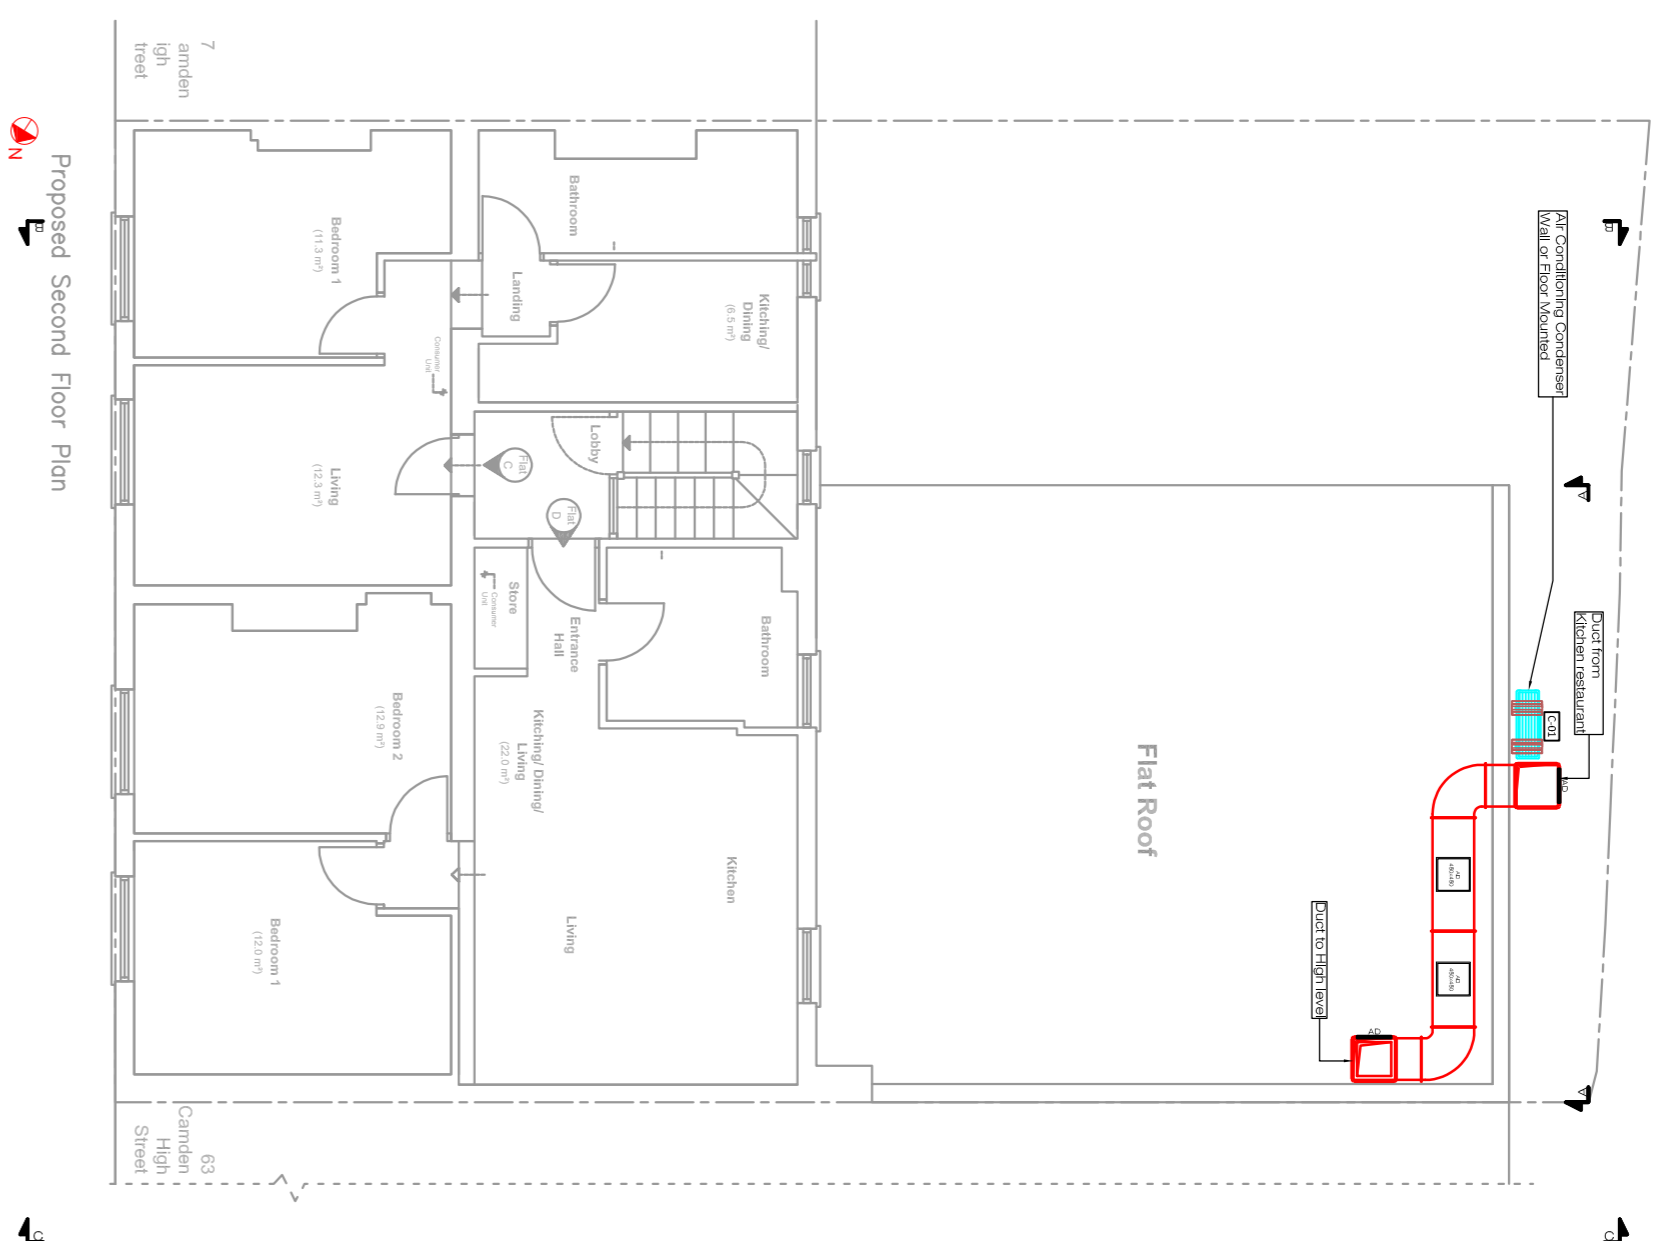

 






**Legend - Demise**

Commercial

Communal Emergency 'right of way' escape

NOTES:

**HVAC LEGEND:**

	Supply Air Duct
	Extract Air Duct
	Supply Air Outlet
	Extract Air Outlet
	A/C Cooling Capacity
	A/C Heating Capacity
	Fire Damper
	Supply Air Valve
	Extract Air Valve
	Access Door
	A/C Conditioning Unit

THIS DRAWING MUST NOT BE SCALED. ALL SETTING OUT MUST BE CHECKED ON SITE. ALL DIMENSIONS MUST BE CHECKED ON SITE. THIS DRAWING MUST BE READ IN CONJUNCTION WITH THE TENDER SPECIFICATION CLAUSES. THIS DRAWING MUST NOT BE USED FOR LAND TRANSFER PURPOSES.

COPYRIGHT OF: LEECH GROUP SERVICES, LEECH MECHANICAL SERVICES & POSITIVE FACILITIES MAINTENANCE

**LEECH**  
**GROUP SERVICES**  
Unit 17, Mapledean Works, Maldon  
Road, Latchingdon, Essex, CM3 6LG  
Tel: +44 (0)1621 742424  
Email: [help@leechgroupservices.co.uk](mailto:help@leechgroupservices.co.uk)  
[www.leechgroupservices.co.uk](http://www.leechgroupservices.co.uk)

H.			
G.			
F.			
E.			
D.			
C.			
B.	MS	Discharge revised	24.06.2020
A.	MS	Revised as per comments	19.06.2020
Rev	Rev by	Description	Date

Rooster Piri Piri  
61 Camden High Street  
London, NW1 7JL

**title:** Proposed Ventilation & Air Conditioning External Layout

PROJECT NUMBER:	Rooster Pin Pirri Camden
DATE:	27/05/2020
DRAWN BY:	MS
CHECKED BY:	ML
DRAWING NO:	RPP/002 Rev B
SCALE	1:100@ A1